



§ NORTH FAIRVIEW AVENUE

§ NORTH MITCHELL STREET

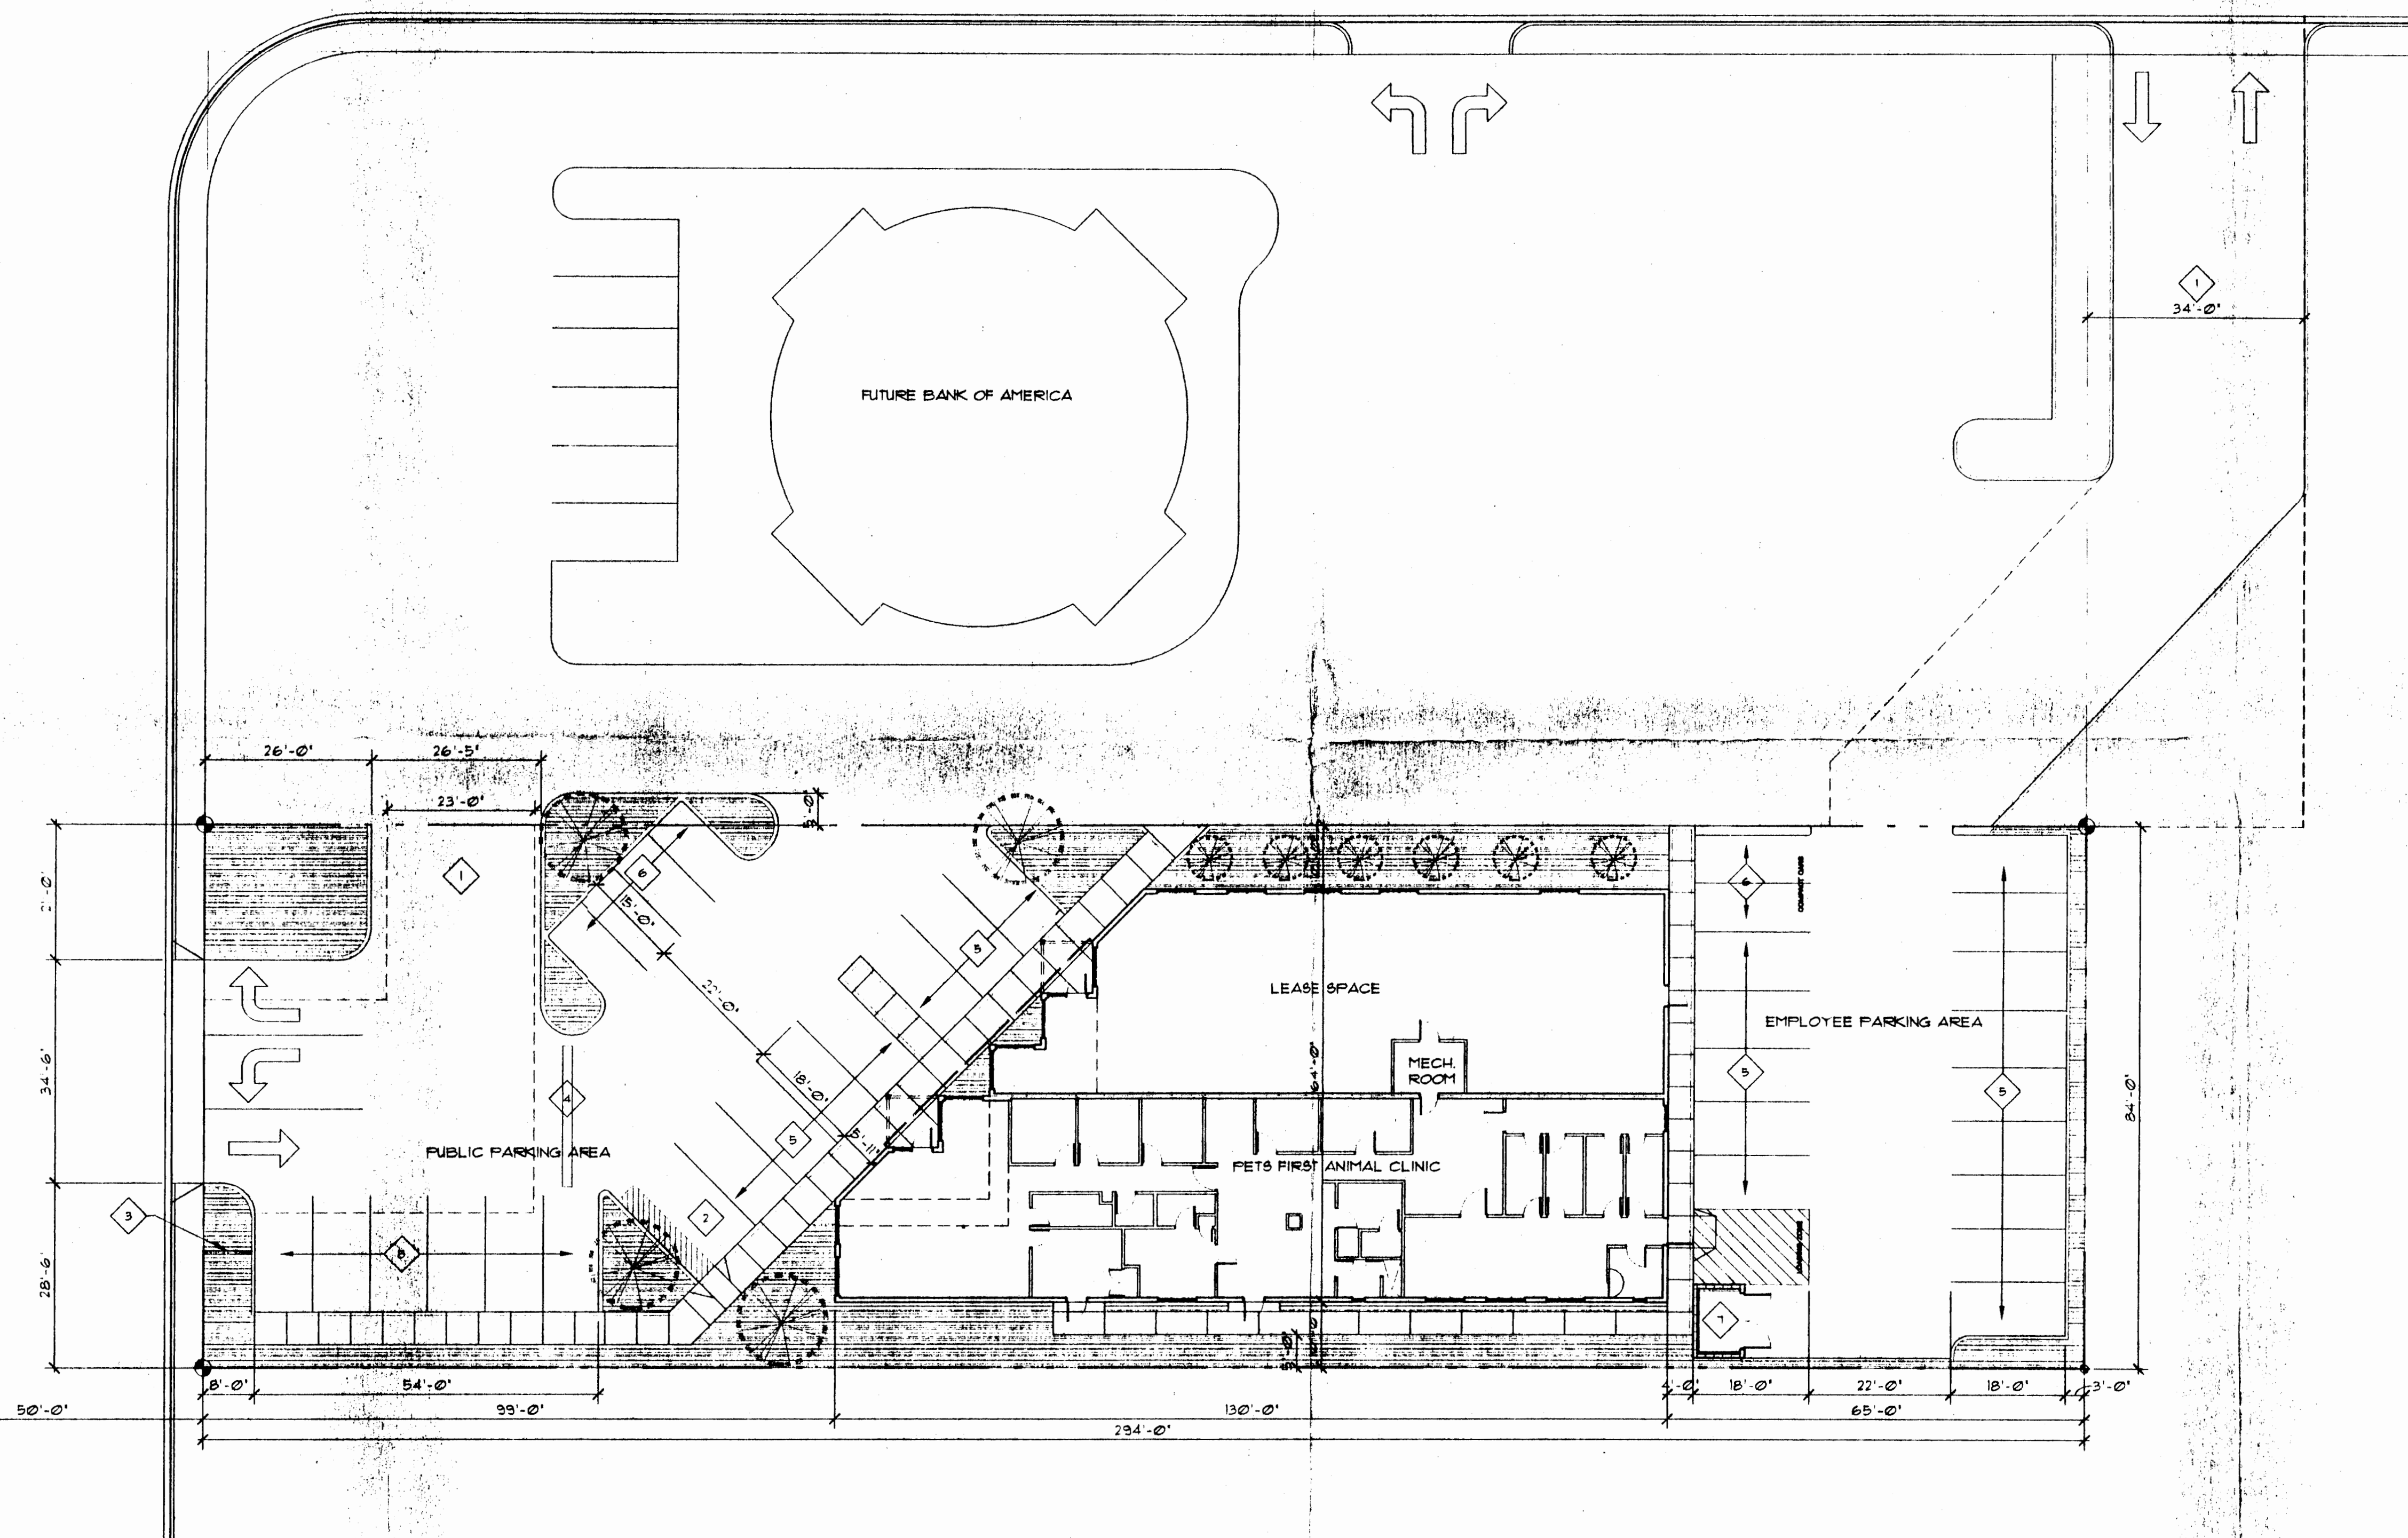

- 1 ACCESS EASEMENT
- 2 INTERNATIONAL HANDICAP SYMBOL
- 3 ACCESS AISLE STRIPING PAINTED ON ASPHALT
- 4 'PETS FIRST' & TENANT MONUMENT SIGN
- 5 SPEED BUMP
- 6 REGULAR PARKING STALL - 9'-0" WIDTH
- 7 COMPACT PARKING STALL - 7'-0" WIDTH
- 8 TRASH ENCLOSURE

A SITE PLAN
SCALE: 1"=16'-0"

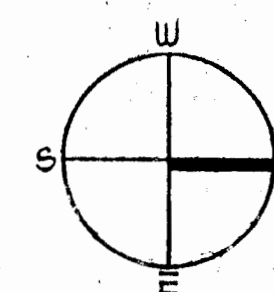

HOSFORD & LARSON
ARCHITECTS AIA
Boise, Idaho 83702
212 North Ninth
Phone: [208] 338-1413 Fax: [208] 336-0371

REVISIONS


PROJECT NUMBER
9308
DATE
DEC-1993
SCALE
1/16"=1'-0"
SHEET TITLE
DEMO/SITE
FILE NAME
9308100

1.00


AJD

3:42:17pm

12/14/93

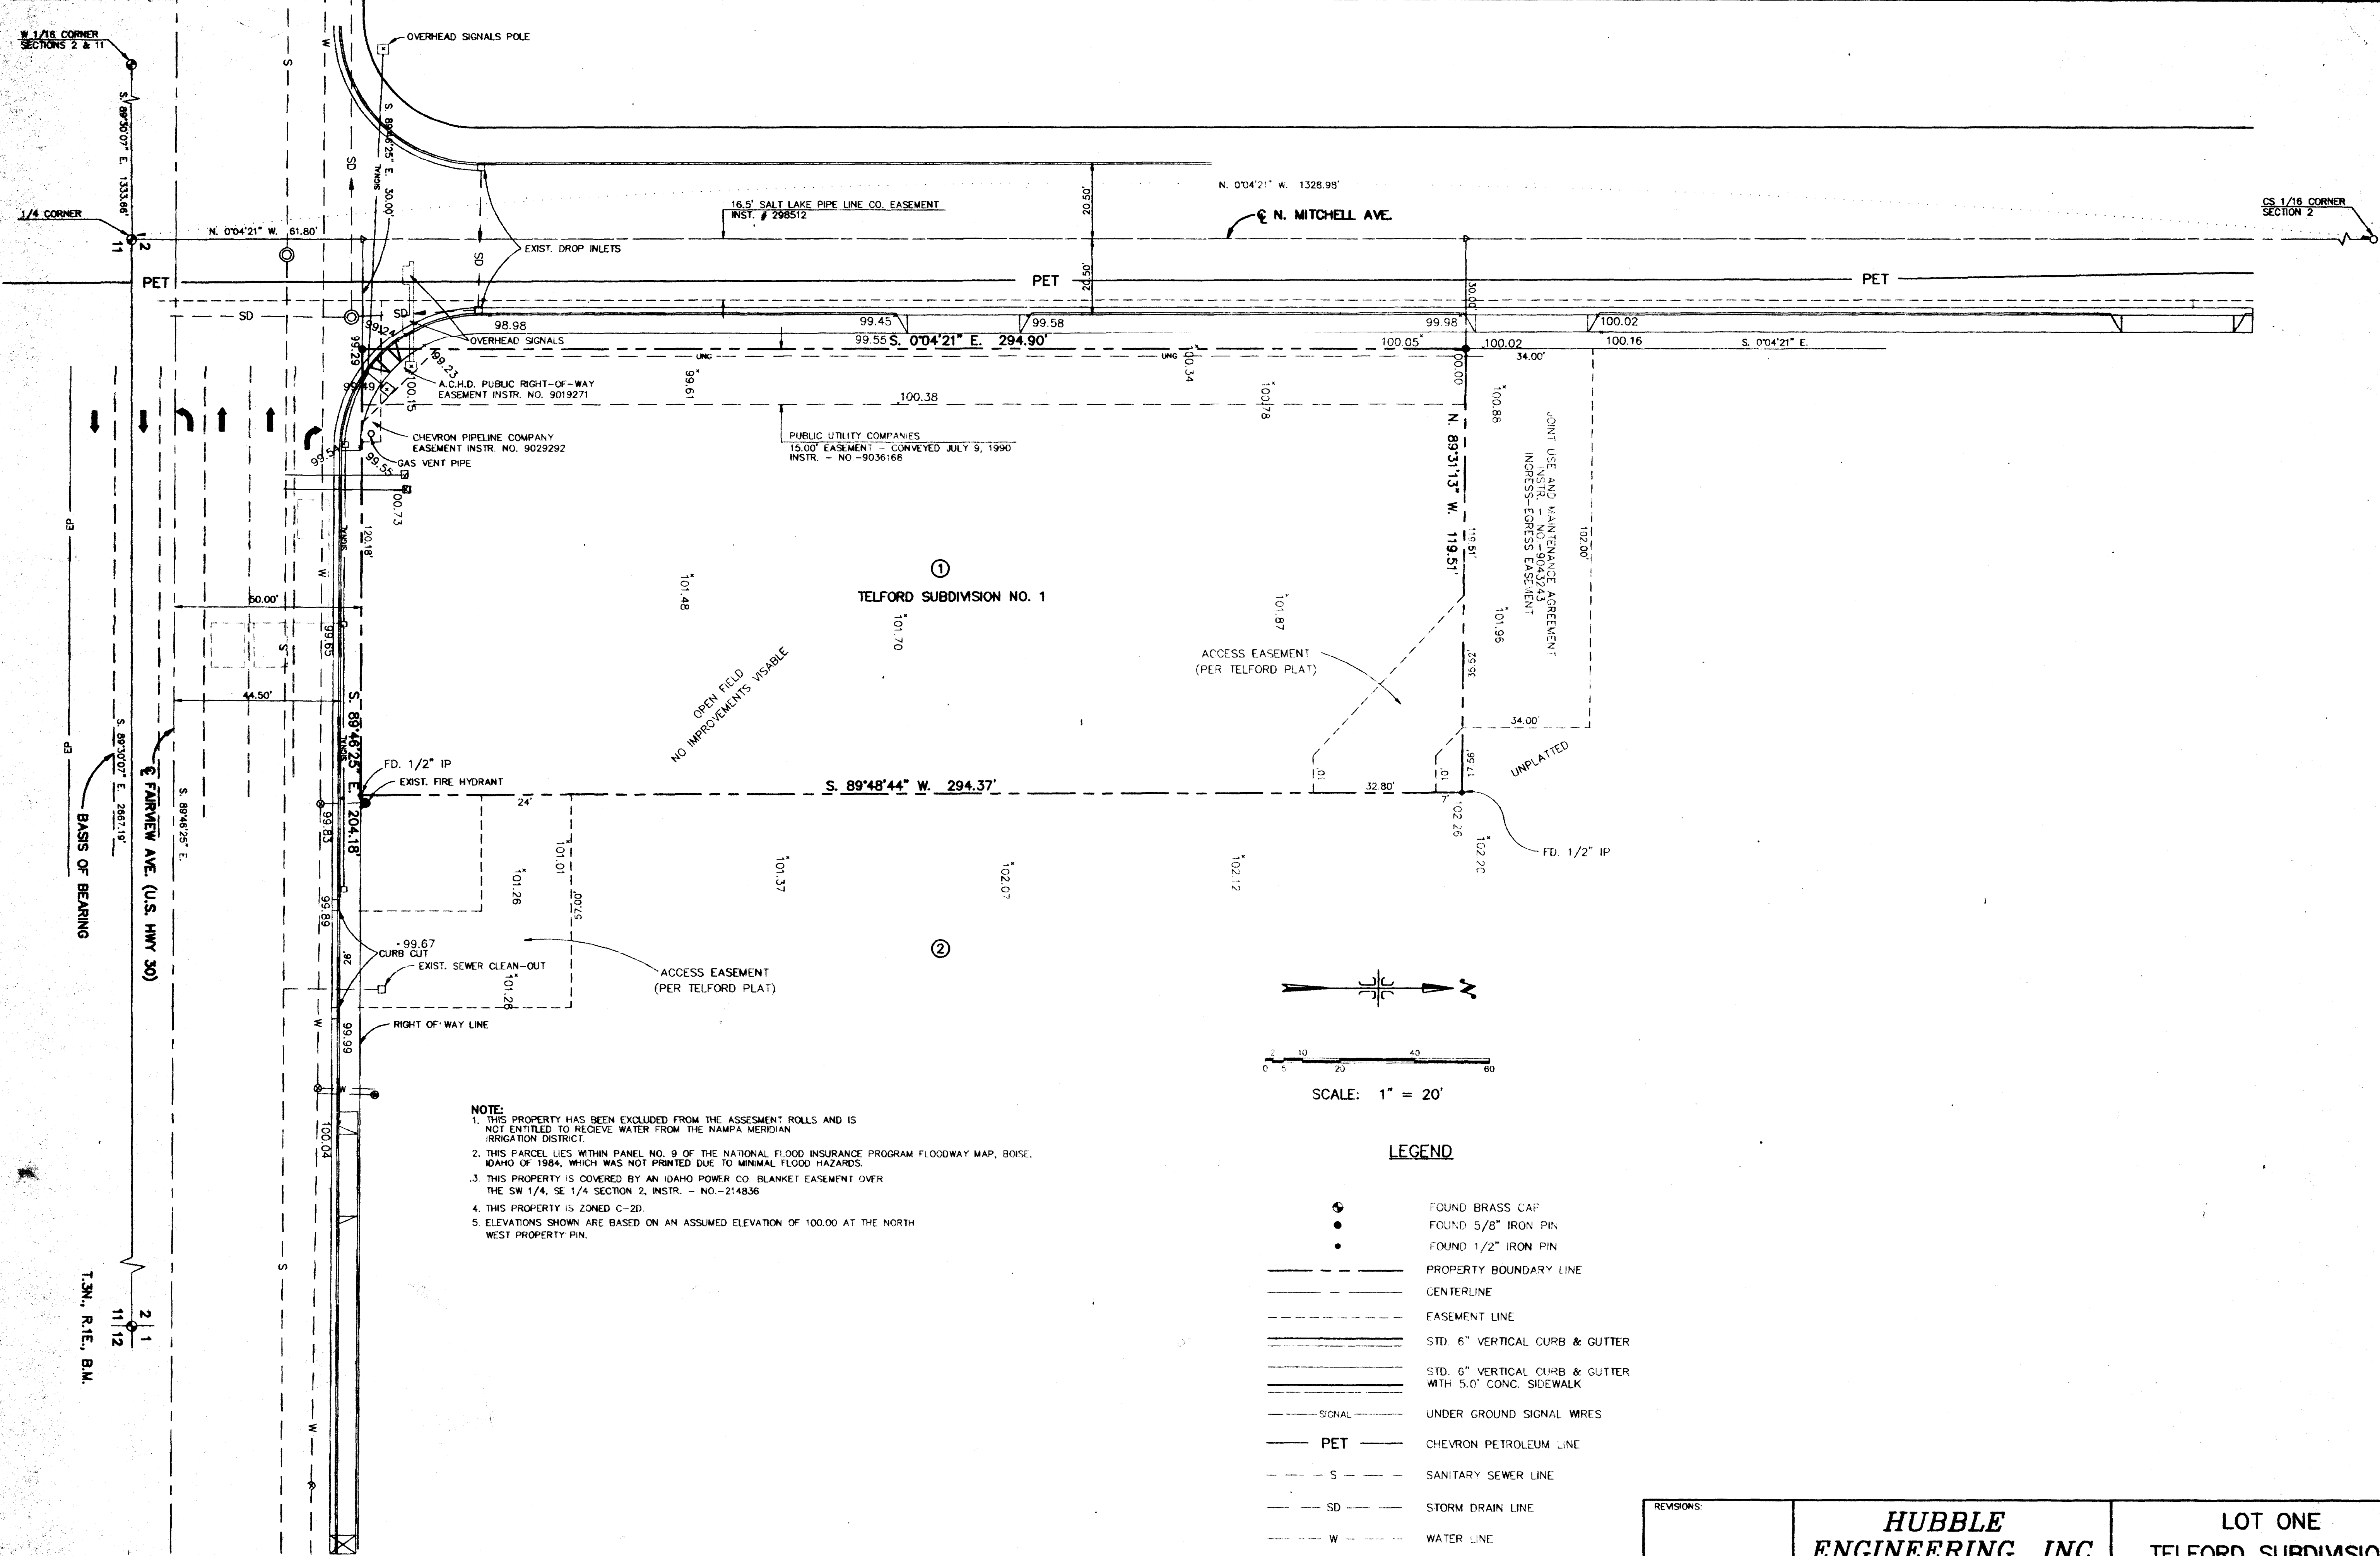

NOTE:
 1. THIS PROPERTY HAS BEEN EXCLUDED FROM THE ASSESMENT ROLLS AND IS NOT ENTITLED TO RECEIVE WATER FROM THE NAMPA MERIDIAN IRRIGATION DISTRICT.
 2. THIS PARCEL LIES WITHIN PANEL NO. 9 OF THE NATIONAL FLOOD INSURANCE PROGRAM FLOODWAY MAP, BOISE, IDAHO OF 1984, WHICH WAS NOT PRINTED DUE TO MINIMAL FLOOD HAZARDS.
 3. THIS PROPERTY IS COVERED BY AN IDAHO POWER CO. BLANKET EASEMENT OVER THE SW 1/4, SE 1/4 SECTION 2, INSTR. - NO.-214836.
 4. THIS PROPERTY IS ZONED C-2D.
 5. ELEVATIONS SHOWN ARE BASED ON AN ASSUMED ELEVATION OF 100.00 AT THE NORTH WEST PROPERTY PIN.

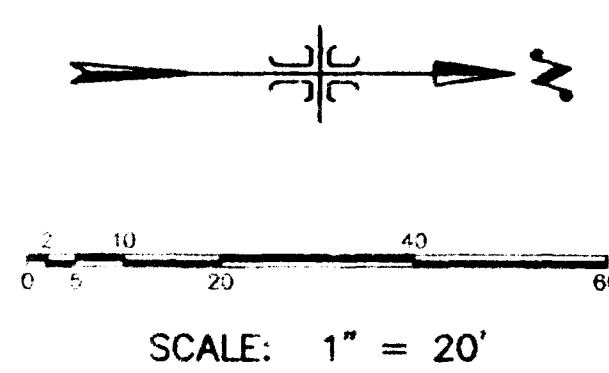

LEGEND

- FOUND BRASS CAP
- FOUND 5/8" IRON PIN
- FOUND 1/2" IRON PIN
- PROPERTY BOUNDARY LINE
- CENTERLINE
- EASEMENT LINE
- STD. 6" VERTICAL CURB & GUTTER
- STD. 6" VERTICAL CURB & GUTTER WITH 5.0' CONC. SIDEWALK
- SIGNAL — UNDER GROUND SIGNAL WIRES
- PET — CHEVRON PETROLEUM LINE
- S — SANITARY SEWER LINE
- SD — STORM DRAIN LINE
- W — WATER LINE
- WATER METER
- WATER VALVE
- UNG — NATURAL GAS LINE
- 100.78 ELEVATION

THESE DRAWINGS, OR ANY PORTION THEREOF, SHALL NOT BE USED ON ANY PROJECT OR EXTENSIONS OF THIS PROJECT EXCEPT BY AGREEMENT IN WRITING WITH HUBBLE ENGINEERING, INC.
 File name: Z:\MATZEK\ZEKALTA.DWG Last edited: 05/25/93


REVISIONS:	HUBBLE ENGINEERING, INC. ENGINEERING-SURVEYING-PLANNING		LOT ONE TELFORD SUBDIVISION	
	9550 BETHEL COURT BOISE, IDAHO 83709 (208) 322-8992		TOPOGRAPHIC SURVEY	
	DESIGNED BY: T.R.W.	DATE: 8-12-93	SHEET NO. A-1.0	
	DRAWN BY:	PROJECT NO.: XX-200-XX		
	CHECKED BY:	CAD DWG. F./SURVEY/MATFAIR		



Lowhard-Conrad
ARCHITECTS
P. A. A. I. A.
1221 SHORELINE LANE BOISE, IDAHO 83702 TEL (208) 345-6677


BANK OF AMERICA
FAIRVIEW AND MITCHELL
BOISE IDAHO
SITE DEVELOPMENT PLAN


JOB NO. 93031.01	
DATE 08-15-93	
DRAWN BY JWM	CHECKED BY BOS
REVISIONS	DATE
SHEET NO. A1-1	

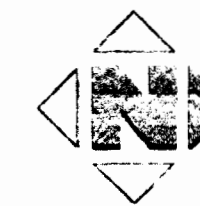

SITE DEVELOPMENT PLAN


SCALE: 1"=20'-0"

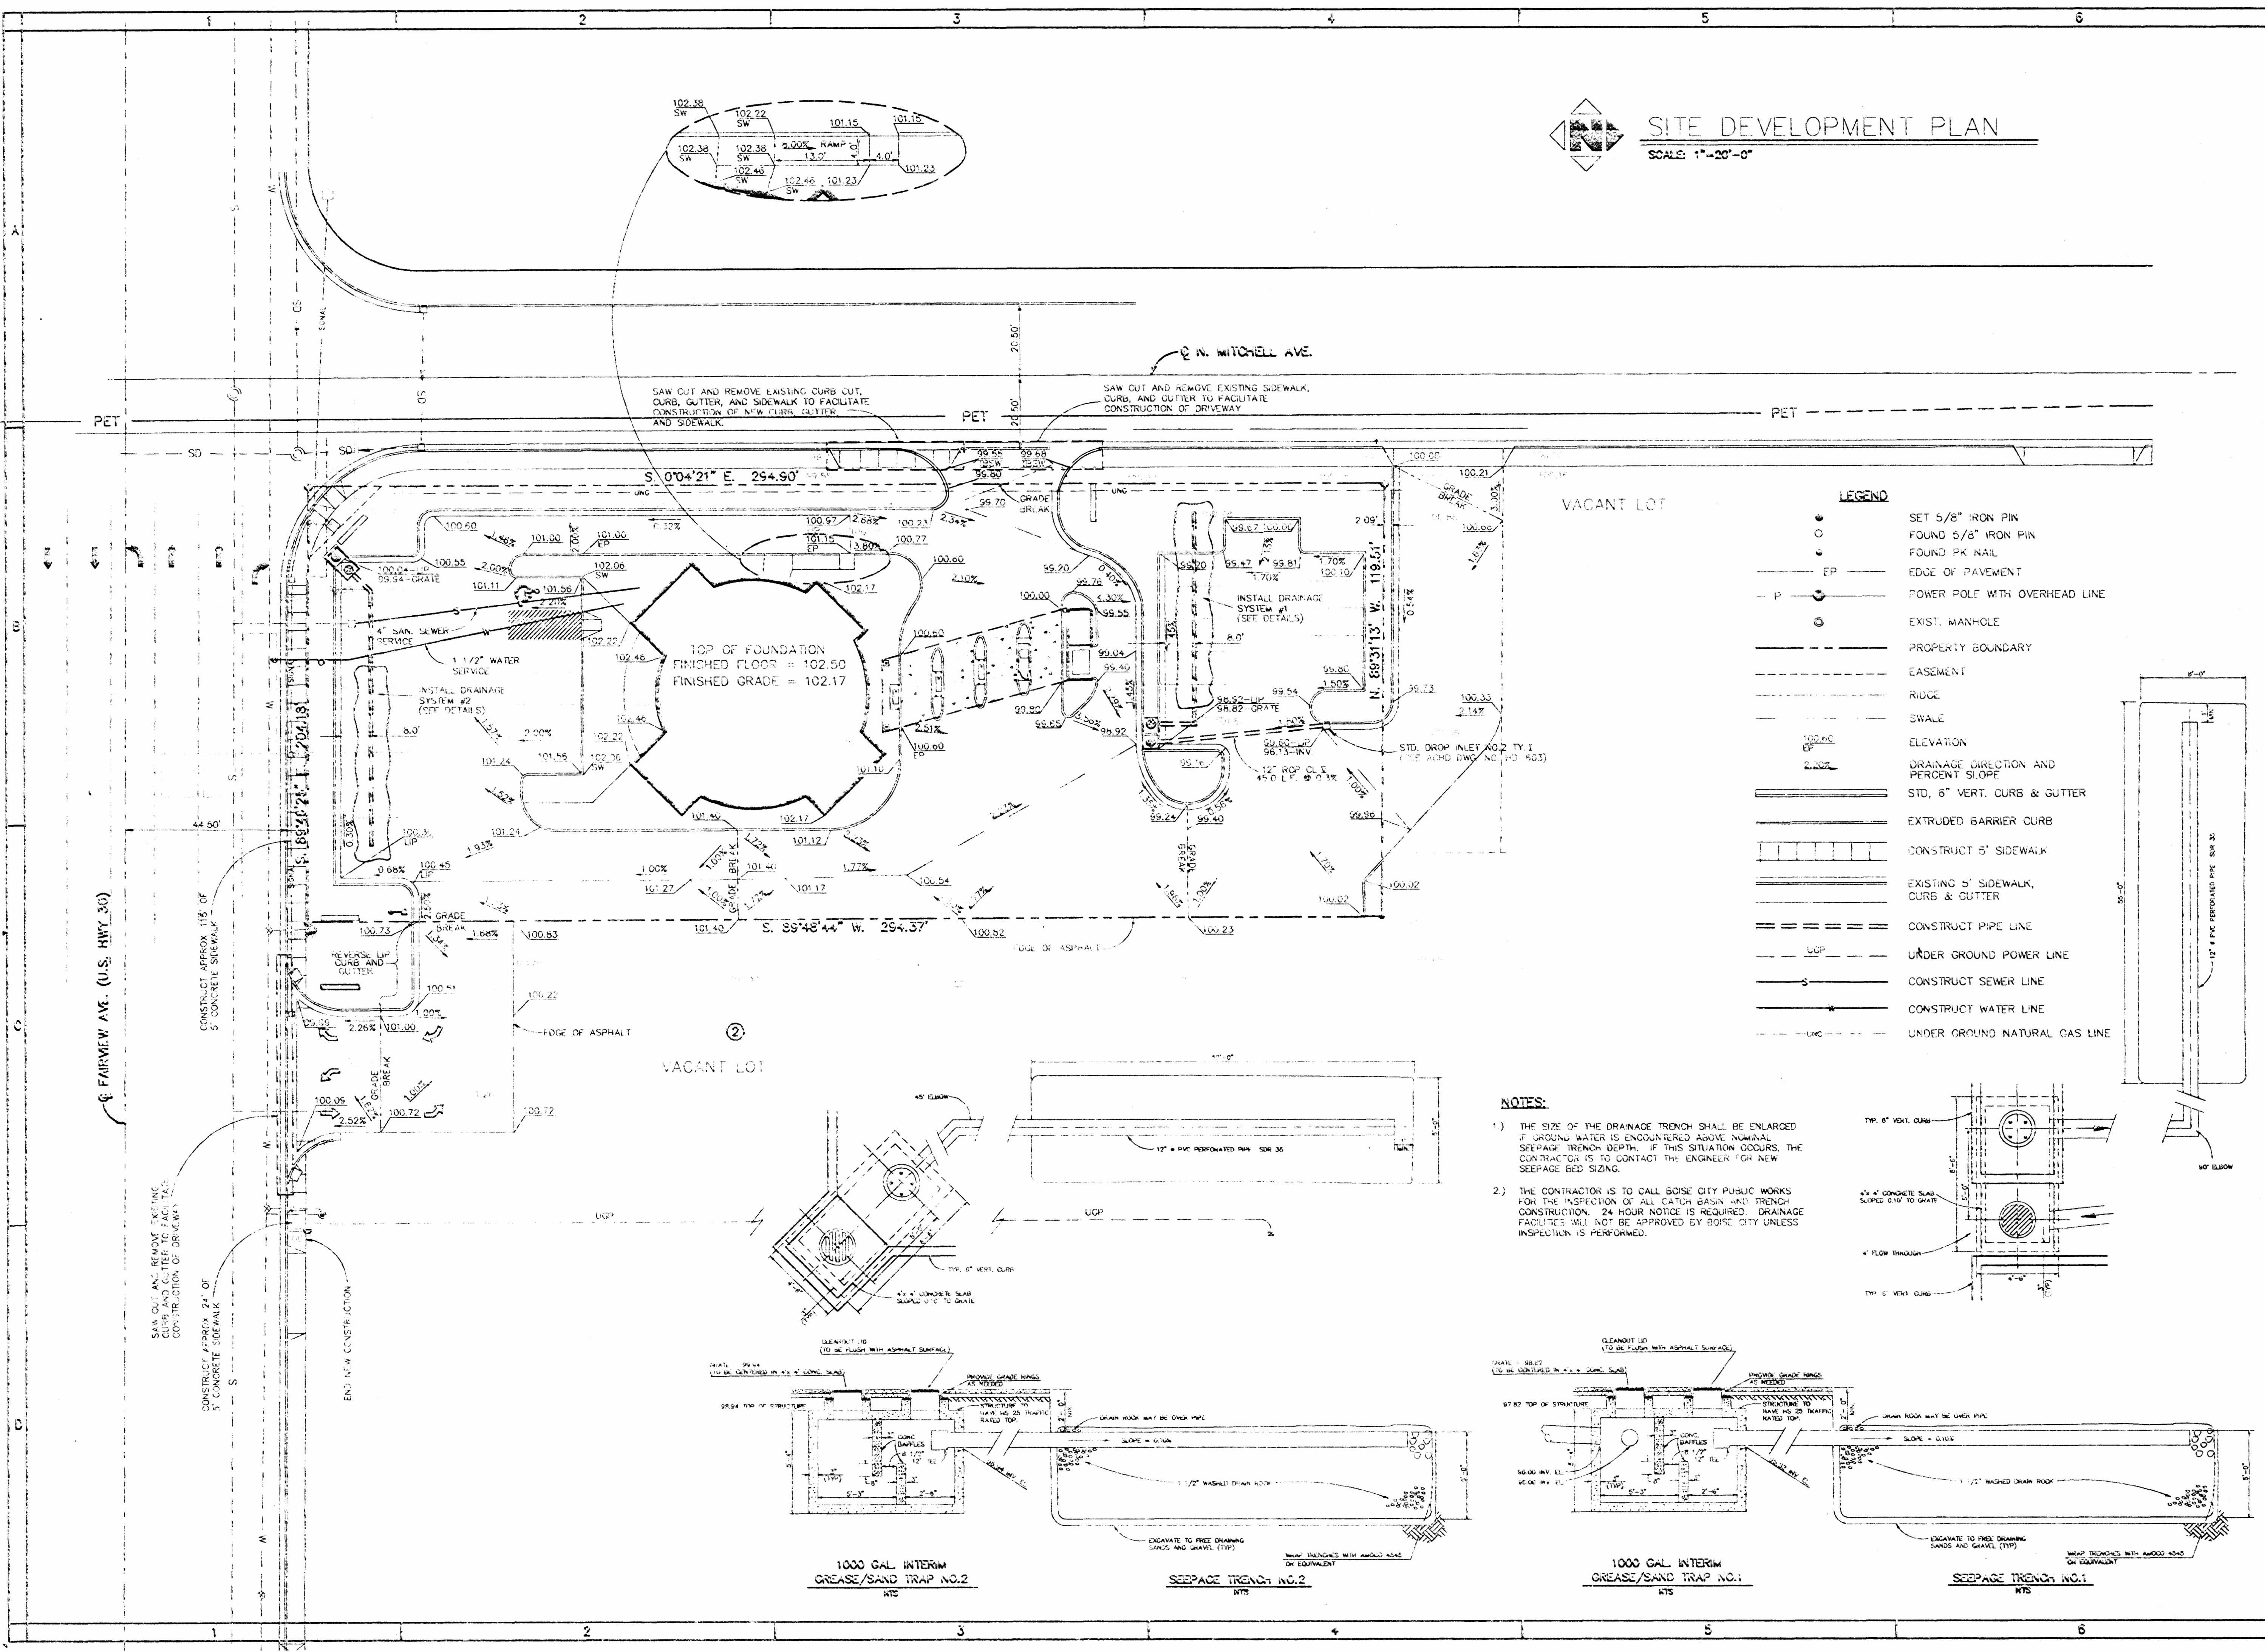

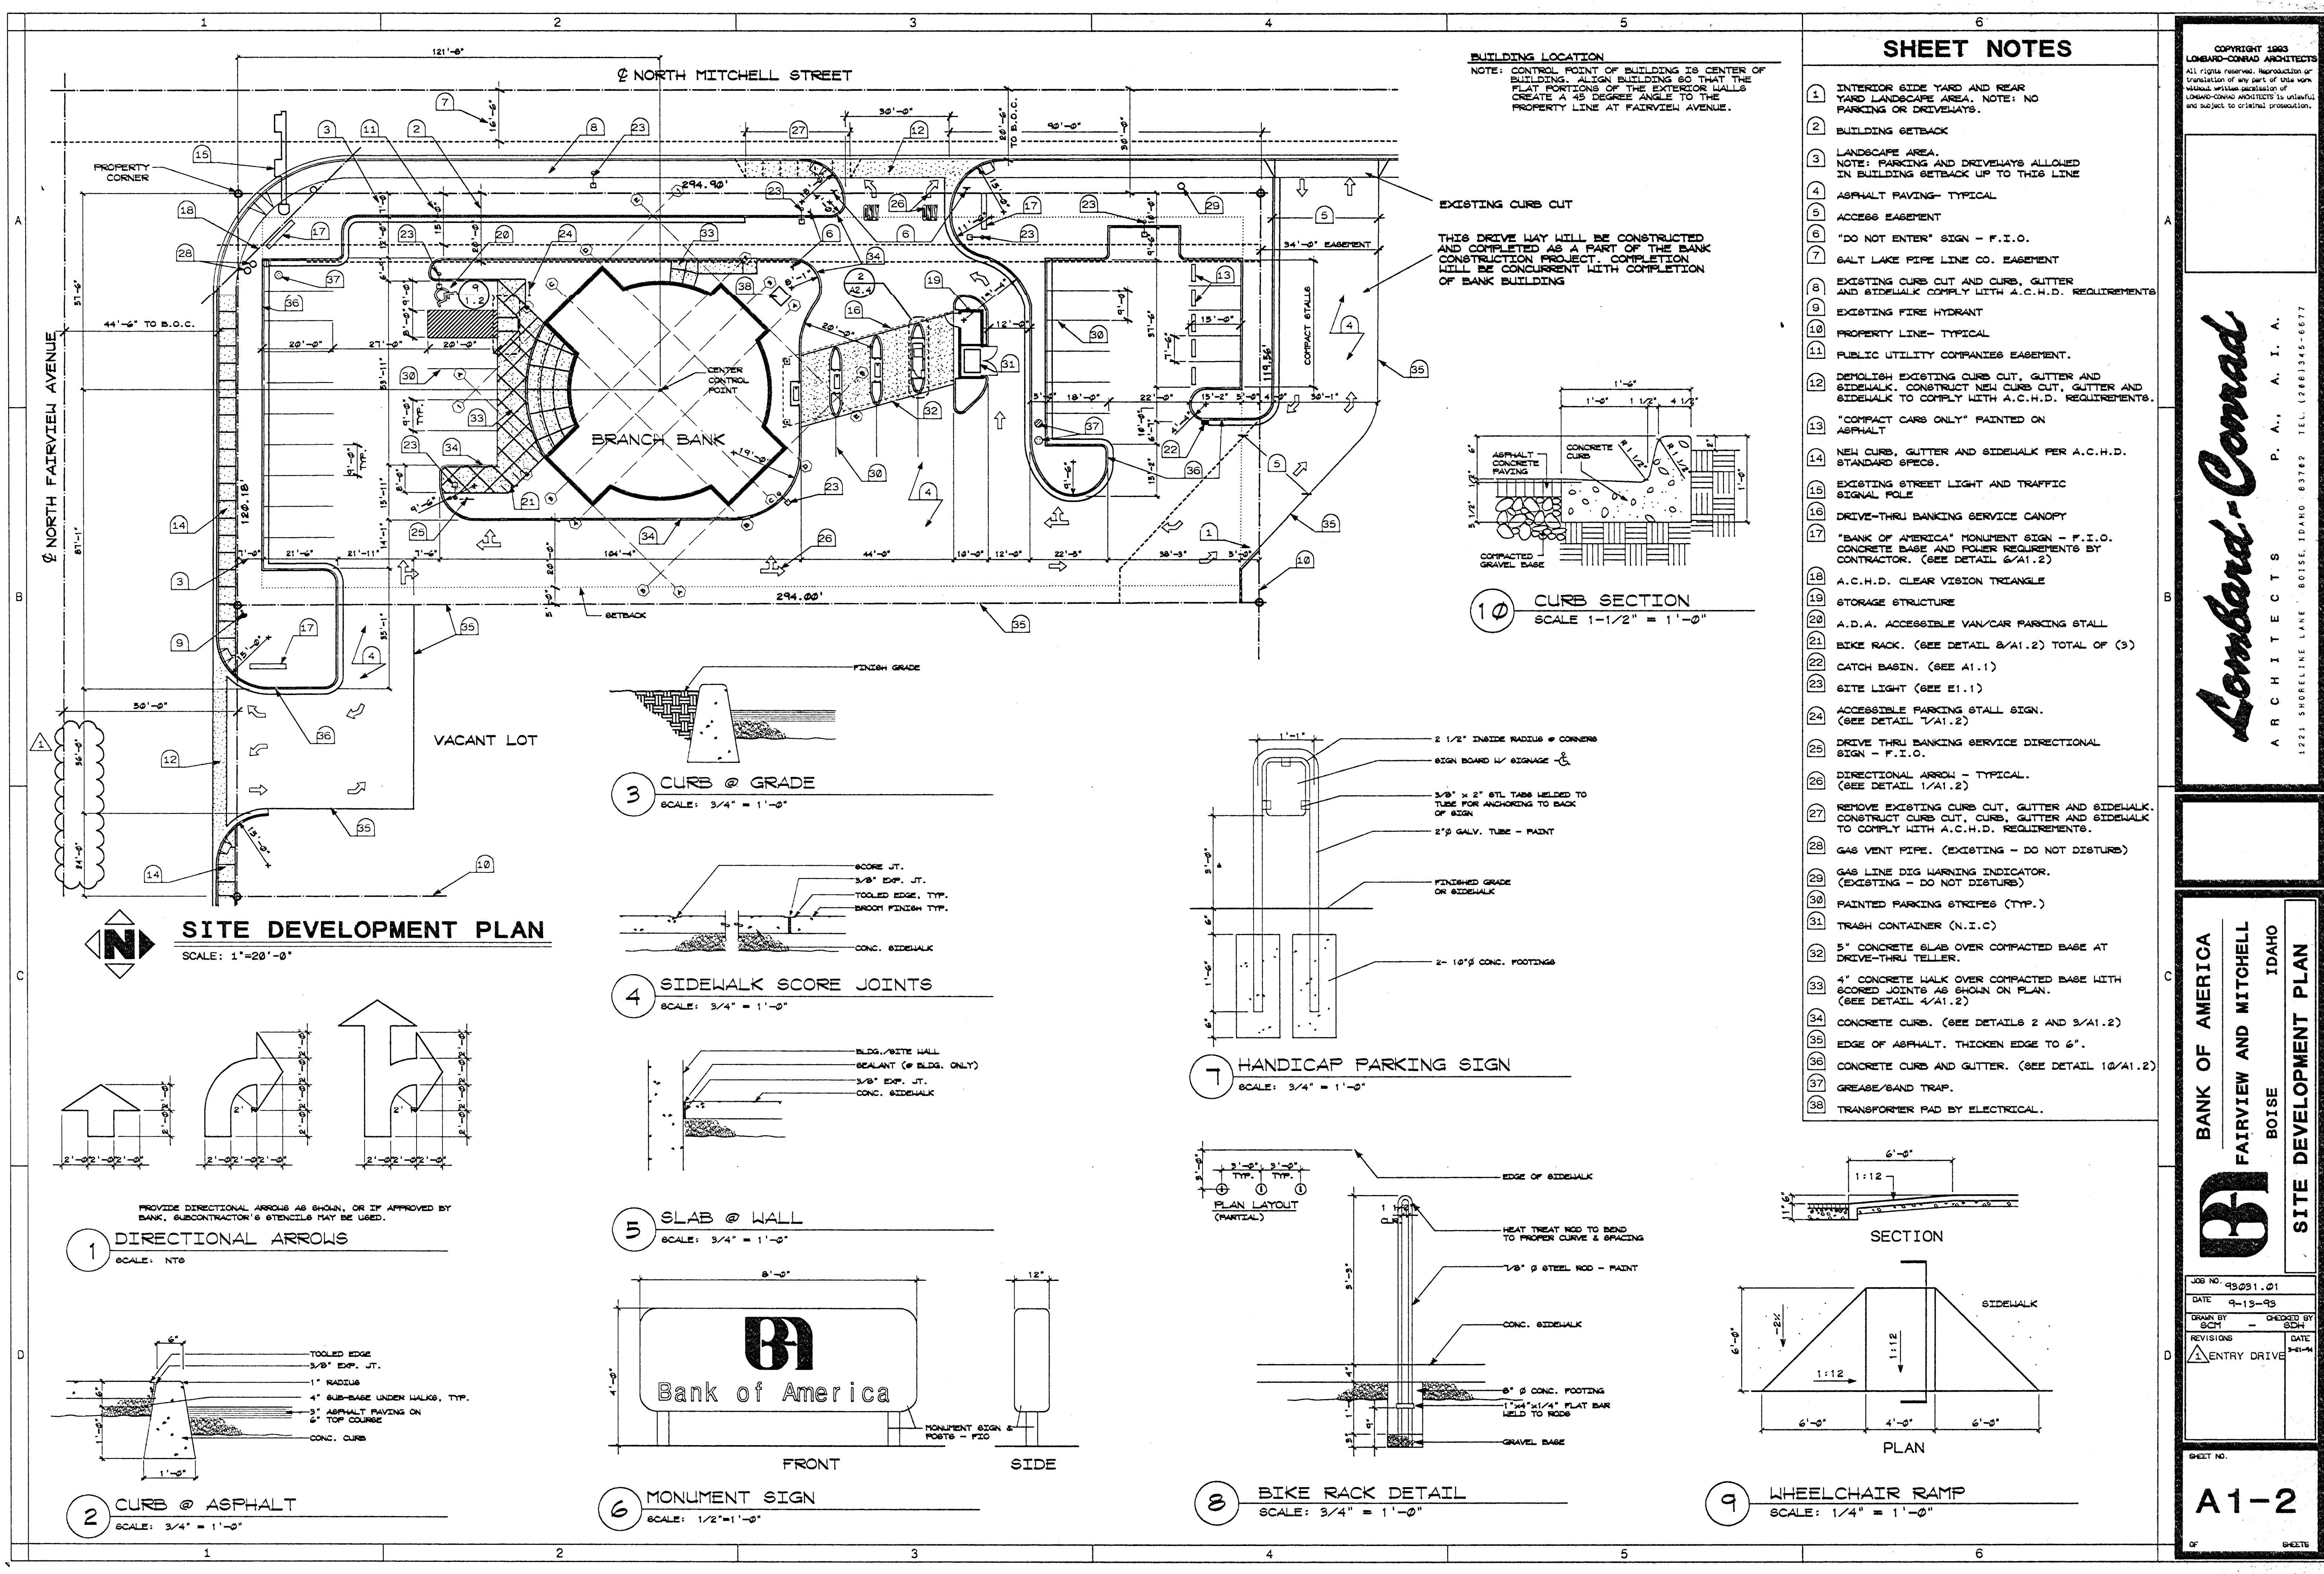


BUILDING LOCATION
NOTE: CONTROL POINT OF BUILDING IS CENTER OF BUILDING. ALIGN BUILDING SO THAT THE FLAT PORTIONS OF THE EXTERIOR WALLS CREATE A 45 DEGREE ANGLE TO THE PROPERTY LINE AT FAIRVIEW AVENUE.


EXISTING CURB CUT
THIS DRIVE WAY WILL BE CONSTRUCTED AND COMPLETED AS A PART OF THE BANK CONSTRUCTION PROJECT. COMPLETION WILL BE CONCURRENT WITH COMPLETION OF BANK BUILDING

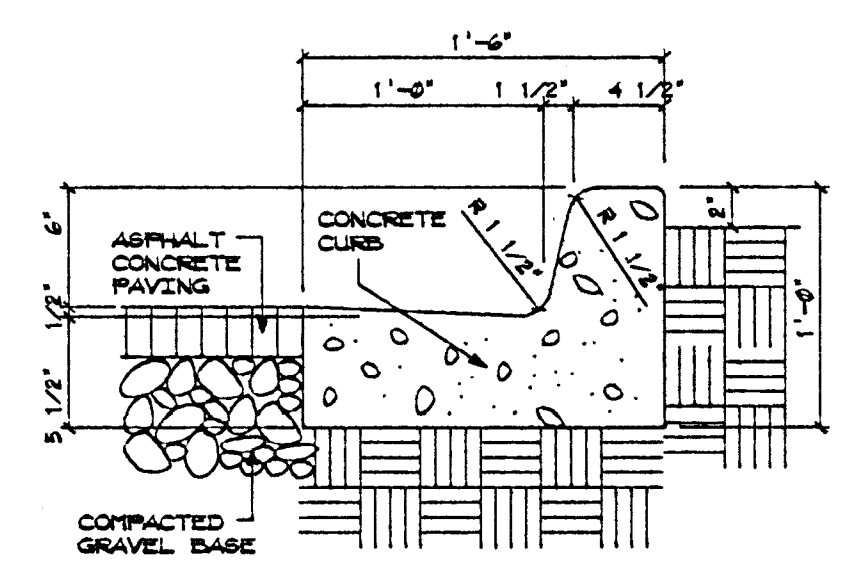


10 CURB SECTION
SCALE 1-1/2" = 1'-0"

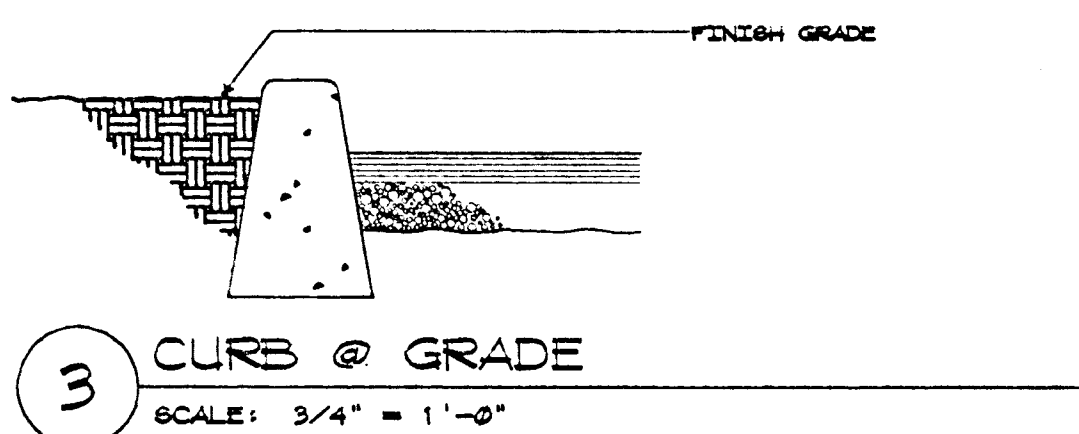


3 CURB @ GRADE
SCALE: 3/4" = 1'-0"

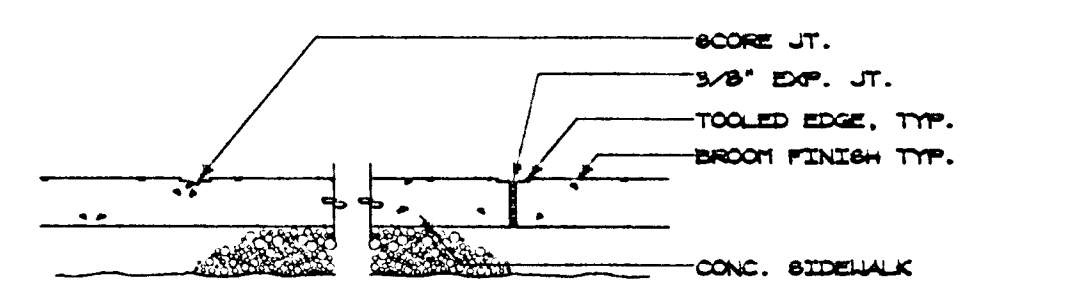


4 SIDEWALK SCORE JOINTS
SCALE: 3/4" = 1'-0"

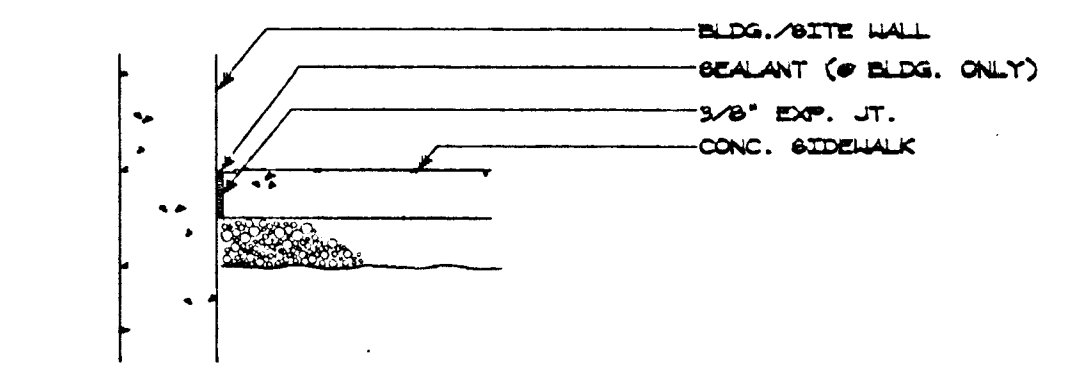


5 SLAB @ WALL
SCALE: 3/4" = 1'-0"

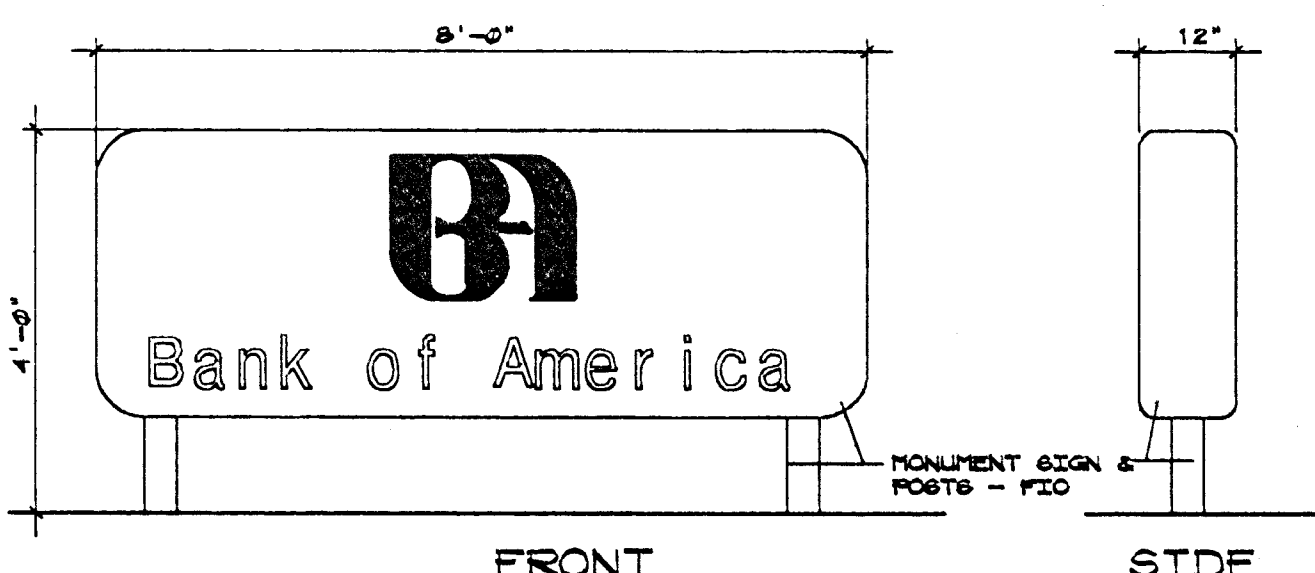


6 MONUMENT SIGN
SCALE: 1/2"=1'-0"

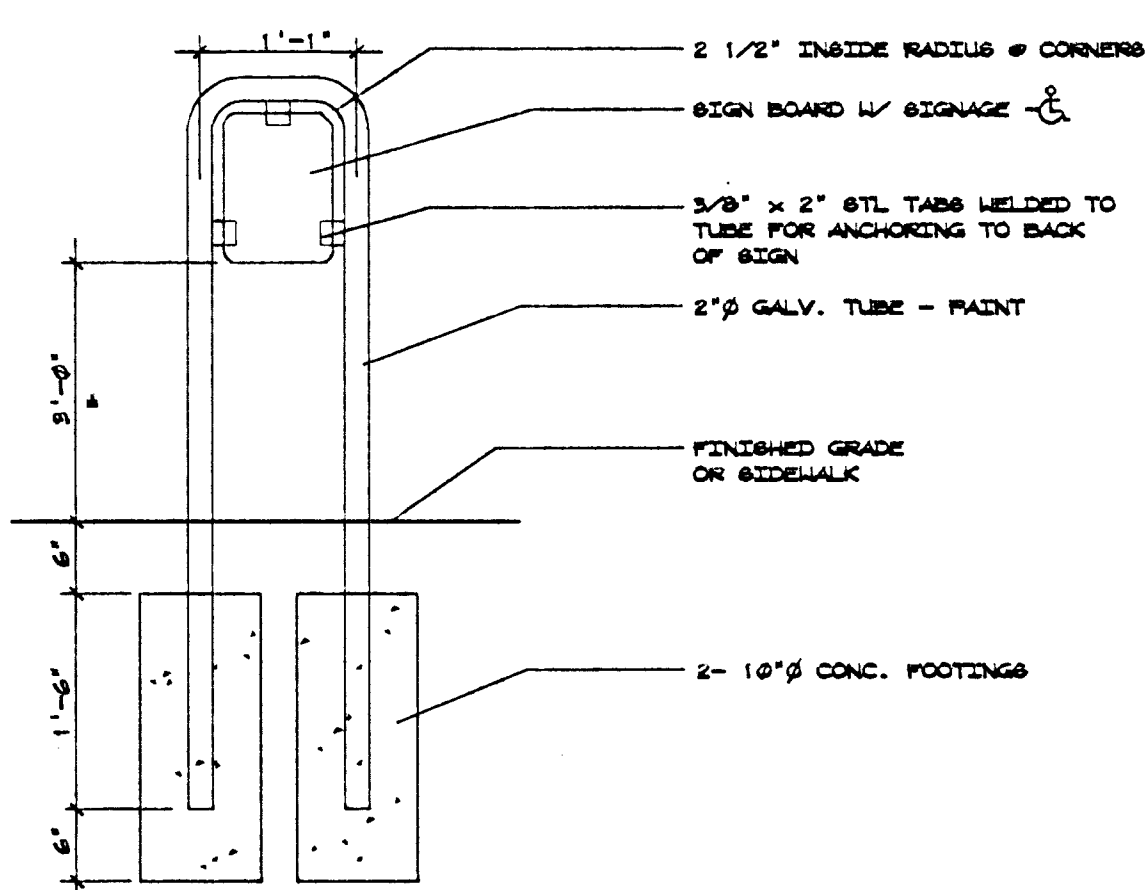

7 HANDICAP PARKING SIGN
SCALE: 3/4" = 1'-0"

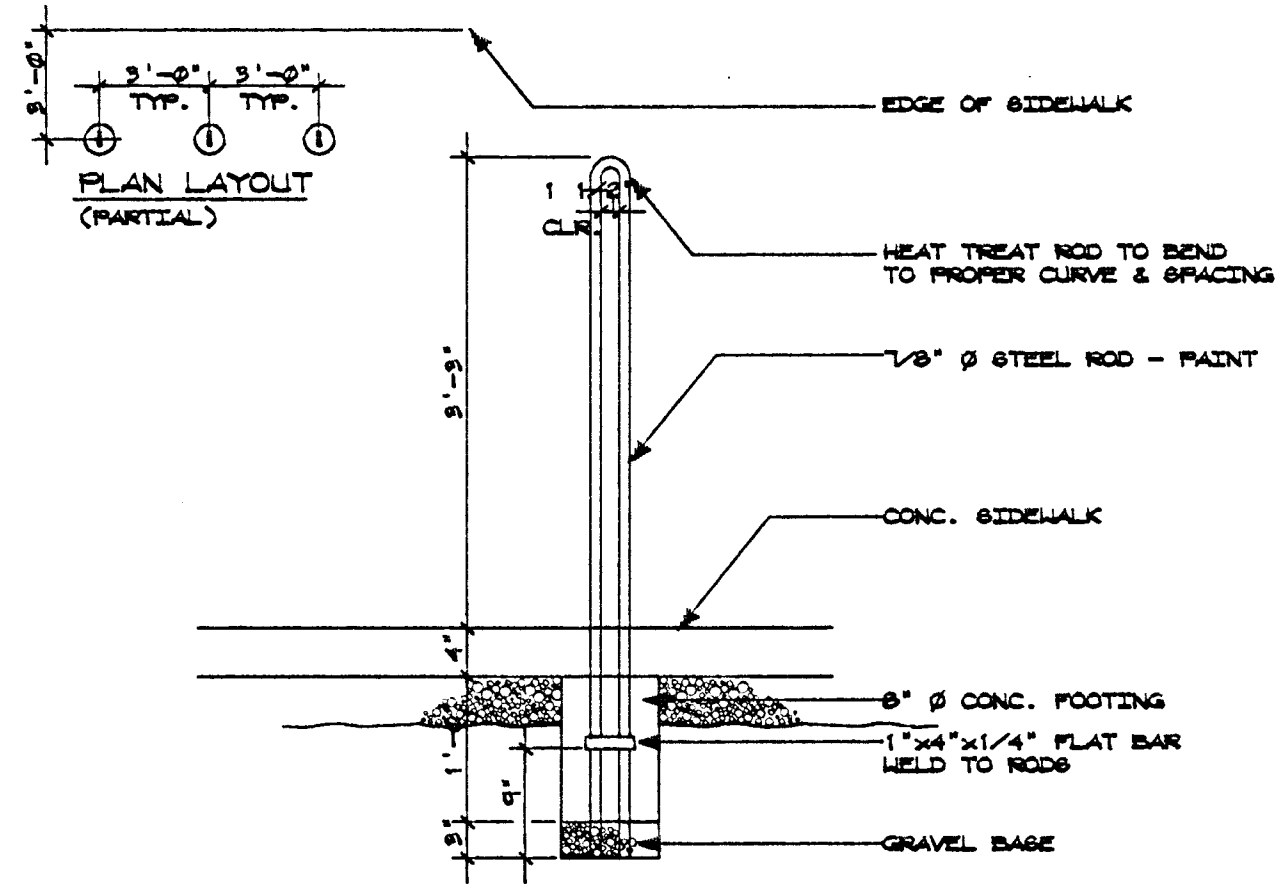

8 BIKE RACK DETAIL
SCALE: 3/4" = 1'-0"

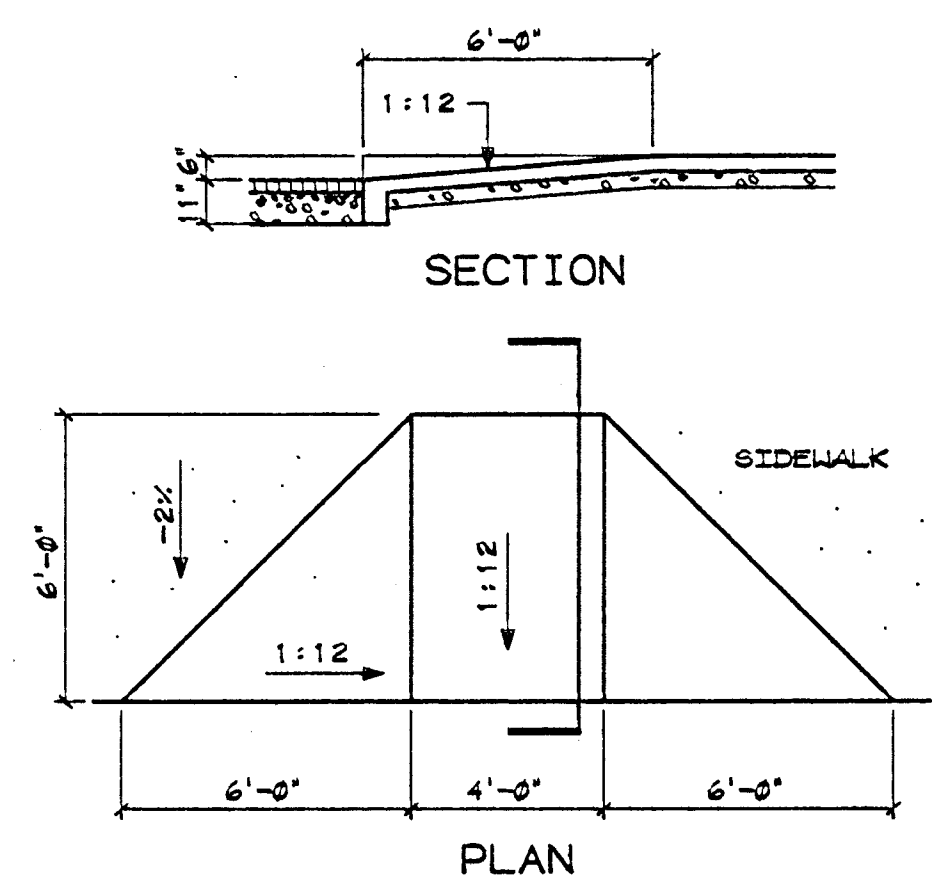

9 WHEELCHAIR RAMP
SCALE: 1/4" = 1'-0"

SHEET NOTES

- 1 INTERIOR SIDE YARD AND REAR YARD LANDSCAPE AREA. NOTE: NO PARKING OR DRIVEWAYS.
- 2 BUILDING SETBACK
- 3 LANDSCAPE AREA. NOTE: PARKING AND DRIVEWAYS ALLOWED IN BUILDING SETBACK UP TO THIS LINE
- 4 ASPHALT PAVING- TYPICAL
- 5 ACCESS EASEMENT
- 6 "DO NOT ENTER" SIGN - F.I.O.
- 7 SALT LAKE PIPE LINE CO. EASEMENT
- 8 EXISTING CURB CUT AND CURB, GUTTER AND SIDEWALK COMPLY WITH A.C.H.D. REQUIREMENTS
- 9 EXISTING FIRE HYDRANT
- 10 PROPERTY LINE- TYPICAL
- 11 PUBLIC UTILITY COMPANIES EASEMENT.
- 12 DEMOLISH EXISTING CURB CUT, GUTTER AND SIDEWALK. CONSTRUCT NEW CURB CUT, GUTTER AND SIDEWALK TO COMPLY WITH A.C.H.D. REQUIREMENTS.
- 13 "COMPACT CARS ONLY" PAINTED ON ASPHALT
- 14 NEW CURB, GUTTER AND SIDEWALK PER A.C.H.D. STANDARD SPECS.
- 15 EXISTING STREET LIGHT AND TRAFFIC SIGNAL POLE
- 16 DRIVE-THRU BANKING SERVICE CANOPY
- 17 "BANK OF AMERICA" MONUMENT SIGN - F.I.O. CONCRETE BASE AND POWER REQUIREMENTS BY CONTRACTOR. (SEE DETAIL 6/A1.2)
- 18 A.C.H.D. CLEAR VISION TRIANGLE
- 19 STORAGE STRUCTURE
- 20 A.D.A. ACCESSIBLE VAN/CAR PARKING STALL
- 21 BIKE RACK. (SEE DETAIL 8/A1.2) TOTAL OF (3)
- 22 CATCH BASIN. (SEE A1.1)
- 23 SITE LIGHT (SEE E1.1)
- 24 ACCESSIBLE PARKING STALL SIGN. (SEE DETAIL 7/A1.2)
- 25 DRIVE THRU BANKING SERVICE DIRECTIONAL SIGN - F.I.O.
- 26 DIRECTIONAL ARROW - TYPICAL. (SEE DETAIL 1/A1.2)
- 27 REMOVE EXISTING CURB CUT, GUTTER AND SIDEWALK. CONSTRUCT CURB CUT, CURB, GUTTER AND SIDEWALK TO COMPLY WITH A.C.H.D. REQUIREMENTS.
- 28 GAS VENT PIPE. (EXISTING - DO NOT DISTURB)
- 29 GAS LINE DIG WARNING INDICATOR. (EXISTING - DO NOT DISTURB)
- 30 PAINTED PARKING STRIPES (TYP.)
- 31 TRASH CONTAINER (N.I.C)
- 32 5" CONCRETE SLAB OVER COMPACTED BASE AT DRIVE-THRU TELLER.
- 33 4" CONCRETE WALK OVER COMPACTED BASE WITH SCORED JOINTS AS SHOWN ON PLAN. (SEE DETAIL 4/A1.2)
- 34 CONCRETE CURB. (SEE DETAILS 2 AND 3/A1.2)
- 35 EDGE OF ASPHALT. THICKEN EDGE TO 6".
- 36 CONCRETE CURB AND GUTTER. (SEE DETAIL 10/A1.2)
- 37 GREASE/SAND TRAP.
- 38 TRANSFORMER PAD BY ELECTRICAL.


Lombard-Conrad
ARCHITECTS
P. A., A. I. A.
1221 SHORELINE LANE BOISE, IDAHO 83702 TEL. (208)345-6677

BANK OF AMERICA
FAIRVIEW AND MITCHELL
BOISE
IDAHO

SITE DEVELOPMENT PLAN

JOB NO: 93031.01
DATE: 9-13-93
DRAWN BY: SCH
CHECKED BY: SCH
REVISIONS: ENTRY DRIVE
DATE: 9-14-93

SHEET NO. **A1-2**

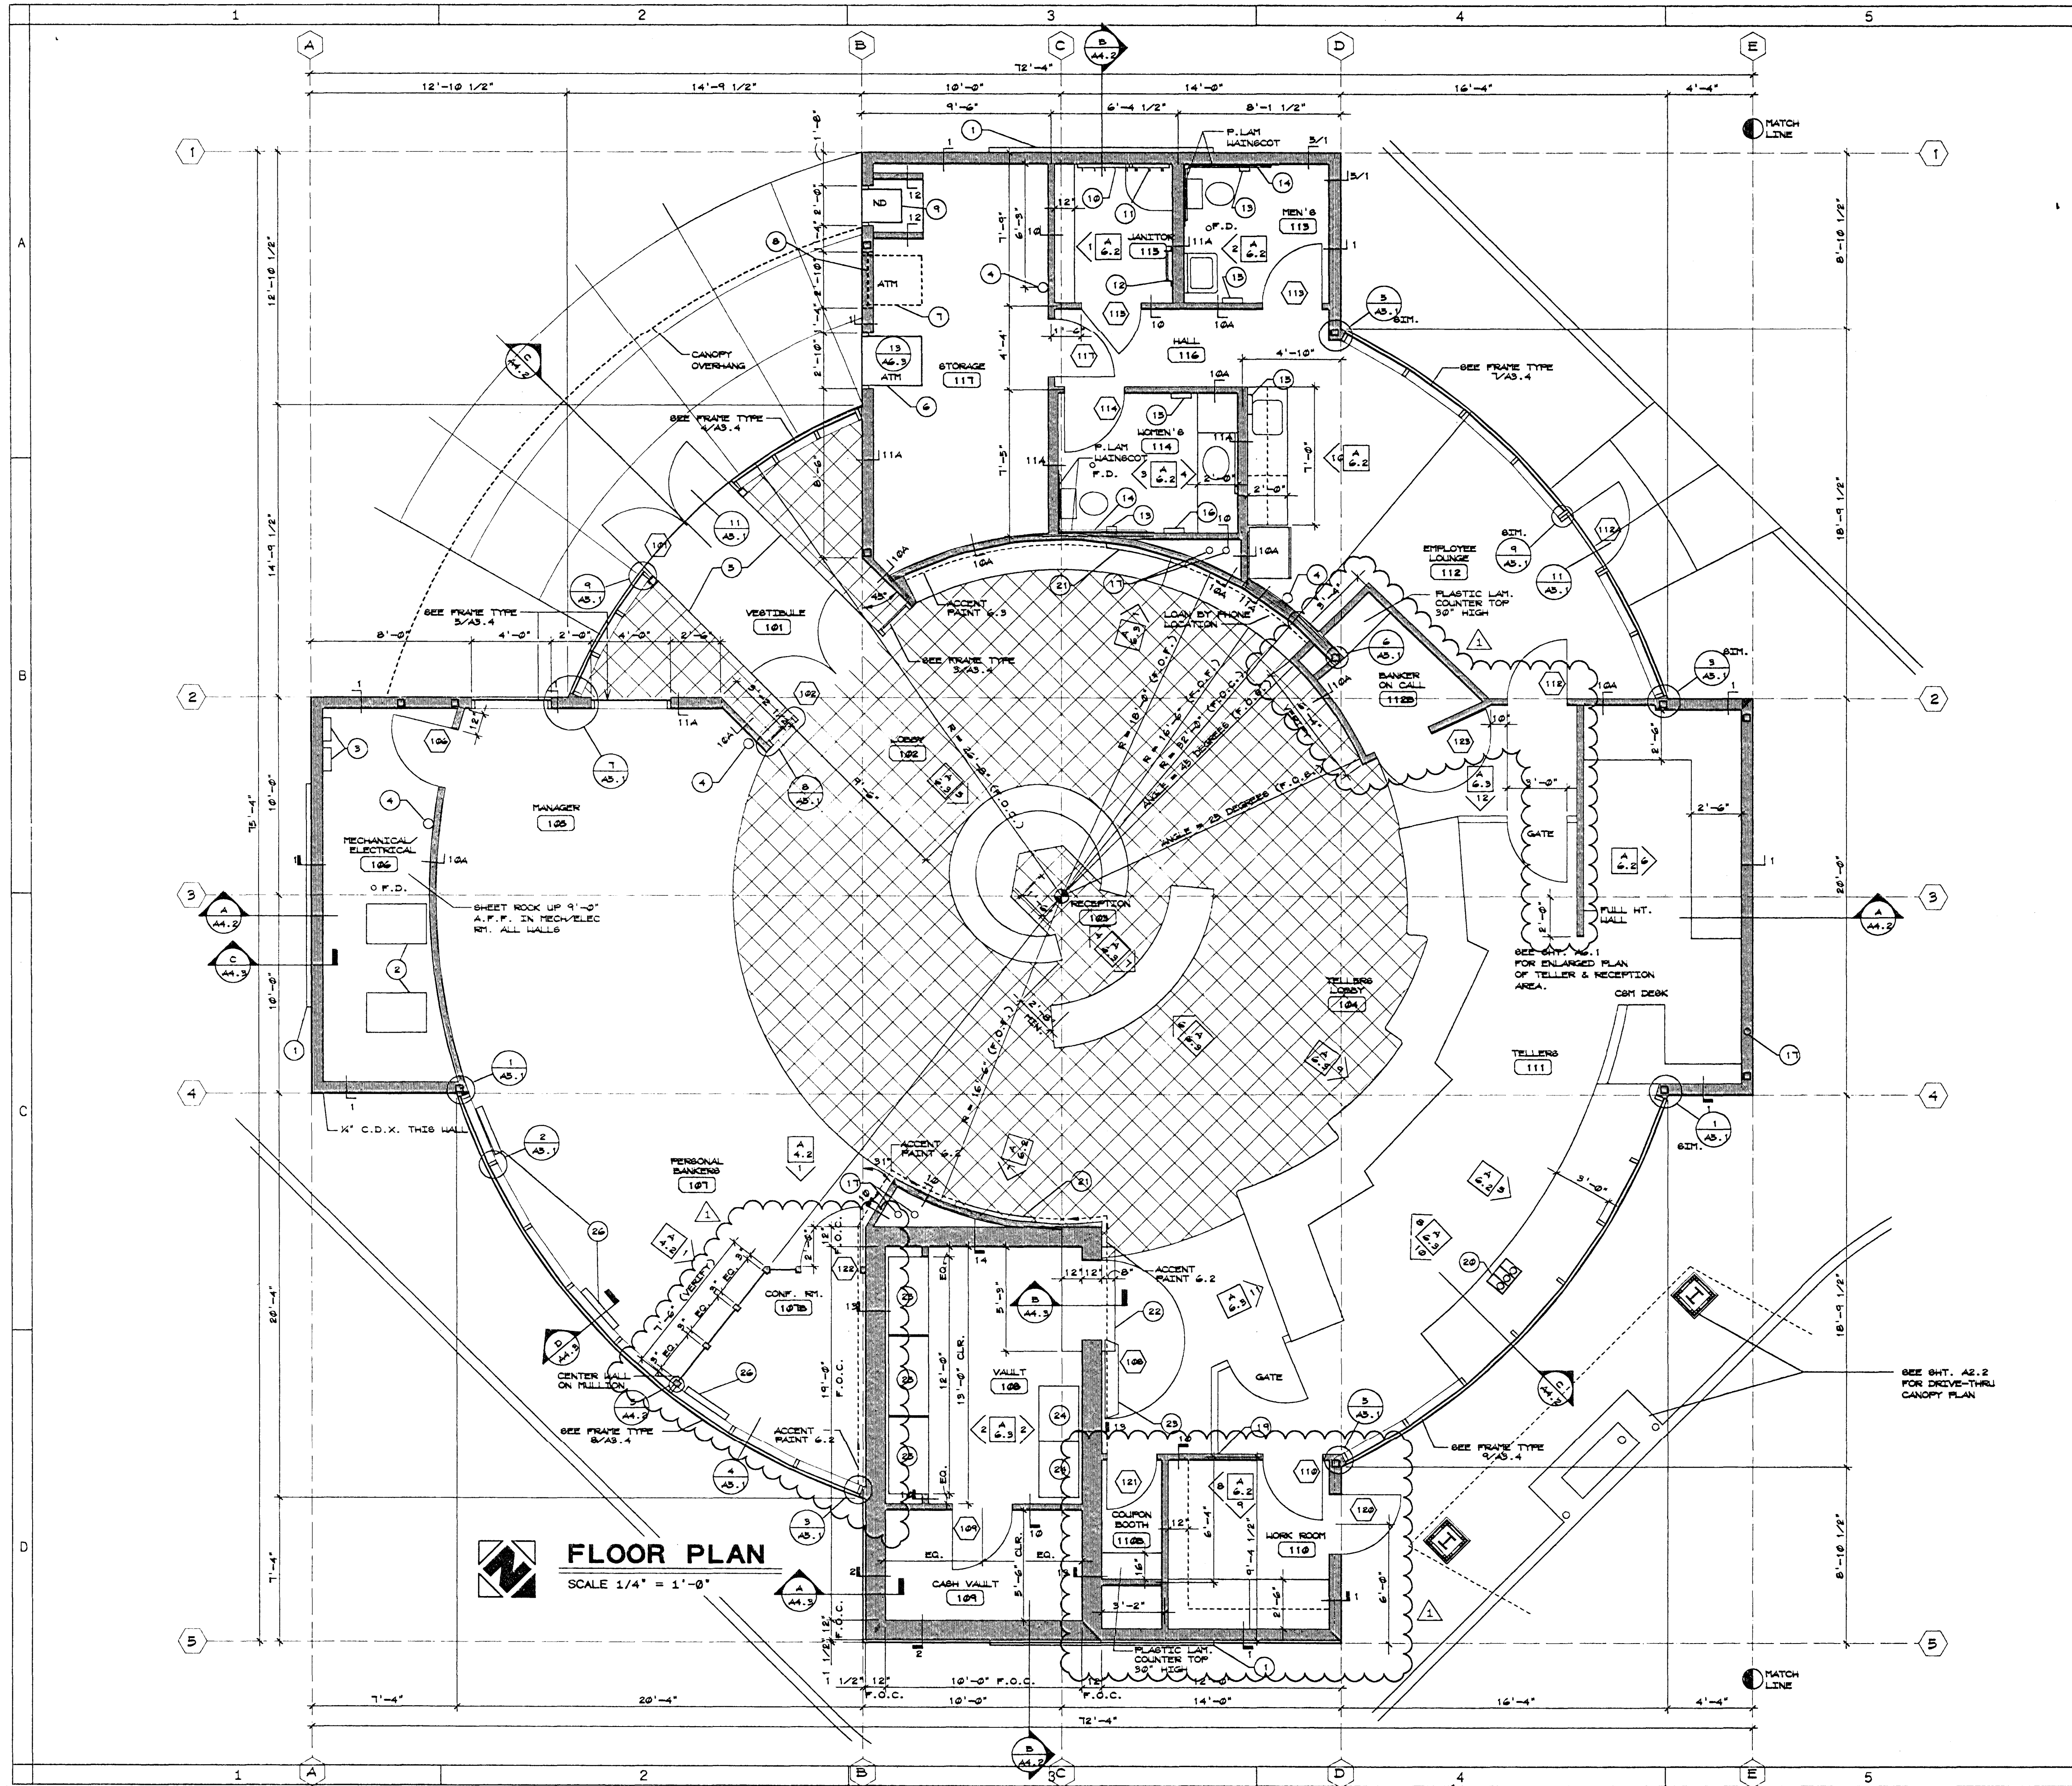

GENERAL NOTES - FLOOR PLAN

1. EXTERIOR GRID LINES ARE ON FACE OF CONCRETE FOUNDATION WALLS/FACE OF STUD WALLS.
2. ALL DIMENSIONS ARE TO GRID LINES, FACE OF CONCRETE, FACE OF EXTERIOR STUD WALLS AND CENTERLINE OF INTERIOR STUD WALLS, UNLESS NOTED OTHERWISE.
3. A WALL TYPE CONTIGUES THE FULL ROOM LENGTH, INCLUDING ANY JOGS, ANGLES OR STUD WALLS FOR THE SIDE OF THE WALL UPON WHICH THE FLAG OCCURS.
4. AN "A" OR "B" SUFFIX ON THE WALL TYPE INDICATES ALL COMPONENTS OF THAT TYPE REMAIN UNCHANGED EXCEPT FOR THE LISTED "A" OR "B" ITEM.
5. A FINISH INDICATION AT A SPECIFIC LOCATION OR WALL IS CONTINUOUS FOR THAT AREA OR WALL LENGTH. IT IS NOT LISTING THE FINISH AT ONLY THAT SPOT.

CODED NOTES - FLOOR PLAN

- 1 BANK OF AMERICA SIGN & LOGO - FIO. POWER CONNECTION BY CONTRACTOR.
- 2 HVAC UNITS. SEE MECHANICAL FOR LOCATION.
- 3 ELECTRICAL PANELS. SEE ELECTRICAL.
- 4 FIRE EXTINGUISHER MOUNTED ON WALL.
- 5 ENTRY MAT INSTALLED BETWEEN FLOOR TILE.
- 6 AUTOMATIC TELLER MACHINE - FIO. SEE DETAIL 13/AS.3.
- 7 FUTURE ATM LOCATION.
- 8 PROVIDE HEADER IN WALL FOR FUTURE ATM. SEE STRUCTURAL.
- 9 NIGHT DEPOSIT - FIO. SEE DETAILS 14 & 15/AS.3.
- 10 10 DAY PAPER STORAGE HOOKS, 2 ROWS.
- 11 MOP HOLDER.
- 12 ROOF ACCESS LADDER & ROOF HATCH ABOVE. SEE DETAIL 1/AS.3.
- 13 TOILET PAPER DISPENSER.
- 14 HANDICAP GRAB BAR.
- 15 PAPER TOWEL DISPENSER.
- 16 SANITARY WIPER DISPOSAL.
- 17 ROOF DRAIN DOWNSPOUTS.
- 18 NOT USED.
- 19 PROVIDE SOLID BLOCKING IN WALL.
- 20 PNEUMATIC TUBE SYSTEM - FIO.
- 21 INTERIOR BANK OF AMERICA SIGN & LOGO - FIO. POWER CONNECTION BY CONTRACTOR.
- 22 CONTRACTOR TO FILL & SMOOTH 1-1/2" DEEP PIT AFTER VAULT DOOR IS SET.
- 23 VAULT DOOR - FIO. SEE DETAILS 13, 14, & 15/AS.2.
- 24 COUPON BOOTHS. SEE DETAIL 9/AS.2.
- 25 SAFE DEPOSIT BOXES - FIO.
- 26 FLOOR REGISTERS. SEE MECHANICAL.

WALL TYPES

- EXTERIOR WALLS:
1. EXTERIOR INSULATION & FINISH SYSTEM
1/2" GYPSUM SHEATHING
1/2" PLYWOOD SHEATHING
2 X 6 STUDS @ 16" O.C.
R-19 BATT INSULATION
VAPOR BARRIER
 2. EXTERIOR INSULATION & FINISH SYSTEM
1/2" GYPSUM SHEATHING
1/2" PLYWOOD SHEATHING
2 X 4 LAID FLAT FURRING @ 24" O.C.
12" CONCRETE VAULT WALL
2 X 4 LAID FLAT FURRING @ 24" O.C.
1-1/2" RIGID INSULATION
VAPOR BARRIER
 3. EXTERIOR INSULATION & FINISH SYSTEM
1/2" GYPSUM SHEATHING
1/2" PLYWOOD SHEATHING
2 X 6 STUDS @ 16" O.C.
1/2" GYPSUM SHEATHING
EXTERIOR INSULATION & FINISH SYSTEM
 4. EXTERIOR INSULATION & FINISH SYSTEM
1/2" GYPSUM SHEATHING
1/2" PLYWOOD SHEATHING
2 X 6 STUDS @ 16" O.C.
 5. 6" TYPE X WATER RESISTANT CORE @ EXTERIOR
6" TYPE X GYP. BD. TO UNDERSIDE OF DECK @ INTERIOR
INTERIOR WALLS
 10. 2 X 4 STUDS @ 16" O.C.
 - 10A. 3" ACOUSTICAL INSULATION
 11. 2 X 6 STUDS @ 16" O.C.
 - 11A. 2 LAYERS OF 2" ACOUSTICAL INSULATION
 12. 6" CONCRETE WALL
 13. 2 X 4 LAID FLAT FURRING @ 24" O.C.
12" CONCRETE VAULT WALL
2 X 4 LAID FLAT FURRING @ 24" O.C.
 14. 2 X 4 LAID FLAT FURRING @ 24" O.C.
12 CONCRETE VAULT WALL
 15. EXTERIOR INSULATION & FINISH SYSTEM
1/2" GYPSUM SHEATHING
2 X 4 STUDS @ 16" O.C.

COPYRIGHT 1993
Lombard-Conrad ARCHITECTS

All rights reserved. Reproduction or translation of any part of this work without written permission of Lombard-Conrad Architects is unlawful and subject to criminal prosecution.

Lombard-Conrad

ARCHITECTS

P. A., A. I. A.


1221 SHORELINE LANE BOISE, IDAHO 83702 TEL. (208)345-6677

BANK OF AMERICA
FAIRVIEW AND MITCHELL
BOISE
IDAHO

FLOOR PLAN

JOB NO. 93031.01
DATE 9-13-93
DRAWN BY SCH - CHECKED BY SDH
REVISIONS
1 FLOOR PLAN DATE 9-21-94


SHEET NO.
A2.1
OF SHEETS

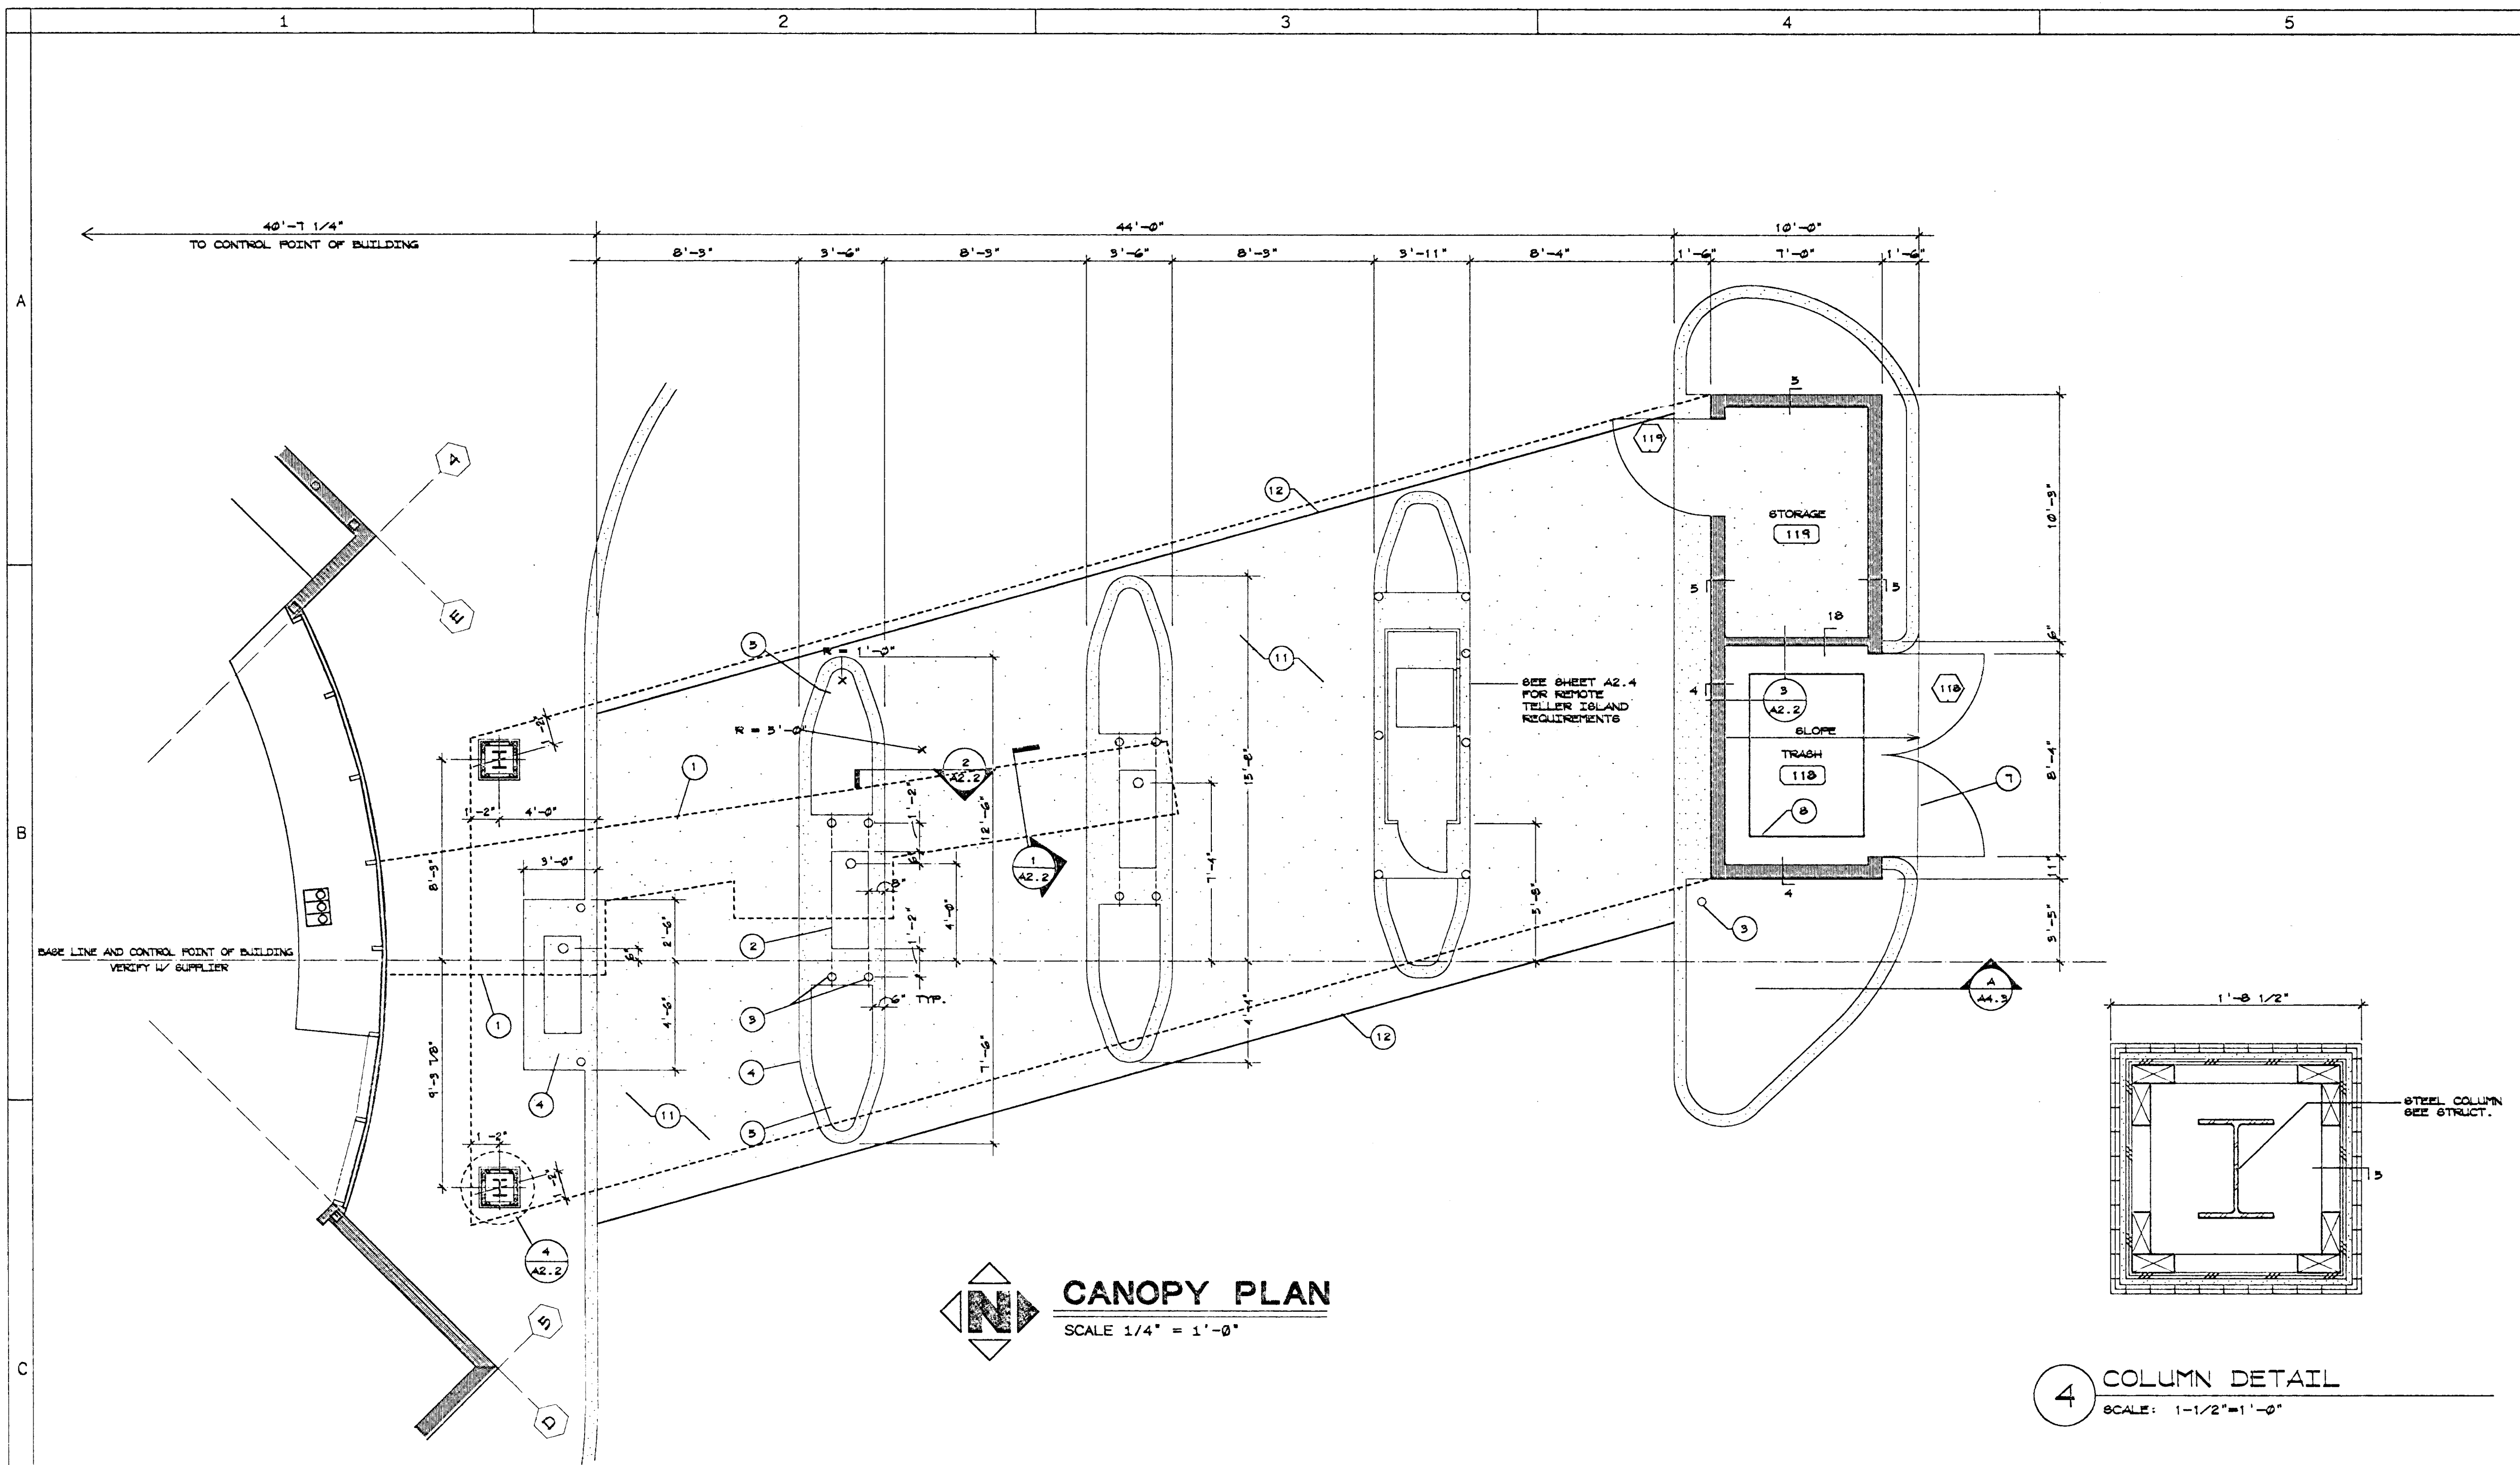


CANOPY PLAN
SCALE 1/4" = 1'-0"

REQUIREMENTS AND PROCEDURES FOR DIRECT BURIAL TUBE INSTALLATIONS


1. THE BUILDING FLOOR SLAB AND THE FINISHED EXTERIOR WALL IN THE TELLER AREA WITH THE REQUIRED ROUGH OPENINGS MUST BE CONSTRUCTED BEFORE MANUFACTURER CAN INSTALL THE PNEUMATIC TUBE SYSTEM.
2. THE GENERAL CONTRACTOR IS TO HAVE THE TRENCH OPEN AND FREE OF WATER WITH A 2" LAYER OF COMPACTED SAND BEFORE MOBILE TUBE INSTALLER ARRIVES AT THE SITE.
3. THE GENERAL CONTRACTOR IS TO KEEP TRENCHING FREE OF WATER UNTIL TUBE IS COMPLETELY INSTALLED.
4. MANUFACTURER INSTALLS PNEUMATIC RUBE, TESTS TUBE RUN WITH TEST CARRIER, CHECKS FOR LEAKS AND JOINT TIGHTNESS, REMOVES SUPPORT BLOOMS AND APPLIES PROTECTION TO ALL EXPOSED SECTIONS OF TUBING.
5. GENERAL CONTRACTOR THEN DEPOSITS 18" OF FINELY HAND COMPACTED SAND AROUND AND OVER TUBE.
6. MANUFACTURER'S INSTALLER REPEATS CARRIER TEST.
7. THE ELECTRICAL CONTRACTOR INSTALLS CONDUITS AS REQUIRED IN TRENCH AND CONDUIT ENTRIES INTO EQUIPMENT AS SHOWN ON THE ELECTRICAL SHEET.
8. THE GENERAL CONTRACTOR THEN BACKFILLS TRENCH WITH GRANULAR MATERIAL COMPACTED AFTER EVERY 6" LAYER AND PLACES PAVEMENT AS REQUIRED.
9. GENERAL CONTRACTOR SHALL BE RESPONSIBLE FOR THE TRENCHING & BACKFILLING RELATED TO THE PNEUMATIC TRENCHING DETAILS & AS REQUIRED BY THE SUPPLIER & IN COMPLIANCE WITH THE SOILS CONDITION AS NOTED IN THE SOILS REPORT.

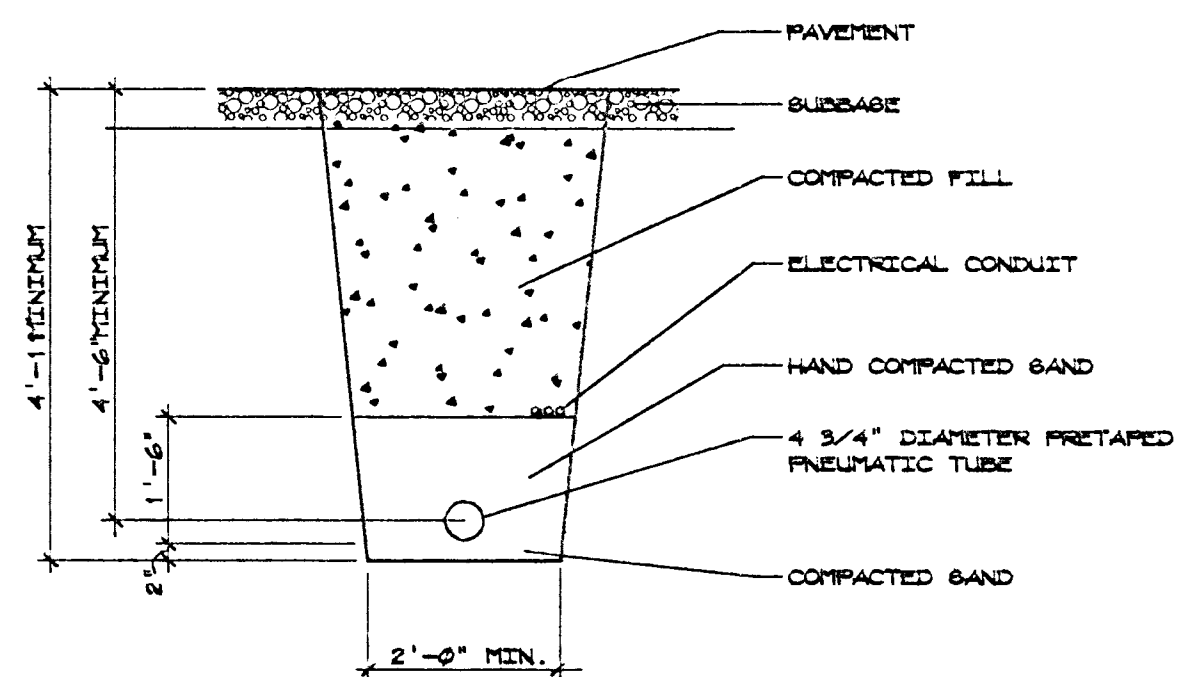


1 PNEUMATIC TUBE TRENCH DETAIL
SCALE: 1/2" = 1'-0"

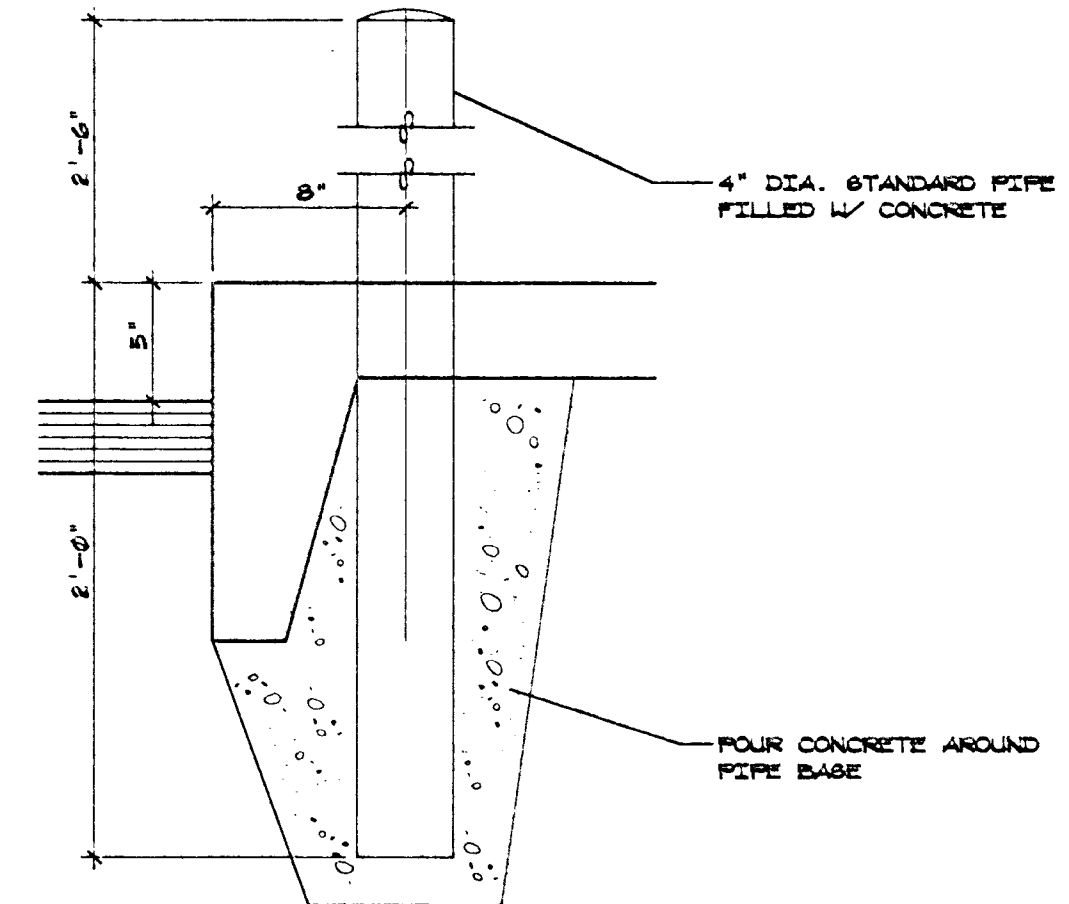

2 4" PIPE BOLLARD
SCALE: 1 1/2" = 1'-0"

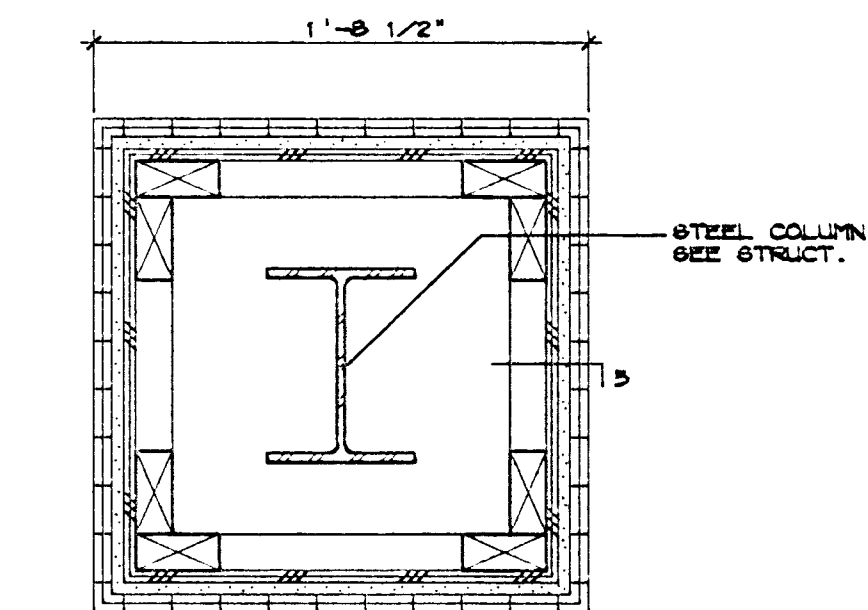

4 COLUMN DETAIL
SCALE: 1-1/2" = 1'-0"

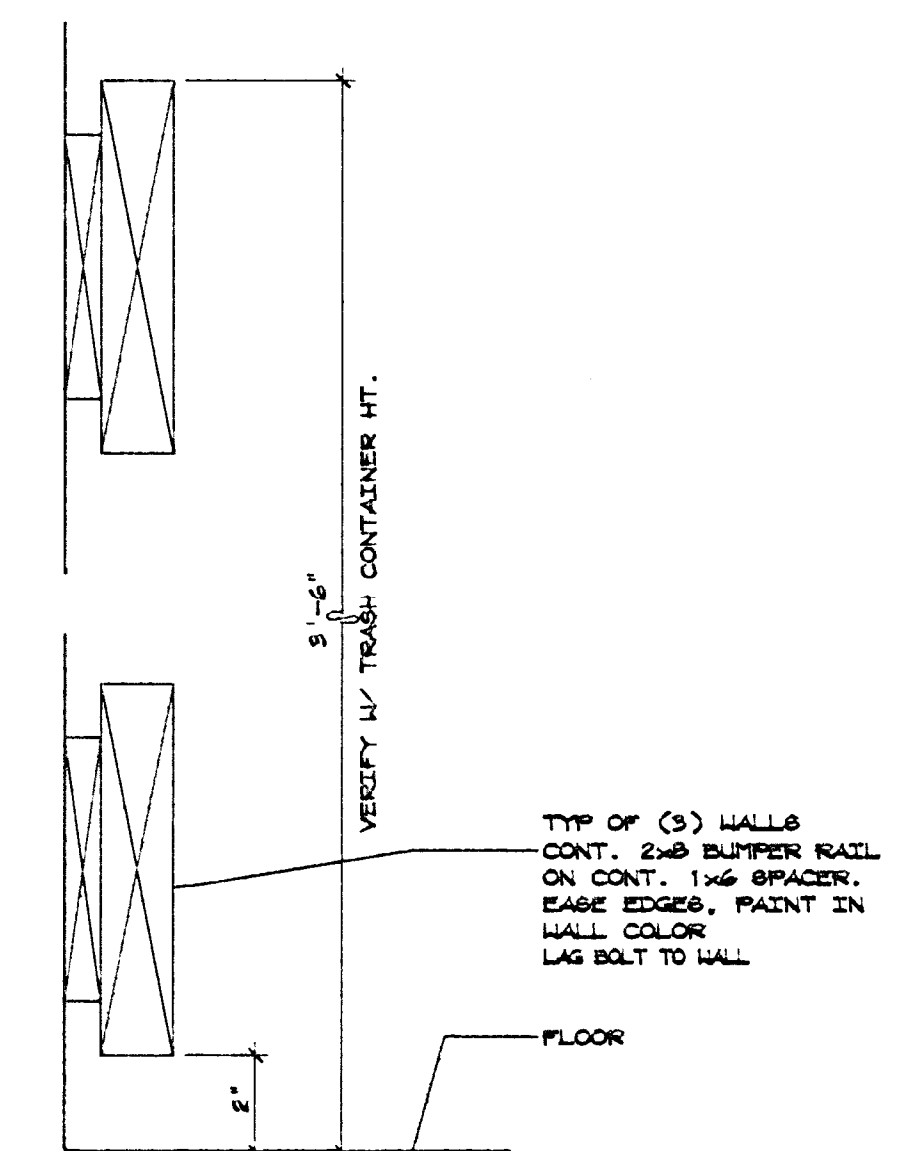

3 WALL BUMPER
SCALE: 3" = 1'-0"

GENERAL NOTES - FLOOR PLAN

1. EXTERIOR GRID LINES ARE ON FACE OF CONCRETE FOUNDATION WALLS/FACE OF STUD WALLS.
2. ALL DIMENSIONS ARE TO GRID LINES, FACE OF CONCRETE, FACE OF EXTERIOR STUD WALLS AND CENTERLINE OF INTERIOR STUD WALLS, UNLESS NOTED OTHERWISE.
3. A WALL TYPE CONTIGUES THE FULL ROOM LENGTH, INCLUDING ANY JOGS, ANGLES OR STUD WALLS FOR THE SIDE OF THE WALL UPON WHICH THE FLAG OCCURS.
4. AN "A" OR "B" SUFFIX ON THE WALL TYPE INDICATES ALL COMPONENTS OF THAT TYPE REMAIN UNCHANGED EXCEPT FOR THE LISTED "A" OR "B" ITEM.
5. A FINISH INDICATION AT A SPECIFIC LOCATION OR WALL IS CONTINUOUS FOR THAT AREA OR WALL LENGTH. IT IS NOT LISTING THE FINISH AT ONLY THAT SPOT.
6. VERIFY EXACT LOCATION OF REMOTE BANKING UNITS PRIOR TO TRENCHING.

CODED NOTES - FLOOR PLAN

- 1 PNEUMATIC TUBE TRENCH, SEE DETAIL 1/A2.2
- 2 TELLER CUSTOMER UNIT BY LEFEBURE #2301 TEL-AIR SYSTEM "90 X L" - FIO.
- 3 4" PIPE BOLLARD FILLED WITH CONCRETE, SEE DETAIL 2/A2.2
- 4 5" HIGH CONCRETE ISLAND CURB.
- 5 LANDSCAPE AREA, TYP.
- 6 (2) 2 X 8 WOOD BUMPER RAILS ALL SIDES, SEE DETAIL 3/A2.2
- 7 CONCRETE APRON, SLOPE FROM TRASH ROOM FLOOR TO ASPHALT DRIVE
- 8 TRASH CONTAINER, NIC.
- 9 ROOF DRAIN DOWNSPOUT
- 10 BANK OF AMERICA SIGN & LOGO - FIO
POWER CONNECTION PROVIDED BY CONTRACTOR.
- 11 5" CONCRETE SLAB OVER CONCRETE BASE AT DRIVE-THRU TELLER LANES.
- 12 TRANSITION BETWEEN ASPHALT AND CONCRETE. (THICKEN EDGES OF ASPHALT AND CONCRETE)

WALL TYPES

1. EXTERIOR WALLS:
2. EXTERIOR INSULATION & FINISH SYSTEM
1/2" GYPSUM SHEATHING
1/2" PLYWOOD SHEATHING
2 X 6 STUDS @ 16" O.C.
R-19 BATT INSULATION
VAPOR BARRIER
3. EXTERIOR INSULATION & FINISH SYSTEM
1/2" GYPSUM SHEATHING
1/2" PLYWOOD SHEATHING
2 X 4 LAMINATED PLYWOOD @ 24" O.C.
12" CONCRETE VAULT WALL
2 X 4 LAMINATED PLYWOOD @ 24" O.C.
1-1/2" RIGID INSULATION
VAPOR BARRIER
4. EXTERIOR INSULATION & FINISH SYSTEM
1/2" GYPSUM SHEATHING
1/2" PLYWOOD SHEATHING
2 X 6 STUDS @ 16" O.C.
1/2" GYPSUM SHEATHING
EXTERIOR INSULATION & FINISH SYSTEM
5. EXTERIOR INSULATION & FINISH SYSTEM
1/2" GYPSUM SHEATHING
1/2" PLYWOOD SHEATHING
2 X 6 STUDS @ 16" O.C.
10. INTERIOR WALLS
11. 2 X 4 STUDS @ 16" O.C.
12. 3" ACOUSTICAL INSULATION
13. 2 X 6 STUDS @ 16" O.C.
14. 2 LAYERS OF 2" ACOUSTICAL INSULATION
15. 6" CONCRETE WALL
16. 2 X 4 LAMINATED PLYWOOD @ 24" O.C.
12" CONCRETE VAULT WALL
2 X 4 LAMINATED PLYWOOD @ 24" O.C.
17. 2 X 4 LAMINATED PLYWOOD @ 24" O.C.
12 CONCRETE VAULT WALL
18. EXTERIOR INSULATION & FINISH SYSTEM
1/2" GYPSUM SHEATHING
2 X 4 STUDS @ 16" O.C.

Copyright 1993
Lombard-Conrad Architects

All rights reserved. Reproduction or translation of any part of this work without written permission of Lombard-Conrad Architects is unlawful and subject to criminal prosecution.

Lombard-Conrad
ARCHITECTS
P. A., A. I. A.
1221 SHORELINE LANE BOISE, IDAHO 83702 TEL. (208) 345-6677


BANK OF AMERICA
FAIRVIEW AND MITCHELL
BOISE IDAHO
CANOPY PLAN

JOB NO. 93091.01
DATE 9-9-93
DRAWN BY SCM
CHECKED BY
REVISIONS
DATE


SHEET NO.

A2.2


OF SHEETS

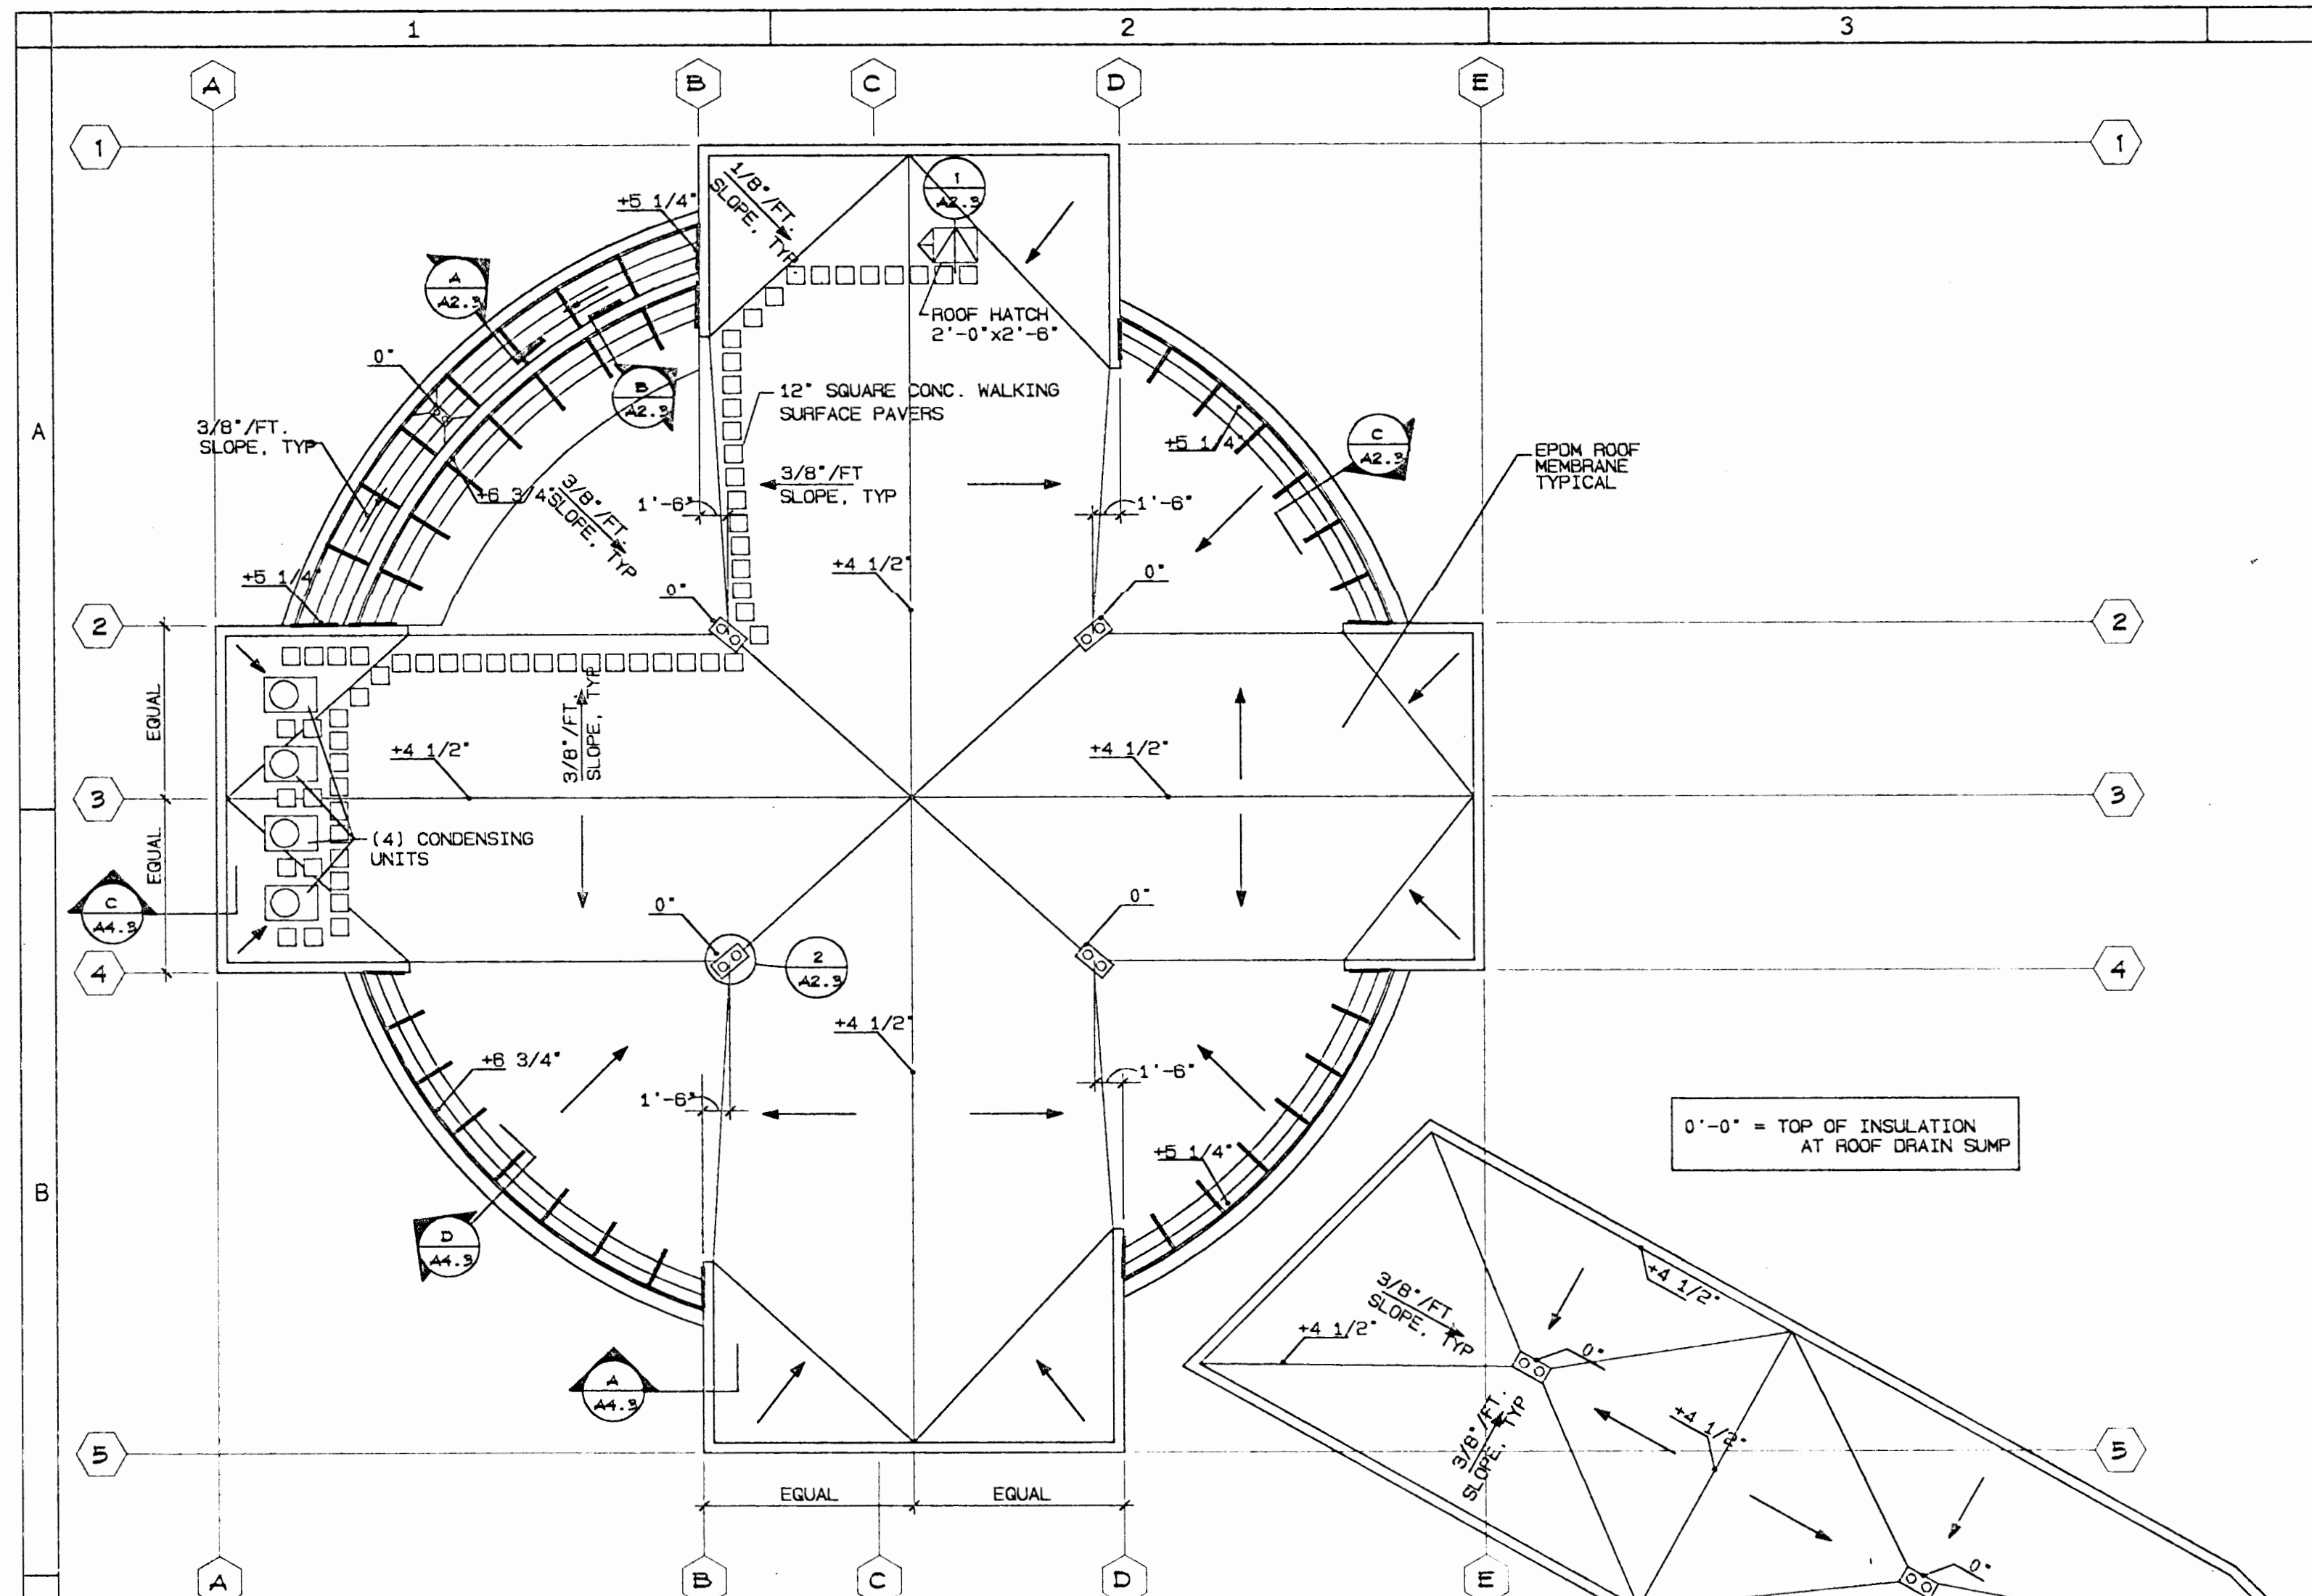


ROOF PLAN
SCALE: 1/8" = 1'-0"

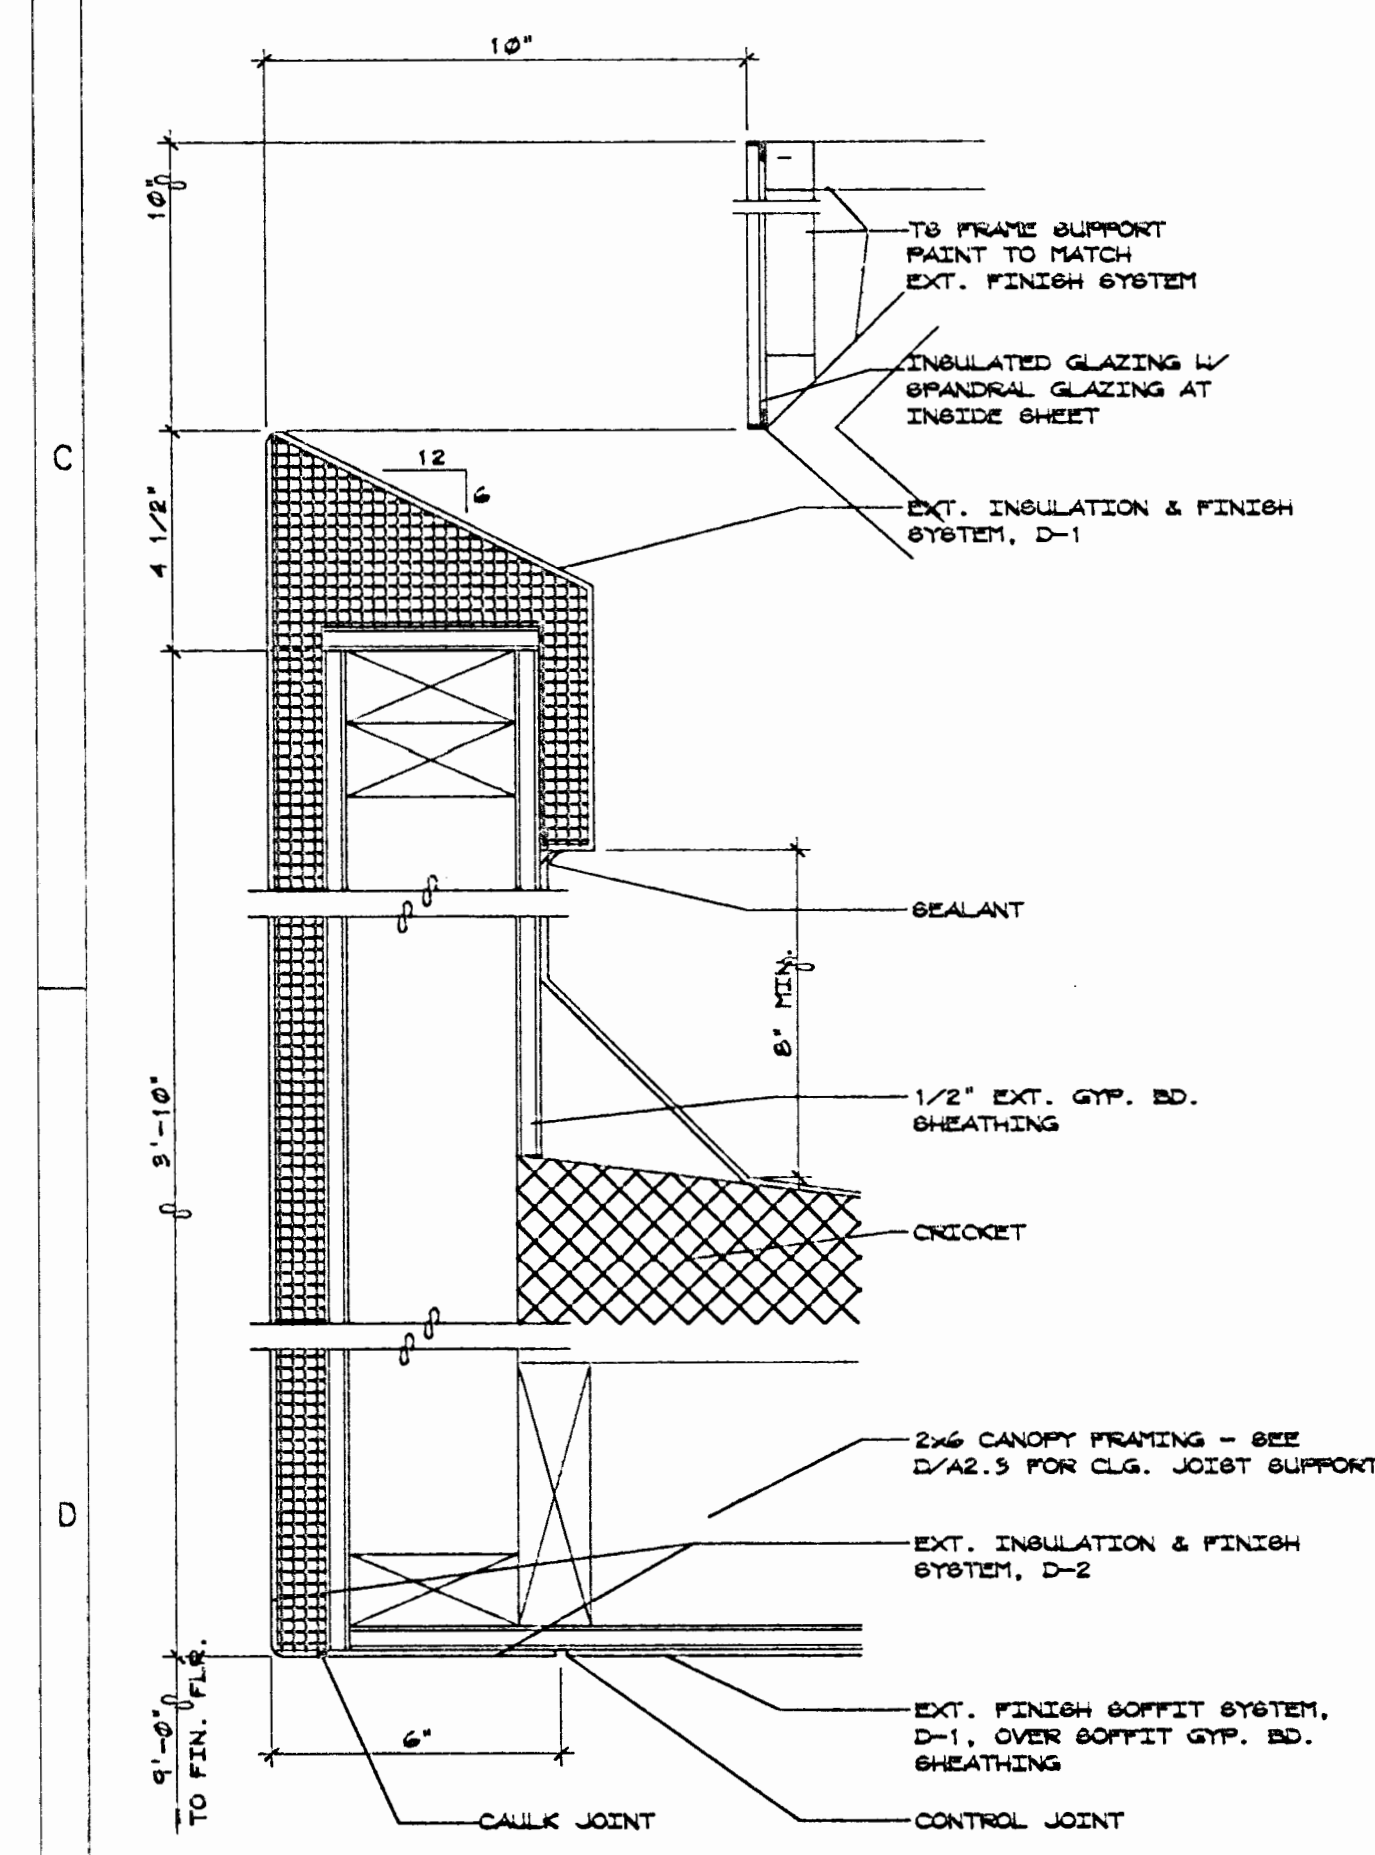


A ENTRY CANOPY FASCIA
SCALE: 3/4" = 1'-0"

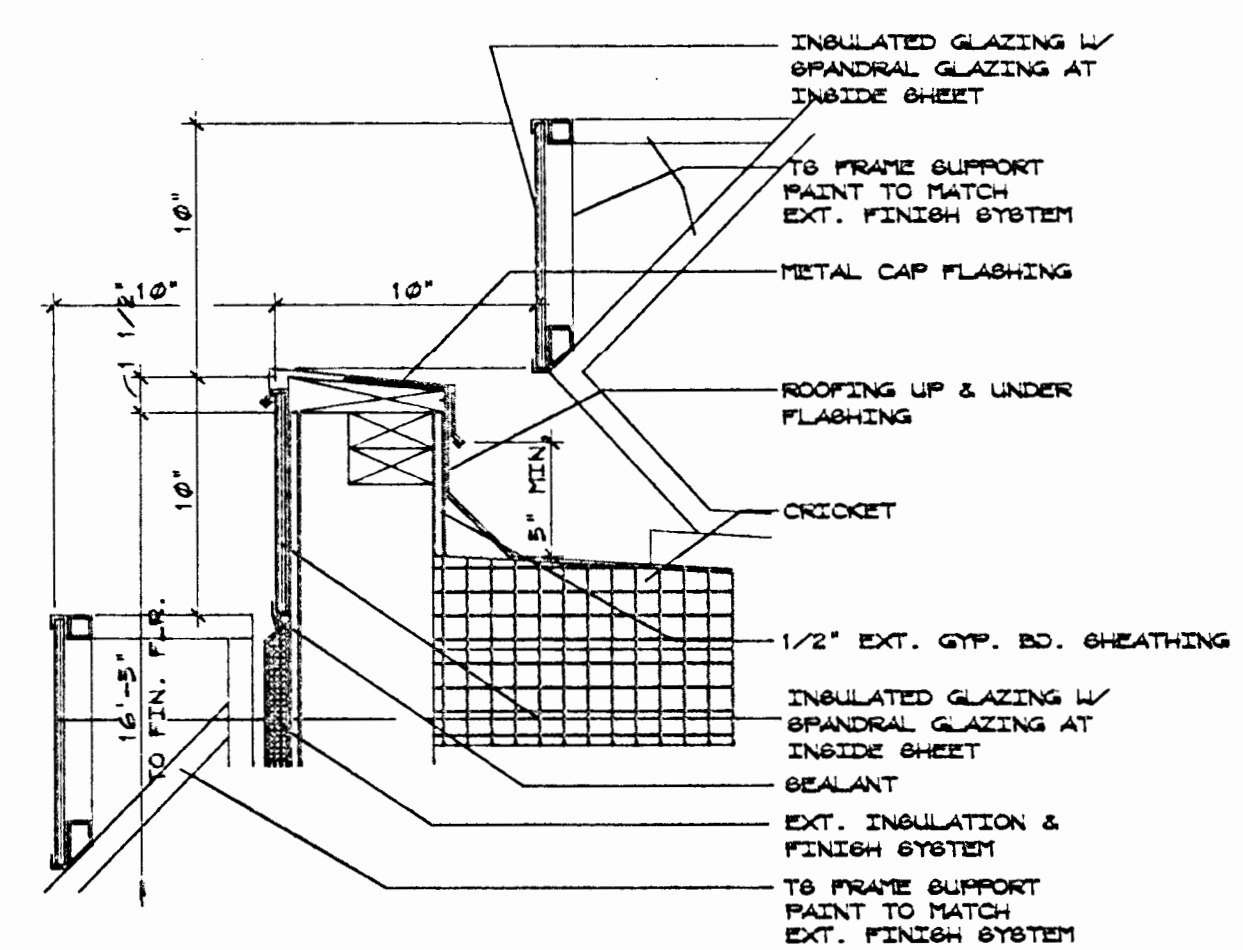


B PARAPET @ ENTRY
SCALE: 1 1/2" = 1'-0"

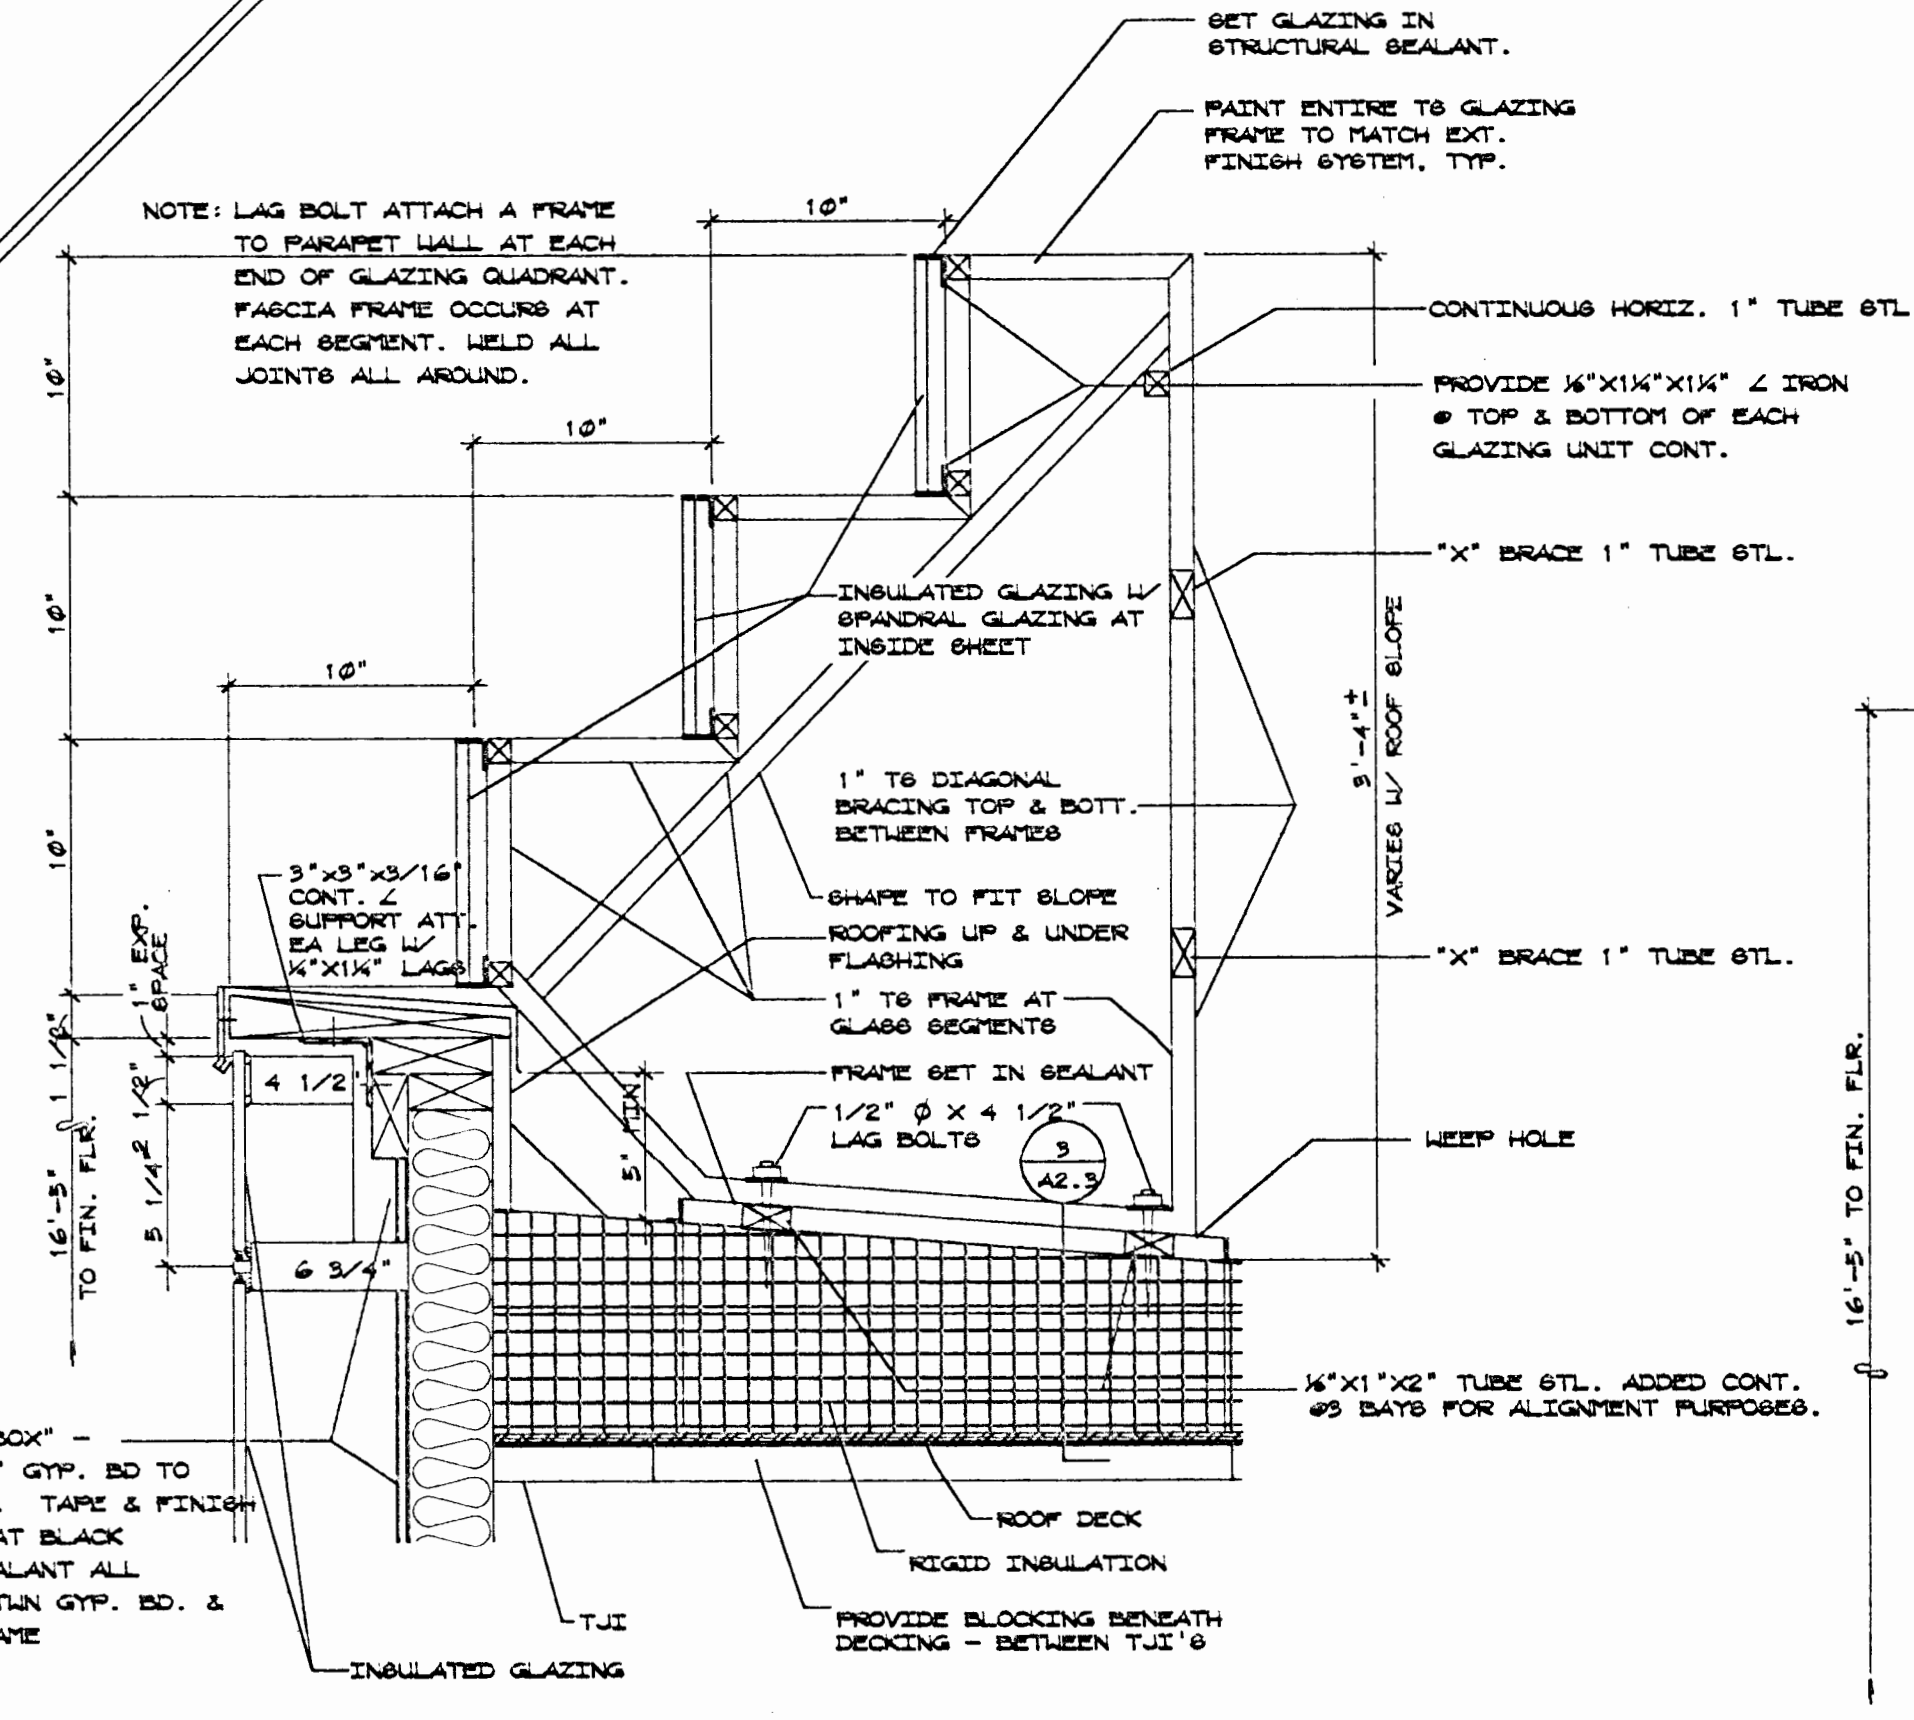


C PARAPET @ WINDOW WALL & GLASS FASCIA FRAME
SCALE: 1 1/2" = 1'-0"

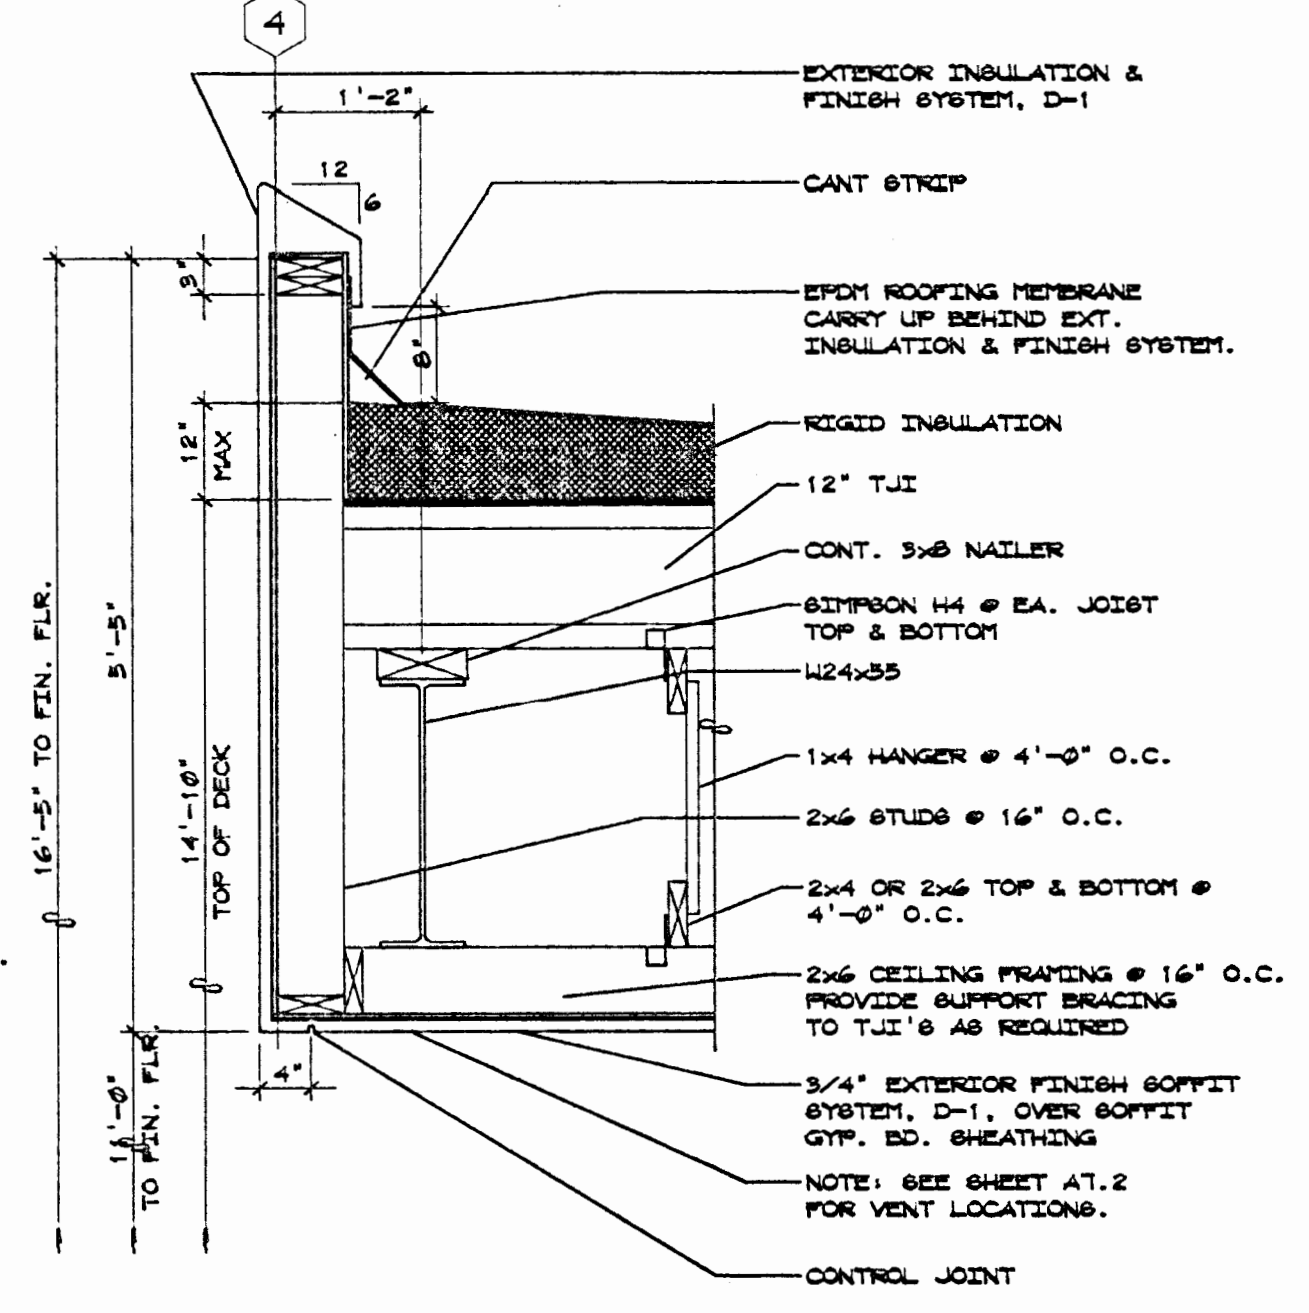


D DRIVE-UP CANOPY FASCIA
SCALE: 3/4" = 1'-0"

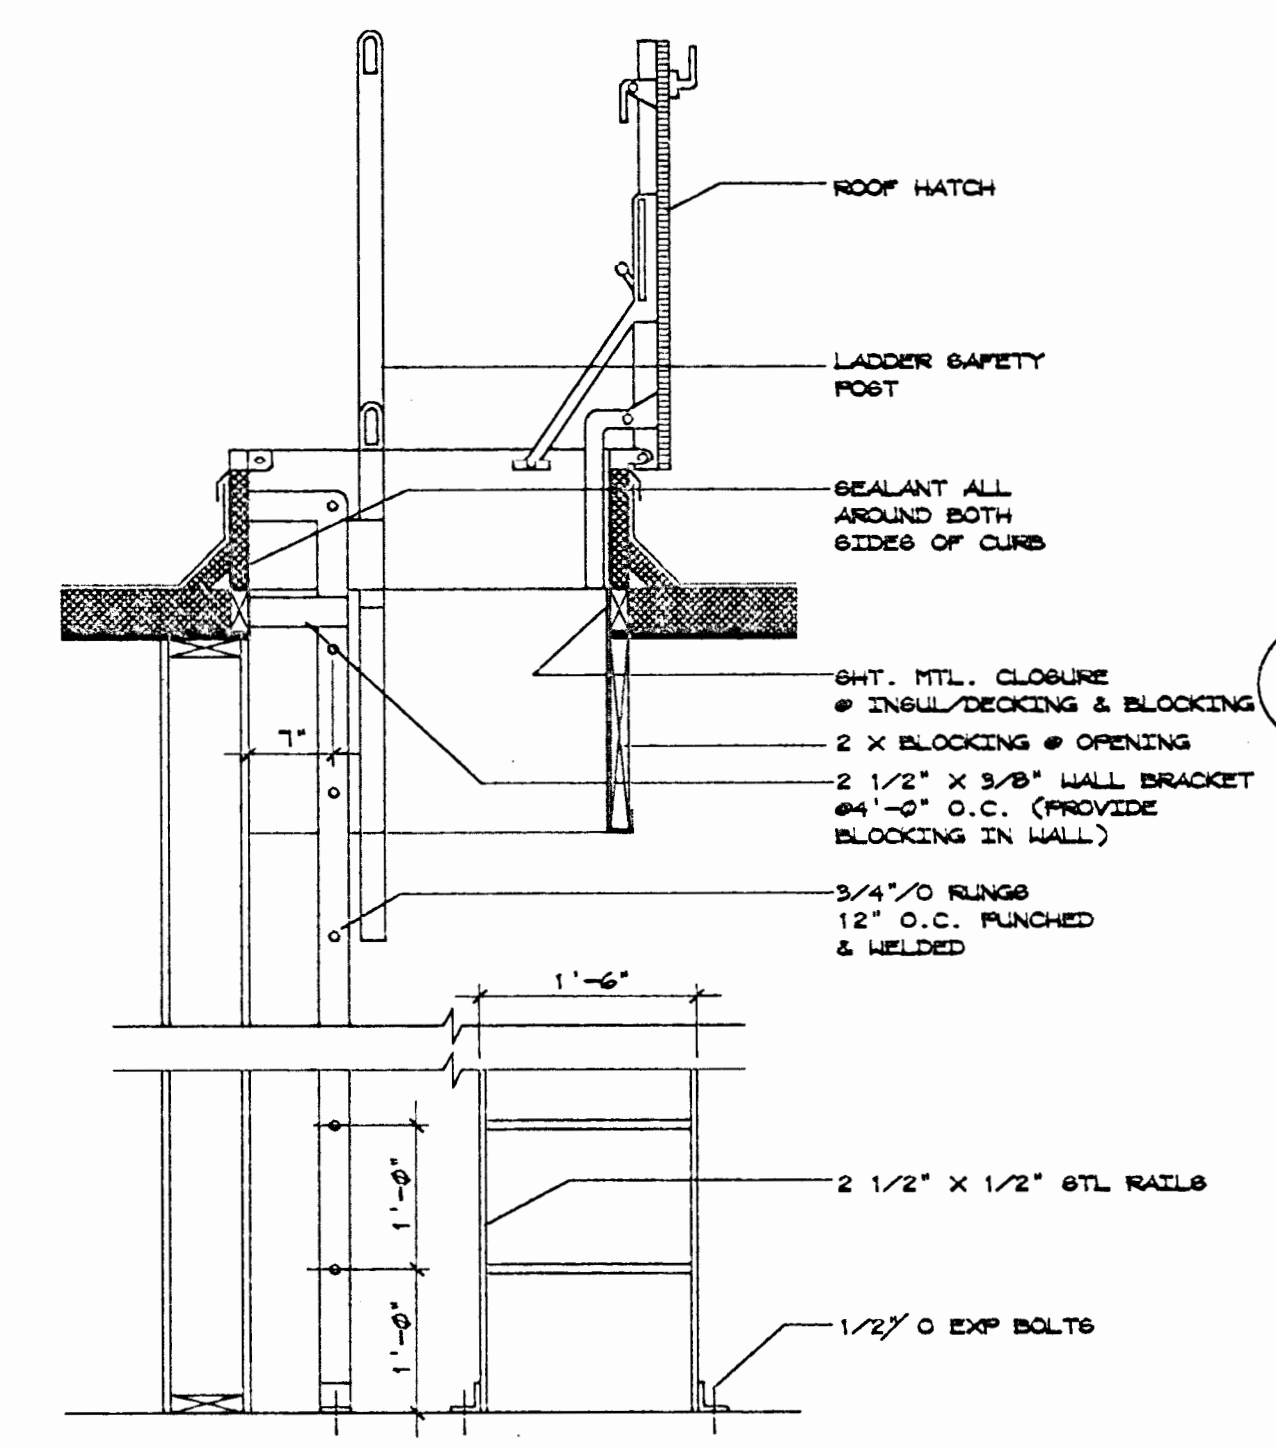

1 ROOF HATCH/LADDER
SCALE: 3/4" = 1'-0"

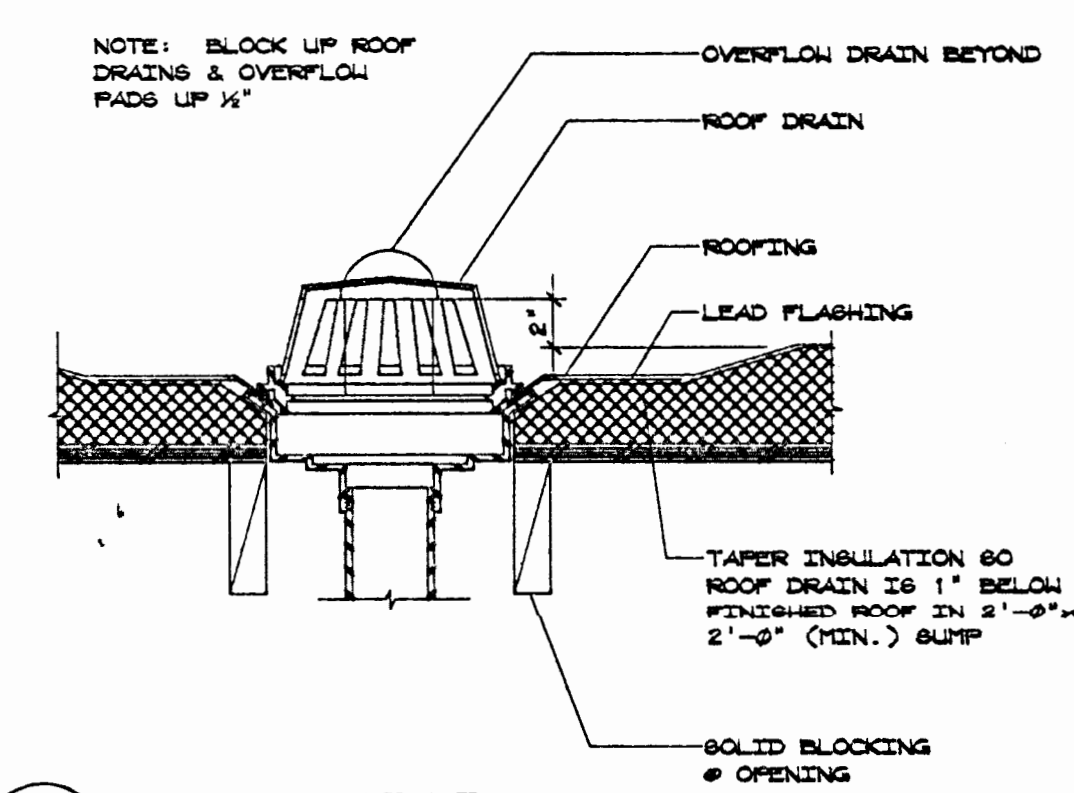

2 ROOF DRAIN
SCALE: 1 1/2" = 1'-0"

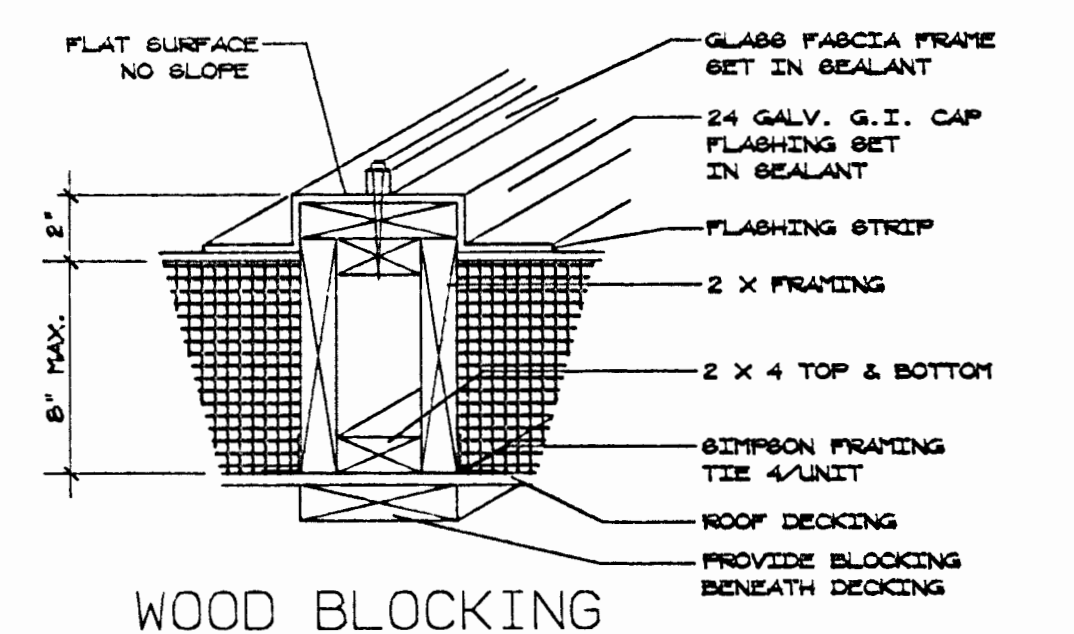

3 WOOD BLOCKING @ GLAZE FRAME
SCALE: 1 1/2" = 1'-0"

COPYRIGHT 1993
Lombard-Conrad ARCHITECTS
All rights reserved. Reproduction or
translation of any part of this work
without written permission of
Lombard-Conrad ARCHITECTS is unlawful
and subject to criminal prosecution.



Lombard-Conrad
ARCHITECTS
P. A. A. I. A.
1221 SHORELINE LANE BOISE, IDAHO 83762 TEL (208) 345-6677


BANK OF AMERICA
FAIRVIEW AND MITCHELL
BOISE IDAHO

ROOF PLAN, DETAILS


JOB NO. 93031.01	
DATE 9-13-93	CHECKED BY SDH
DESIGNED BY SDH	DATE
REVISIONS	
SHEET NO.	

A2.3


OF SHEETS

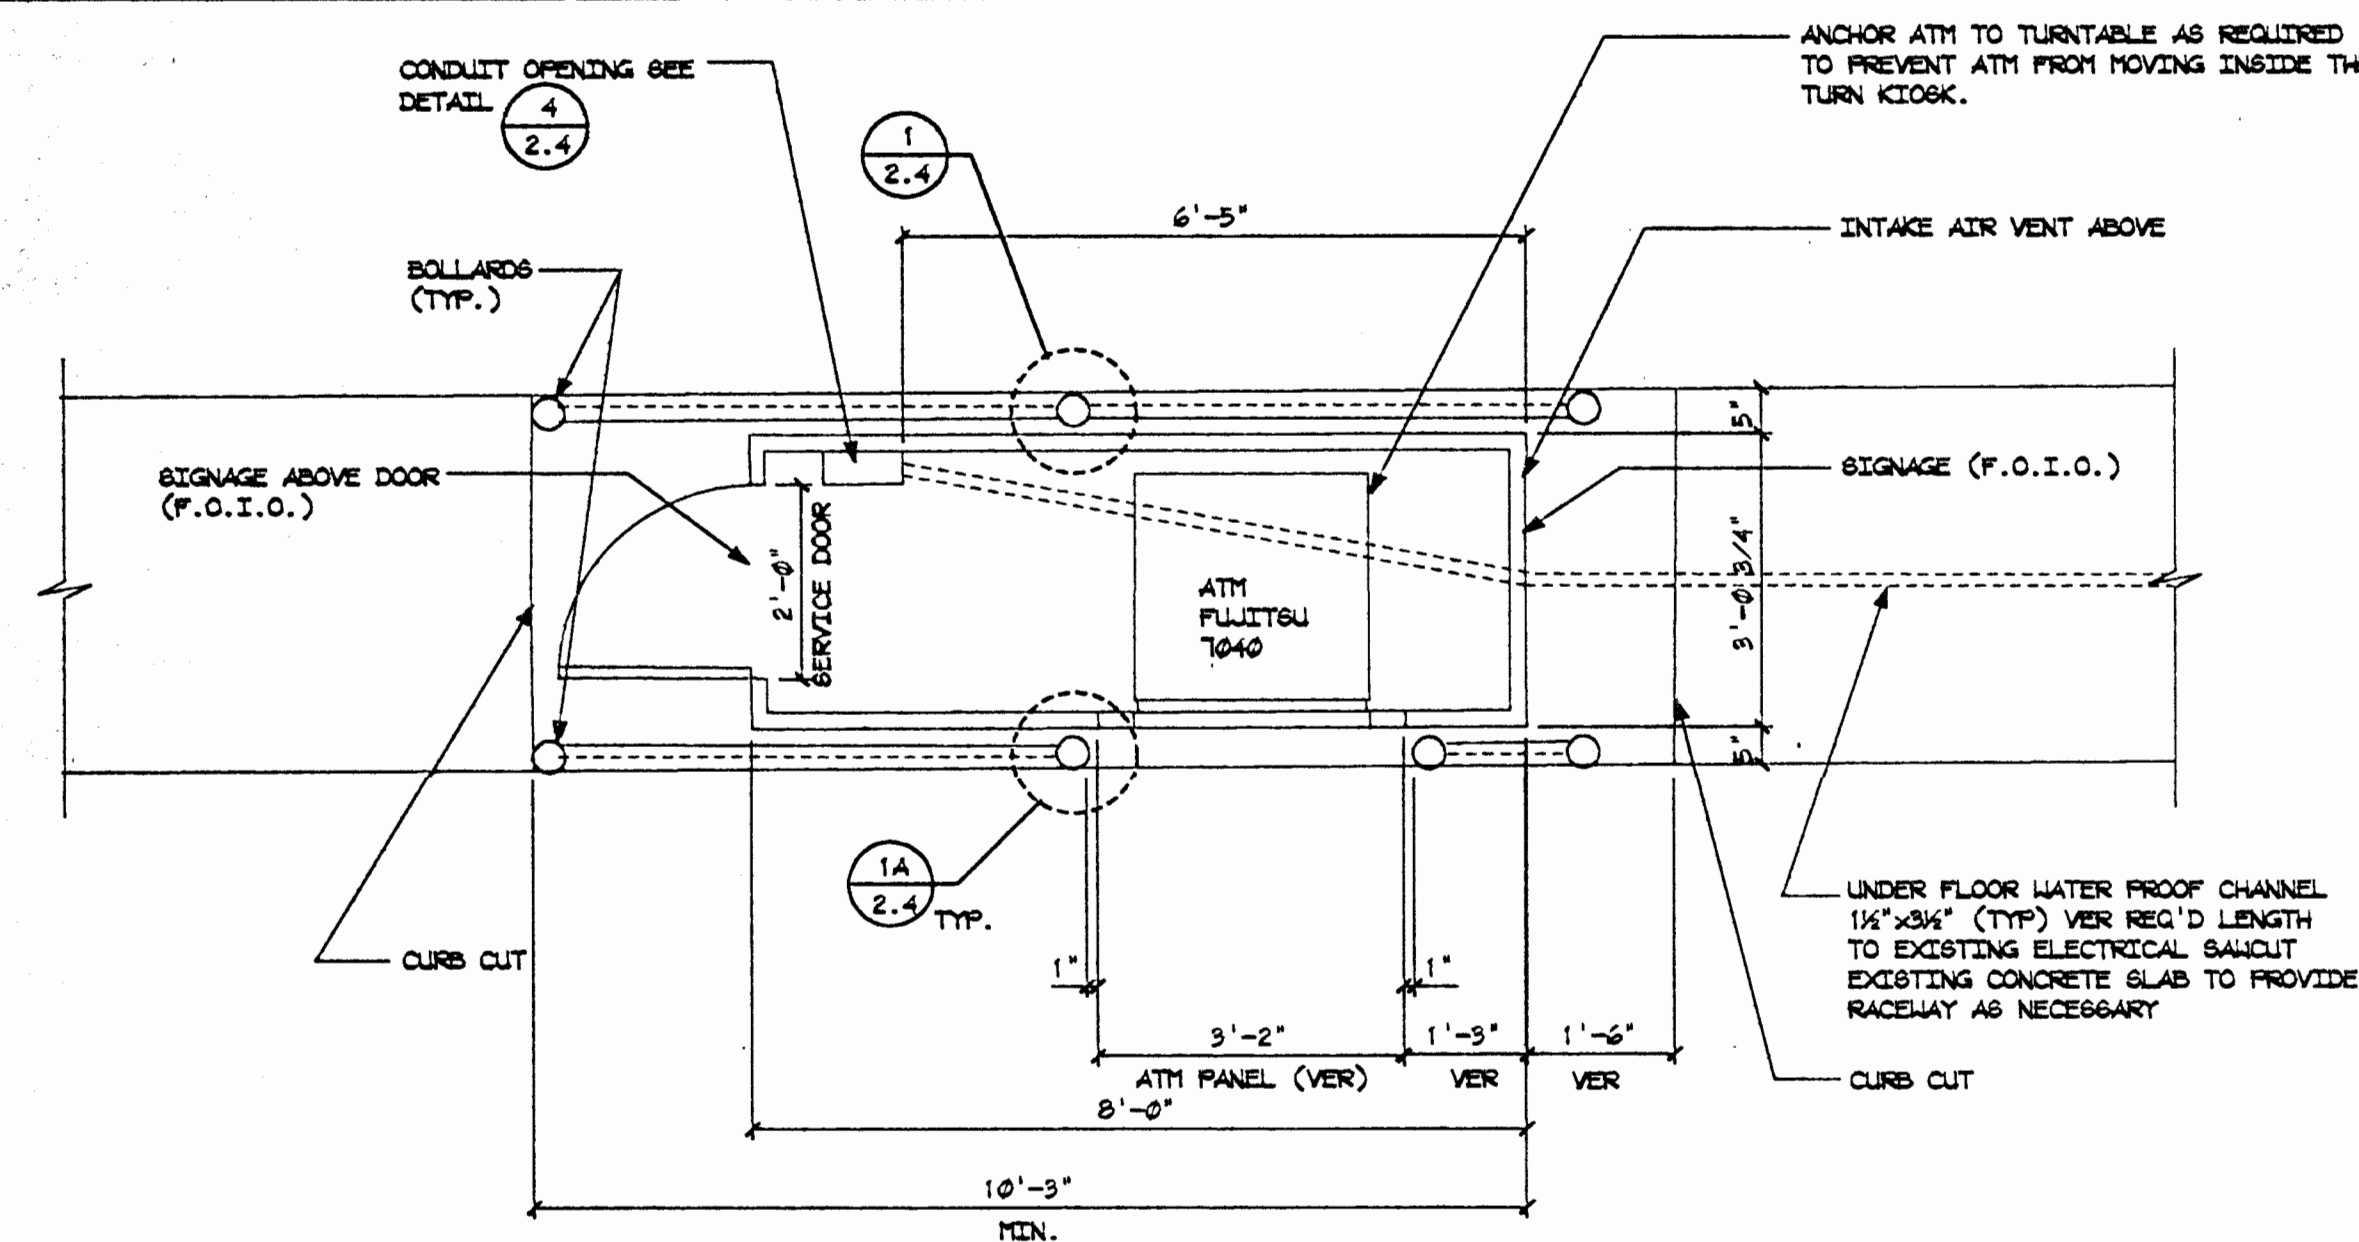


2 PLAN
SCALE: 1/2" = 1'-0"

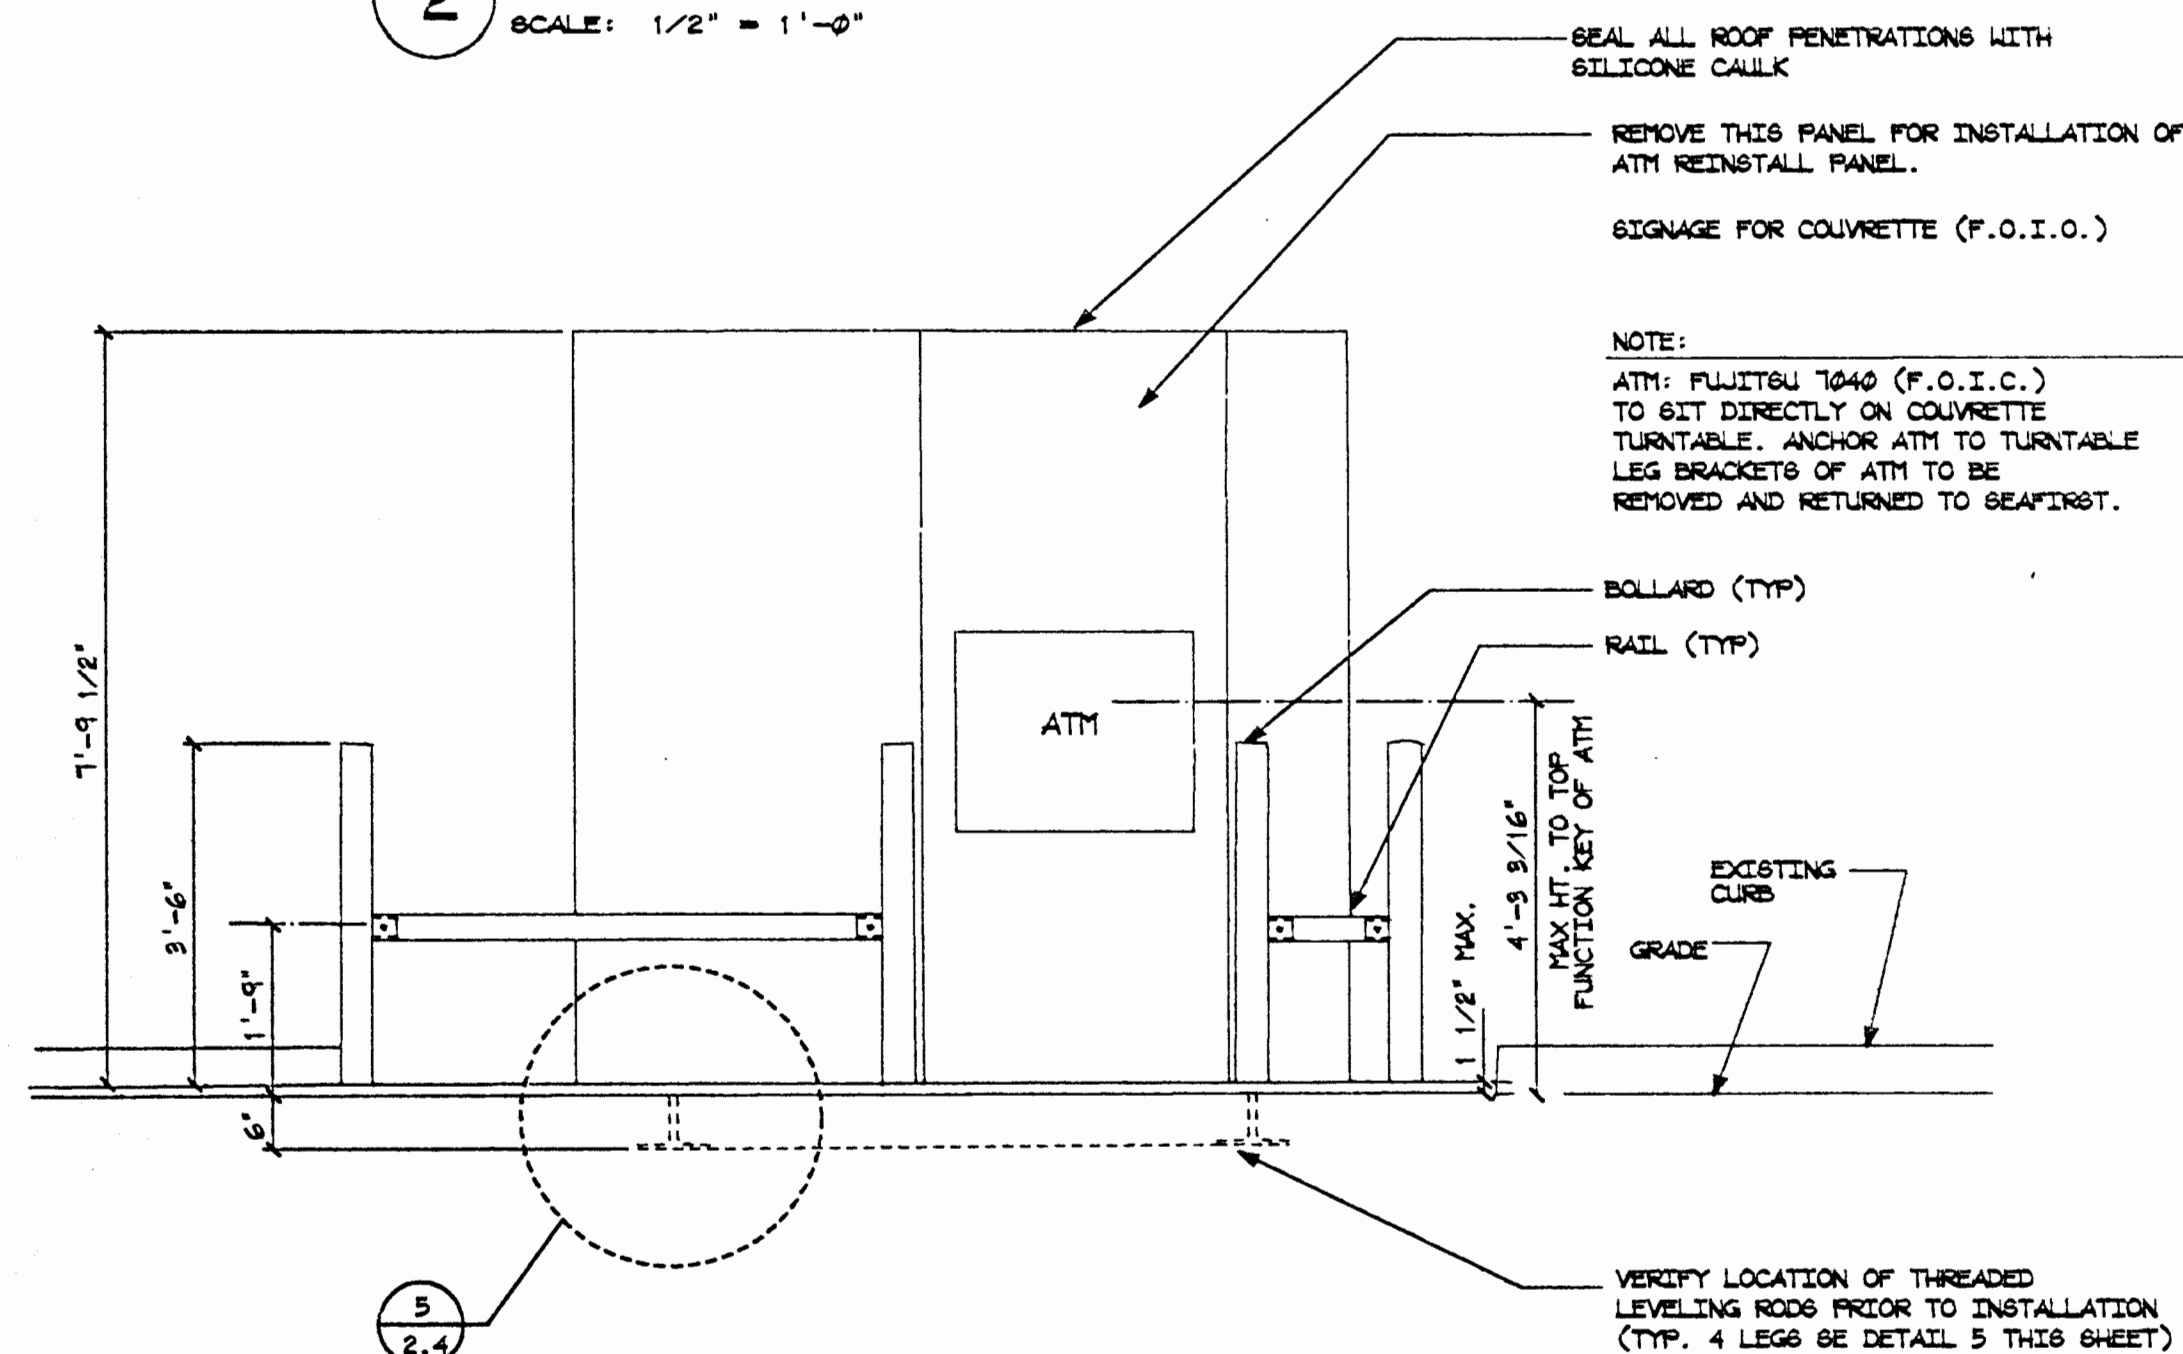


A FRONT ELEVATION
SCALE: 1/2" = 1'-0"

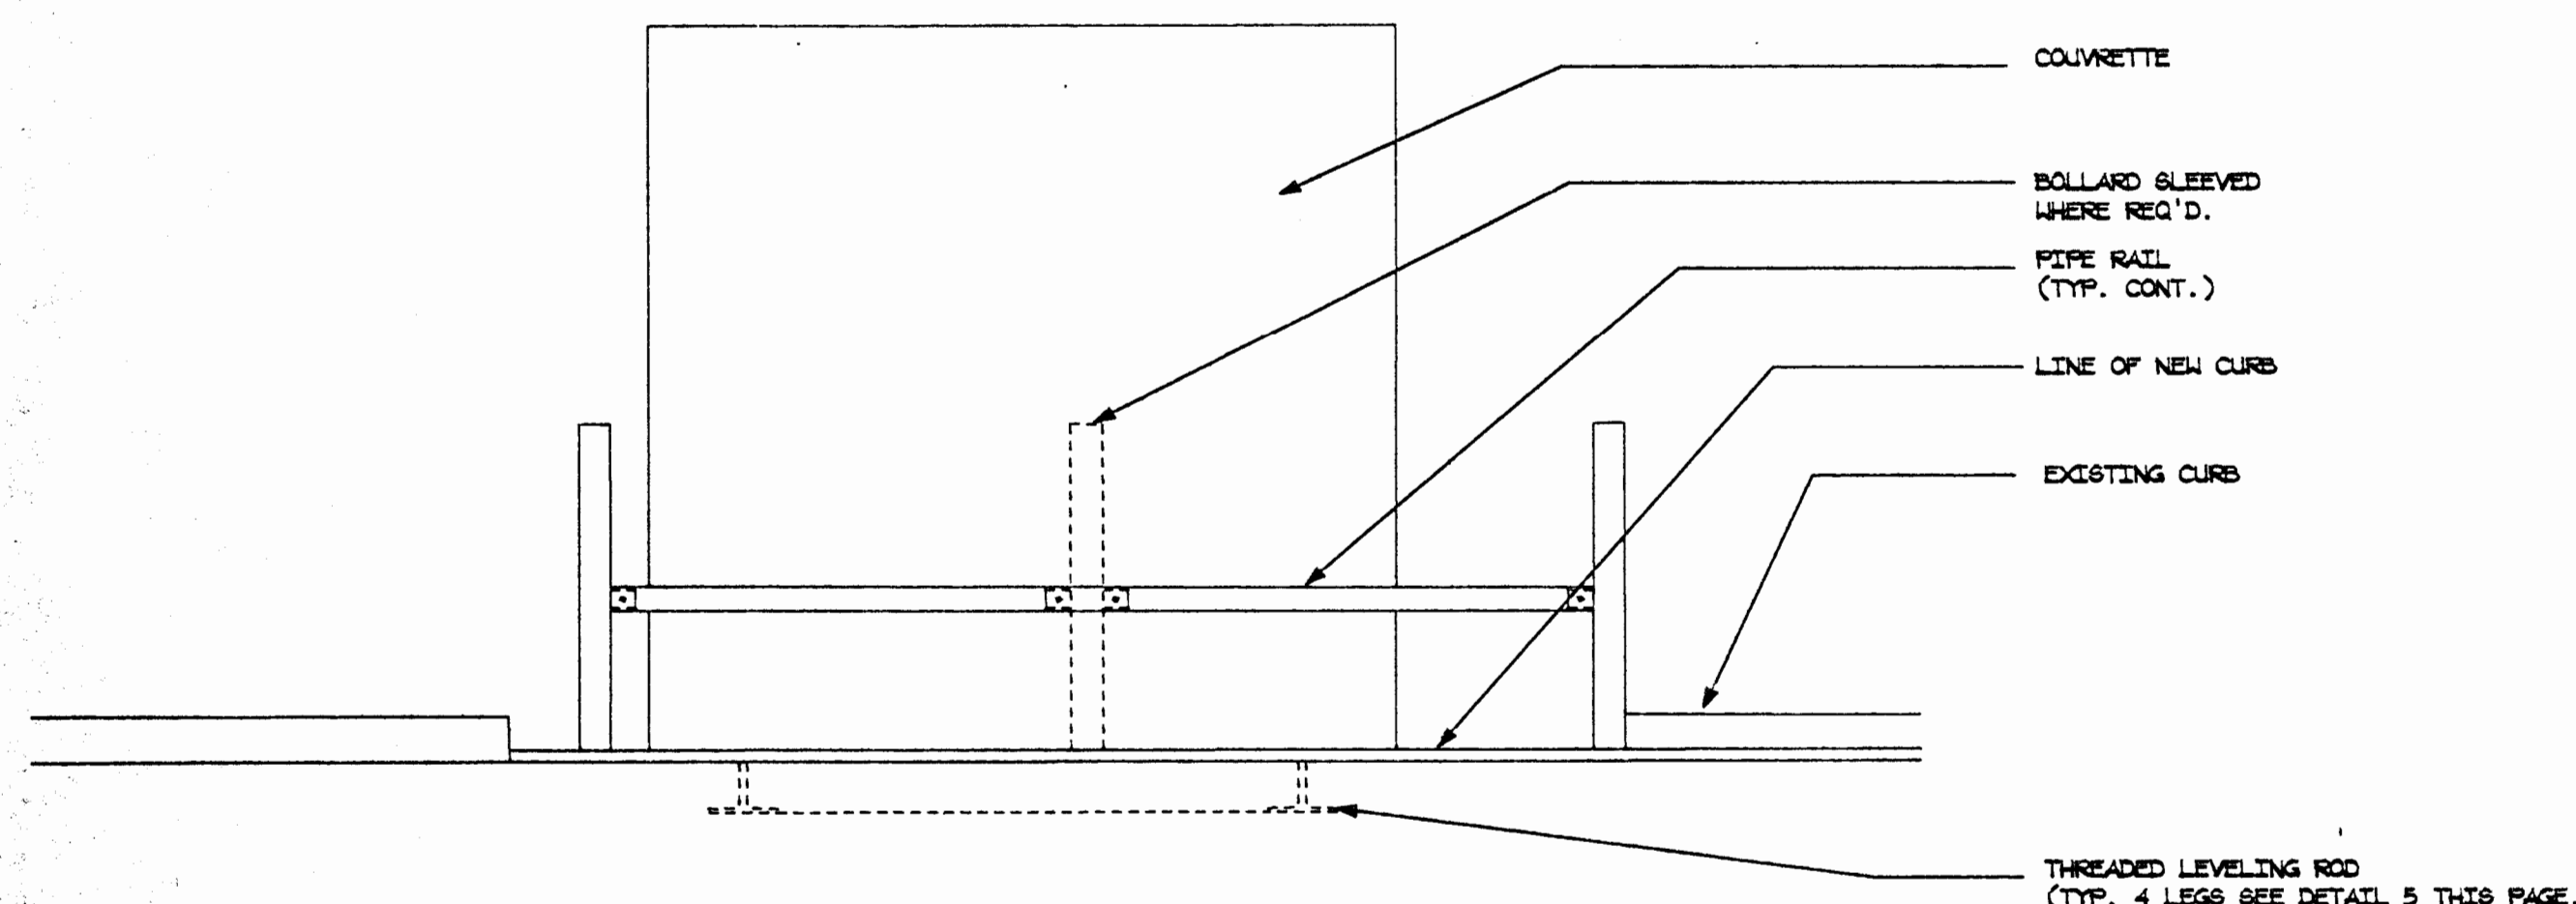


B REAR ELEVATION
SCALE: 1/2" = 1'-0"

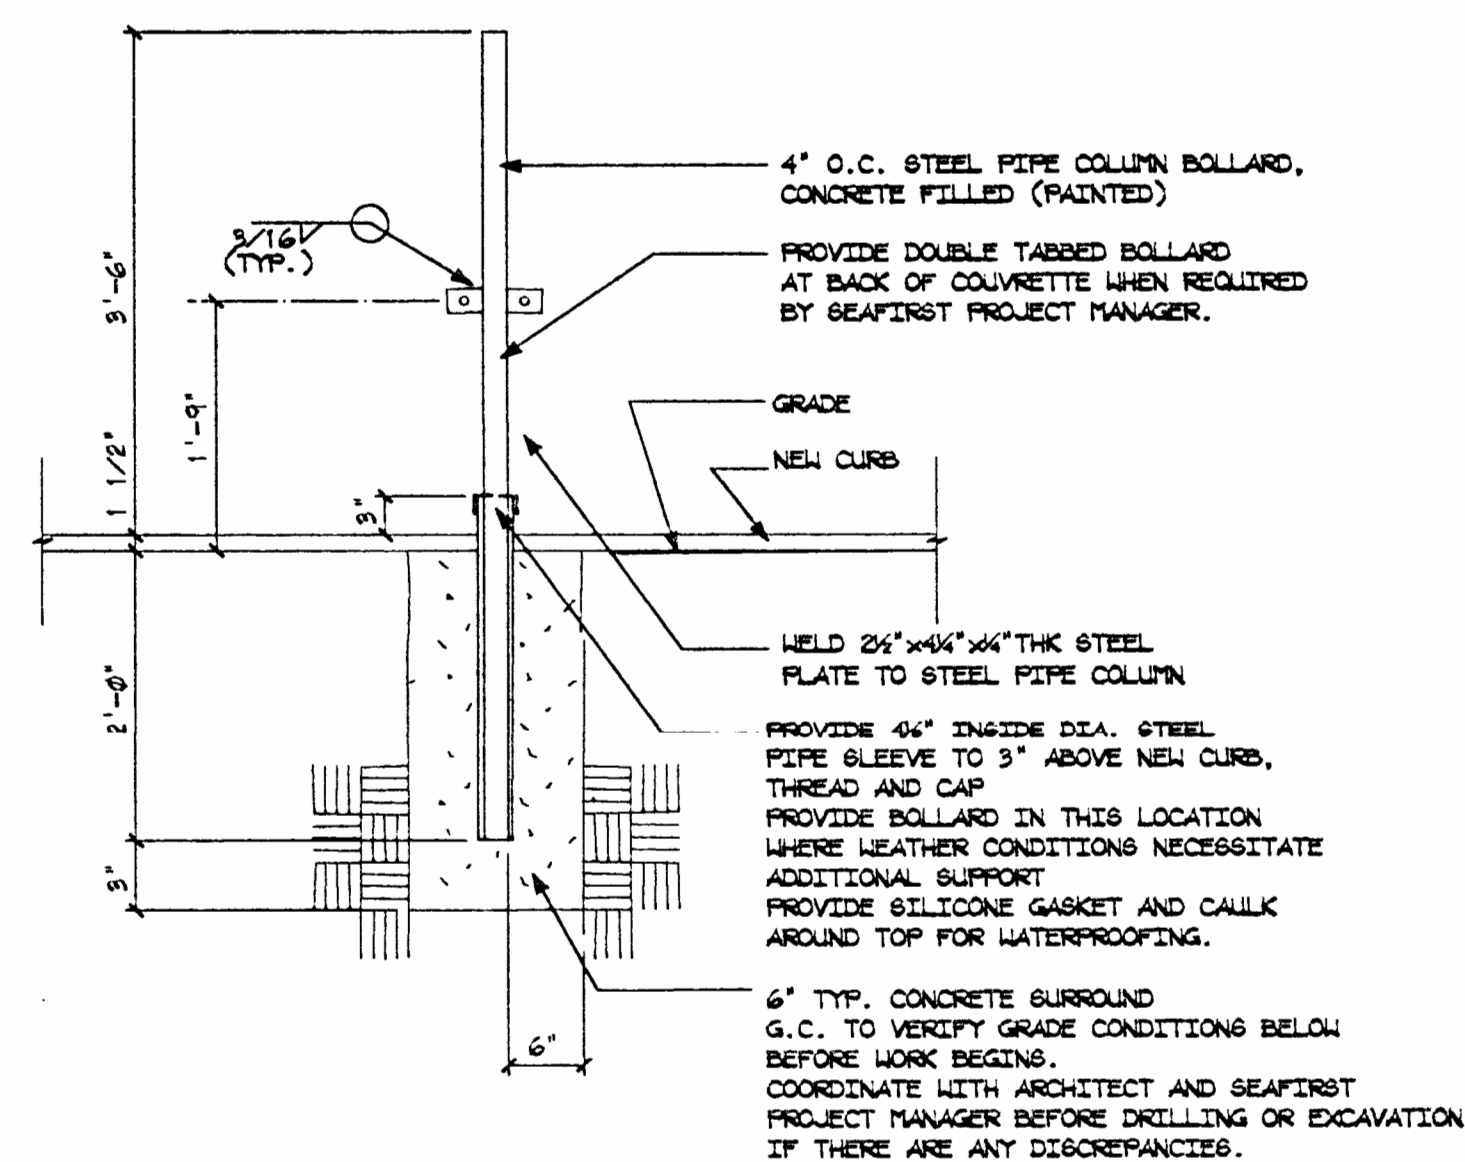


1A 1 BOLLARD SECTION
SCALE: 3/4" = 1'-0"

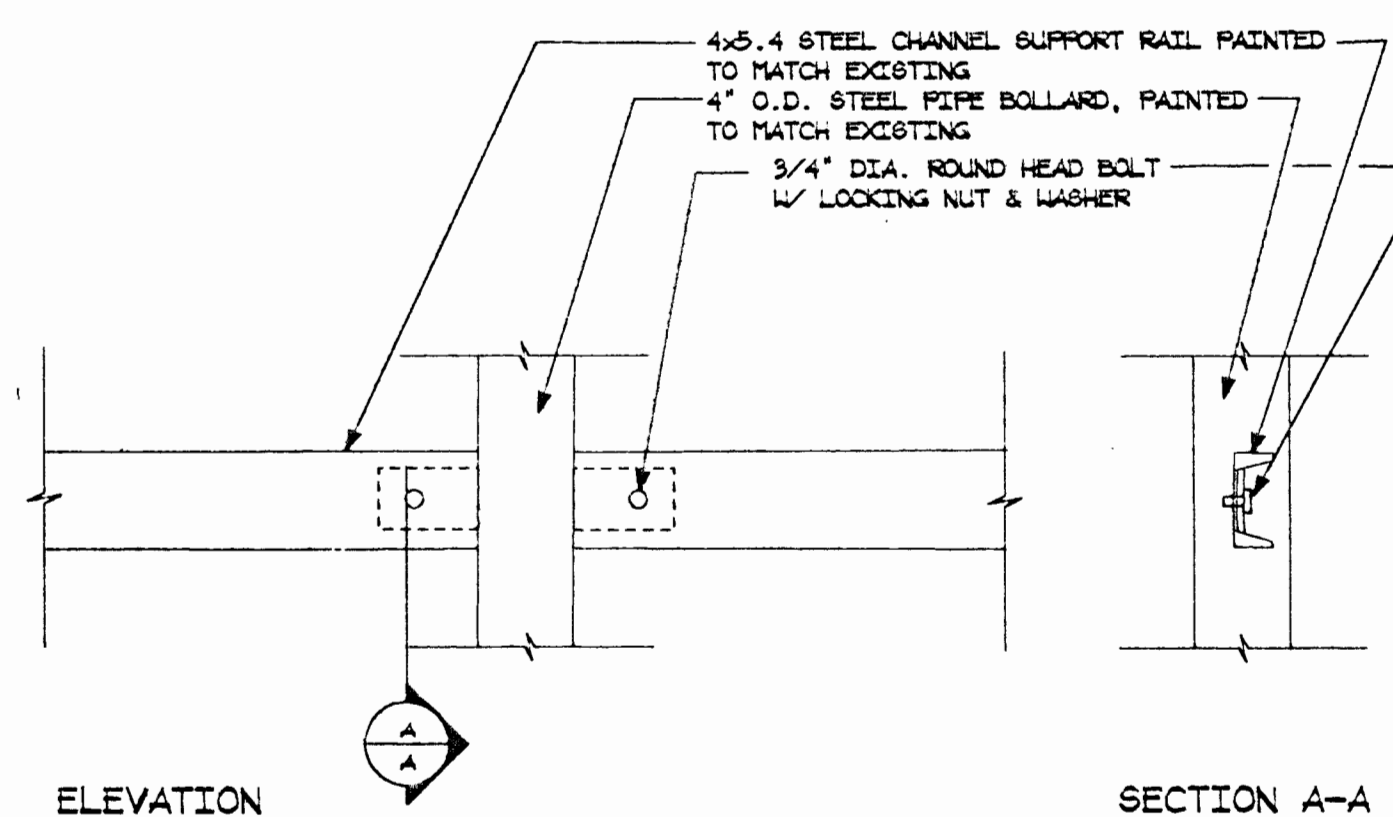


2 RAIL DETAIL
SCALE: 1 1/2" = 1'-0"

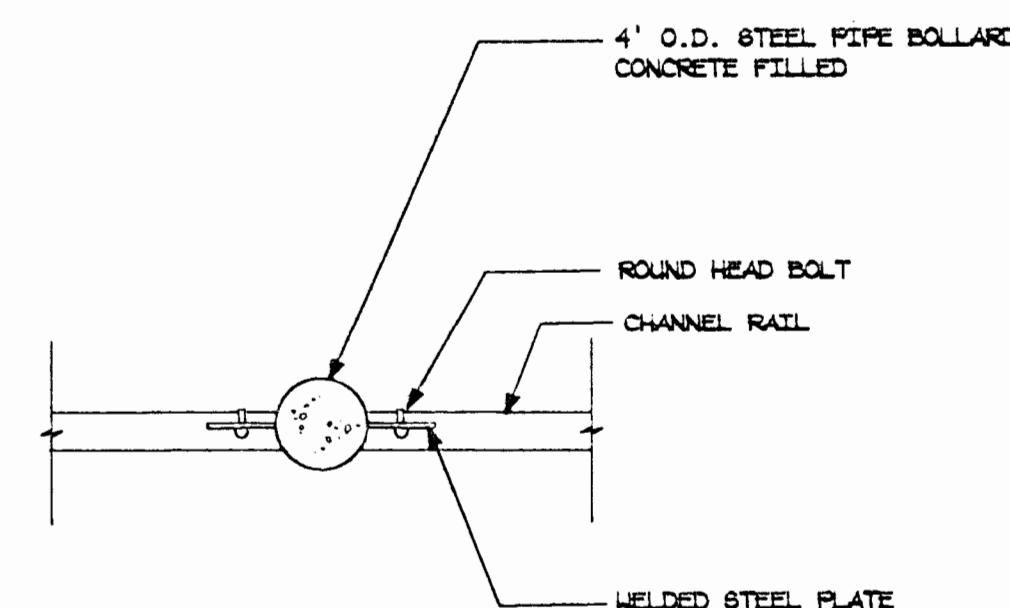

3 BOLLARD PLAN @ RAIL
SCALE: 1 1/2" = 1'-0"

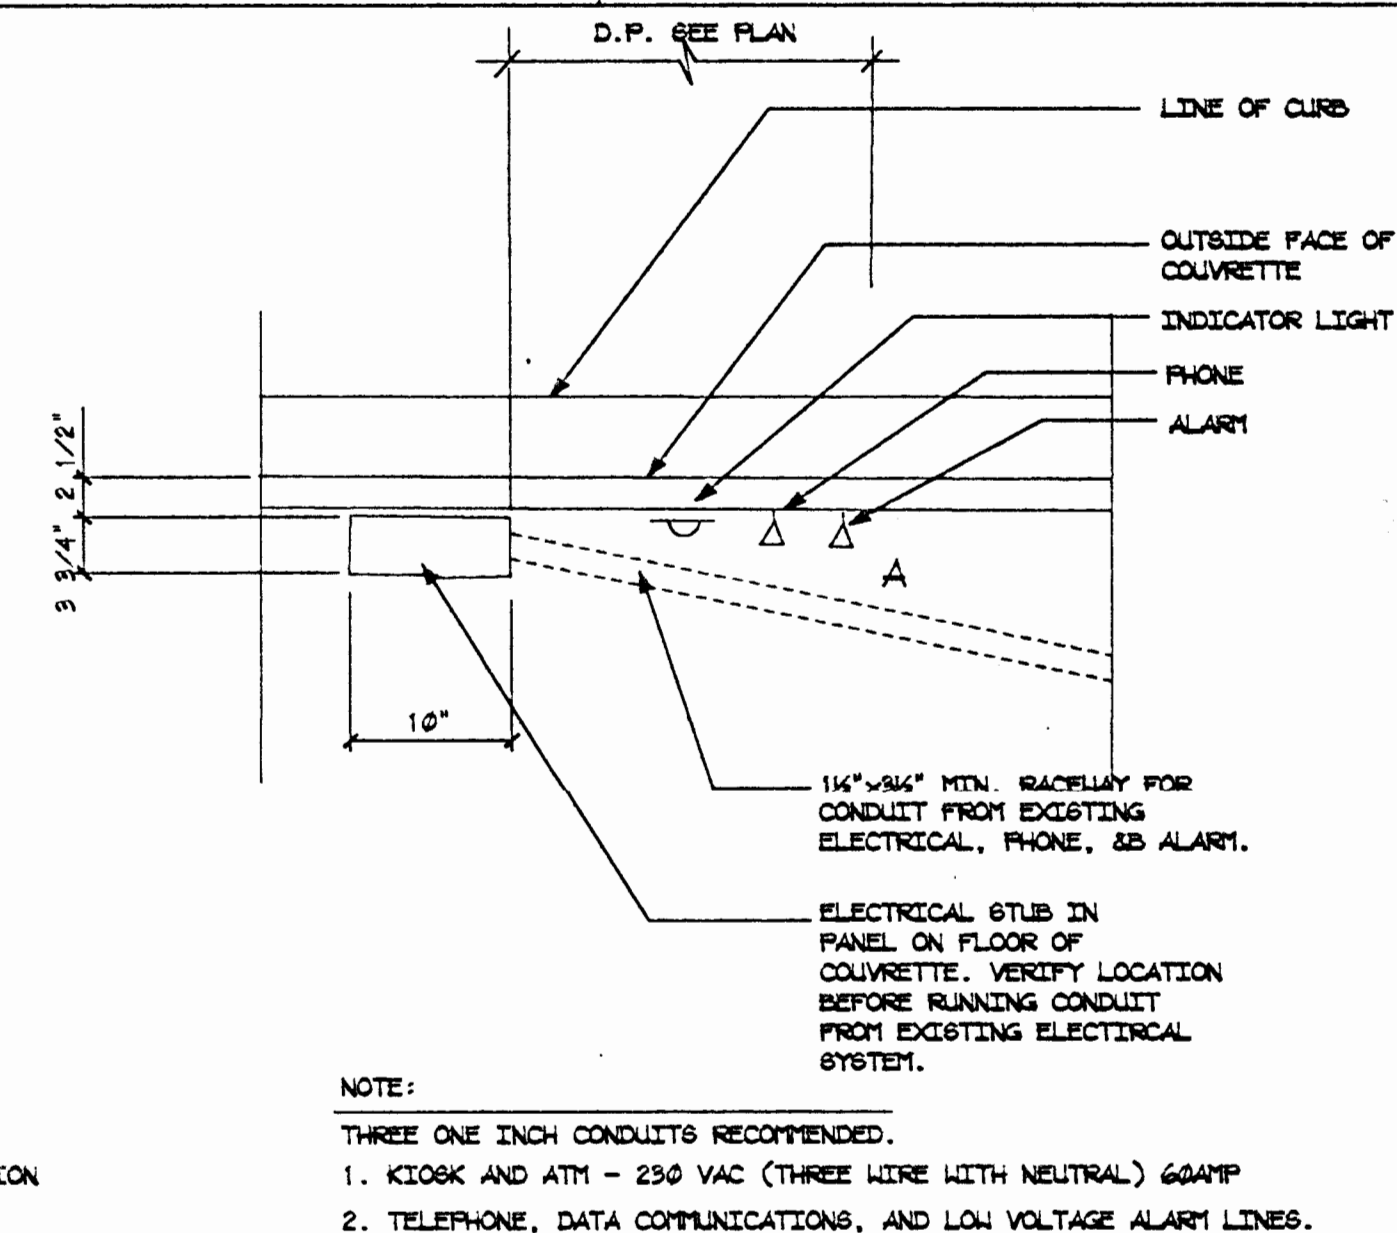

4 ELECTRICAL STUB-IN DETAIL
SCALE: 1 1/2" = 1'-0"

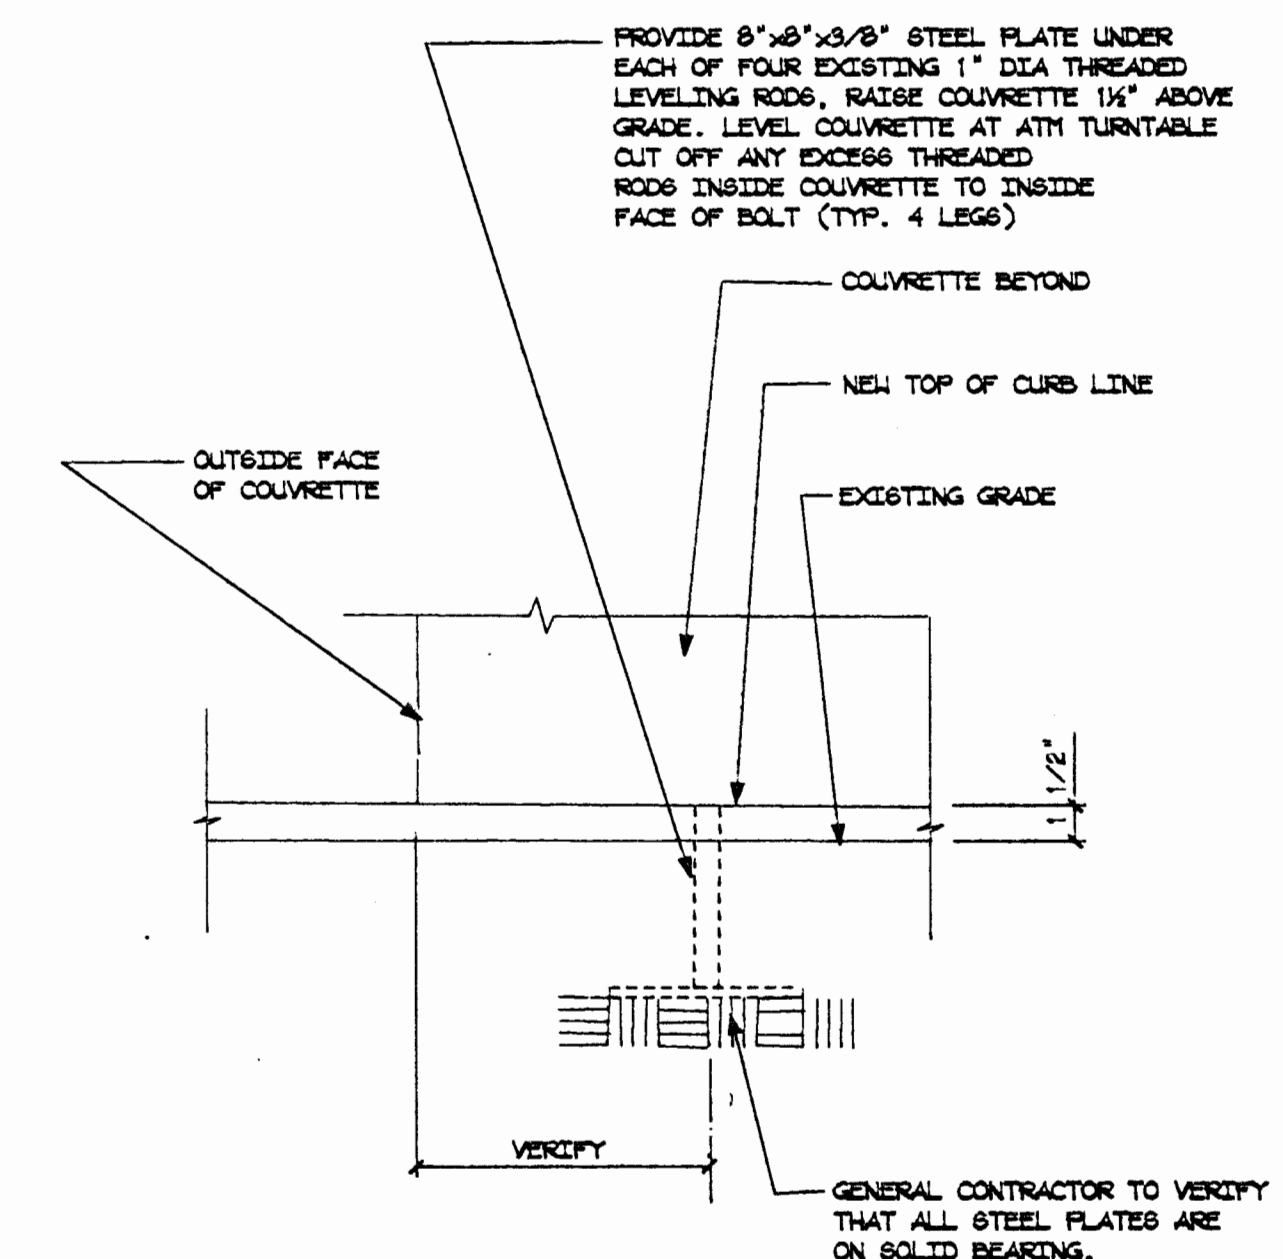

5 STEEL PLATE DETAIL
SCALE: 1 1/2" = 1'-0"


CONSTRUCTION NOTES

1. GASKET AND REMOVE EXISTING ISLAND PER DIMENSIONED PLAN TO EXISTING GRADE. VERIFY ON SITE AND CONTACT ARCHITECT AND SEAFIRST PROJECT MANAGER IF THERE ARE ANY DISCREPANCIES.
2. REMOVE EXISTING BOLLARDS, REMOTE TELLERS, ETC. PATCH/REPAIR ANY OPENINGS. STUB ELECTRICAL.
3. LOCATE AND PREPARE FOOT PADS FOR LEVELING RODS.
4. LOCATE AND PREPARE FIXED AND SLEEVED BOLLARDS.
5. CHECK DRIVE-UP PAD ON ATM SIDE OF COUVRETTE FOR LEVEL. FINAL INSTALLED HEIGHT OF ATM TOP FUNCTION KEY 51-53 1/2" MAX. ABOVE FINISHED GRADE AT DRIVE-UP LANE. GRADE TO SLOPE AWAY FROM DRIVE-UP PAD AND REAR OF COUVRETTE.
6. INSTALL CONDUIT AND WIRING FOR ELECTRICAL, PHONE, DATA, AND ALARM CONNECTIONS AS SHOWN.
7. PREPARE COUVRETTE FOR PLACEMENT BY FORKLIFT AND SET IN PLACE. SOME ASSEMBLY AND ADJUSTMENT WILL BE REQUIRED FOR UNIT, H.V.A.C., AND ATM. ORIENT AND LEVEL COUVRETTE.
8. GENERAL CONTRACTOR TO INSTALL H.V.A.C. UNIT AND PROVIDE ELECTRICAL.
9. FORM AND PLACE CONCRETE.
10. THIS IS INTENDED TO BE USED AS A GUIDE FOR THE ASSEMBLY AND PLACEMENT OF COUVRETTE UNIT. BUT IT IS THE RESPONSIBILITY OF THE GENERAL CONTRACTOR TO THOROUGHLY REVIEW THE PROCEDURE PRIOR TO INSTALLATION W/ SEAFIRST PROJECT MANAGER.

GENERAL NOTES

1. CONTRACTOR TO PAINT ALL BOLLARDS AND RAILINGS TO MATCH COUVRETTE.
2. CURB AND LANE STRIPING OR PAINTED LANE INDICATORS TO MATCH EXISTING CONDITIONS- U.O.N.
3. CONCRETE FINISH TO MATCH EXISTING CONDITIONS- U.O.N.

COPYRIGHT 1993
Lombard-Conrad Architects
All rights reserved. Reproduction or translation of any part of this work without written permission of Lombard-Conrad Architects is unlawful and subject to criminal prosecution.

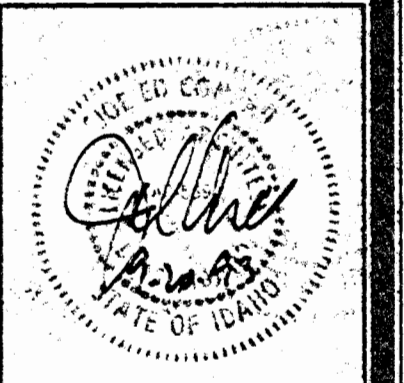


Lombard-Conrad
ARCHITECTS
P. A., A. I. A.
1221 SHORELINE LANE BOISE, IDAHO 83782 TEL. (208) 345-6677


BANK OF AMERICA
FAIRVIEW AND MITCHELL
BOISE IDAHO
ATM PLAN, ELEVS, & DETAILS

JOB NO. 93031.01
DATE 9-9-93
DRAWN BY GLL CHECKED BY NLT
REVISIONS DATE


SHEET NO.
A2-4
OF SHEETS

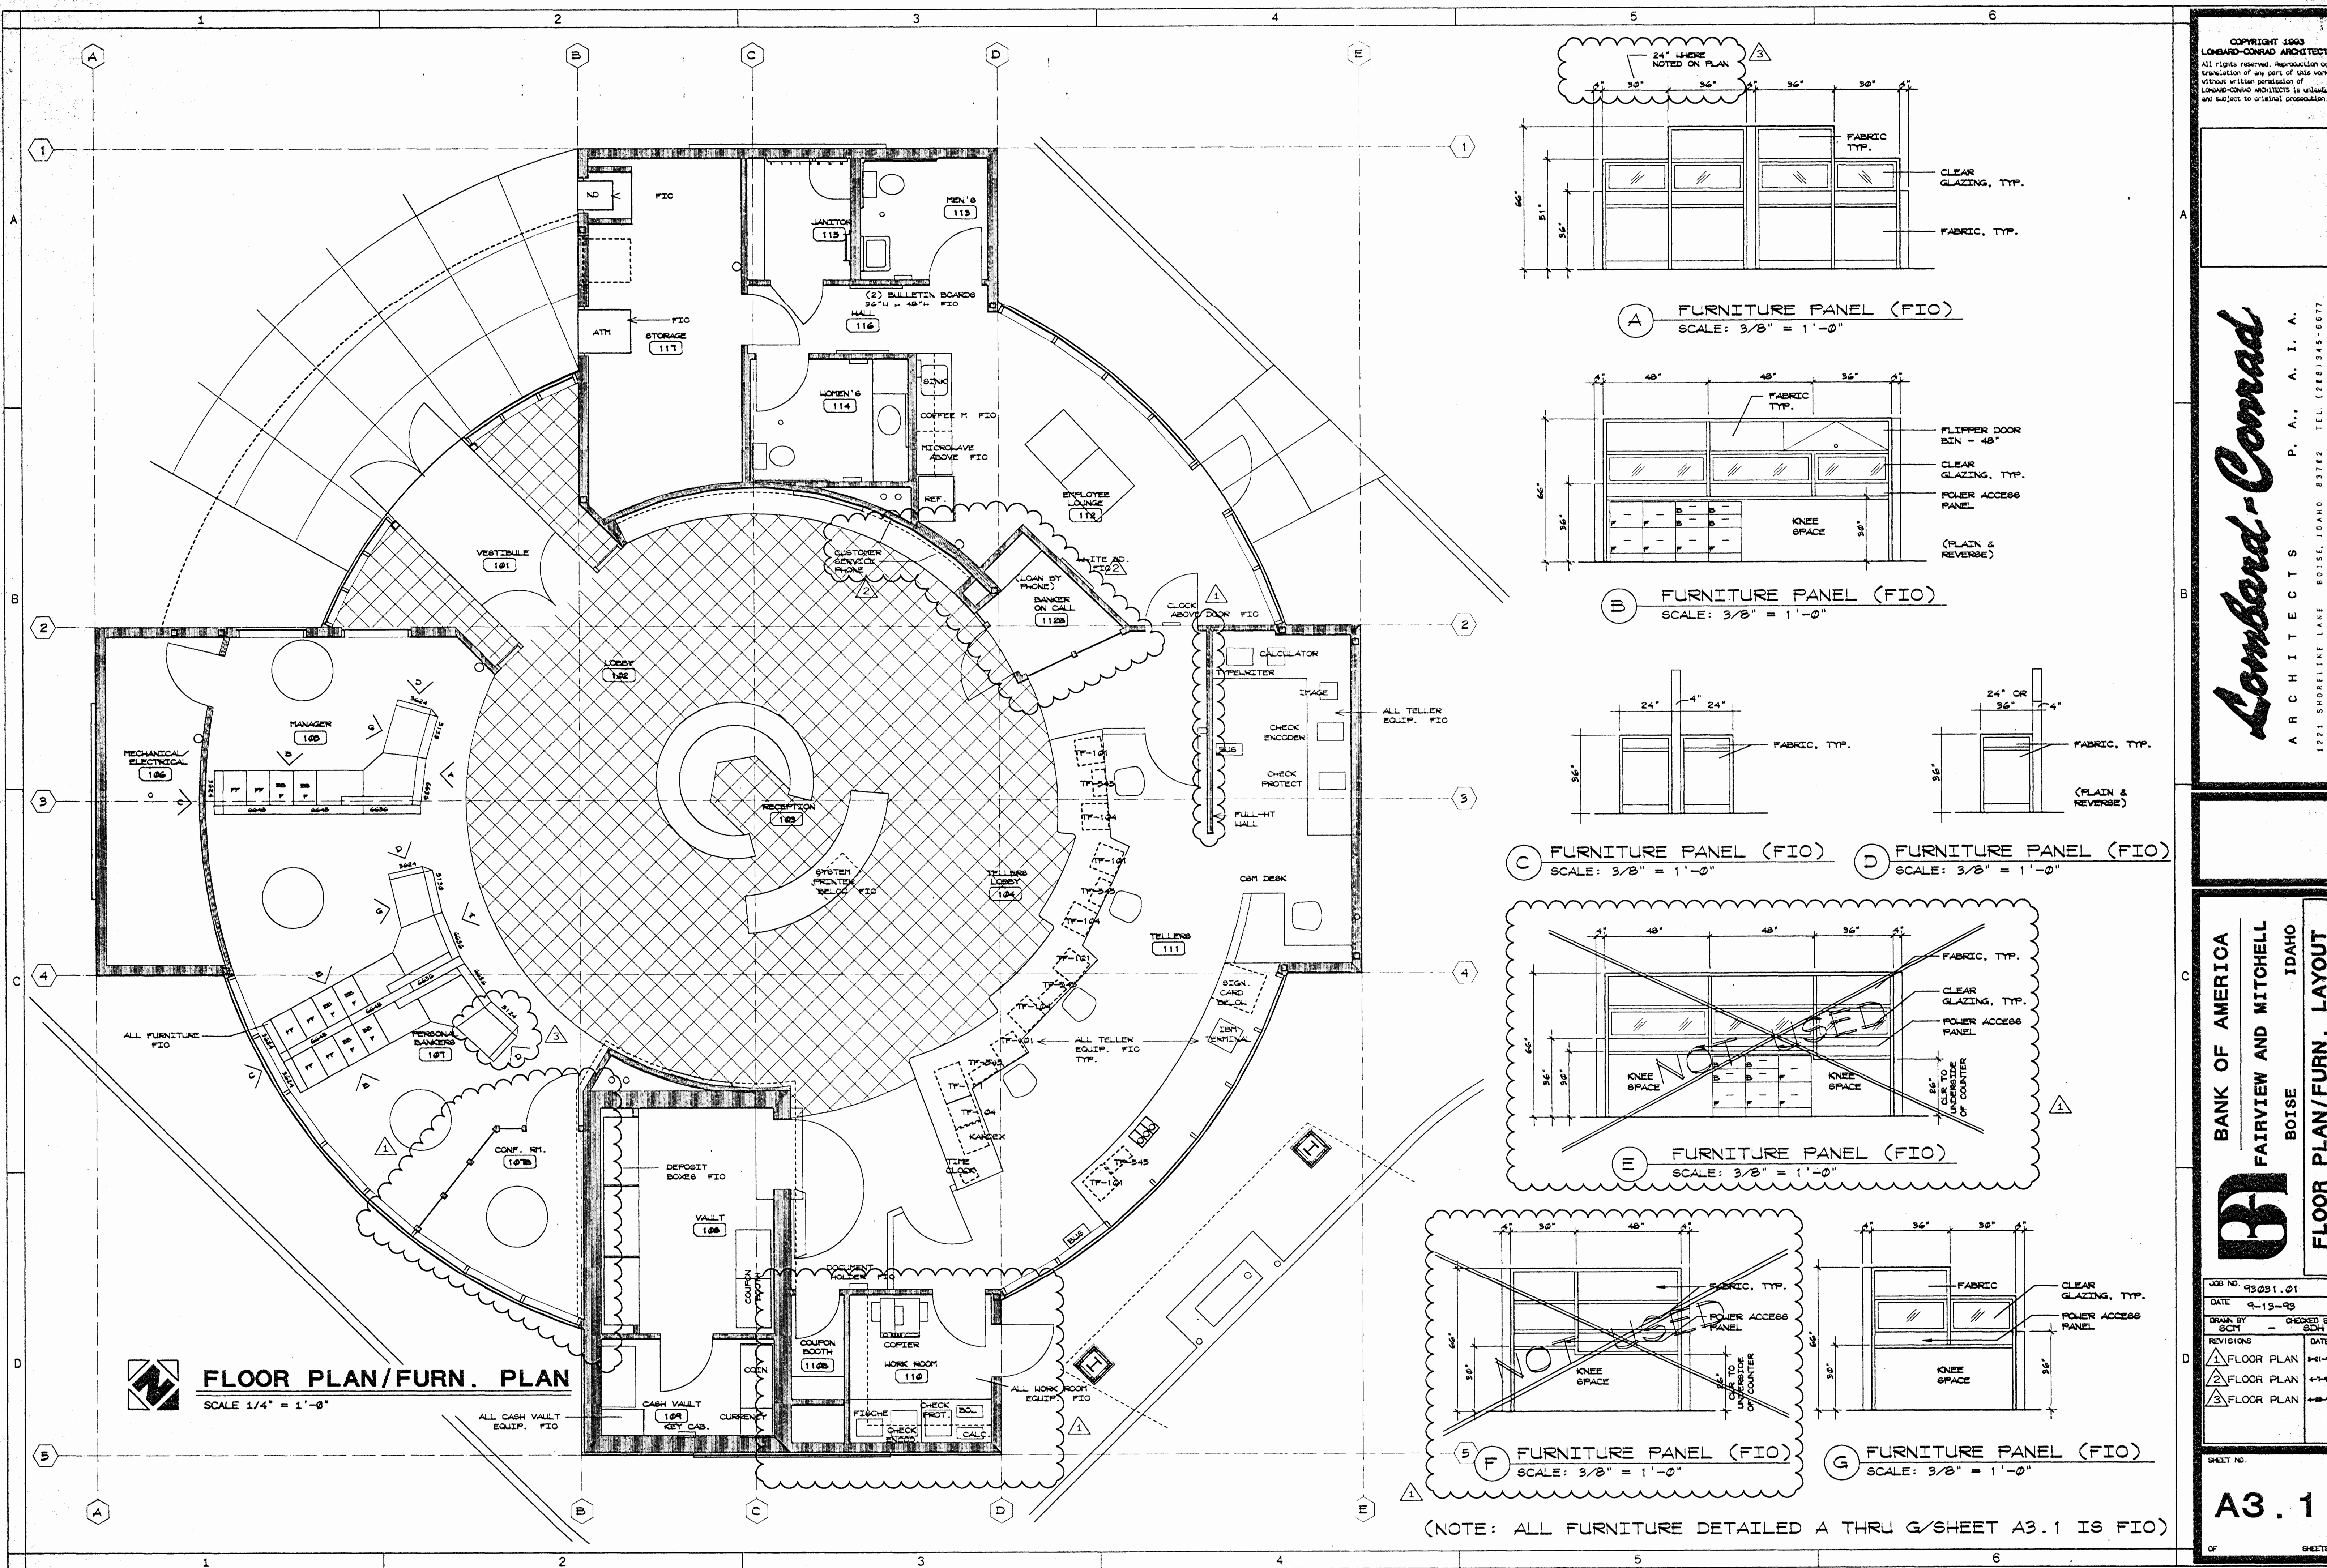


FLOOR PLAN/FURN. PLAN
SCALE: 1/4" = 1'-0"

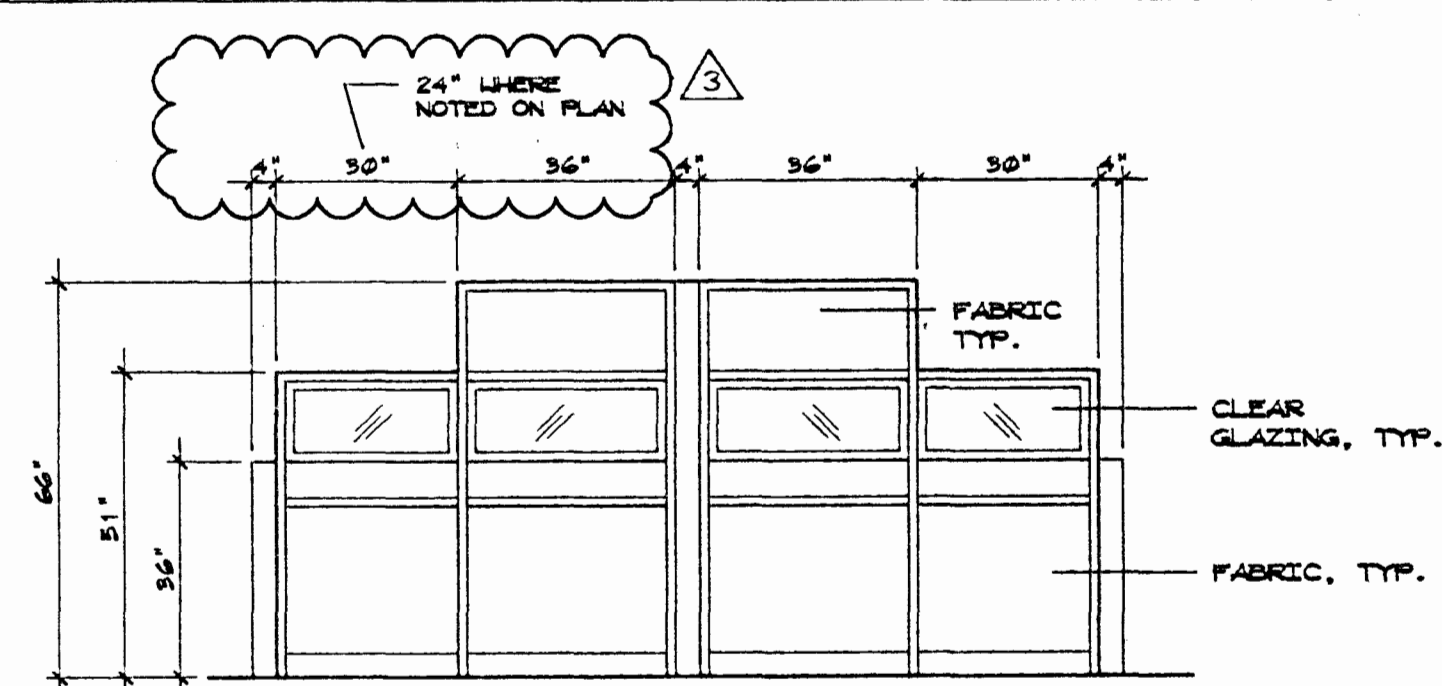

A FURNITURE PANEL (FIO)
SCALE: 3/8" = 1'-0"

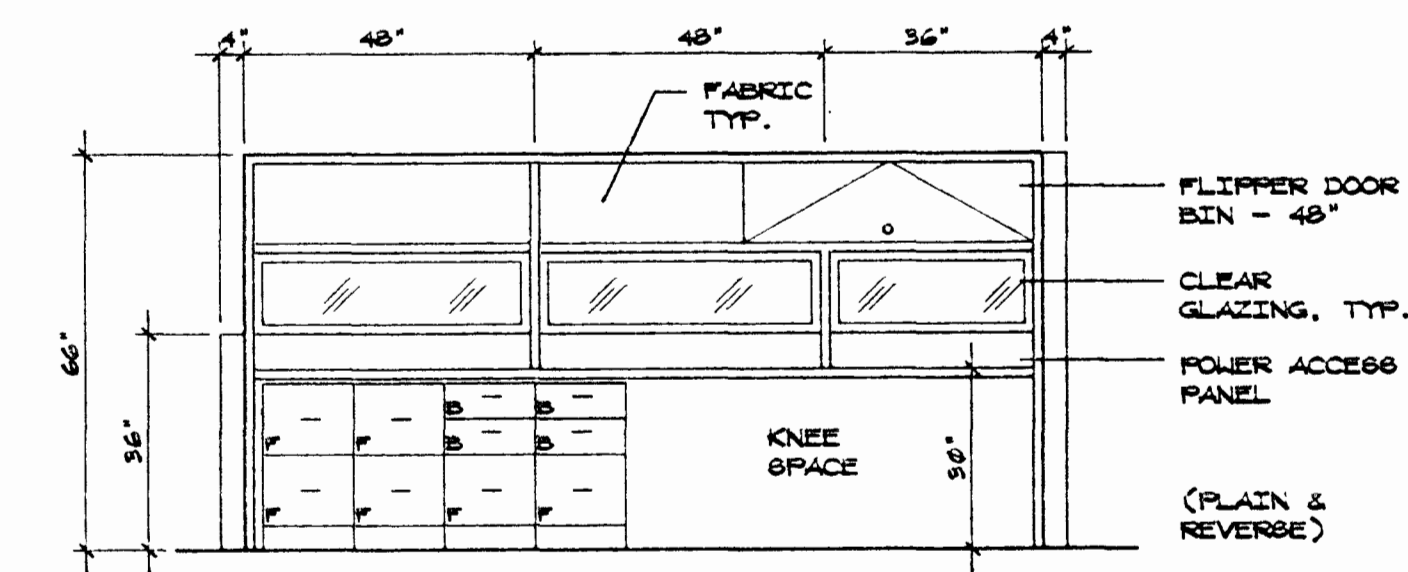


B FURNITURE PANEL (FIO)
SCALE: 3/8" = 1'-0"

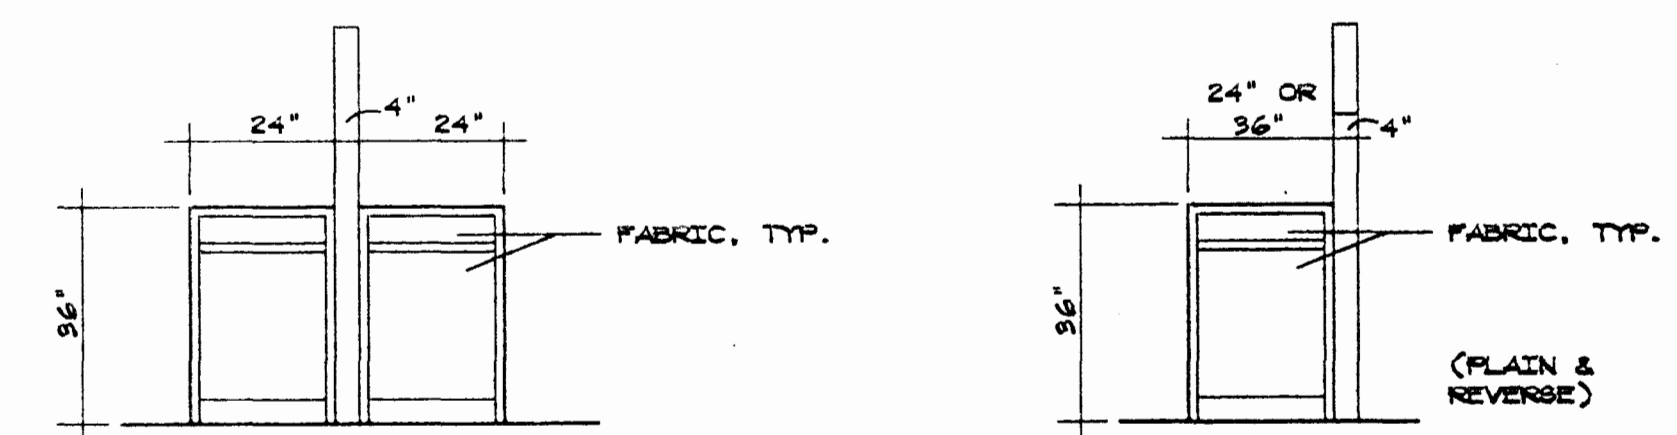


C FURNITURE PANEL (FIO)
SCALE: 3/8" = 1'-0"


D FURNITURE PANEL (FIO)
SCALE: 3/8" = 1'-0"

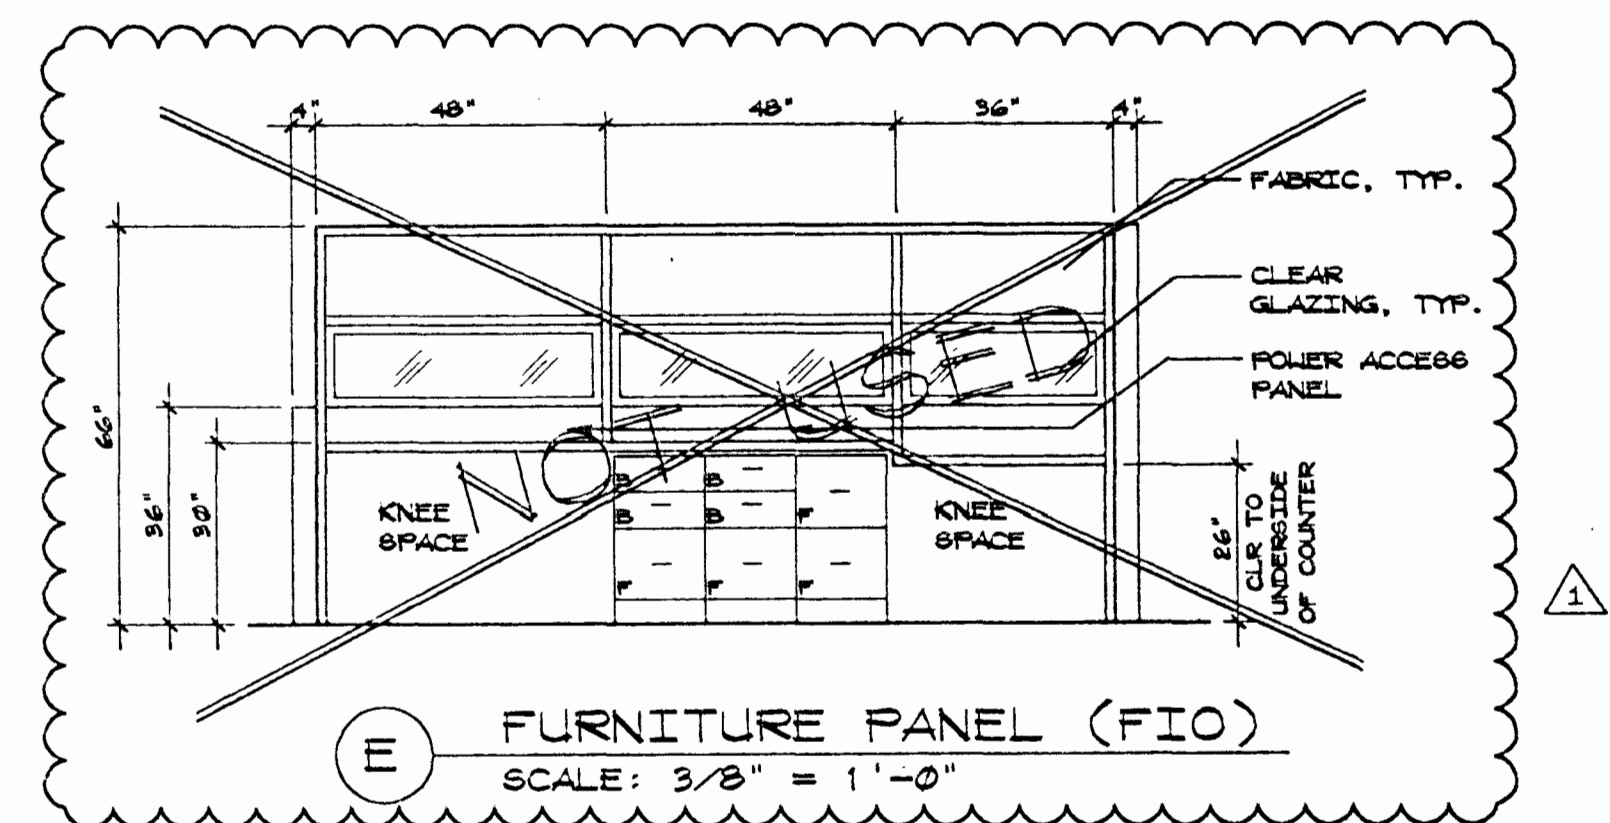

E FURNITURE PANEL (FIO)
SCALE: 3/8" = 1'-0"

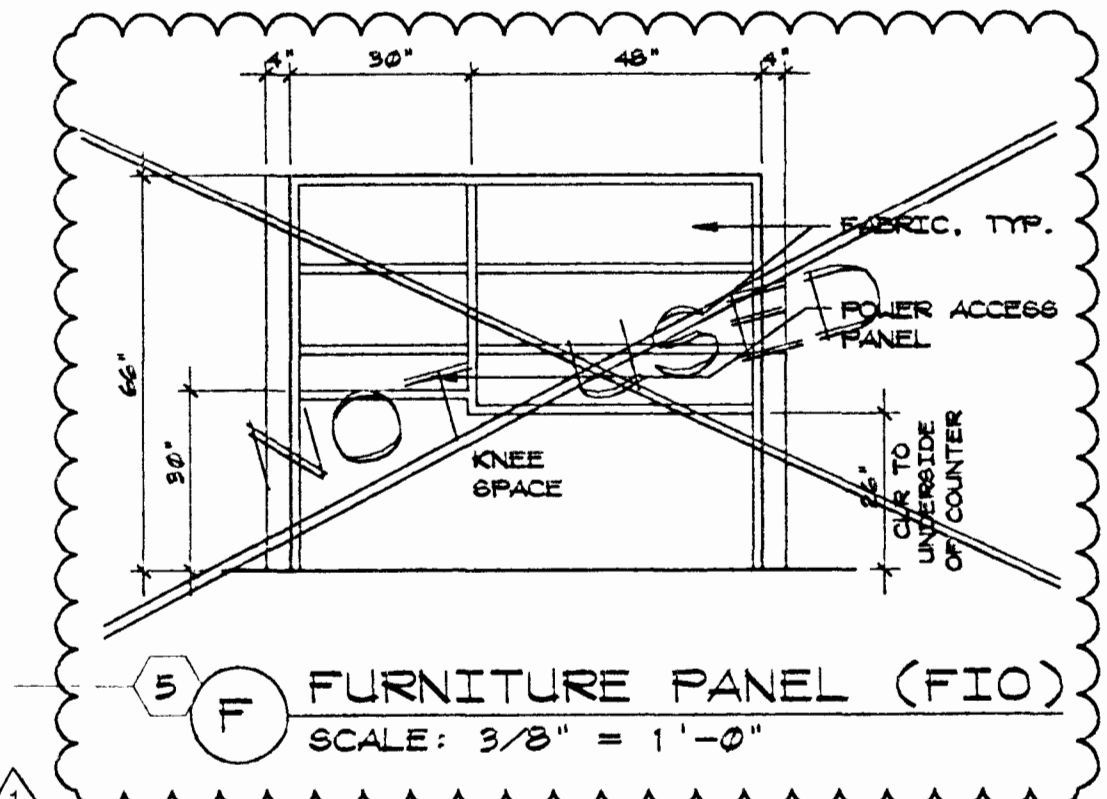

F FURNITURE PANEL (FIO)
SCALE: 3/8" = 1'-0"

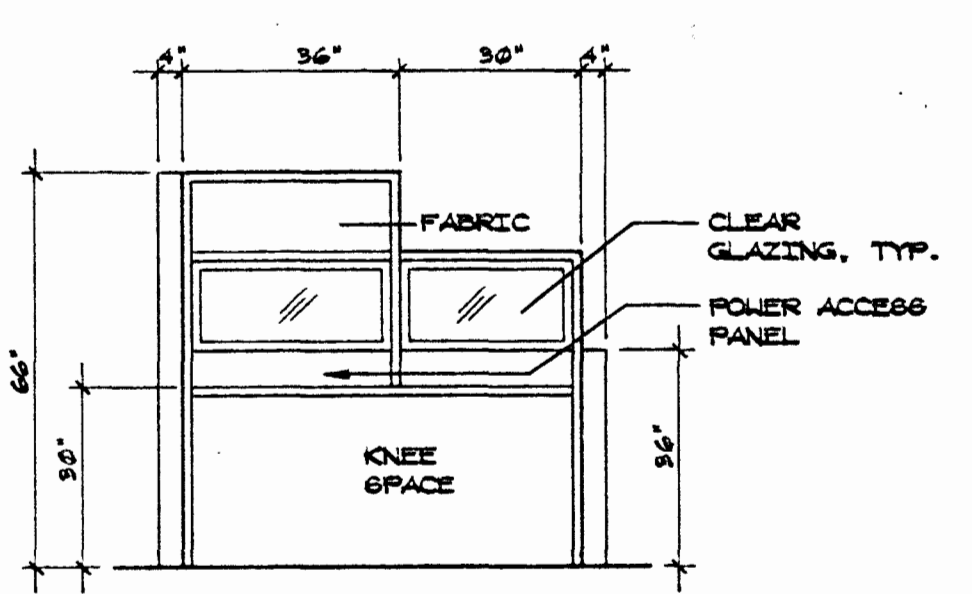

G FURNITURE PANEL (FIO)
SCALE: 3/8" = 1'-0"


(NOTE: ALL FURNITURE DETAILED A THRU G/SHEET A3.1 IS FIO)

COPYRIGHT 1993
 LOMBARD-CONRAD ARCHITECTS
 All rights reserved. Reproduction or
 translation of any part of this work
 without written permission of
 LOMBARD-CONRAD ARCHITECTS is unlawful
 and subject to criminal prosecution.

Lombard-Conrad
 ARCHITECTS
 P. A., A. I. A.
 1221 SHORELINE LANE BOISE, IDAHO 83702 TEL. (208) 345-6677

BANK OF AMERICA
FAIRVIEW AND MITCHELL
BOISE IDAHO
FLOOR PLAN/FURN. LAYOUT

JOB NO. 93091.01
 DATE 9-19-93
 DRAWN BY SCM CHECKED BY SCM
 REVISIONS DATE
 1 FLOOR PLAN 9-1-93
 2 FLOOR PLAN 9-1-93
 3 FLOOR PLAN 9-1-93
 SHEET NO.
A3.1
 OF SHEETS

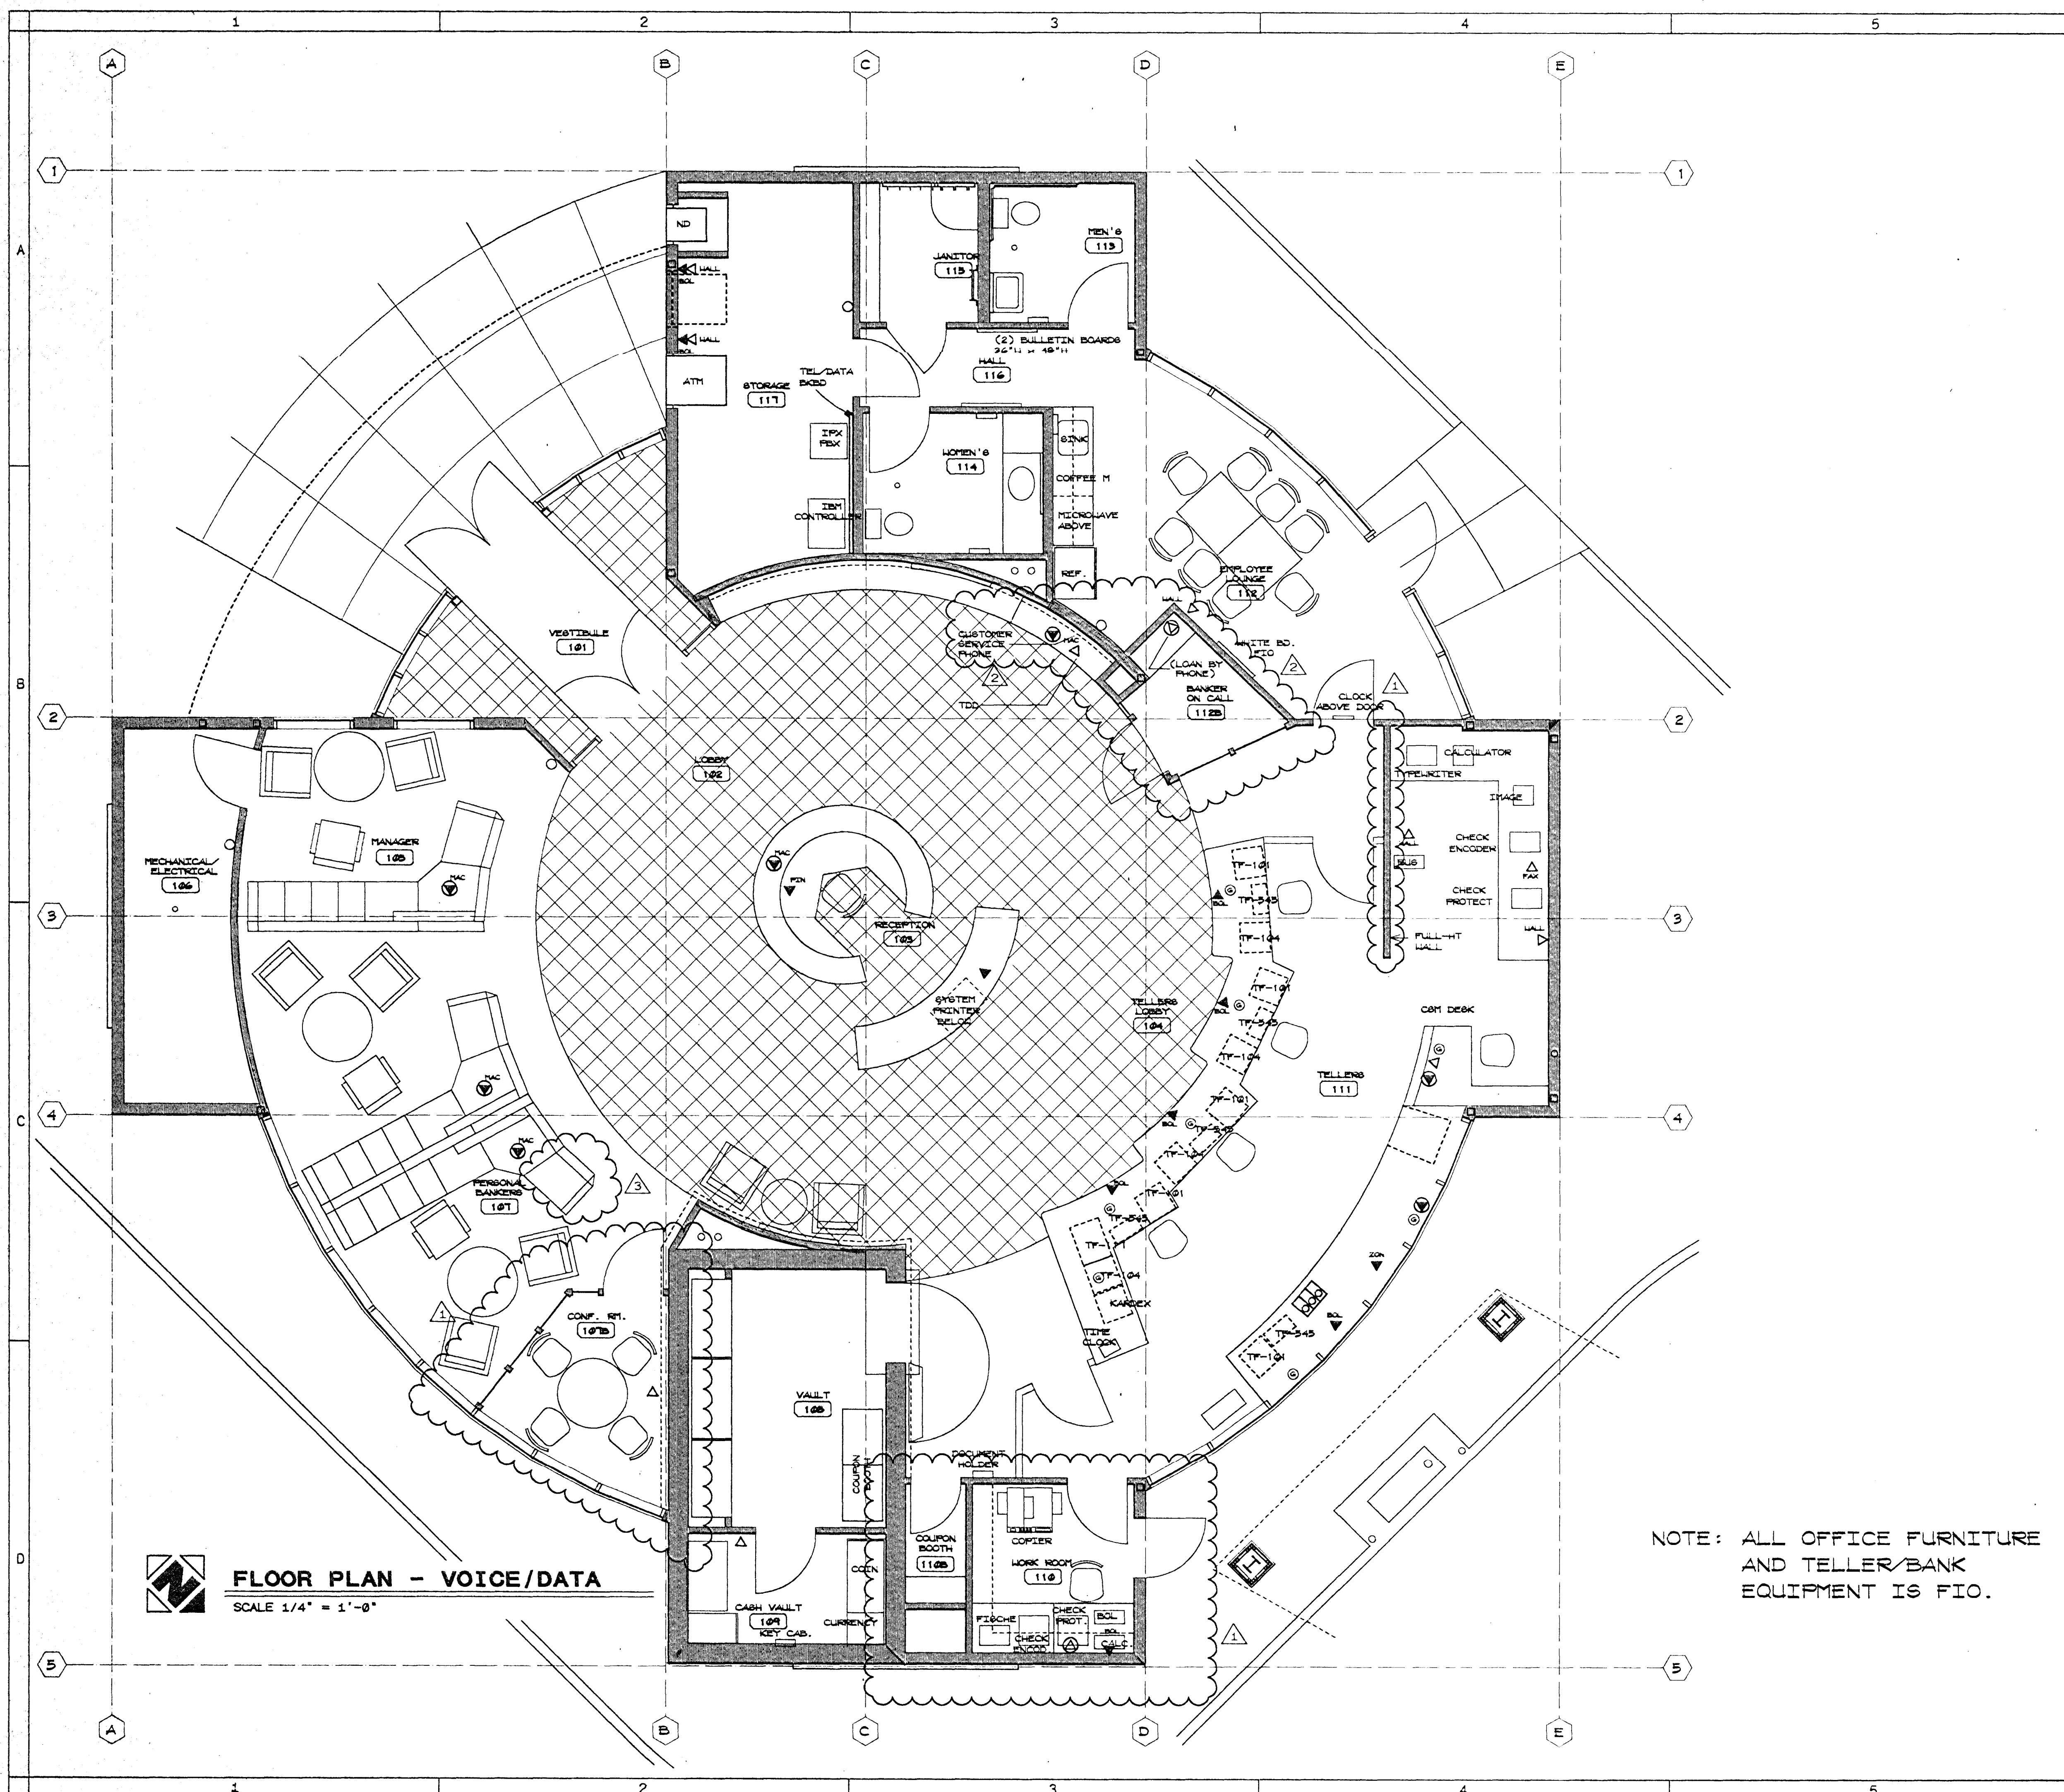

EQUIPMENT & CABLE LEGEND

SYMBOL	EQUIPMENT TYPE
	TELLER EXPANSION UNIT (TEU)
	MAC
	SYSTEM PRINTER
	PIN OUTLET
	ZON
	TELEPHONE (ONLY)
	COMBINATION VOICE & DATA
	FAX OUTLET
	GROMMET HOLE

CABLE TYPE

2 - 4 TWISTED PAIR (AT&T # 2010-C)

1 - 4 TWISTED PAIR (AT&T # 2010-C)

1 - 4 TWISTED PAIR (AT&T # 2010-C)

1 - 4 TWISTED PAIR (AT&T # 2010-C)

1 - 4 TWISTED PAIR (AT&T # 2010-C)

1 - 4 TWISTED PAIR (AT&T # 2010-C)

2 - 4 TWISTED PAIR (AT&T # 2010-C)

CABLES FROM AND TO

DATA CABLE FROM I.T.C. IN ROOM 117 (STORAGE) TO EACH TELLER EXPANSION UNIT (TEU)

FROM I.B.M. CONTROLLER IN ROOM 117 (STORAGE) TO EACH MAC TERMINAL

FROM I.B.M. CONTROLLER IN ROOM 117 (STORAGE) TO SYSTEM PRINTER #103 RECEPTION

FROM TELEPHONE BACKBOARD IN ROOM 117 TO EACH STATION

FROM TELEPHONE BACKBOARD IN ROOM 117 TO EACH STATION

FROM TELEPHONE BACKBOARD IN ROOM 117 TO EACH STATION

FROM TELEPHONE BACKBOARD IN ROOM 117 TO EACH STATION

FROM TELEPHONE BACKBOARD IN ROOM 117 TO EACH STATION

NOTE: ALL OFFICE FURNITURE AND TELLER/BANK EQUIPMENT IS FIO.

FLOOR PLAN - VOICE/DATA
SCALE 1/4" = 1'-0"

COPYRIGHT 1993
Lombard-Conrad ARCHITECTS
All rights reserved. Reproduction or
translation of any part of this work
without written permission of
Lombard-Conrad ARCHITECTS is unlawful
and subject to criminal prosecution.

Lombard-Conrad
ARCHITECTS
P. A., A. I. A.
1221 SHORELINE LANE BOISE, IDAHO 83782 TEL. (208) 345-6677

BANK OF AMERICA
FAIRVIEW AND MITCHELL
BOISE IDAHO
FLOOR PLAN - VOICE DATA

JOB NO. 93091.01
DATE 9-13-93
DRAWN BY SCH - CHECKED BY SCH
REVISIONS
1. FLOOR PLAN 9-13-93
2. FLOOR PLAN 9-13-93
3. FLOOR PLAN 9-13-93

SHEET NO.
A3.2
OF SHEETS

DOOR SCHEDULE


DOOR NO.	RM NO.	SIZE	DOOR				FRAME				DETAILS SEE SHEET A5.1				LABEL	HDL	REMARKS
			TYPE	MATL	FIN	GLAZ	TYPE	MATL	FIN	DEP	HEAD	HINGE JAMB	STRIKE JAMB	SILL			
101	101	FR. 3'-0" X 7'-0"	B	AL	FF	A	4	AL	FF	6 3/4"	13	9	9	11	-	2	
102	102	FR. 3'-0" X 7'-0"	B	AL	FF	A	3	AL	FF	4 1/2"	14	8	8	-	-	3	
106	106	3'-0" X 7'-0"	A	LD	ST	-	1	STL	FT	5 3/4"	12	12	12	-	-	6	UNDERCUT DOOR 1/2"
108	108	-	-	-	-	-	-	-	-	-	14/AS.2	15/AS.2	15/AS.2	14/AS.2	-	-	VALLEY DOOR BY OWNER CONTR. TO GRAB AFTER INSTALLATION 12 1/2" LOUVER IN DOOR
109	109	3'-0" X 7'-0"	A	LD	ST	-	1	STL	FT	5 3/4"	12	12	12	-	-	10	UNDERCUT DOOR 1/2"
110	110	3'-0" X 7'-0"	C	LD	ST	A	1	STL	FT	5 3/4"	12	5	5	12	-	7	UNDERCUT DOOR 1/2"
NOT USED																	
112	112	3'-0" X 7'-0"	C	LD	ST	A	1	STL	FT	5 3/4"	12	12	12	-	-	12	UNDERCUT DOOR 1/2"
112A	112	3'-0" X 7'-0"	B	AL	FF	A	7	AL	FF	6 3/4"	13	8 1/2"	9	11	-	1	
113	113	3'-0" X 7'-0"	A	LD	FT	-	1	STL	FT	5 3/4"	12	12	12	-	-	11	UNDERCUT DOOR 3/4"
114	114	3'-0" X 7'-0"	A	LD	FT	-	1	STL	FT	5 3/4"	12	12	12	-	-	11	UNDERCUT DOOR 3/4"
115	115	3'-0" X 7'-0"	A	LD	FT	-	1	STL	FT	5 3/4"	12	12	12	-	-	9	UNDERCUT DOOR 3/4"
117	117	3'-0" X 7'-0"	A	LD	FT	-	1	STL	FT	5 3/4"	12	12	12	-	-	8	UNDERCUT DOOR 1/2"
118	118	FR. 4'-0" X 7'-0"	A	STL	FT	-	2	STL	FT	8 3/4"	12	12	12	-	-	4	64" X 20" LOUVER IN DOOR
119	119	4'-0" X 7'-0"	A	STL	FT	-	1	STL	FT	7 3/4"	12	12	12	11	-	13	
120	110	3'-0" X 7'-0"	C	STL	FT	E	1	STL	FT	8 3/4"	-	-	-	-	-	1	
121	110B	3'-0" X 4'-0"	D	LD	FT	-	1	STL	FT	5 3/4"	12	12	12	-	-	11	CENTER DOOR IN FRAME
122	107B	3'-0" X 7'-0"	A *	LD	ST	A	1	LD	ST	*	8/4.2	7/4.2	8/4.2	-	-	11	* DOOR TYPE A ALL GLASS PANEL
123	112B	3'-0" X 7'-0"	A *	LD	ST	A	1	LD	ST	*	8/4.2	11/4.2	8/4.2	-	-	11	* DOOR TYPE A ALL GLASS PANEL

ROOM FINISH SCHEDULE

RM NO	ROOM NAME	FLOORING			BASE		WEST WALL			NORTH WALL			EAST WALL			SOUTH WALL			CEILING			REMARKS
		MATL	FIN	CR	MATL	CR	MATL	FIN	CR	MATL	FIN	CR	MATL	FIN	CR	MATL	FIN	CR	MATL	FIN	CR	
101	VESTIBULE	MAT CT	FF	1.2	RB	4.2	-	-	-	GYP	FT	5.1	GYPK	FT	5.1	GYP	FT	5.1	APC	FF	-	9'-0" * ABOVE DOOR
102	LOBBY	CT	FF	3.1	RB	4.2	GYP	FT	5.3	GYP	FT	5.2	GYPK	FT	5.1	GYPK	FT	5.1	APC	FF	-	11'-0" * ABOVE DOOR OR OPENING
103	RECEPTION	CT	FF	3.1	RB	4.2	-	-	-	-	-	-	-	-	-	-	-	-	APC	FF	-	11'-0"
104	TELLER'S LOBBY	CT	FF	3.1	RB	4.2	-	-	-	-	-	-	-	-	-	-	-	-	APC	FF	-	11'-0"
105	LOAN BY PHONE	CPT	FF	1.1	RB	4.1	GYP	FT	5.1	-	-	-	-	-	-	GYP	FT	5.1	APC	FF	-	9'-0"
106	MECH./ELEC.	SV	FF	2.1	RB	4.2	GYP	FT	5.1	GYP	FT	5.1	GYP	FT	5.1	GYP	FT	5.1	EXP	-	-	-
107	PERSONAL BANKERS	CPT	FF	1.1	RB	4.1	-	-	-	GYP	FT	5.2	-	-	-	-	-	-	APC	FF	-	9'-0"
107B	CONFERENCE ROOM	CPT	FF	1.1	RB	4.1	-	-	-	GYP	FT	5.1	-	-	-	-	-	-	APC	FF	-	9'-0"
108	VAULT	CPT	FF	1.1	RB	4.1	GYP	FT	5.1	GYP	FT	5.1	GYP	FT	5.1	GYPK	FT	5.1	GYP	FT	5.1	8'-6" * ABOVE & SIDES OF DEPOSIT BOXES
109	CASH VAULT	CPT	FF	1.1	RB	4.1	GYP	FT	5.1	GYP	FT	5.1	GYP	FT	5.1	GYP	FT	5.1	GYP	FT	5.1	8'-6"
110	WORK ROOM	SV	FF	2.1	RB	4.2	GYP	FT	5.1	GYP	FT	5.1	GYP	FT	5.1	GYP	FT	5.1	APC	FF	-	8'-0"
110B	COUPON BOOTH	CPT	FF	2.1	RB	4.1	GYP	FT	5.1	GYP	FT	5.1	GYP	FT	5.1	GYP	FT	5.1	APC	FF	-	8'-0"
111	TELLERS	CPT	FF	1.1	RB	4.1	GYP	FT	5.1	GYP	FT	5.1	GYP	FT	5.1	GYP	FT	5.2	APC	FF	-	9'-0"
111A	ATM CLOSET	SV	FF	2.1	RB	4.2	GYP	FT	5.1	GYP	FT	5.1	GYP	FT	5.1	GYP	FT	5.1	APC	FF	-	8'-0"
112	EMPLOYEE'S LOUNGE	CPT	FF	1.1	RB	4.1	-	-	-	-	-	-	GYP	FT	5.1	GYP	FT	5.1	APC	FF	-	9'-0"
112B	BANKER ON CALL	CPT	FF	1.1	RB	4.1	GYP	FT	5.1	GYP	FT	5.1	GYP	FT	5.1	GYP	FT	5.1	GYP	FT	5.1	8'-0"
113	MEN'S	SV	FF	2.1	5" X 12" RB 4.2	GYP	*FT	5.4	GYP	*FT	5.4	GYP	*FT	5.4	GYP	*FT	5.4	GYP	FT	5.4	8'-0"	* PROVIDE PL-1 LATHING TO 48" A.P.F. WITH METAL TRIM EDGE.
114	WOMEN'S	SV	FF	2.1	5" X 12" RB 4.2	GYP	*FT	5.4	GYP	*FT	5.4	GYP	*FT	5.4	GYP	*FT	5.4	GYP	FT	5.4	8'-0"	* PROVIDE PL-1 LATHING TO 48" A.P.F. WITH METAL TRIM EDGE.
115	JANITOR	SV	FF	2.1	RB	4.2	GYP	FT	5.1	GYP	FT	5.1	GYP	FT	5.1	GYP	FT	5.1	EXP	-	-	-
116	HALL	CPT	FF	1.1	RB	4.1	GYP	FT	5.1	-	-	-	GYP	FT	5.1	GYP	FT	5.1	APC	FF	-	8'-0"
117	STORAGE	SV	FF	2.1	RB	4.2	GYP	FT	5.1	GYP	FT	5.1	GYP	FT	5.1	GYP	FT	5.1	APC	FF	-	8'-0"
118	TRASH	CONC	BLR	-	-	-	EIFS	FF	*	EIFS	FF	*	EIFS	FF	*	EIFS	FF	*	EXT	FF	*	8'-0" * SEE EXT. FINISH KEY
119	STORAGE	CONC	BLR	-	-	-	GYP	FT	5.1	GYP	FT	5.1	GYP	FT	5.1	GYP	FT	5.1	EXP	-	-	-

DOOR TYPES

FRAME TYPES

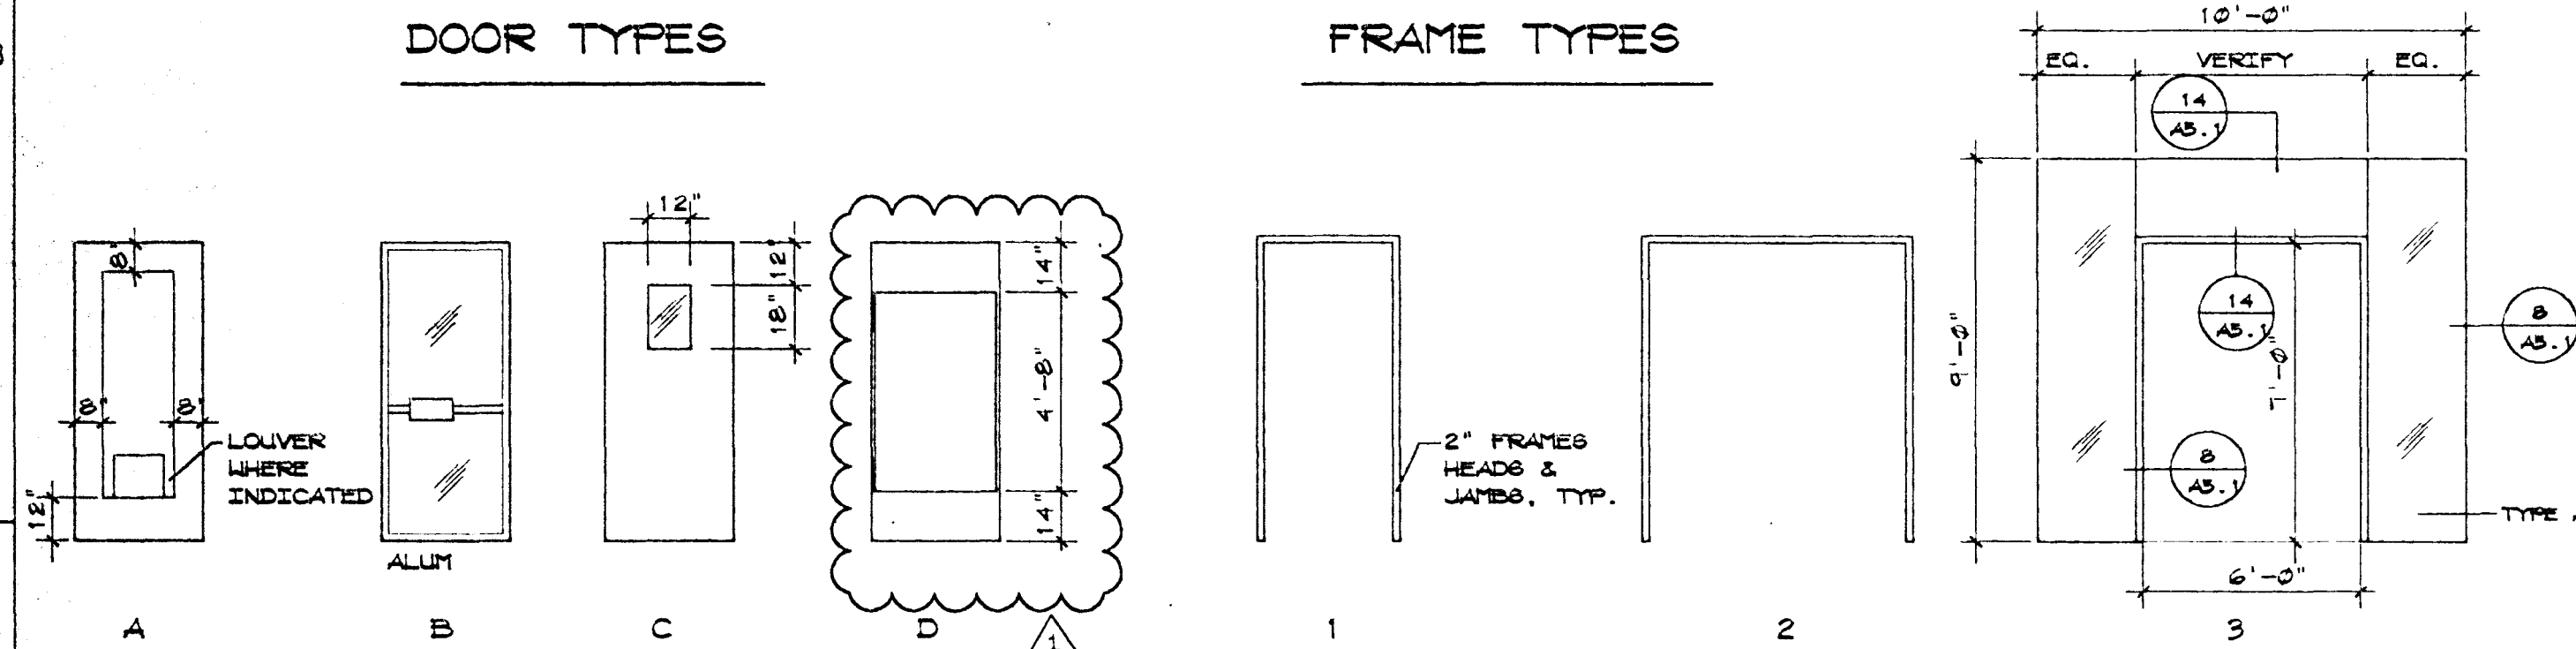

GLAZING TYPES

TYPE A: SINGLE SHEET TEMPERED GLASS
 TYPE B: INSULATED TEMPERED GLASS
 TYPE C: INSULATED TEMPERED GLASS, SPANDREL GLASS INSIDE PANE
 TYPE D: INSULATED TEMPERED GLASS, SPANDREL GLASS INSIDE PANE
 TYPE E: BULLET RESISTANT GLASS

LEGEND

AL ALUMINUM
 FF FACTORY FINISH
 PL PLASTIC LAMINATE
 FR PAIR OF DOORS
 PT PAINT
 ST STAIN
 STL STEEL
 LD WOOD

GENERAL NOTE:
 GLAZING, IN THE SAME WALL PLAIN AS A DOOR,
 MUST BE SAFETY GLAZING IF WITHIN 12" OF A DOOR.
 GLAZING LOCATED LESS THAN 18" OF A WALKING
 SURFACE, MUST BE SAFETY GLASS.
 UBC SEC 5406.

INTERIOR FINISH KEY

CARPET:
 CARPET 1.1 STRATTON, PALLAZO, 6039, COLOR MOSAIC #9350
 ENTRY MAT 1.2 CORAL PLUS CLEAN-OFF-ZONE, #3810 DARK GRAY

RESILIENT FLOORING:
 SHEET VINYL 2.1 ARMBSTRONG CLASSIC CORLON, COMERCIAL SHEET
 FLOORING "BUPFIED" #6605, PLATINUM

CERAMIC TILE:
 TILE 3.1 CROSSVILLE CERAMICS C 675
 STONEHENGE 12 X 12 MATTE

BASE:
 RB 4.1 BURKE, SMOKE #564P (CARPET)
 RB 4.2 BURKE, SMOKE #564P (COVERED)

PAINT:
 PT 5.1 COLUMBIA PAINT OR PARKER #5361, BAVARIAN TONTE,
 550 SEMI GLOSS ENAMEL (GENERAL)
 PT 5.2 COLUMBIA PAINT OR PARKER #5343, LOG CABIN,
 550 SEMI GLOSS ENAMEL (ACCENT)
 PT 5.3 COLUMBIA PAINT OR PARKER #6025N, MIDNIGHT,
 4500 SATIN LATEX ENAMEL (ACCENT)
 PT 5.4 COLUMBIA PAINT OR PARKER #5361, BAVARIAN TONTE,
 EPOXY SEMI GLOSS (TOILET ROOMS)

WOOD DOORS:
 STAIN ST 6.1 DALY'S WOOD STAIN, SPECIAL TS, 1/4" ANILINE DYE 349/326
 PAINT PT 6.2 PAINT TO MATCH WILSONART, PEBBLE, D337-6

STEEL DOOR FRAMES:
 PAINT PT 7.1 PAINT TO MATCH WILSONART, PEBBLE, D337-6

PLASTIC LAMINATE:
 PL-1 8.1 NEVAMAR AMP SURFACE, GREIGE MATRIX, MR-2-2T TEXTURED
 PL-2 8.2 WILSON ART, PEBBLE, E, D337-6
 PL-3 8.3 NEVAMAR POLISHED CHROME PT-6-1

AVONITE:
 AV 9.1 ADOBE BROWN C1-1700, POLISHED FINISH

WINDOW TREATMENT:
 BLINDS 10.1 LEVELOR 312 GREIGE STYLE: KIVIERA

MEDIUM DENSITY OVERLAY PLYWOOD:
 MDO 12.1 PAINT TO MATCH WILSONART, PEBBLE D337-6

FURNITURE PANELS:
 STAIN ST 13. DALY'S WOOD STAIN, SPECIAL TS, 1/4" ANILINE DYE 349/326

EXTERIOR FINISH KEY

EXTERIOR INSULATION & FINISH SYSTEM:
 DRYVIT D-1 TO BE SELECTED BY ARCHITECT
 DRYVIT D-2 TO MATCH COLUMBIA PAINT OR PARKER #6015B
 INDIA INK (ENTRY SOFFIT)

EXTERIOR FINISH SOFFIT SYSTEM:
 DRYVIT TO BE SELECTED BY ARCHITECT

GLAZING:
 INSULATED L.O.F. BLUE-BLUE
 ECLIPSE (ABOVE &
 BELOW CEILING LINE)

SPANDREL SAME AS ABOVE EXCEPT
 APPLY CERAMIC FRIT TO
 BACK (THIS GLAZING OCCURS
 ABOVE ROOF PARAPET)

ALUM. DOOR & WINDOW FRAMES:
 1. DOORS: CLEAR ANODIZED
 2. FRAMES: CLEAR ANODIZED

STEEL DOORS & FRAMES:
 PAINT TO MATCH DRYVIT D-1

BOLLARDS:
 PAINT TO MATCH DRYVIT D-1

METAL CAP FLASHING:
 PAINT TO MATCH ADJACENT SURFACE

MISCELLANEOUS METALS:
 PAINT TO MATCH ADJACENT SURFACE

LEGEND

APC ACOUSTICAL PANEL CEILING
 AV AVONITE
 CONC CONCRETE
 CPT CARPET
 CR COLOR REFERENCE
 CT CERAMIC TILE
 EIFS EXTERIOR INSULATION & FINISH
 SYSTEM
 EXP EXPOSED TO STRUCTURE
 EXT EXTERIOR FINISH SOFFIT SYSTEM
 FF FACTORY FINISH
 GYP GYPSUM BOARD
 MAT ENTRY MAT
 MDO MEDIUM DENSITY OVERLAY PLYWOOD
 PL PLASTIC LAMINATE
 PT PAINT
 RB RUBBER BASE
 BLR SEALER
 SV SHEET VINYL

COPYRIGHT 1993
 LOMBARD-CONRAD ARCHITECTS
 All rights reserved. Reproduction or
 translation of any part of this work
 without written permission of
 LOMBARD-CONRAD ARCHITECTS is unlawful
 and subject to criminal prosecution.

Lombard-Conrad
 ARCHITECTS
 P. A., A. I. A.
 1221 SHORELINE LAKE BOISE, IDAHO 83702 TEL. (208) 345-6077


BANK OF AMERICA
 FAIRVIEW AND MITCHELL
 BOISE IDAHO
 FINISH SCHED., DOOR SCHED. AND TYPES

JOB NO. 93031.01
 DATE 9-13-93
 DRAWN BY SCM CHECKED BY SCM
 REVISIONS
 ADD ROOMS/DOORS 3-1-94
 ADD ROOMS/DOORS 4-1-94

SHEET NO.

A3.4

OF SHEETS

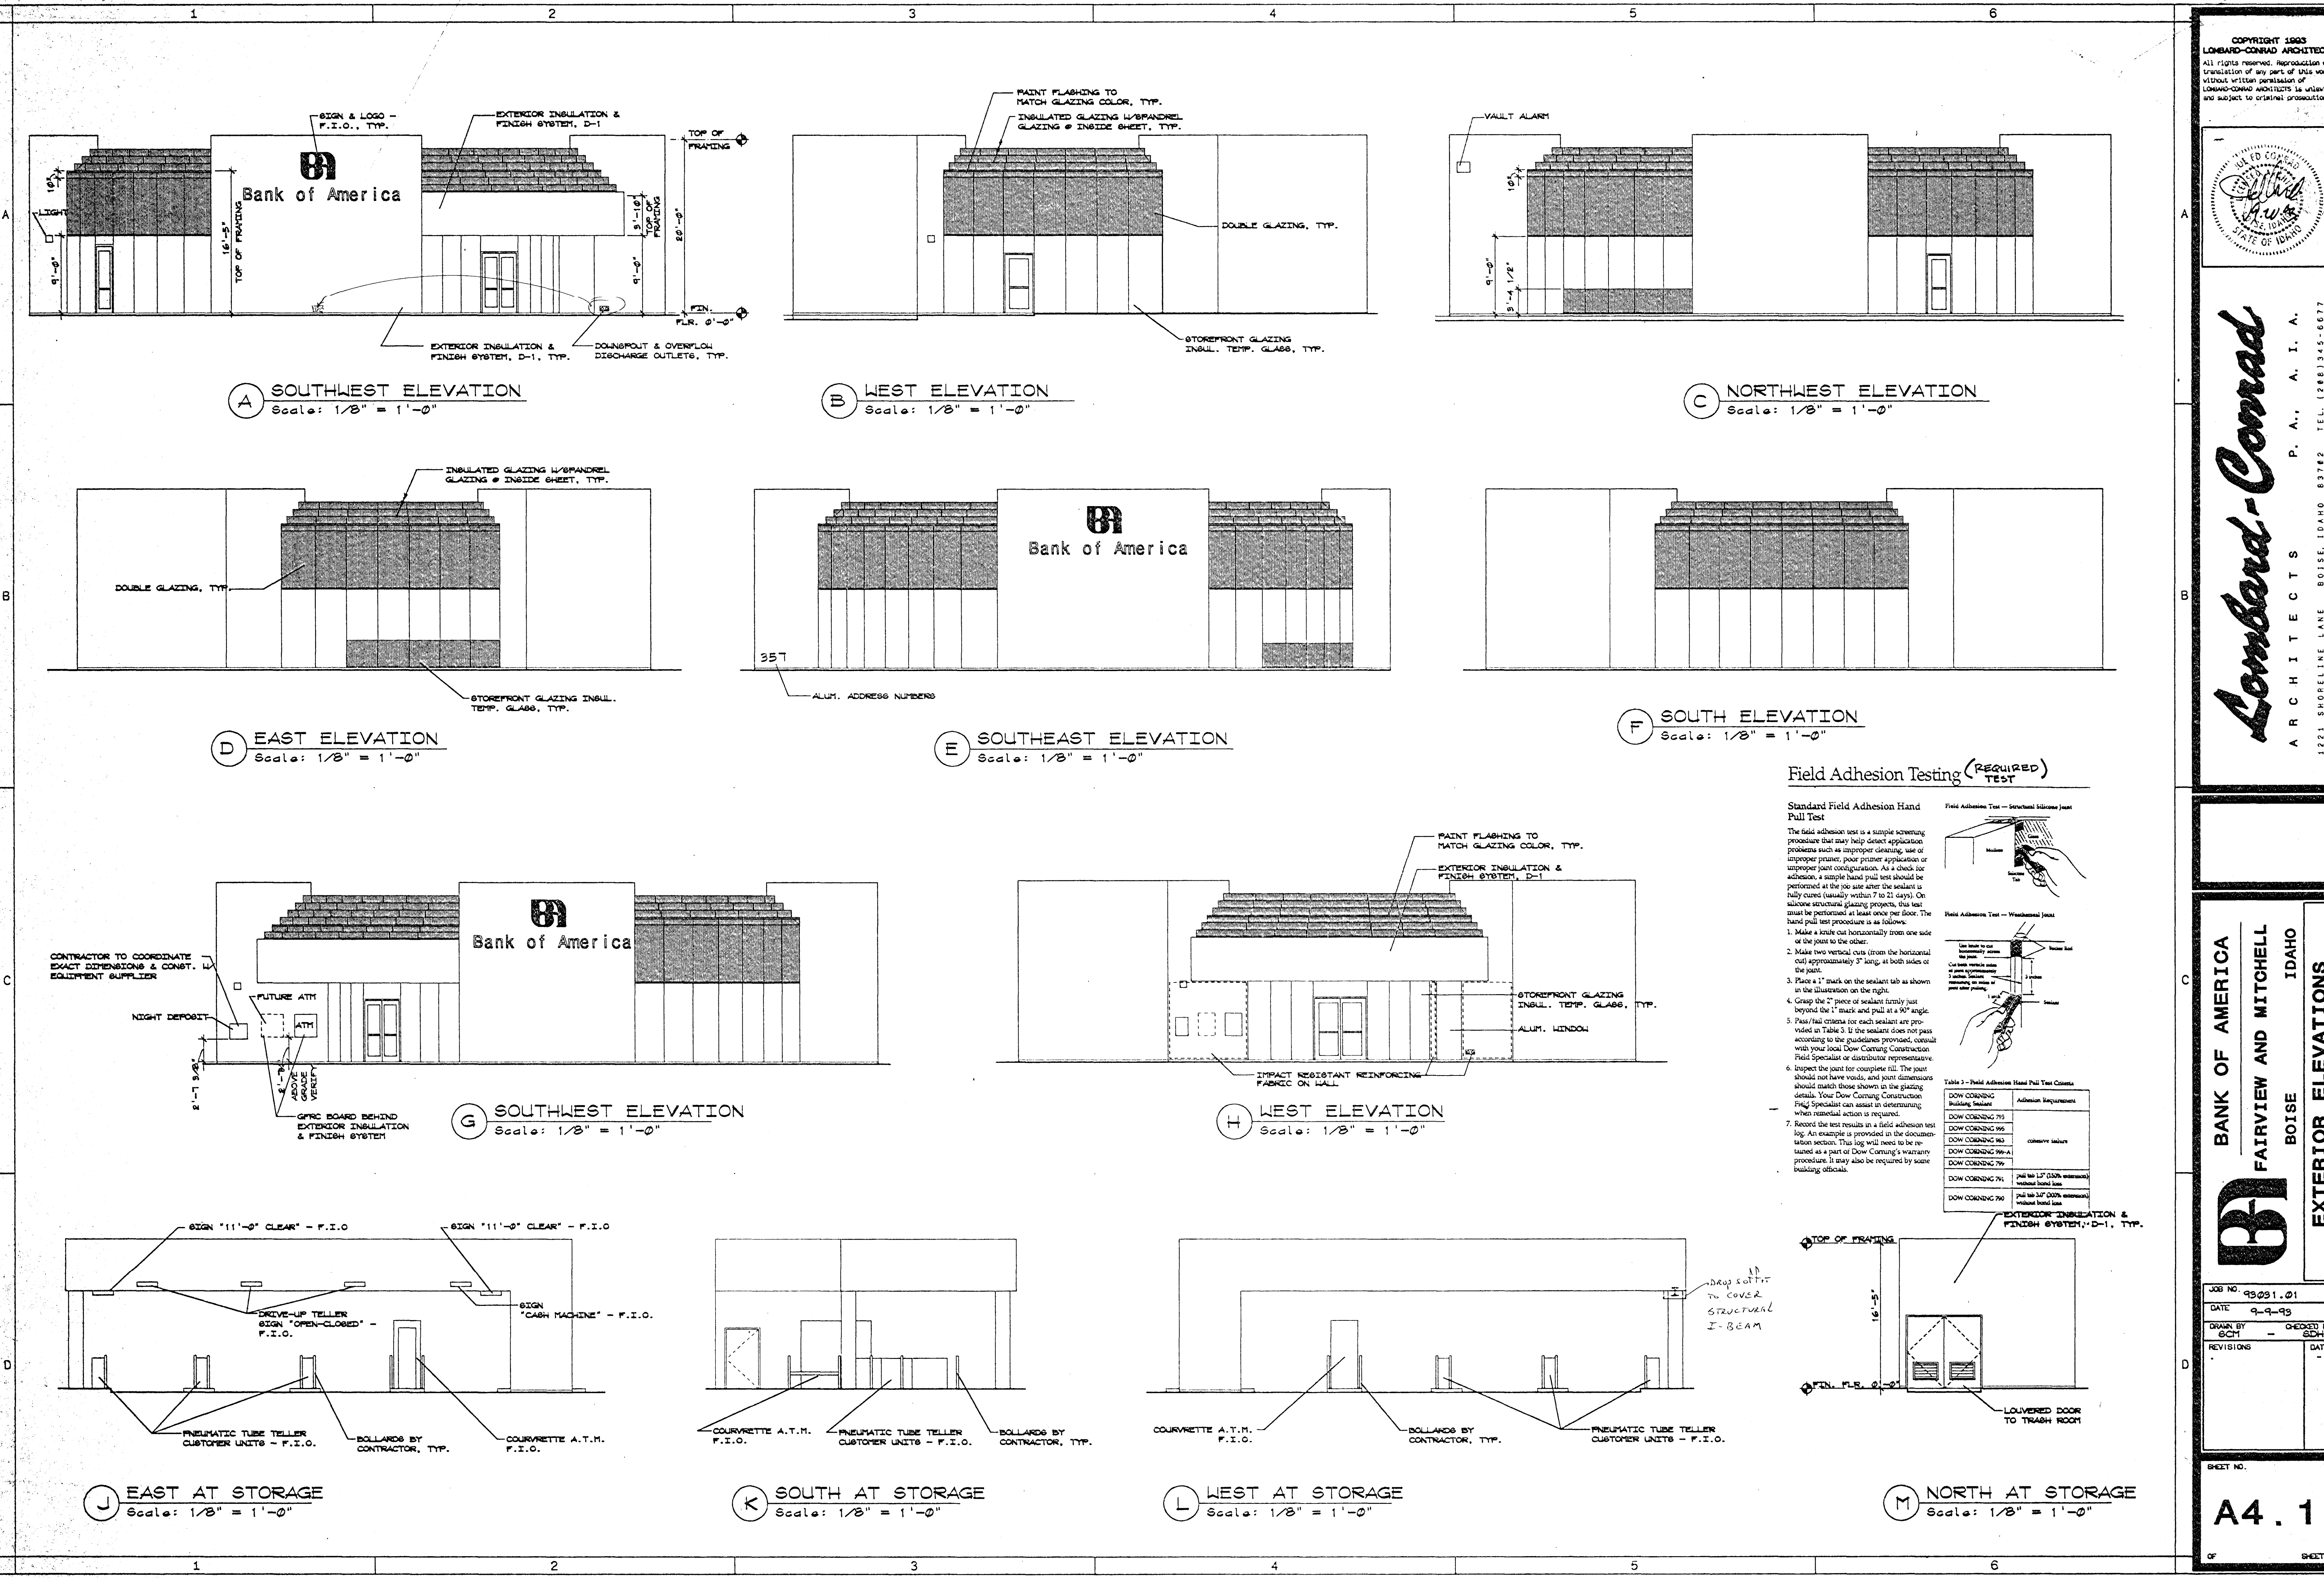

COPYRIGHT 1993
Lombard-Conrad Architects
All rights reserved. Reproduction or
translation of any part of this work
without written permission of
Lombard-Conrad Architects is unlawful
and subject to criminal prosecution.

STATE OF IDAHO
JULY 10 1993
A. I. A.

Lombard-Conrad
ARCHITECTS
P. A., A. I. A.
1221 SHORELINE LANE BOISE, IDAHO 83762 TEL. (208) 345-6677

BANK OF AMERICA
FAIRVIEW AND MITCHELL
BOISE IDAHO
EXTERIOR ELEVATIONS

JOB NO. 93091.01
DATE 9-9-93
DRAWN BY SCH
CHECKED BY SCH
REVISIONS DATE

SHEET NO.
A4.1
OF 3 SHEETS


COPYRIGHT 1993
Lombard-Conrad Architects
All rights reserved. Reproduction or
translation of any part of this work
without written permission of
Lombard-Conrad Architects is unlawful
and subject to criminal prosecution.

Lombard-Conrad
ARCHITECTS
P. A., A. I. A.
1221 SHORELINE LANE BOISE, IDAHO 83782 TEL. (208) 345-6677


BANK OF AMERICA
FAIRVIEW AND MITCHELL
BOISE IDAHO
BUILDING SECTIONS

JOB NO. 93031.01
DATE 9-13-93
DRAWN BY SDH - CHECKED BY SDH
REVISIONS
1 ELEVATION/DETAILS
2 ELEVATION/DETAILS
DATE 2-1-94 4-1-94


SHEET NO.
A4.2
OF SHEETS

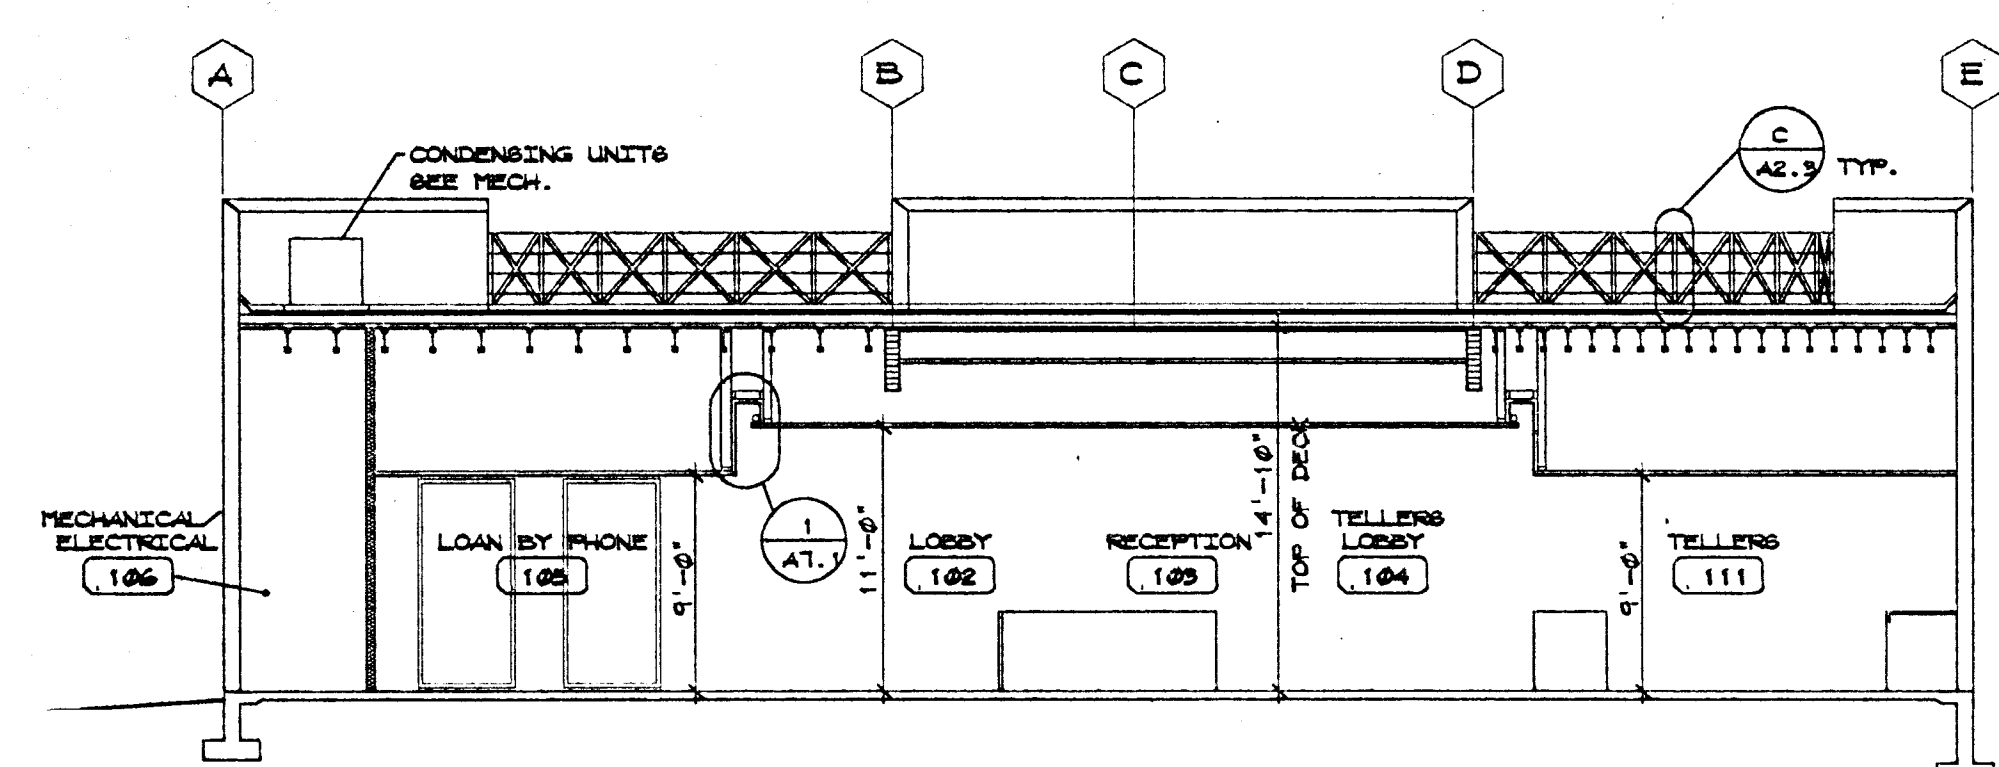


A SECTION A-A
Scale: 1/8" = 1'-0"

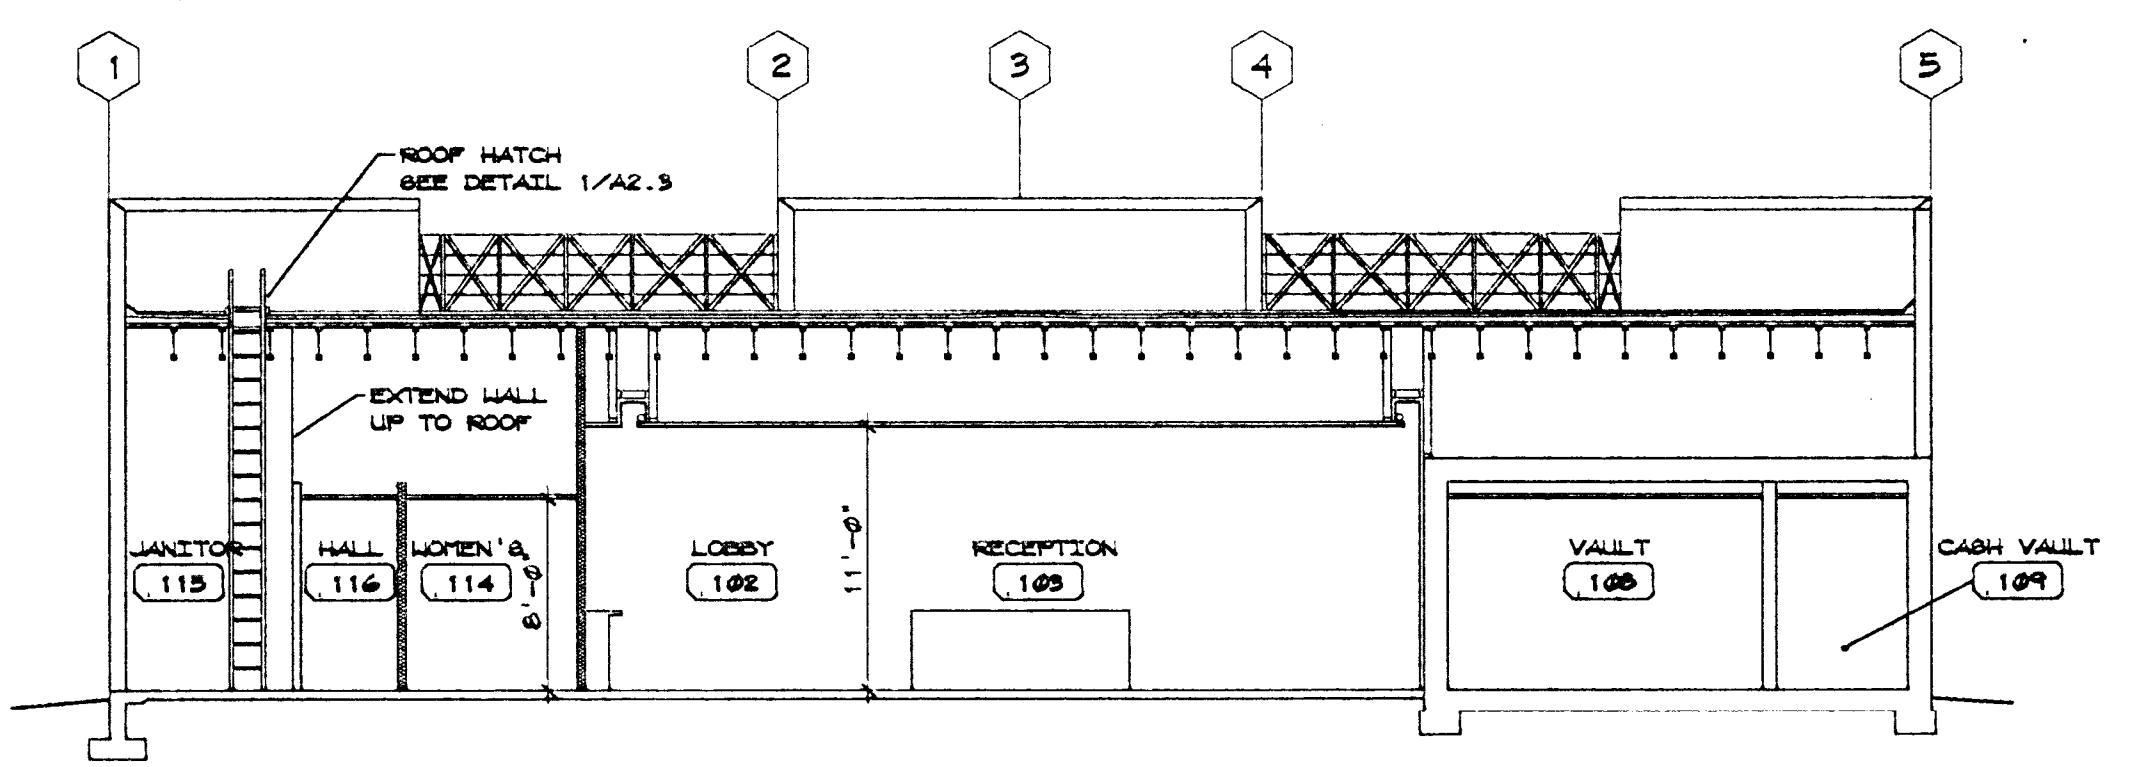

B SECTION B-B
Scale: 1/8" = 1'-0"

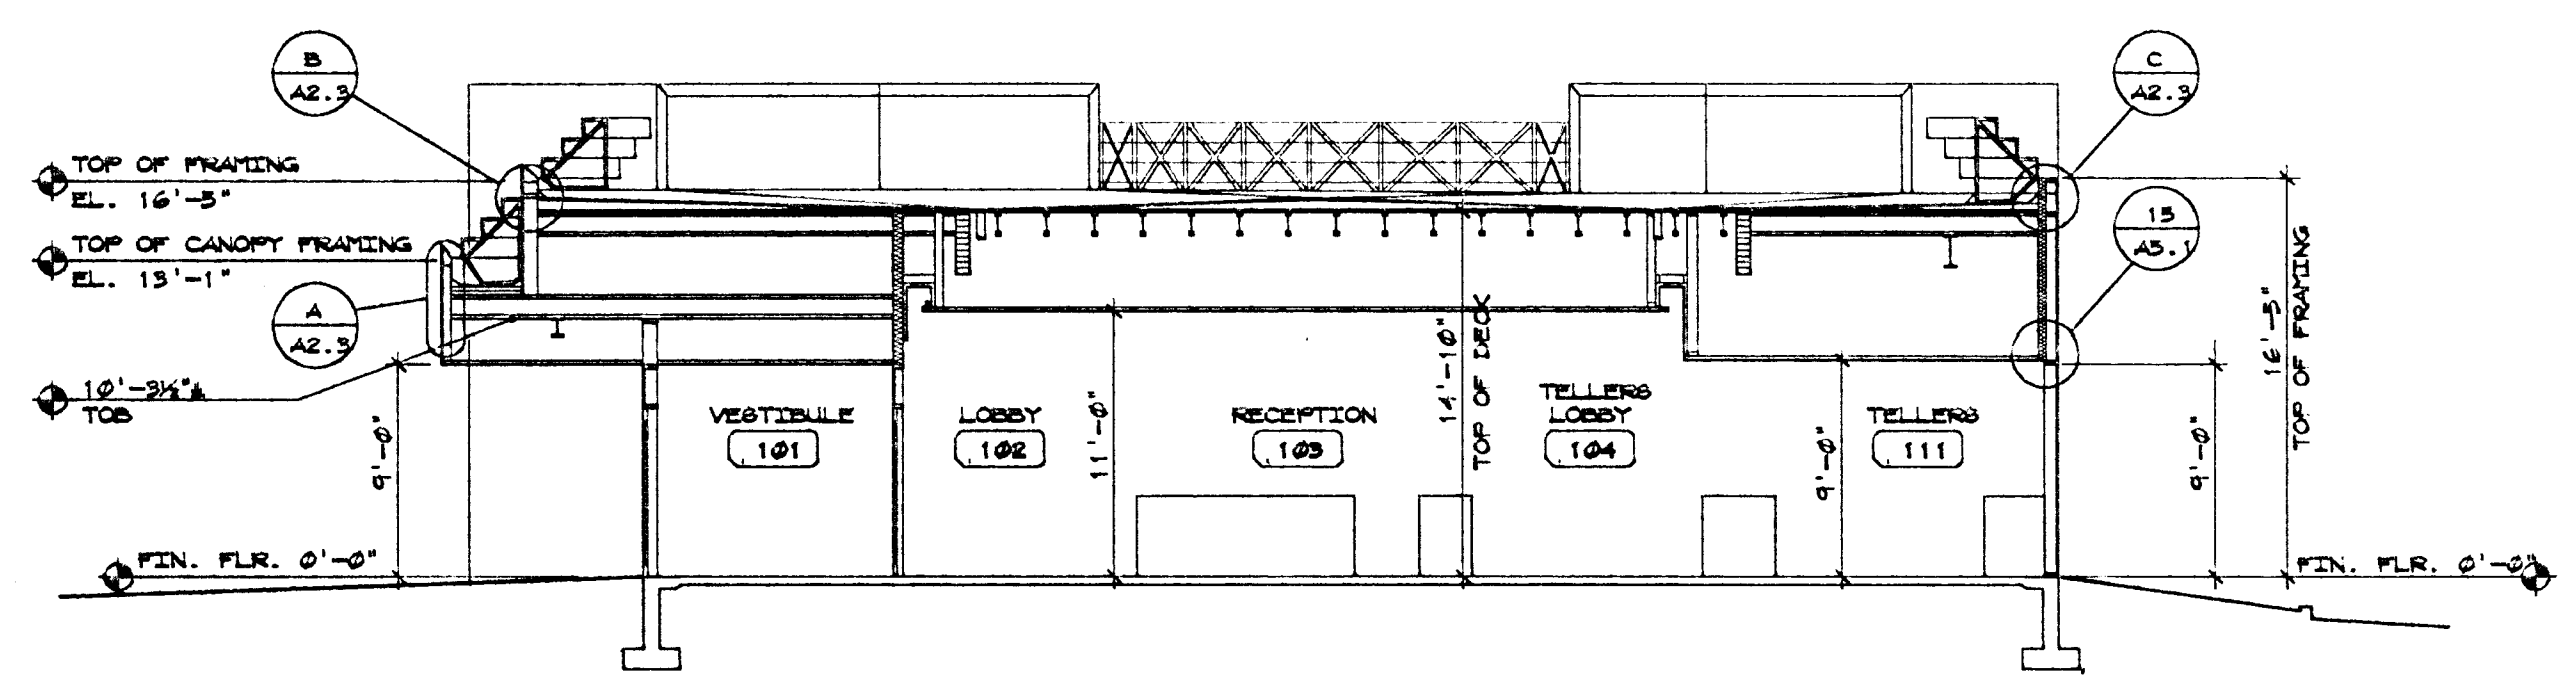


C SECTION C-C
Scale: 1/8" = 1'-0"

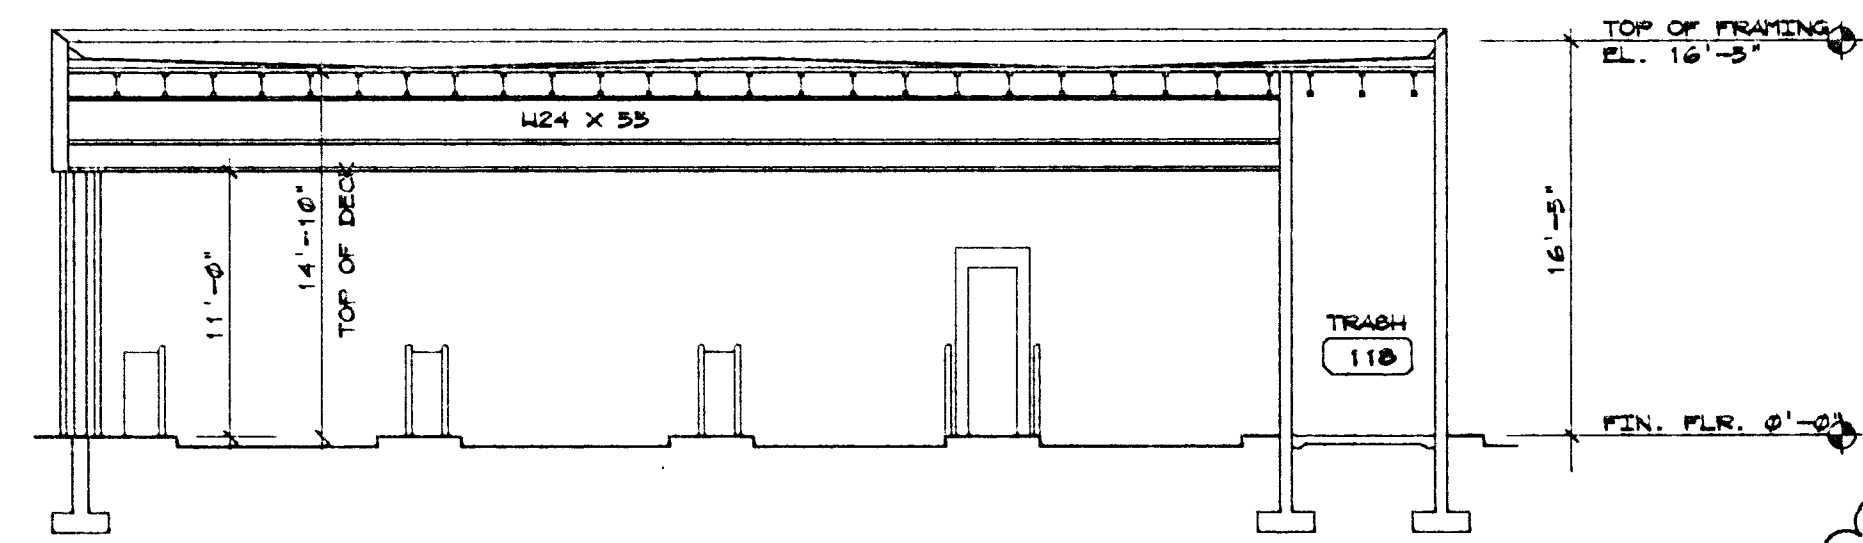


D SECTION D-D
Scale: 1/8" = 1'-0"


NOTE:
INSULATION EXPOSED TO ATTIC AREAS - ALL INSULATION MATERIAL INCLUDING FACINGS ARE REQUIRED TO HAVE A FLAME-SPREAD RATING OF 25 OR LESS AND A MAXIMUM SMOKE DENSITY OF 450 MAXIMUM. UBC SEC 1713 (A)
GENERAL NOTE:
FIRESTOPPING SHALL BE PROVIDED IN THE FOLLOWING LOCATIONS: IN CONCEALED SPACES OF STUD WALLS AND PARTITIONS, INCLUDING TURNED SPACES, AT CEILING AND FLOOR LEVELS AND AT 10' INTERVALS
ALONG THE WALL, SOFFITS, DROPPED AND COVERED CEILING. UBC SEC 2516 (F).

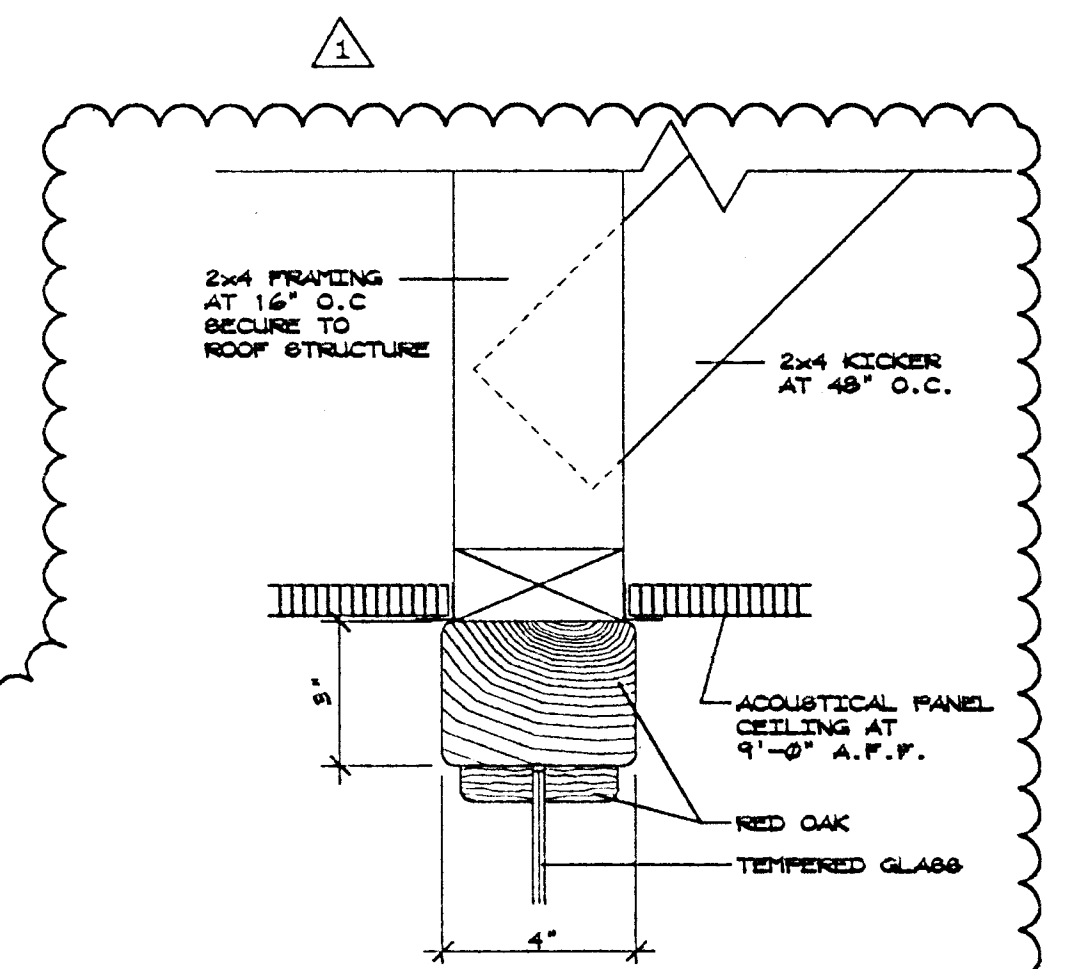


9 WINDOW HEAD
Scale: 3" = 1'-0"

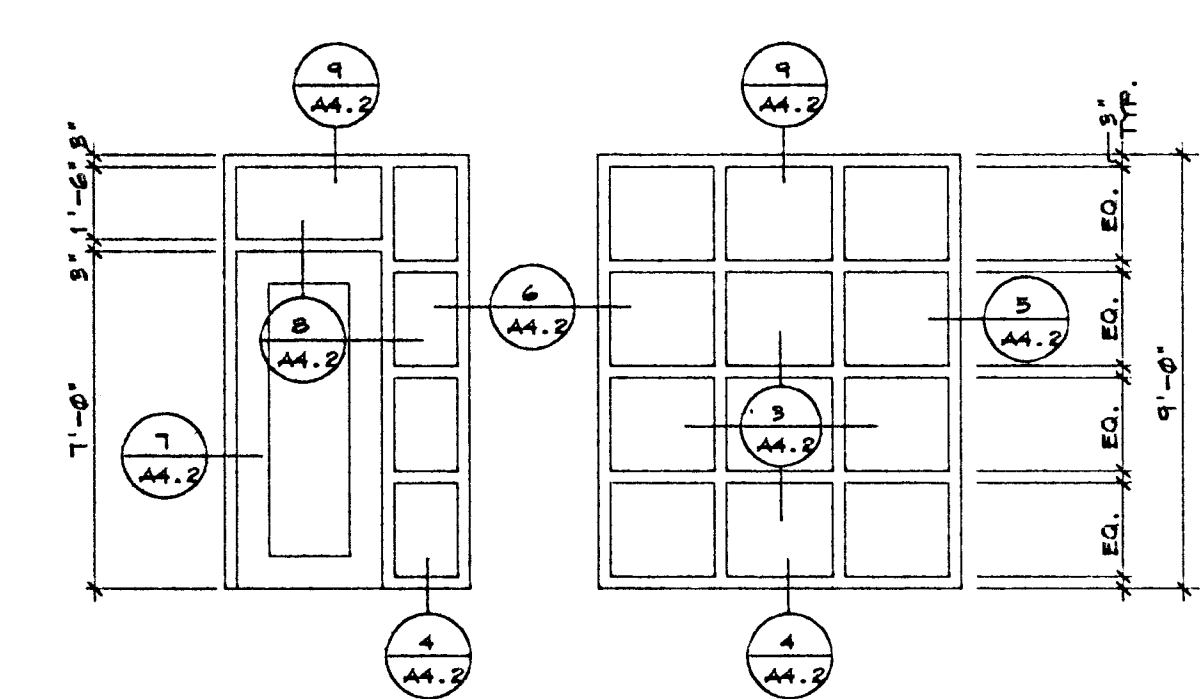


1 WINDOW/DOOR ELEVATION
Scale: 1/4" = 1'-0"

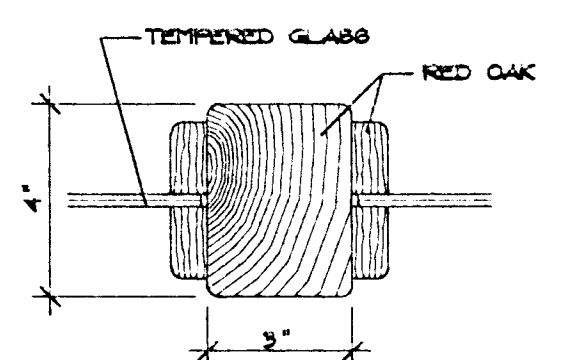


3 WINDOW JAMB
Scale: 3" = 1'-0"

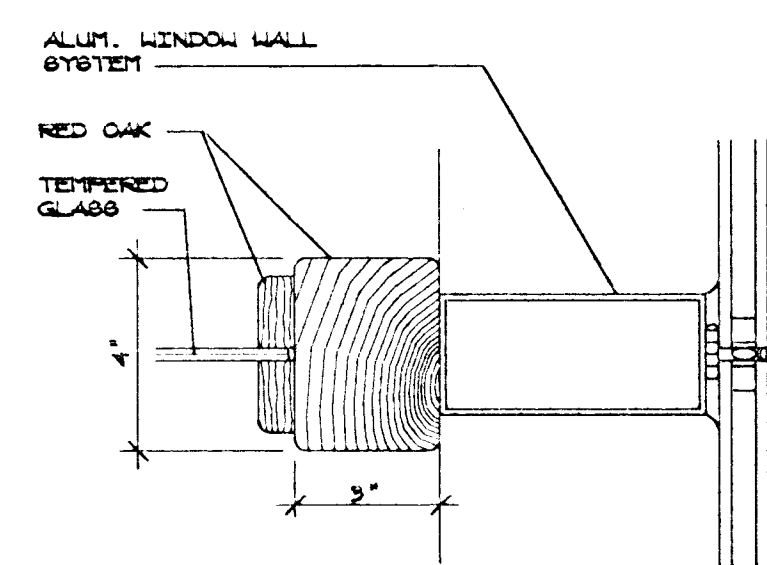


5 WINDOW JAMB
Scale: 3" = 1'-0"

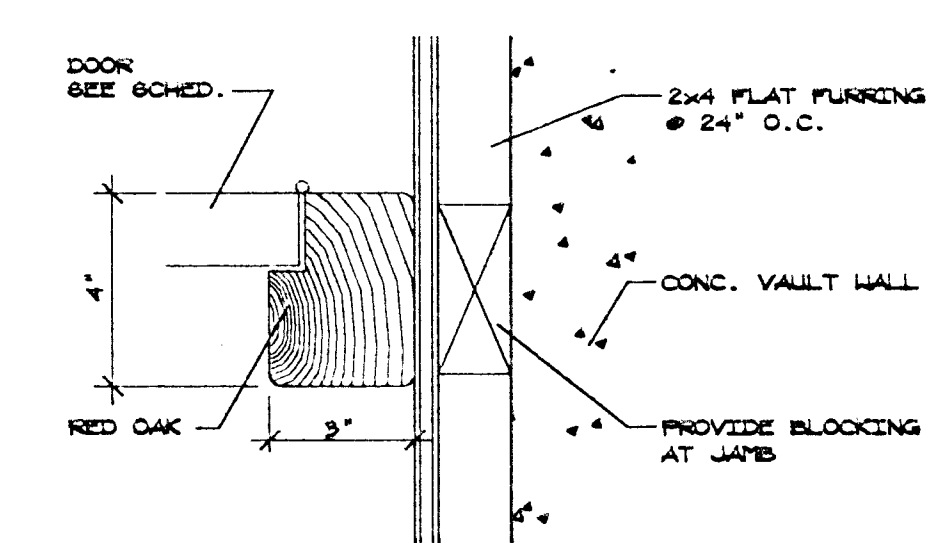


7 DOOR JAMB
Scale: 3" = 1'-0"

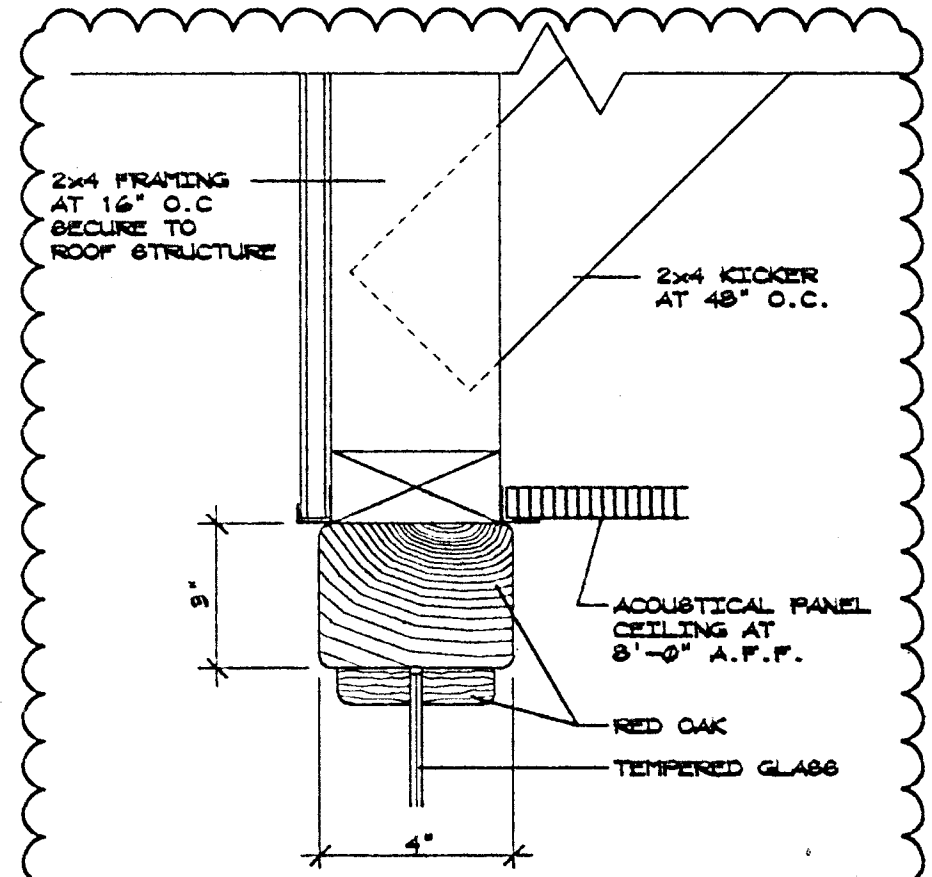


10 WINDOW HEAD
Scale: 3" = 1'-0"

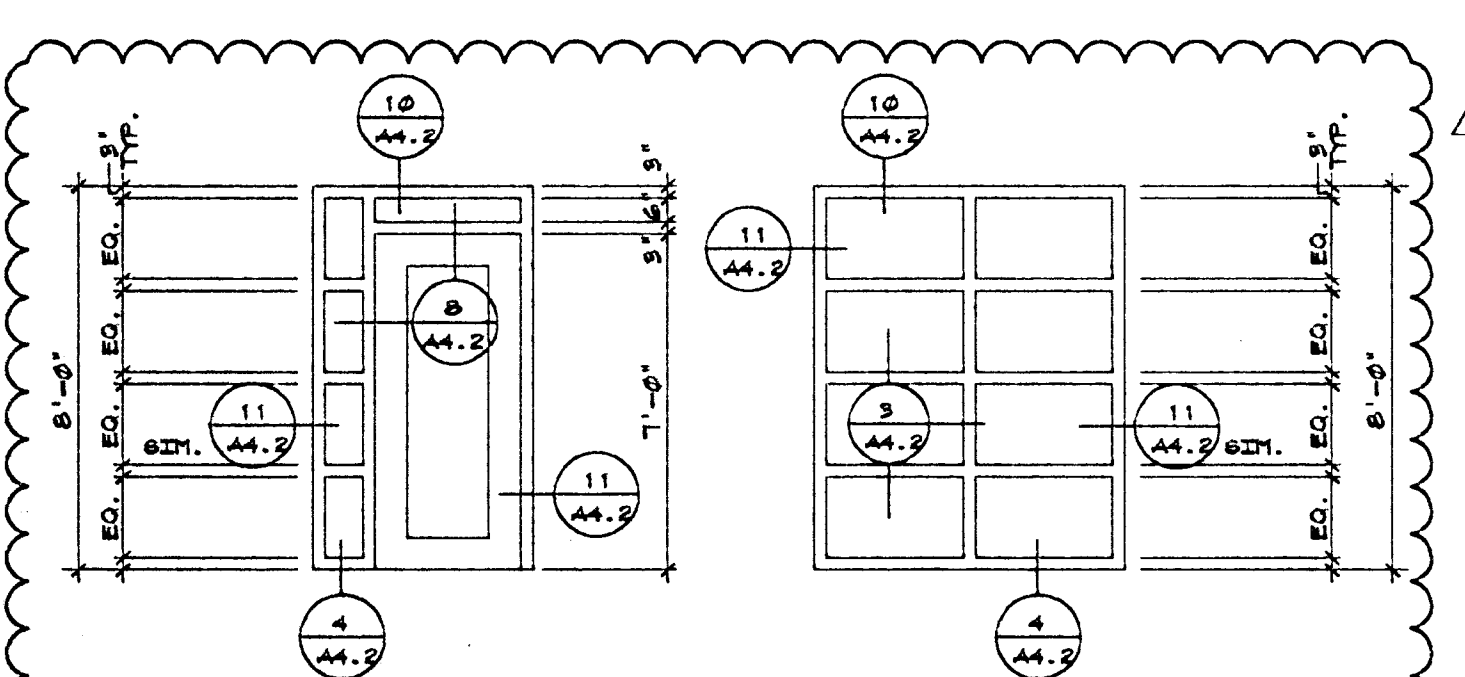


2 WINDOW/DOOR ELEVATION
Scale: 1/4" = 1'-0"

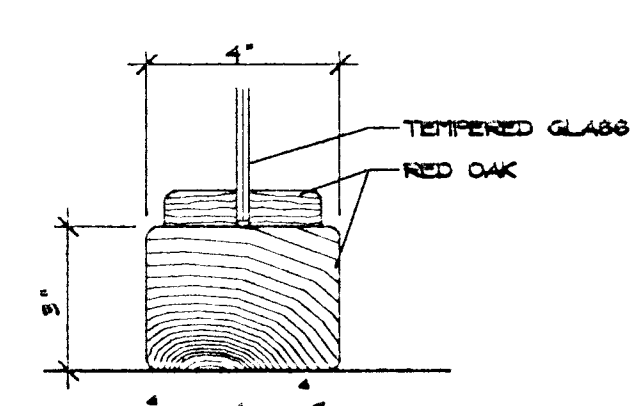


4 WINDOW SILL
Scale: 3" = 1'-0"

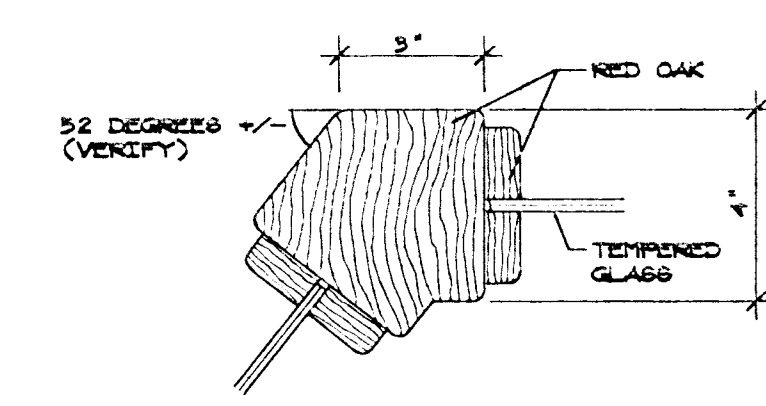


6 WINDOW JAMB
Scale: 3" = 1'-0"

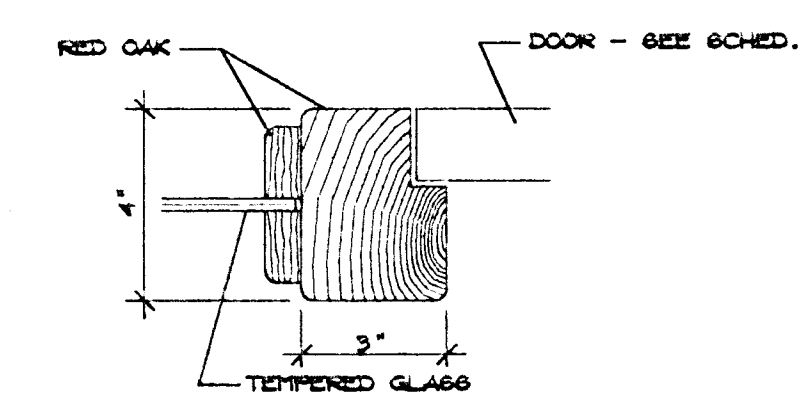




8 WINDOW/DOOR JAMB
Scale: 3" = 1'-0" HEAD SIM.

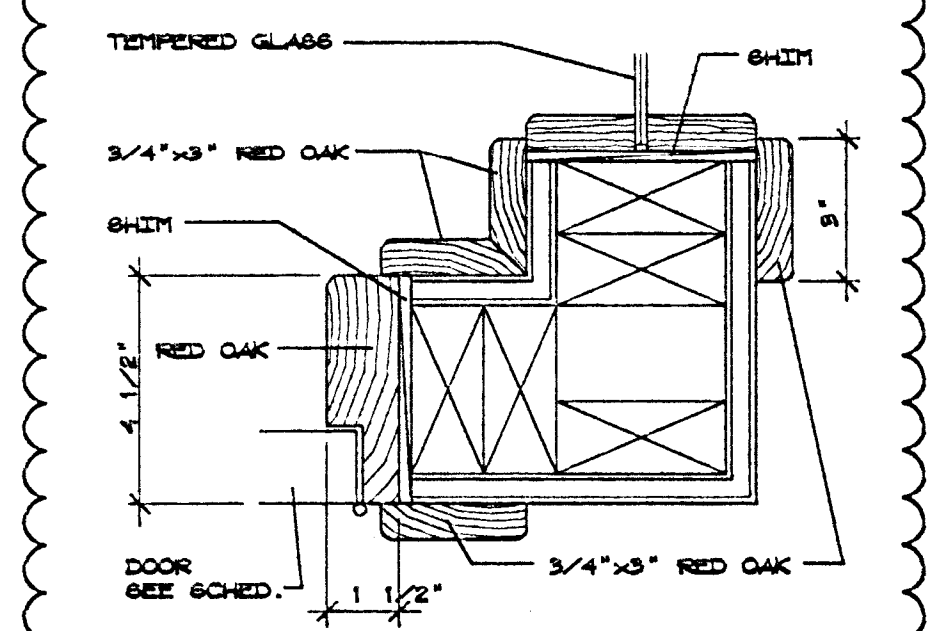


11 DOOR/WINDOW JAMB
Scale: 3" = 1'-0"

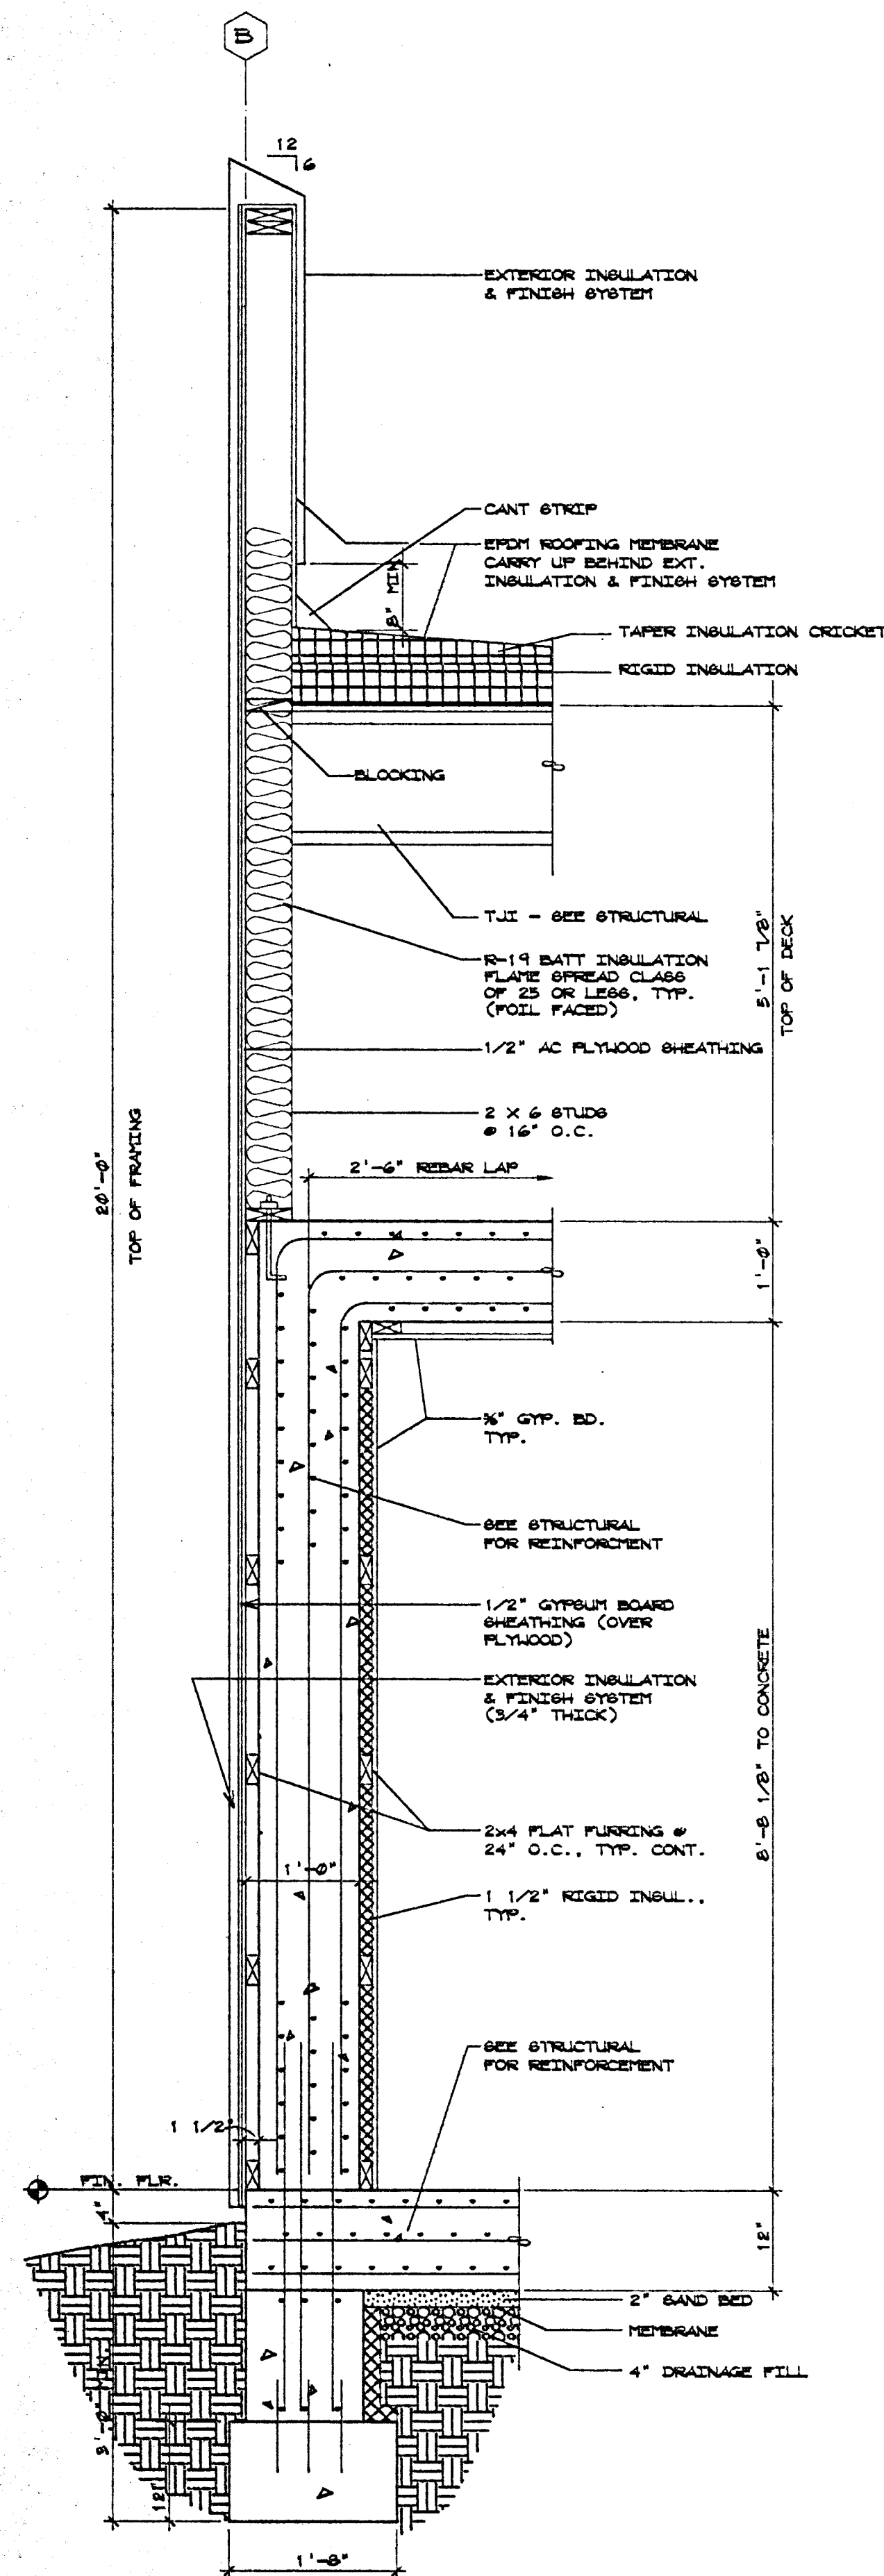

NOTE: PROVIDE CONTINUOUS 2 x 4 BLOCKING AT ALL EDGES
OF ALL PLYWOOD ROOF SHEATHING PANELS PER
U.B.C. 1991 SEC. 1713.3

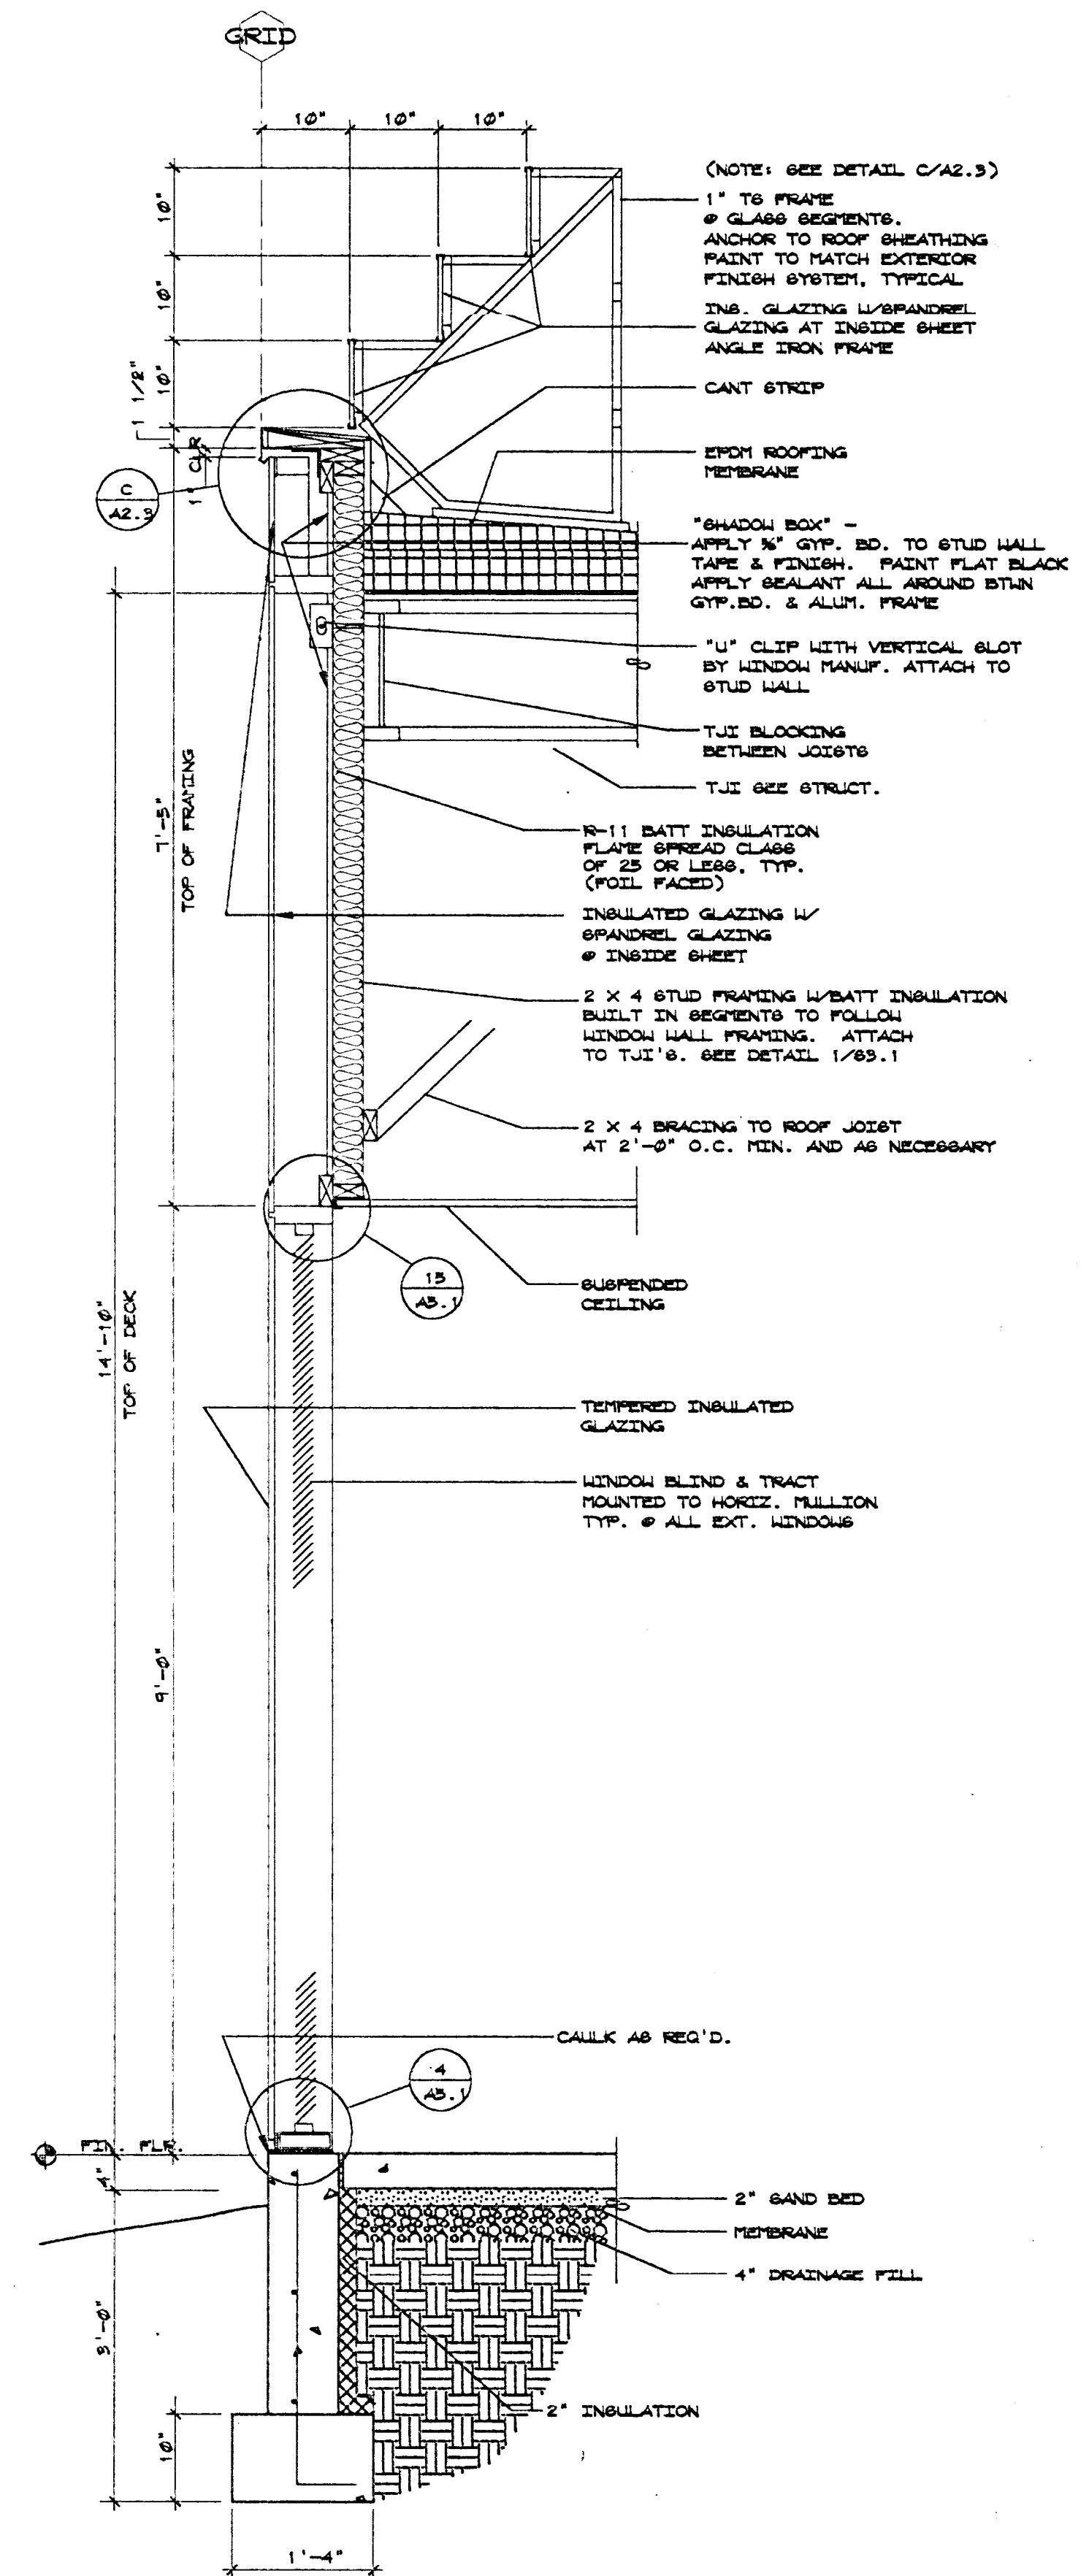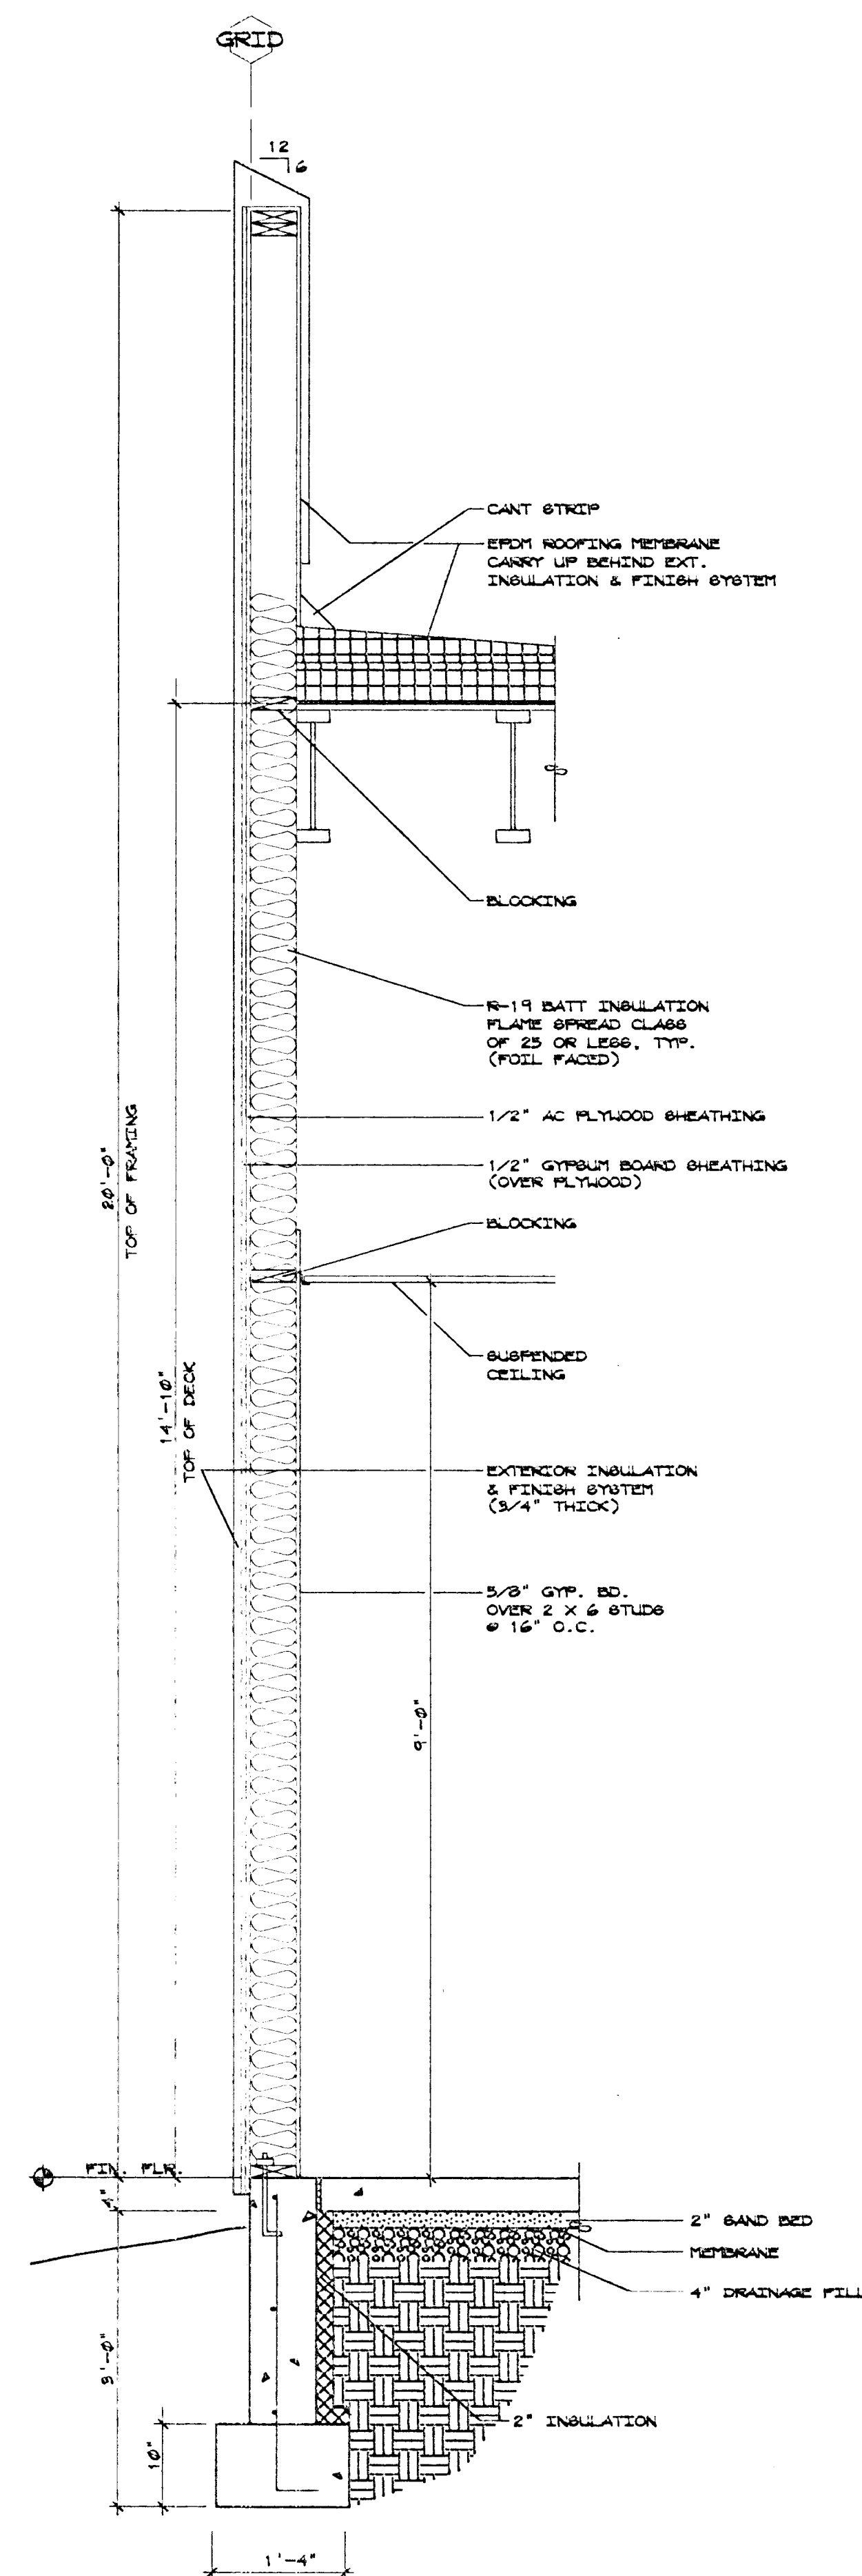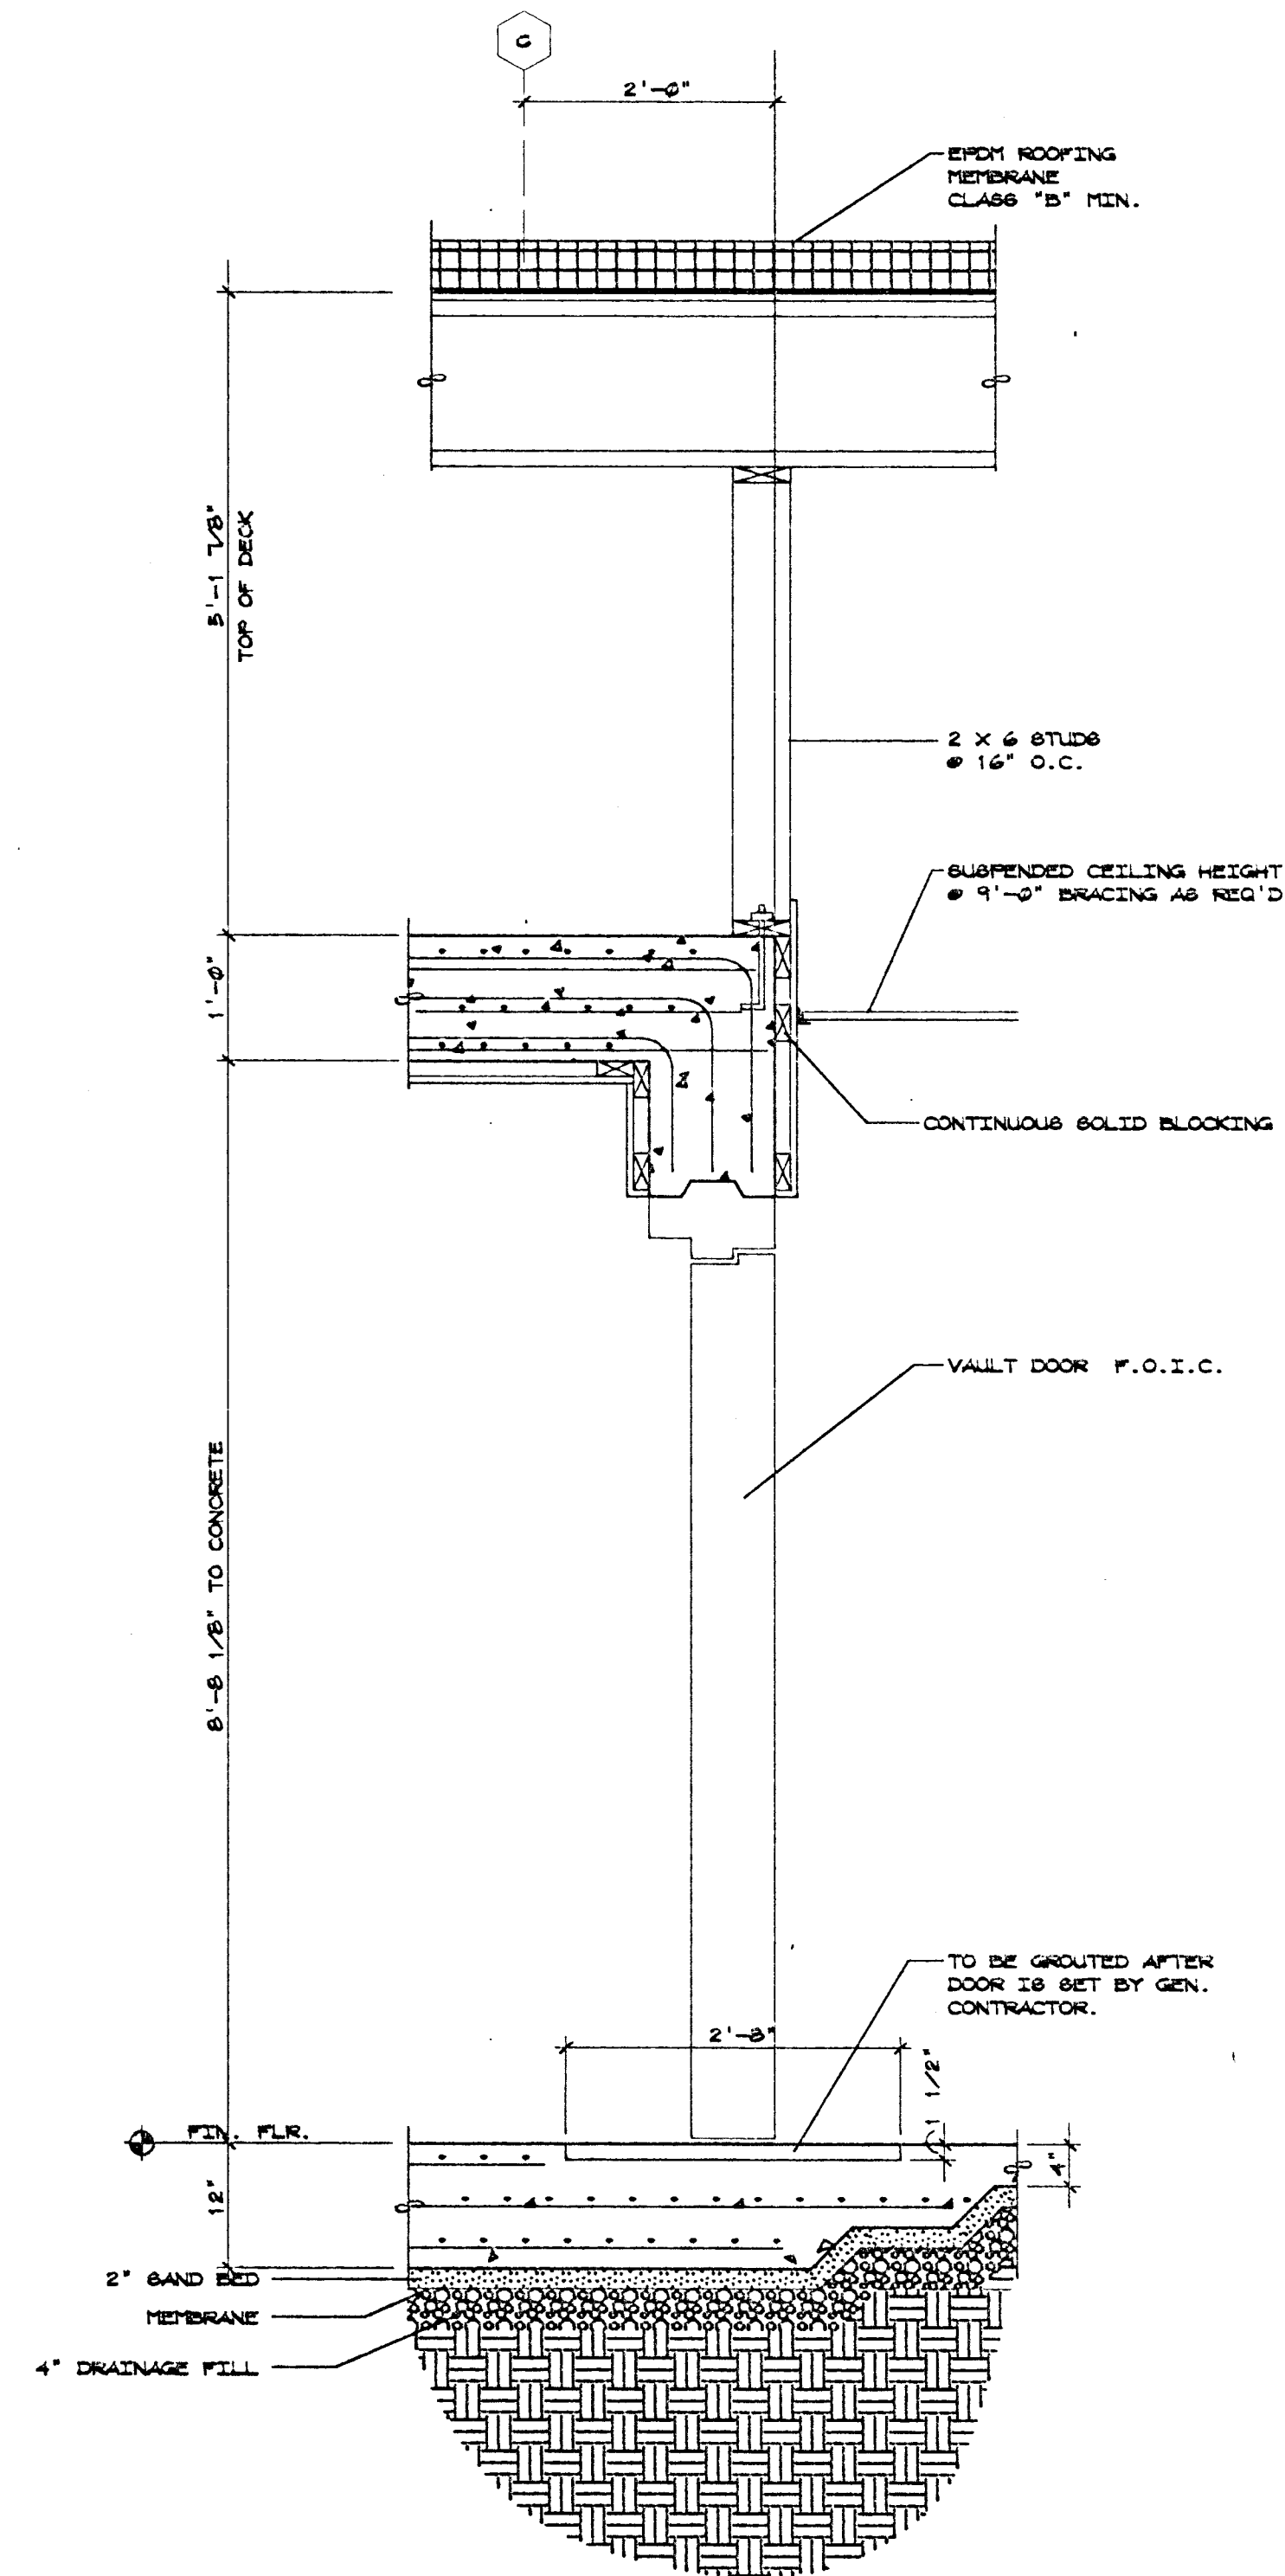

**COPYRIGHT 1993
LONBARD-CONRAD ARCHITECTS**
All rights reserved. Reproduction or
translation of any part of this work
without written permission of
LONBARD-CONRAD ARCHITECTS is unlawful
and subject to criminal prosecution.

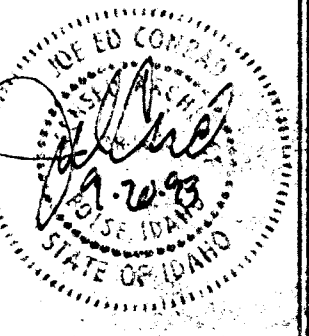


Lombard-Conrad
ARCHITECTS P. A., A. I. A.
1221 SHORELINE LANE BOISE, IDAHO 83742 TEL. (208)345-6677

FAIRVIEW AND MITCHELL BOISE IDAHO WALL SECTIONS




NO. 93031.01	
E 9-13-93	
IN BY CM	CHECKED BY BDH
SIONS	DATE

T NO.
A4 . 3
 SHEETS

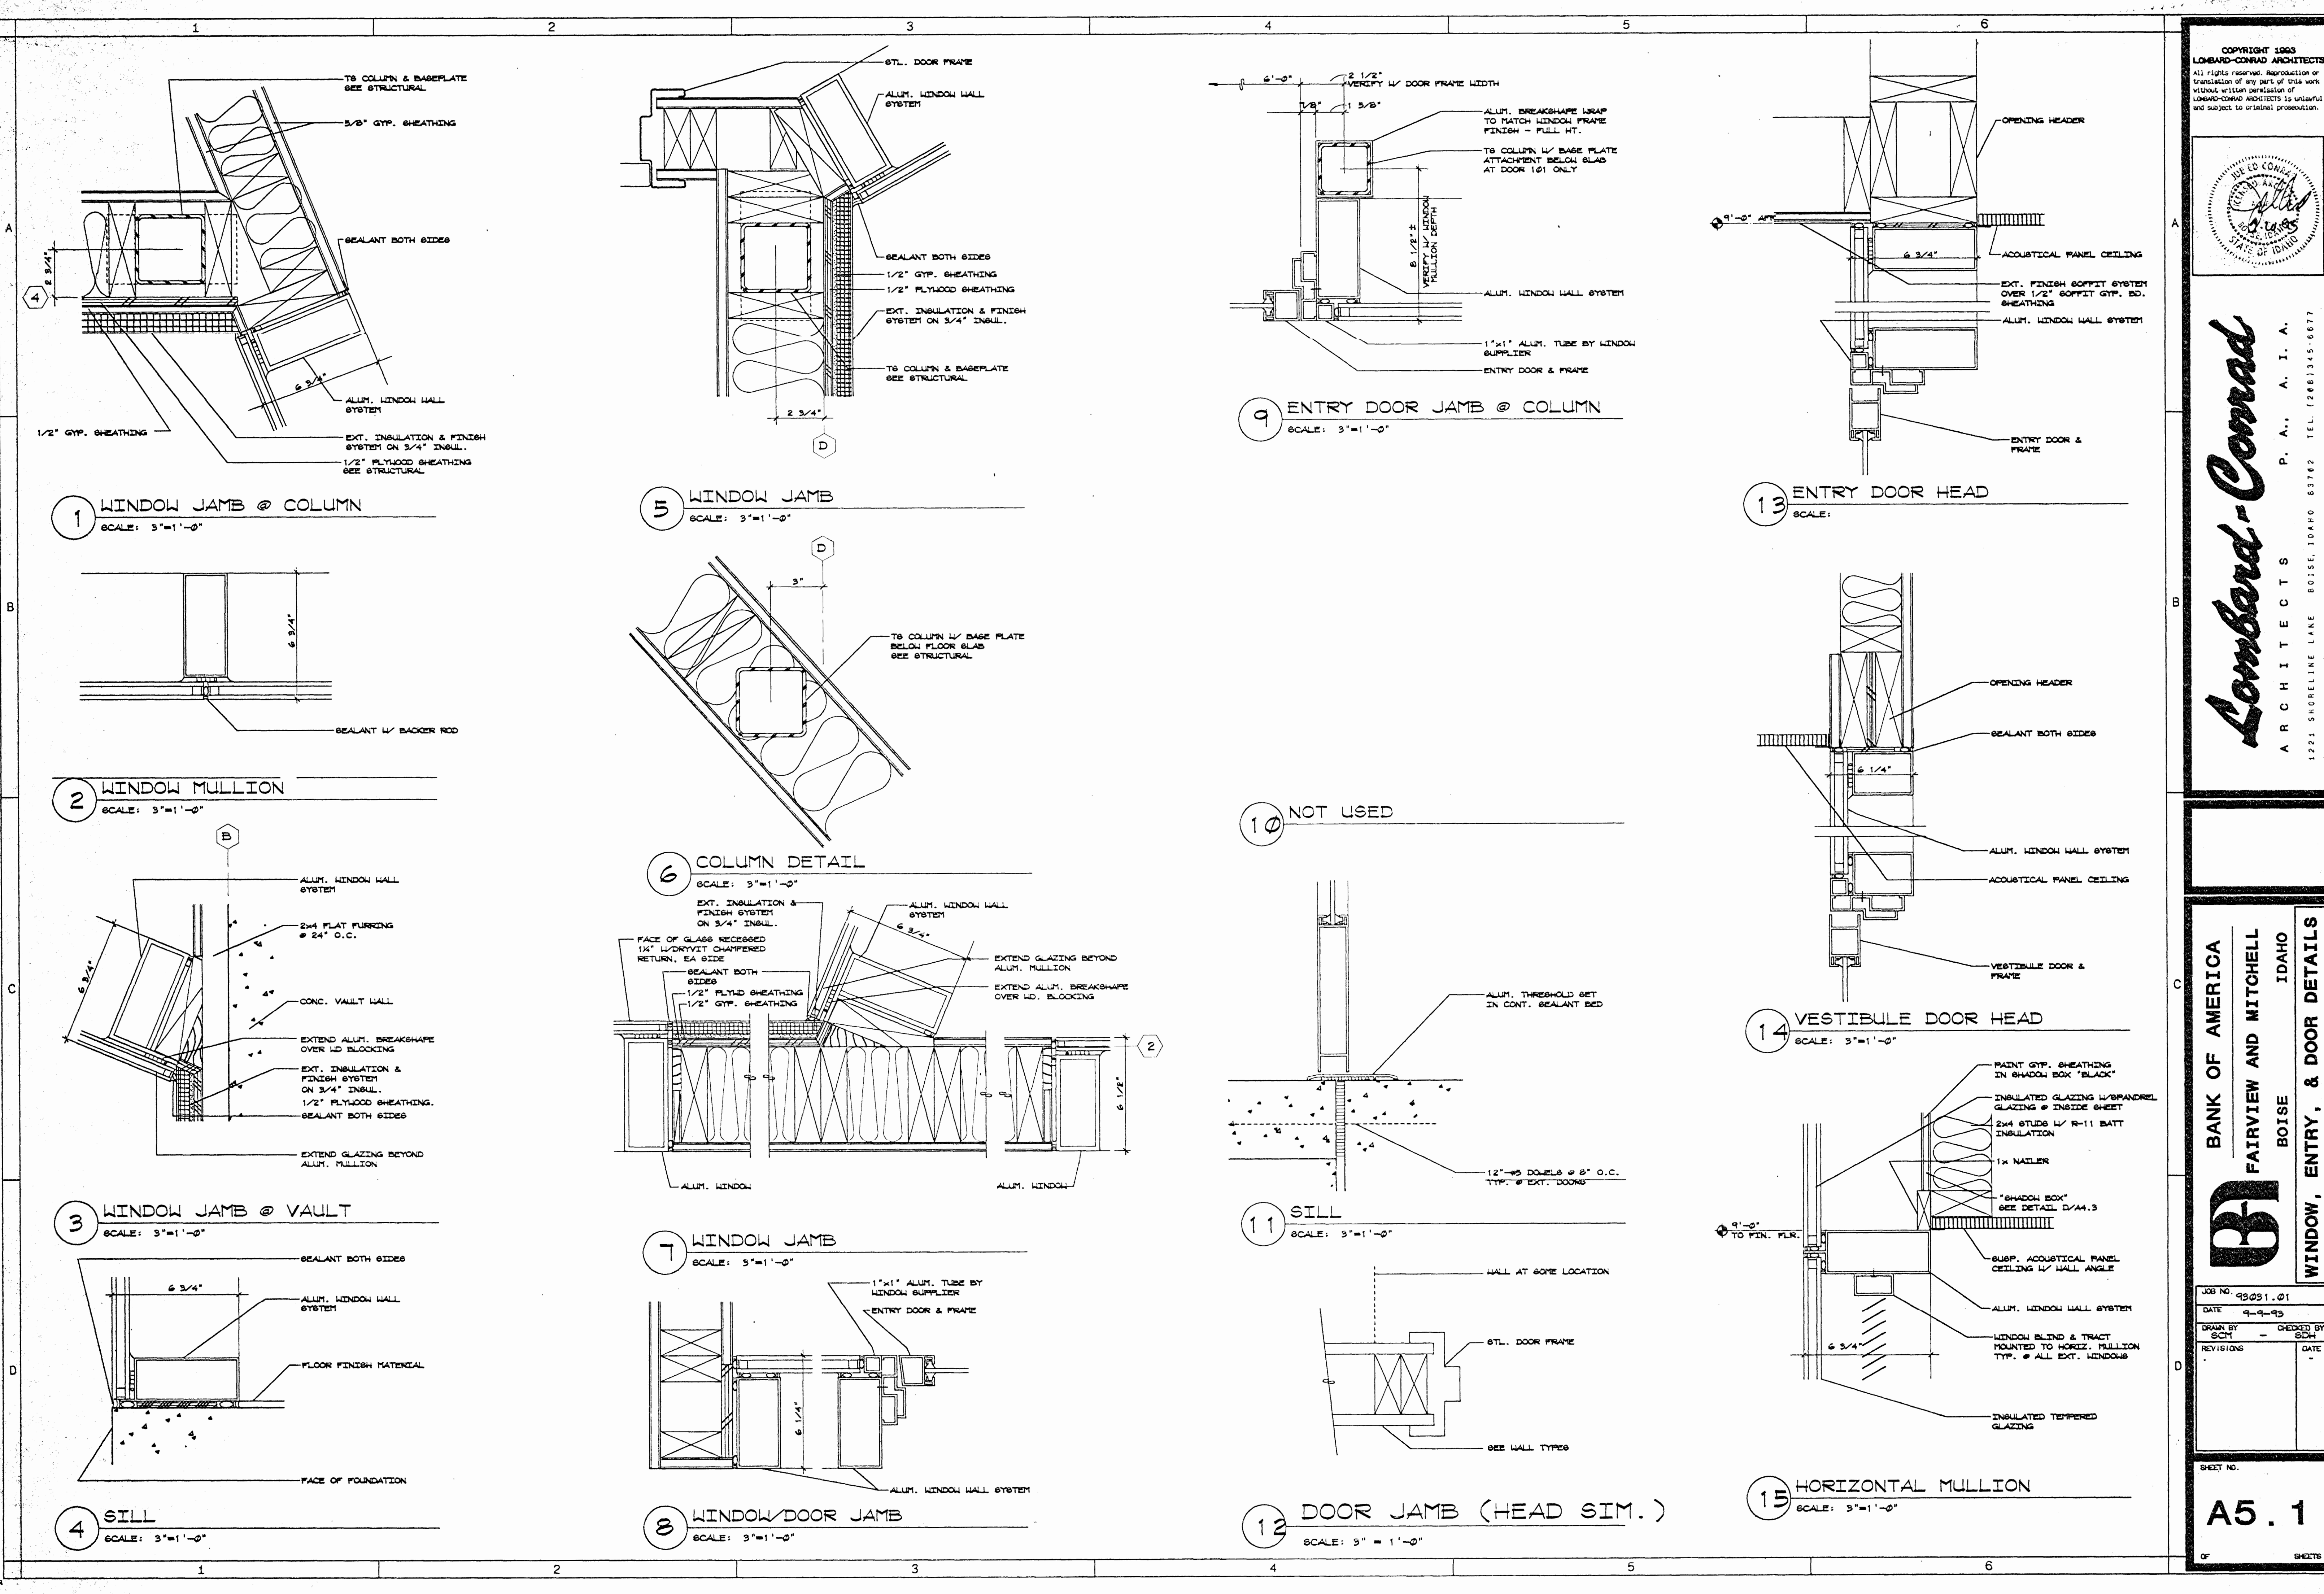


COPYRIGHT 1993
LOWEARD-CONRAD ARCHITECTS
All rights reserved. Reproduction or translation of any part of this work without written permission of LOWEARD-CONRAD ARCHITECTS is unlawful and subject to criminal prosecution.

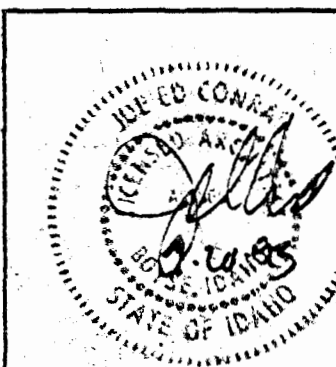

Loweard-Conrad
 ARCHITECTS
 P. A., A. I. A.
 1221 SHORELINE LANE BOISE, IDAHO 83762 TEL. (208) 345-6677

BANK OF AMERICA
FAIRVIEW AND MITCHELL
 BOISE IDAHO
WINDOW, ENTRY, & DOOR DETAILS


JOB NO. 93051.01
 DATE 9-9-93
 DRAWN BY SCH
 CHECKED BY SCH
 REVISIONS
 SHEET NO. **A5.1**
 OF SHEETS

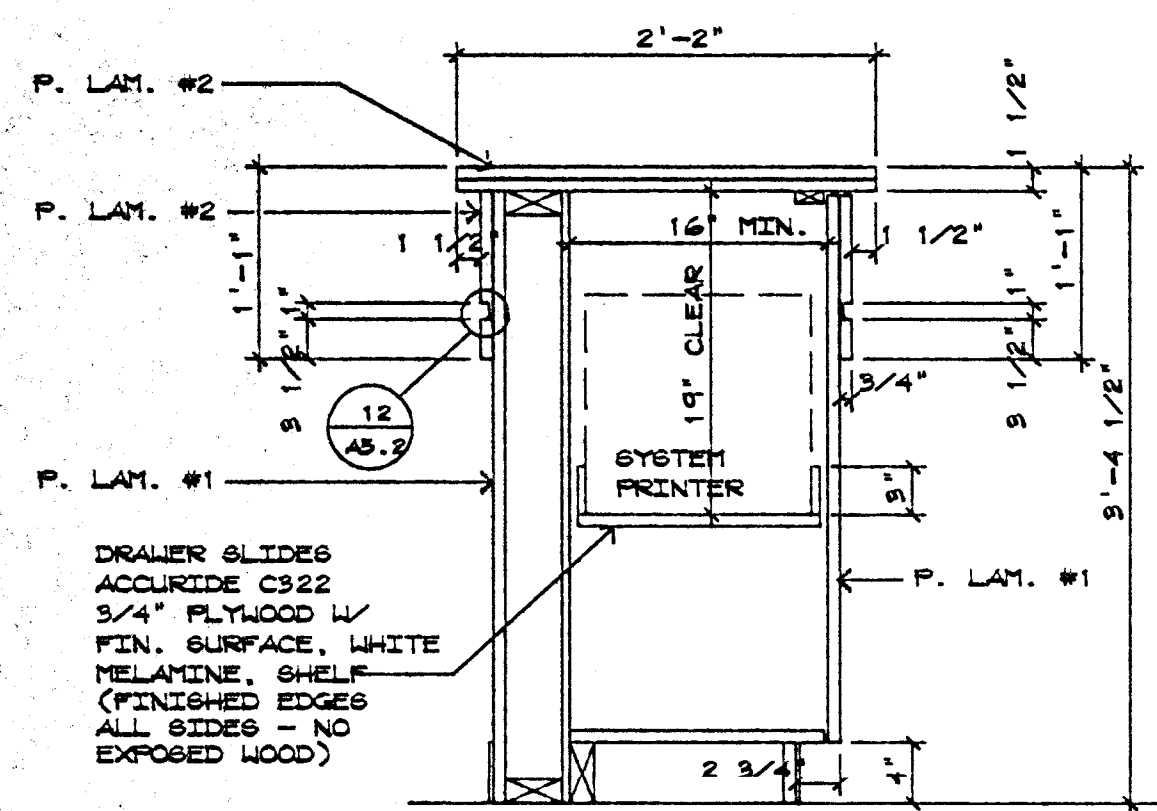


1 REAR REC. COUNTER
SCALE: 1" = 1'-0"

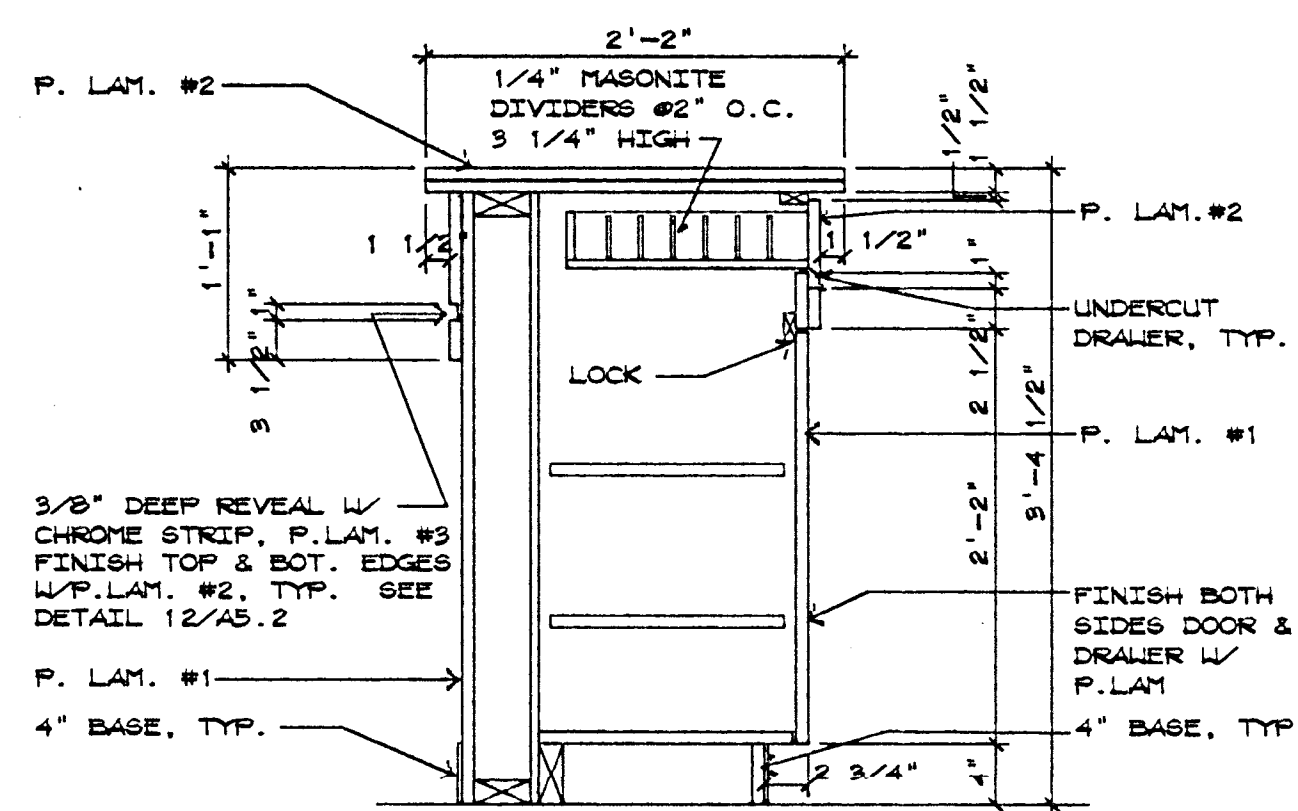


2 REAR REC. COUNTER
SCALE: 1" = 1'-0"

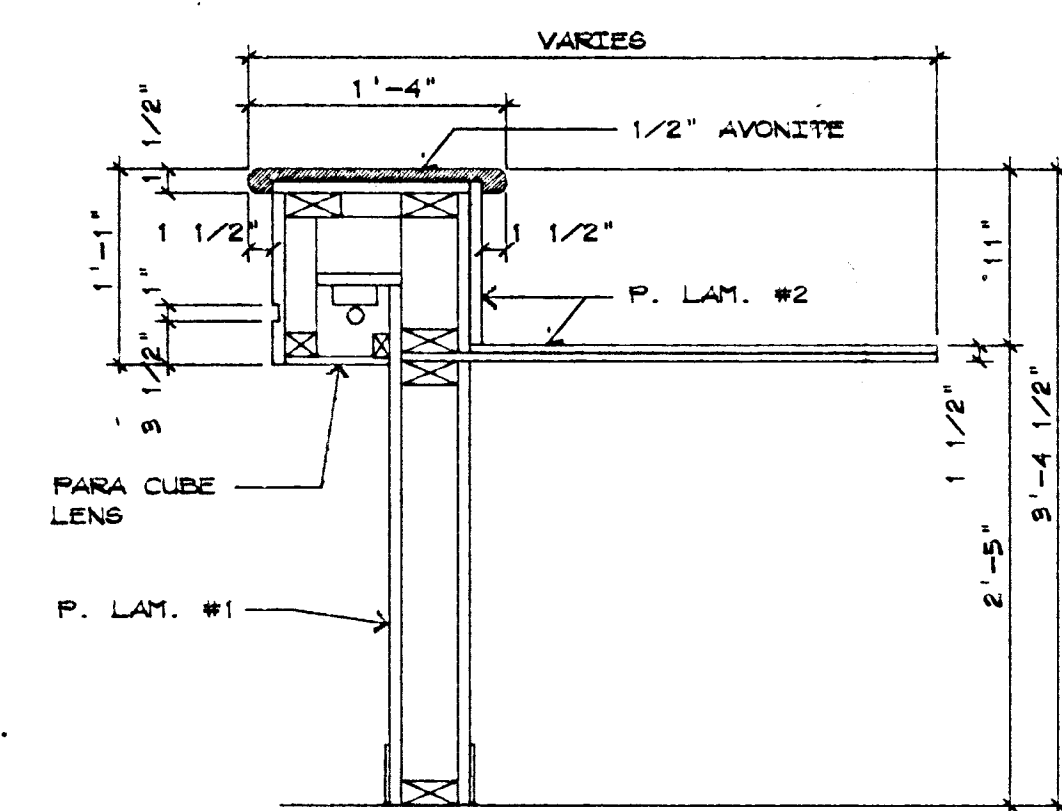


3 FRONT REC. COUNTER
SCALE: 1" = 1'-0"

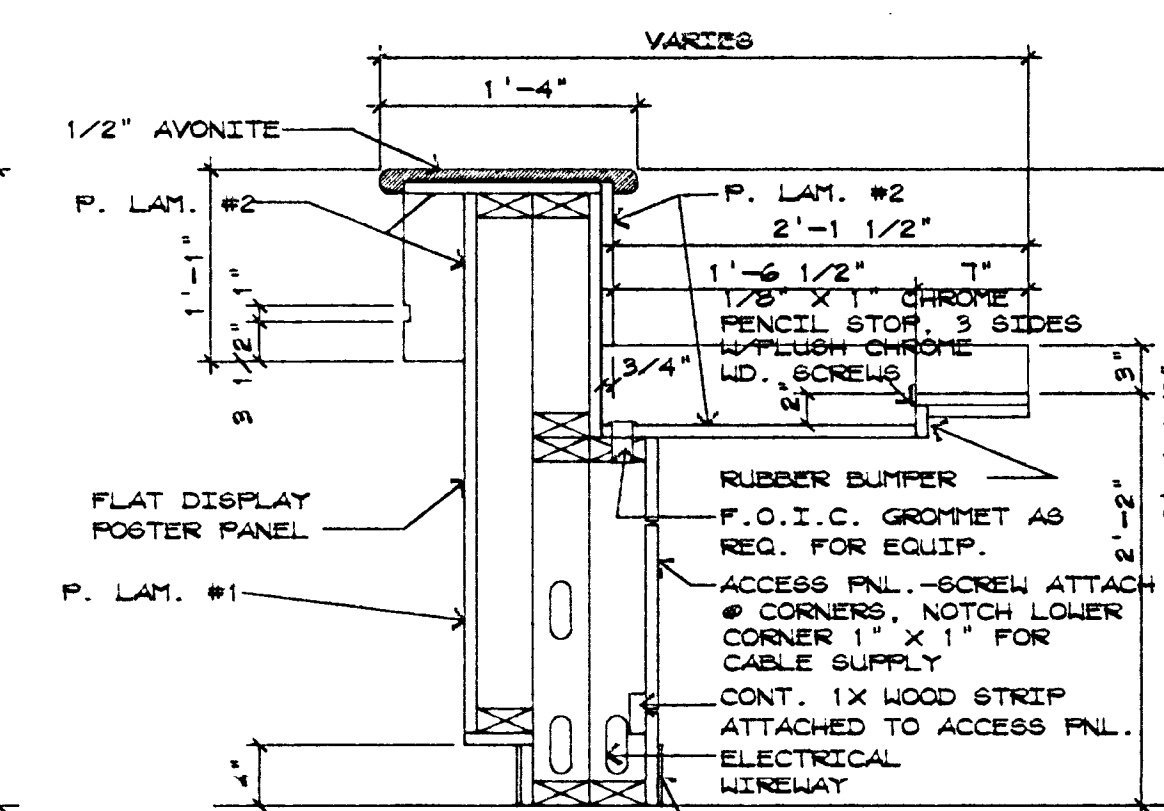


4 FRONT REC. COUNTER
SCALE: 1" = 1'-0"

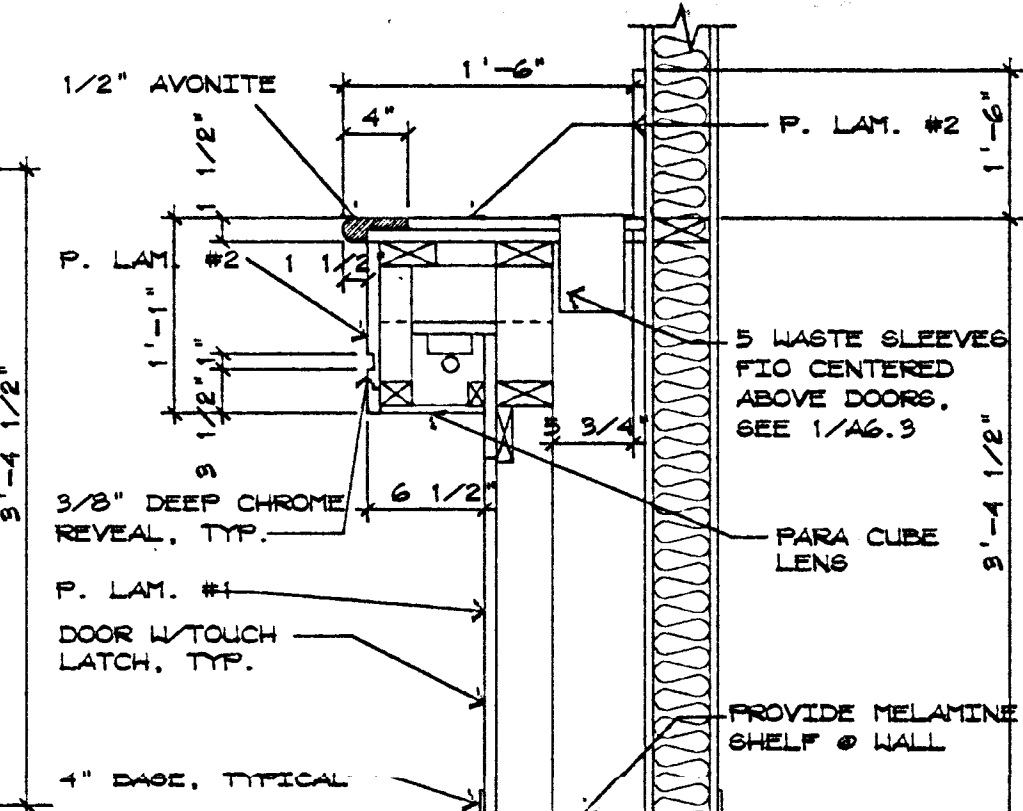


5 MERCHANDISING WALL
SCALE: 1" = 1'-0"

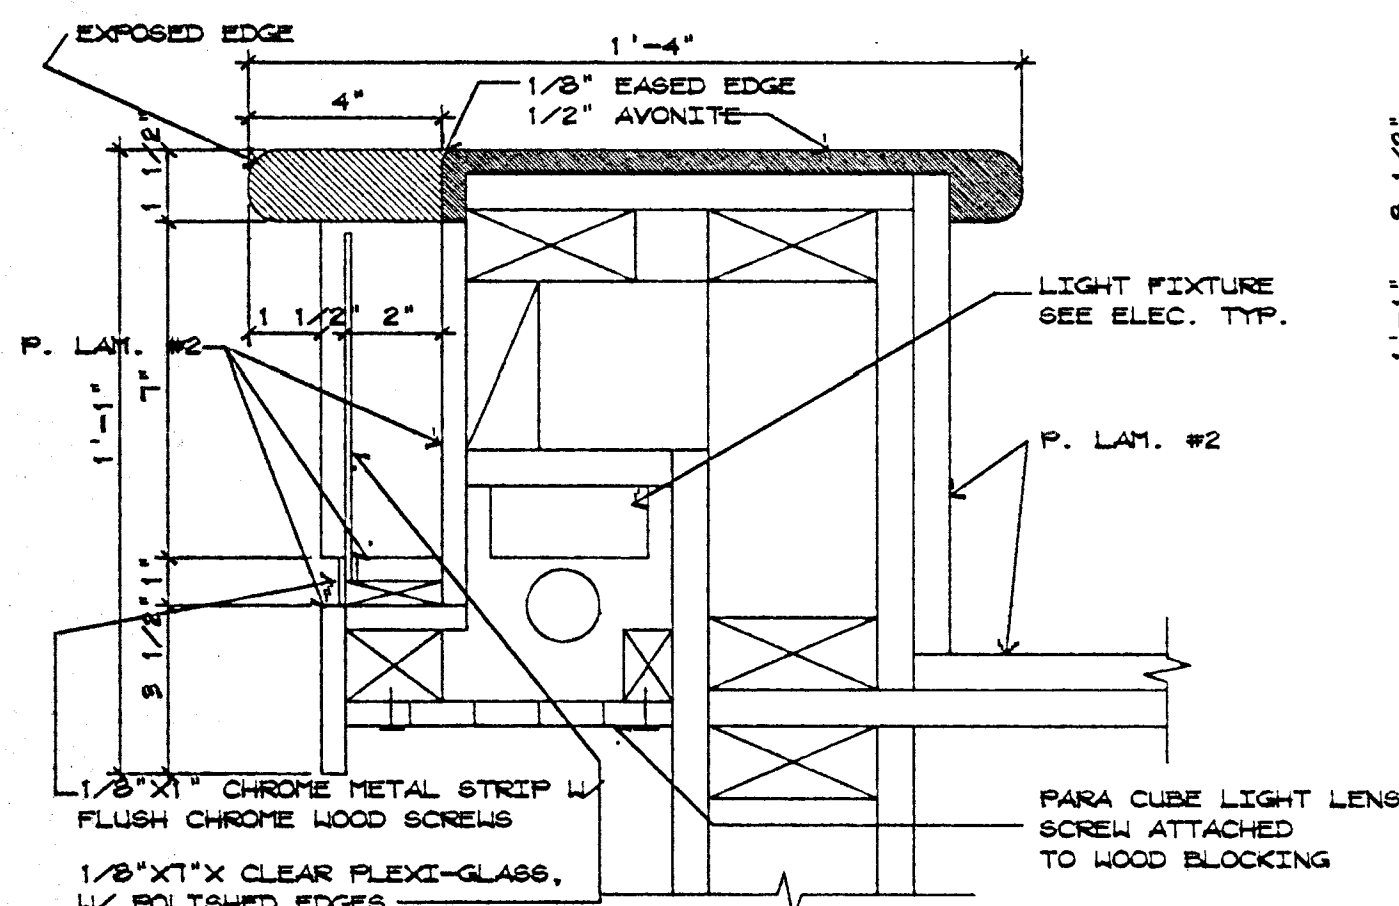


6 PAMPHLET DISPLAY
SCALE: 3" = 1'-0"

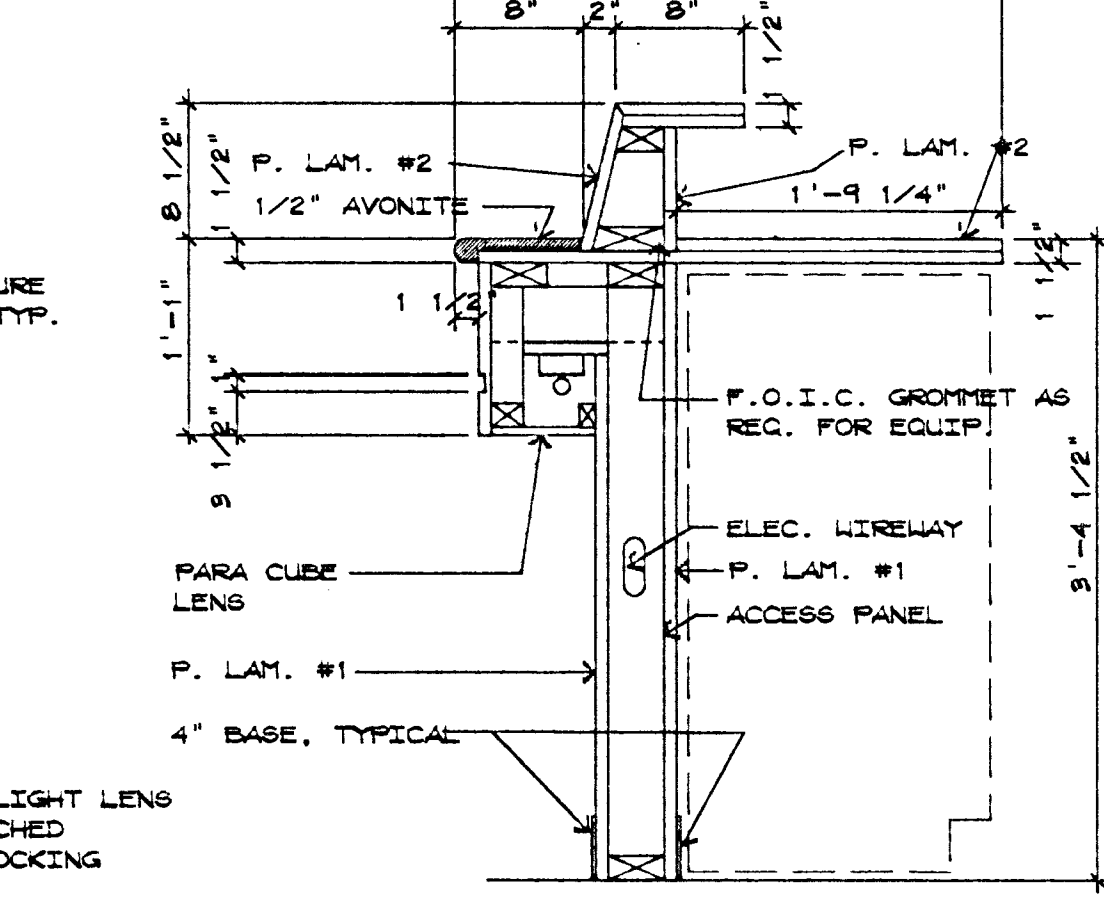


7 TELLER LINE
SCALE: 1" = 1'-0"

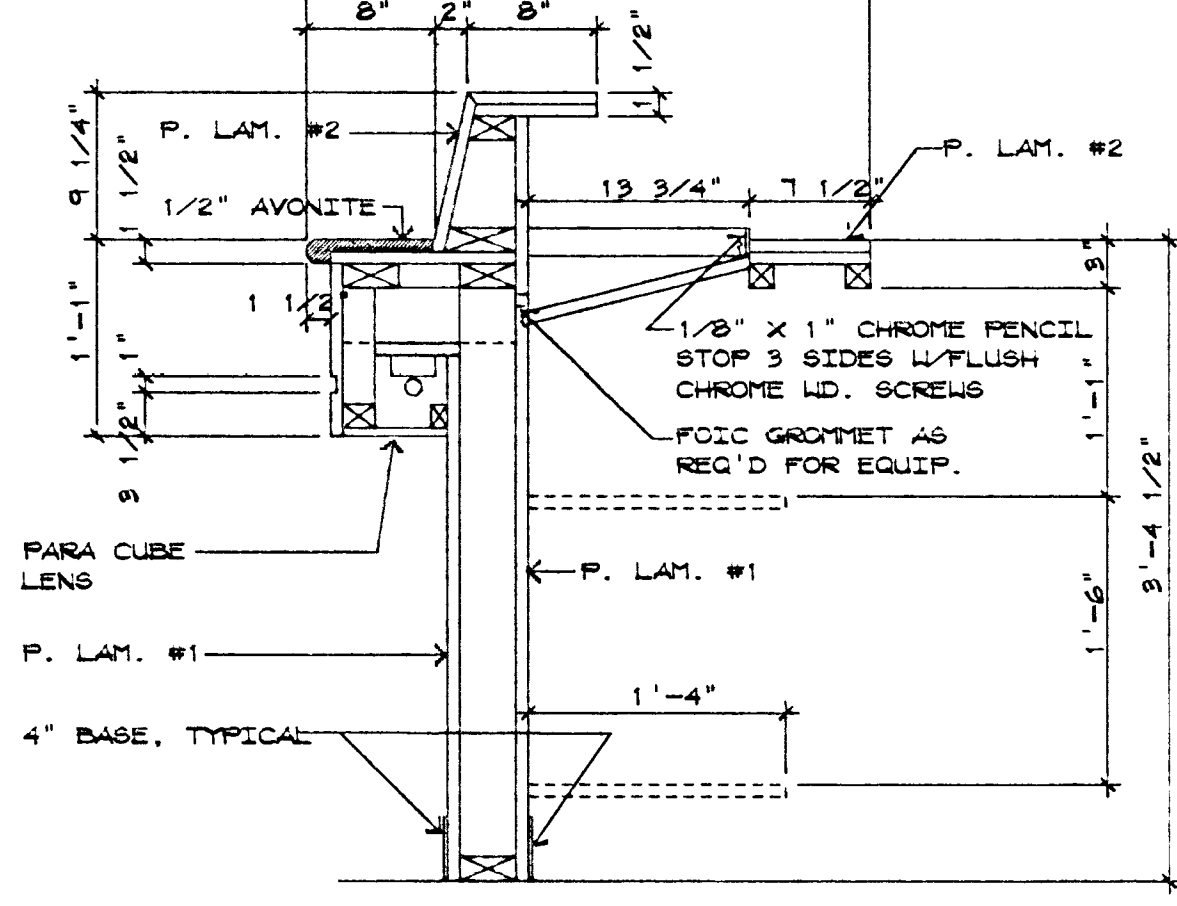


8 TELLER TERMINAL
SCALE: 1" = 1'-0"

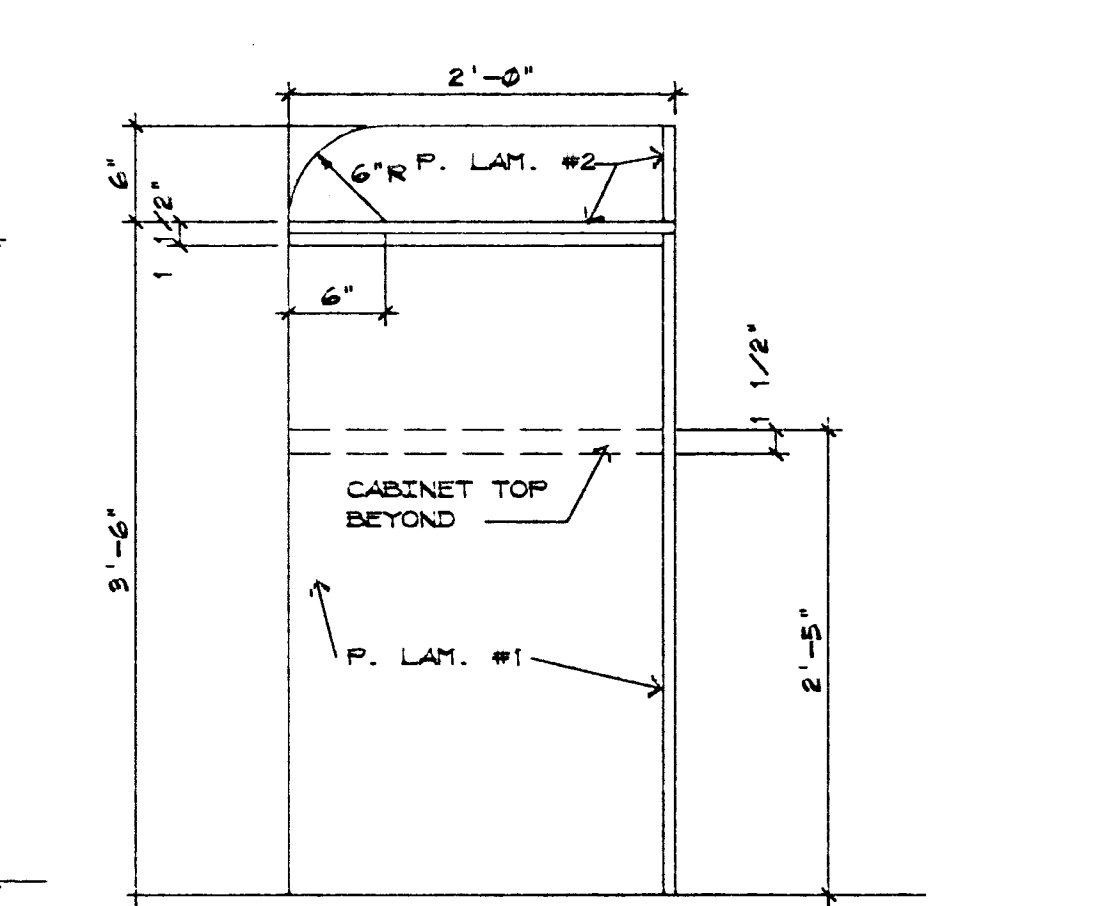


9 VAULT CABINET
SCALE: 1" = 1'-0"

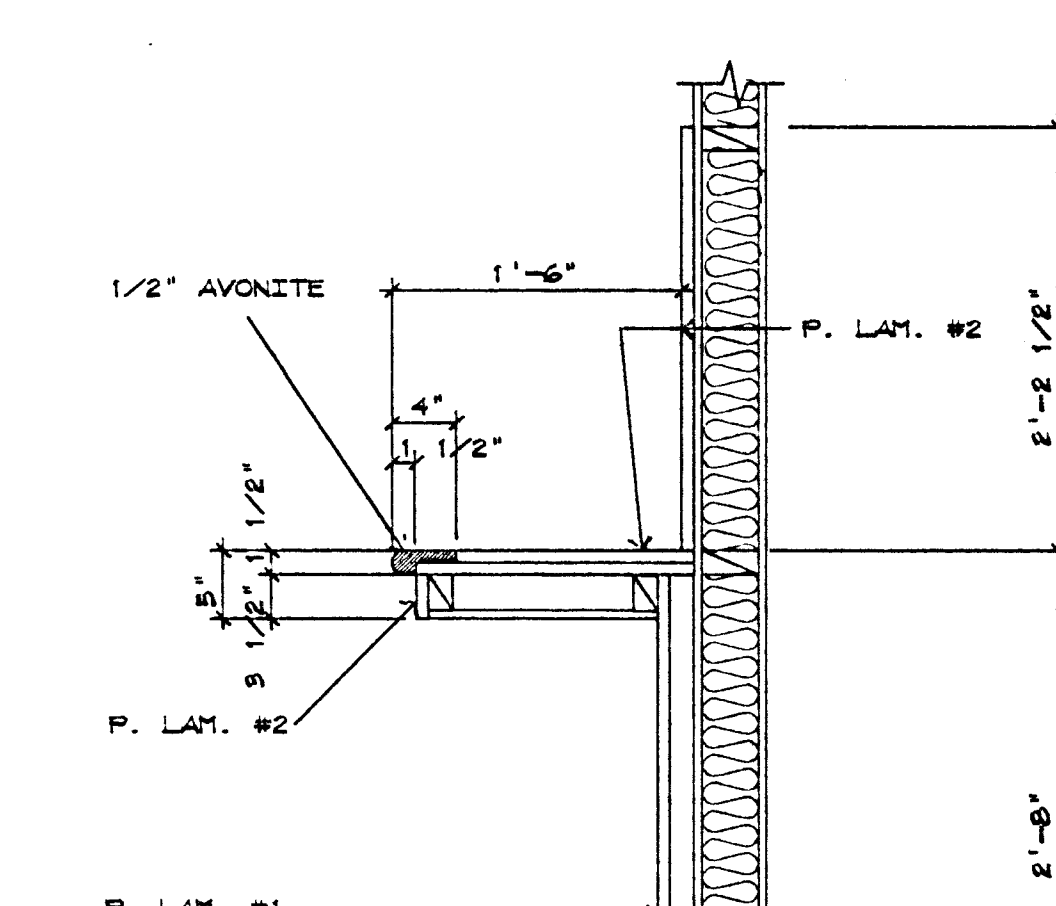


10 MERCHANDISING WALL (LOW COUNTER)
SCALE: 1" = 1'-0"

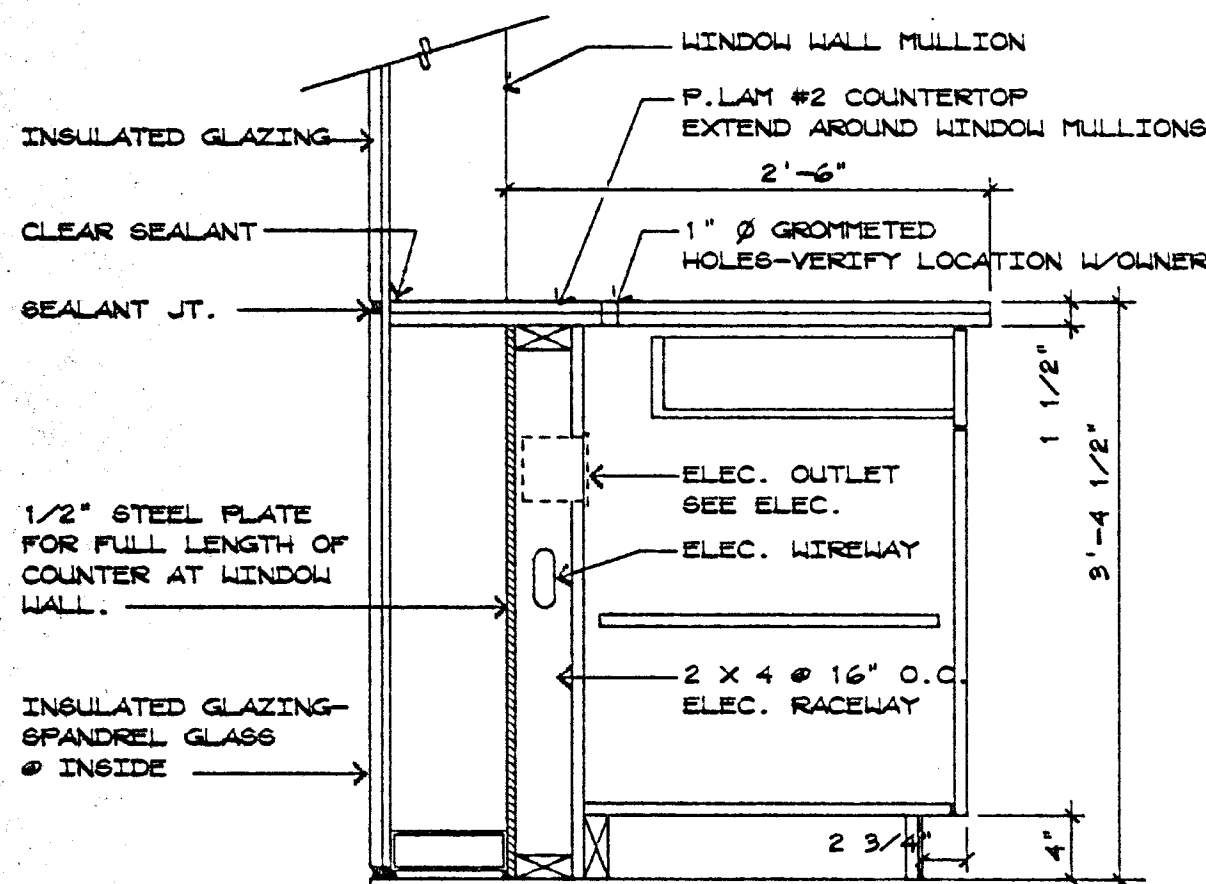


11 TELLER WORK COUNTER
SCALE: 3" = 1'-0"

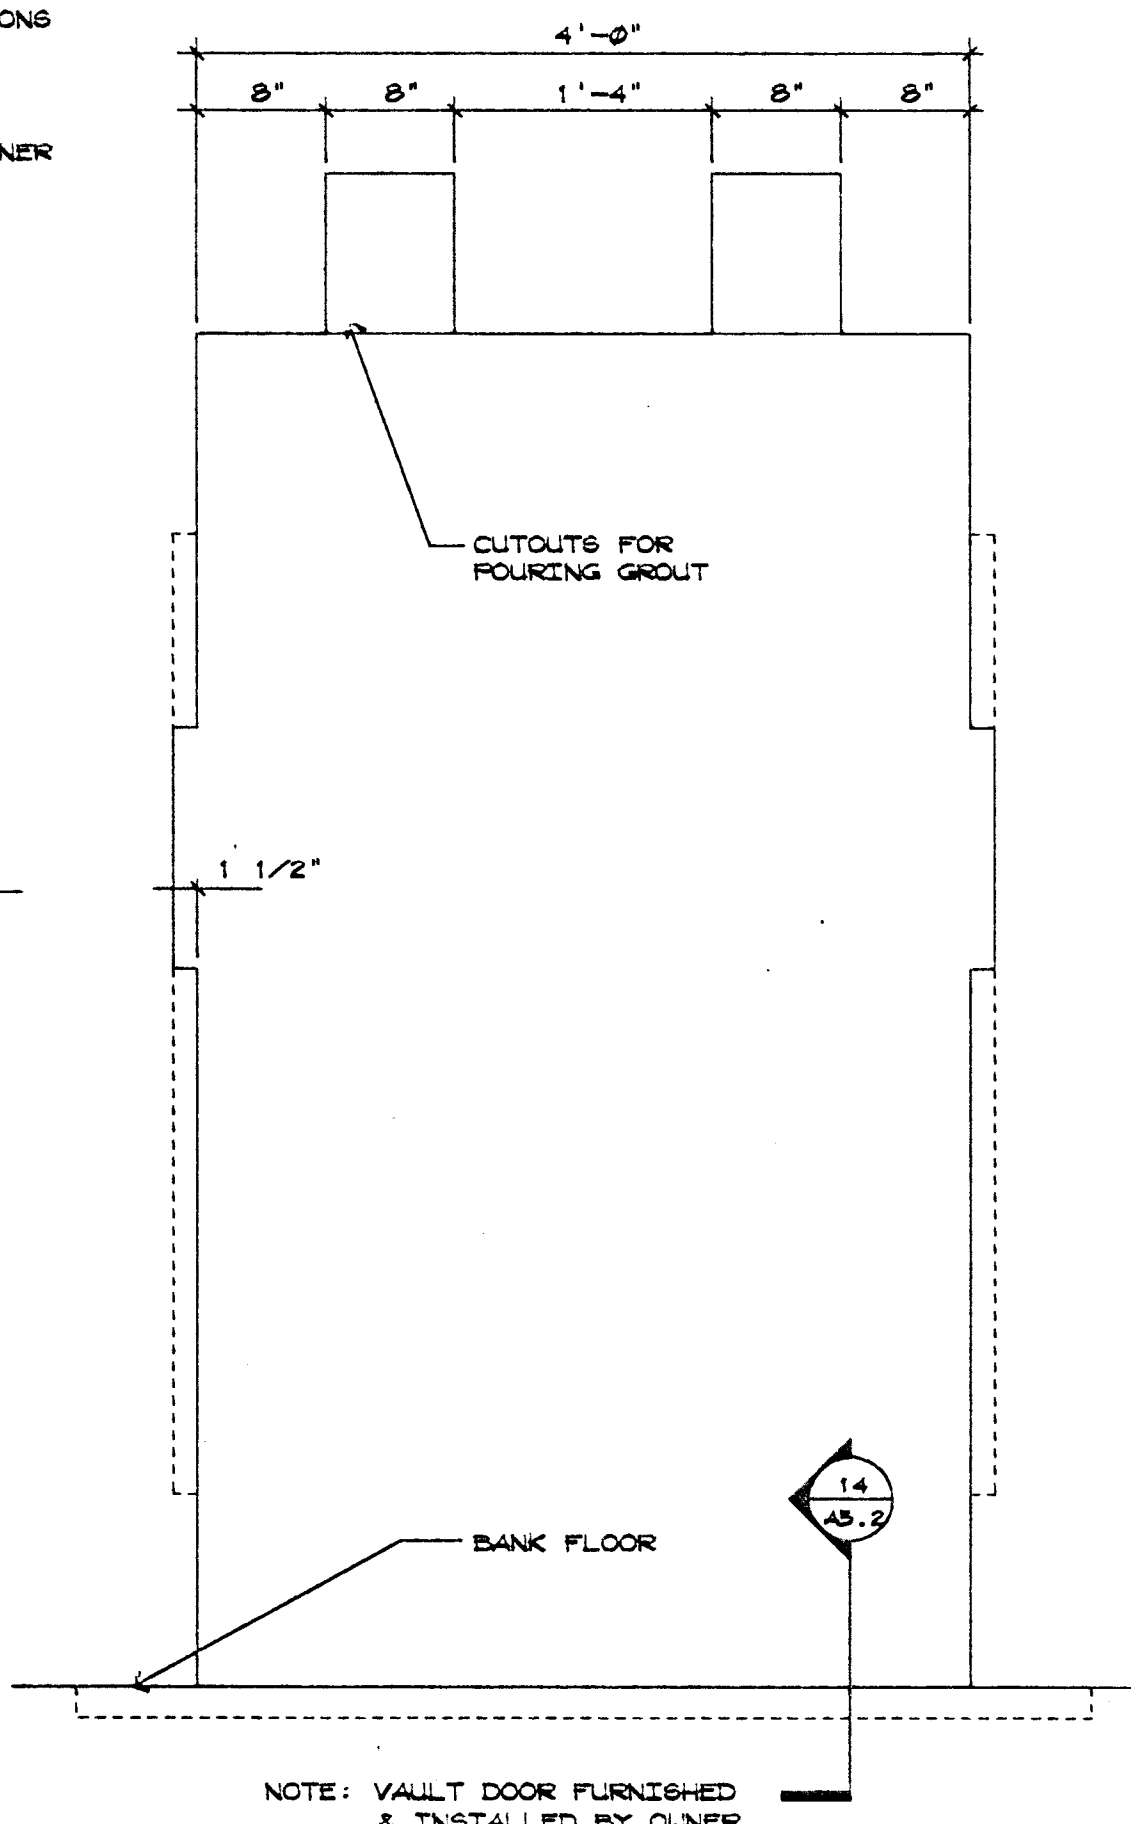


13 VAULT DOOR-FRONT ELEV.
SCALE: 1" = 1'-0"

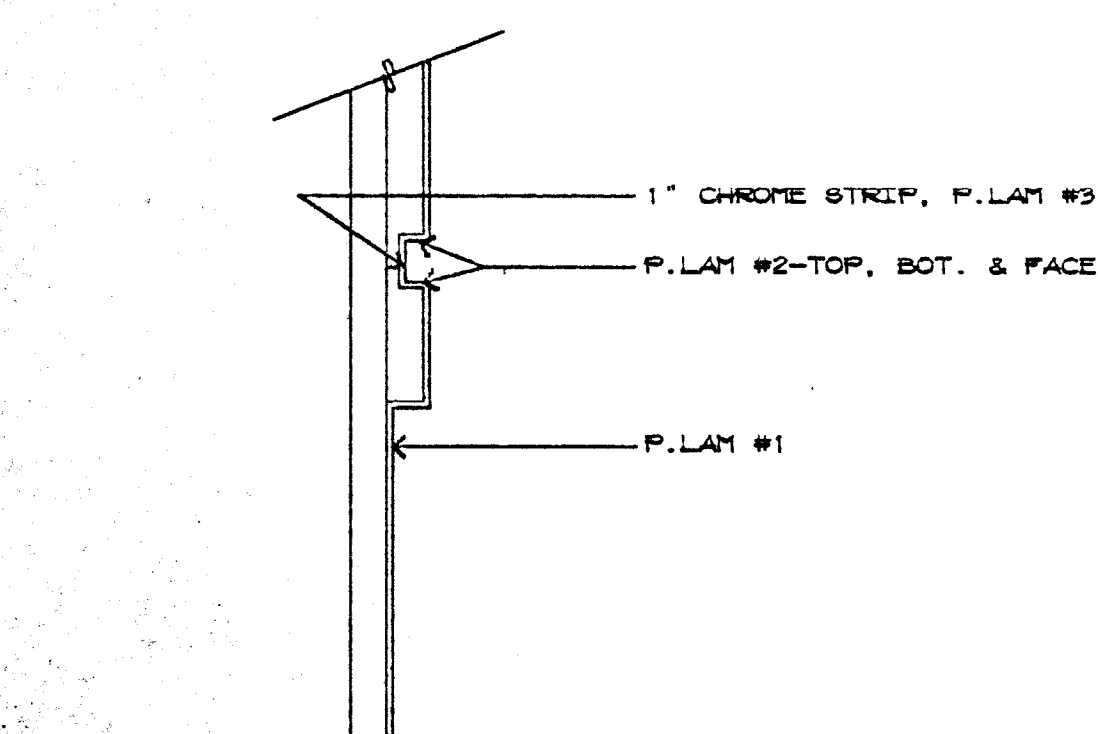


12 CASEWORK REVEAL
SCALE: 3" = 1'-0"

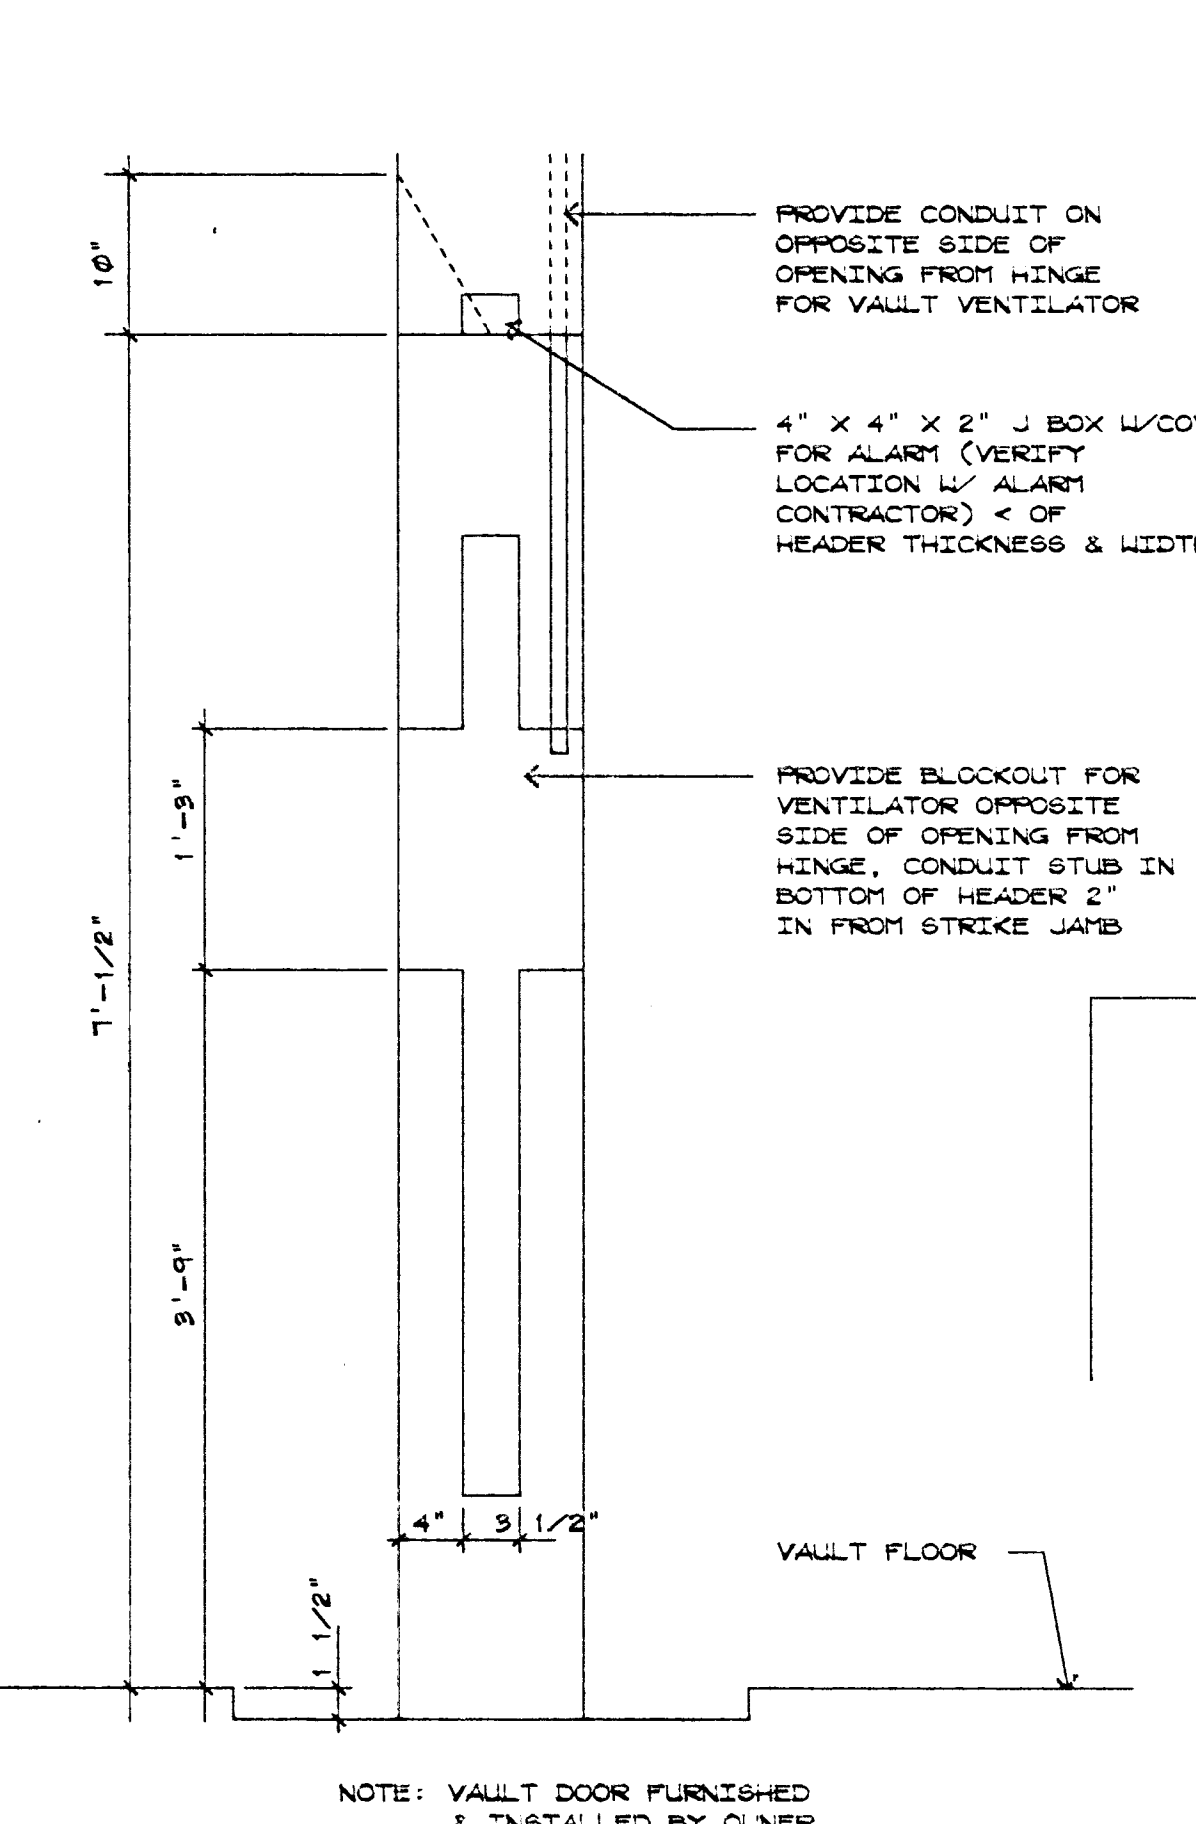

14 VAULT DOOR-SECTION
SCALE: 1" = 1'-0"

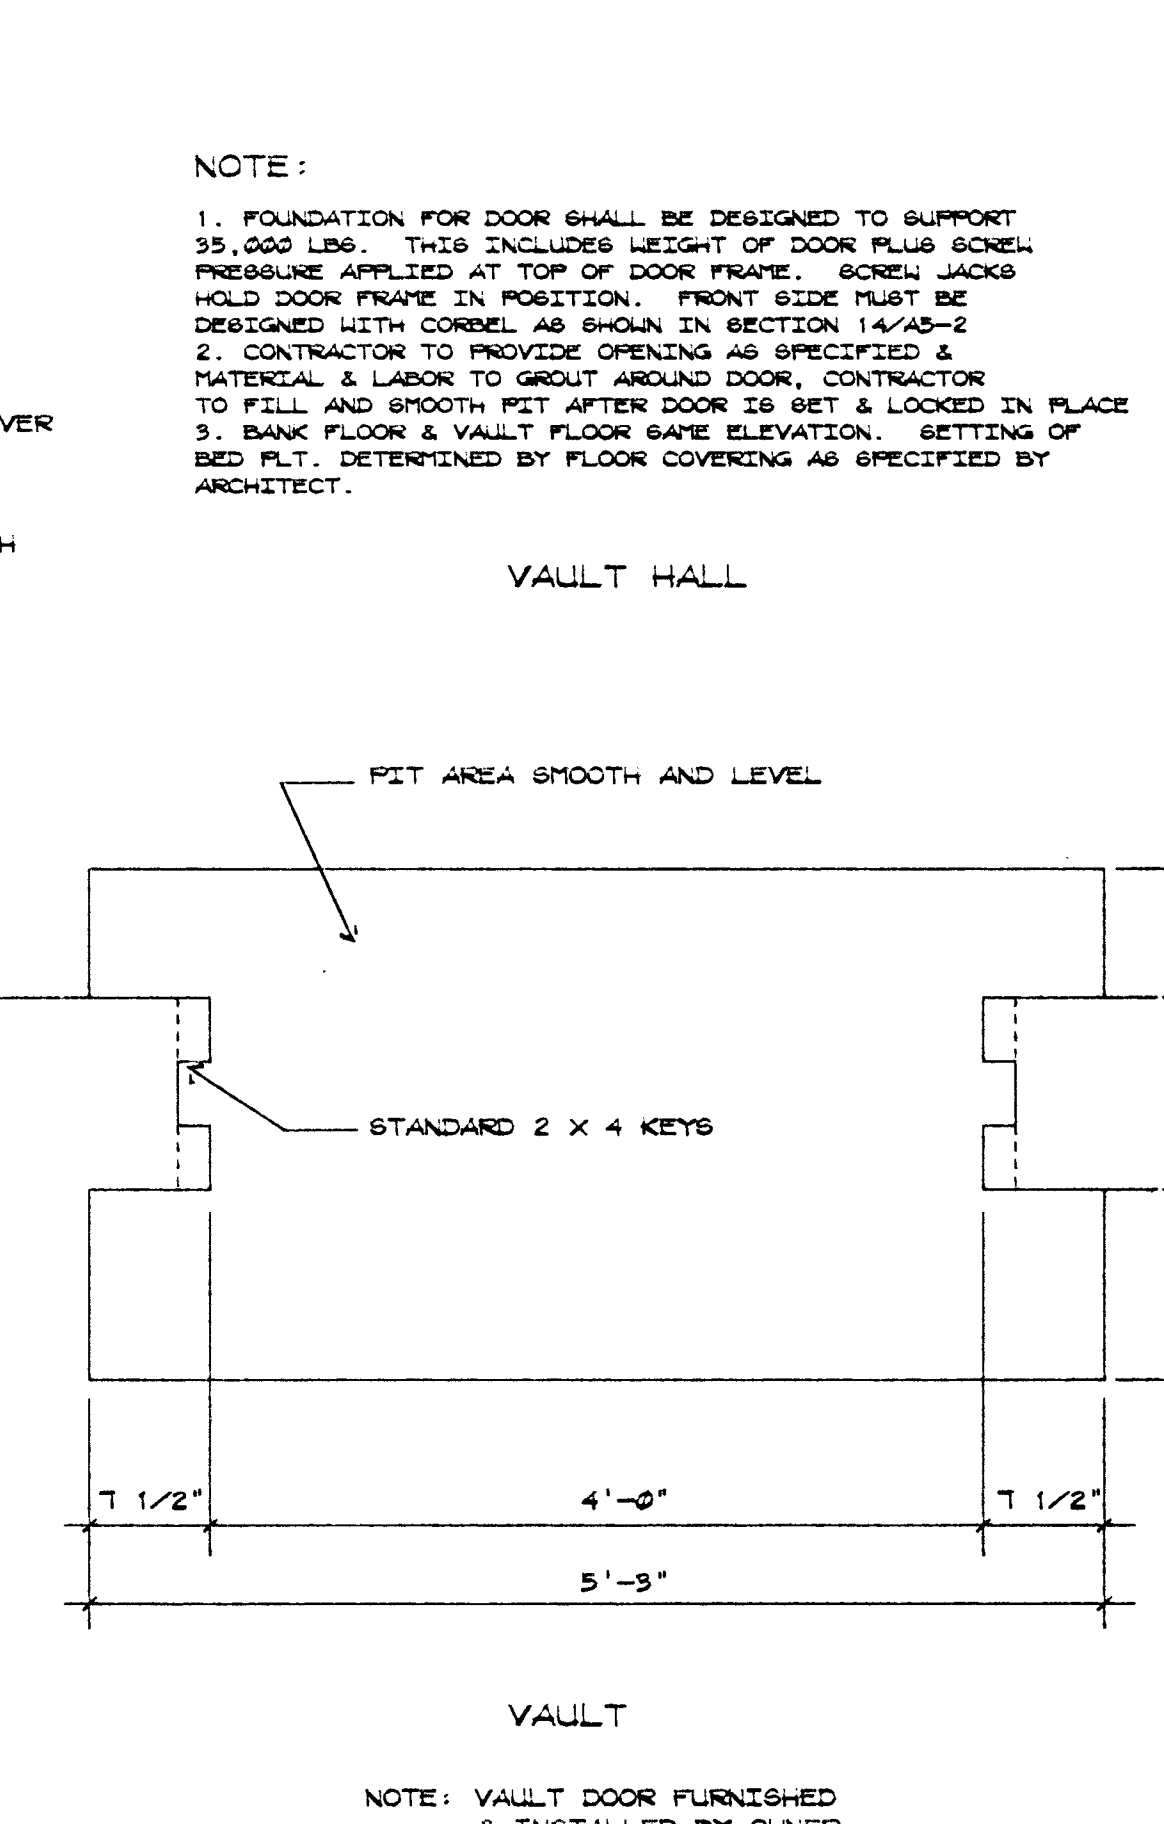

15 VAULT DOOR-PLAN
SCALE: 1" = 1'-0"

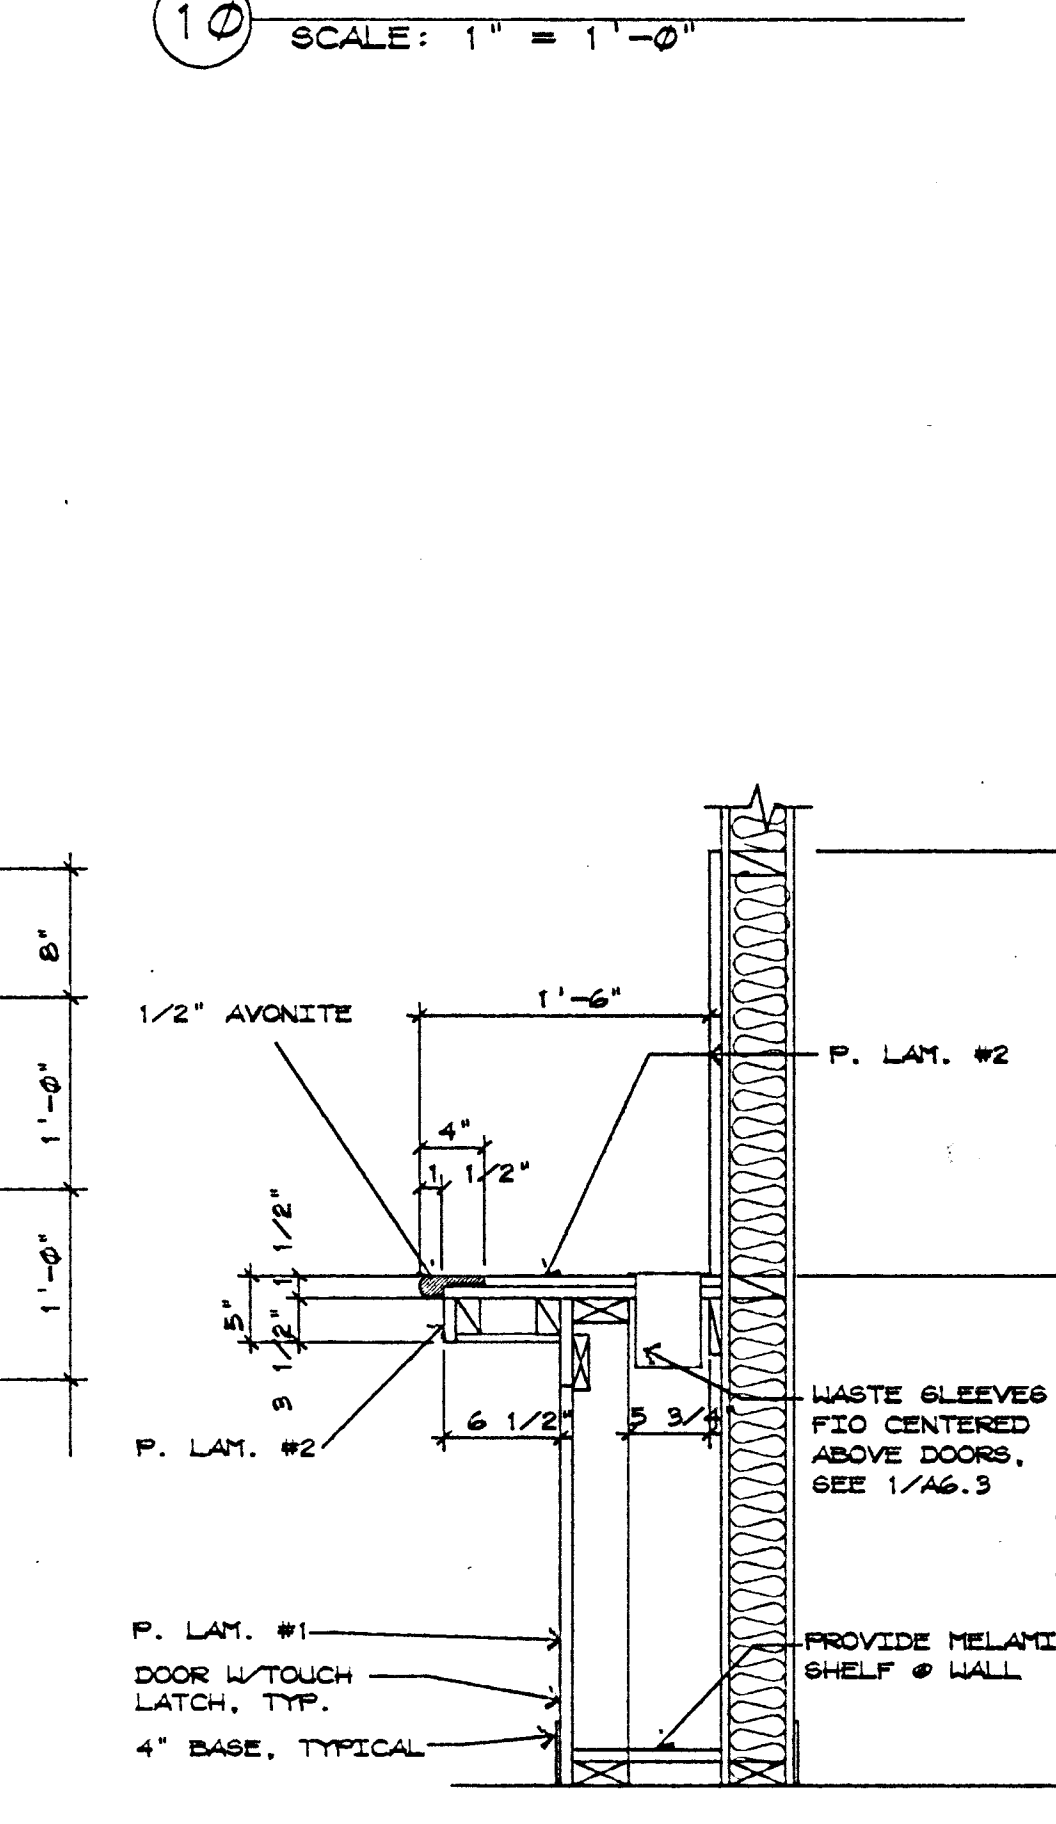

16 MERCHANDISING WALL (LOW COUNTER)
SCALE: 1" = 1'-0"

NOTE:
1. FOUNDATION FOR DOOR SHALL BE DESIGNED TO SUPPORT 35,000 LBS. THIS INCLUDES WEIGHT OF DOOR PLUS SCREW PRESSURE APPLIED AT TOP OF DOOR FRAME. SCREW JACKS HOLD DOOR FRAME IN POSITION. FRONT SIDE MUST BE DESIGNED WITH CORBEL AS SHOWN IN SECTION 14/A5-2.
2. CONTRACTOR TO PROVIDE OPENING AS SPECIFIED & MATERIAL & LABOR TO GROUT AROUND DOOR. CONTRACTOR TO FILL AND SMOOTH FET AFTER DOOR IS SET & LOCKED IN PLACE.
3. BANK FLOOR & VAULT FLOOR SAME ELEVATION. SETTING OF BED FLT. DETERMINED BY FLOOR COVERING AS SPECIFIED BY ARCHITECT.

VAULT HALL

FIT AREA SMOOTH AND LEVEL

STANDARD 2 X 4 KEYS

VAULT

NOTE: VAULT DOOR FURNISHED & INSTALLED BY OWNER

NOTE: VAULT DOOR FURNISHED & INSTALLED BY OWNER

NOTE: VAULT DOOR FURNISHED & INSTALLED BY OWNER

Copyright 1993
Lombard-Conrad Architects
All rights reserved. Reproduction or translation of any part of this work without written permission of Lombard-Conrad Architects is unlawful and subject to criminal prosecution.


1221 SHORELINE LANE BOISE, IDAHO 83782 TEL. (208) 345-6677

Lombard-Conrad
ARCHITECTS
P. A., A. I. A.


BANK OF AMERICA
FAIRVIEW AND MITCHELL
BOISE IDAHO
CASEWORK & INTERIOR DETAILS

JOB NO. 95031.01
DATE 9-13-95
DRAWN BY DNS - CHECKED BY SDH
REVISIONS DATE


SHEET NO.
A5.2

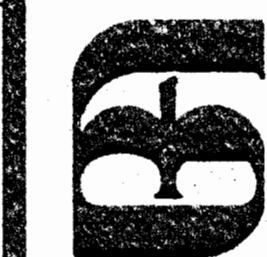

JOB NO.	93031.01
DATE	9-19-93
DRAWN BY	SCM
CHECKED BY	SDH
REVISIONS	DATE
1 FLOOR PLAN	9-21-93
2 FLOOR PLAN	9-21-93

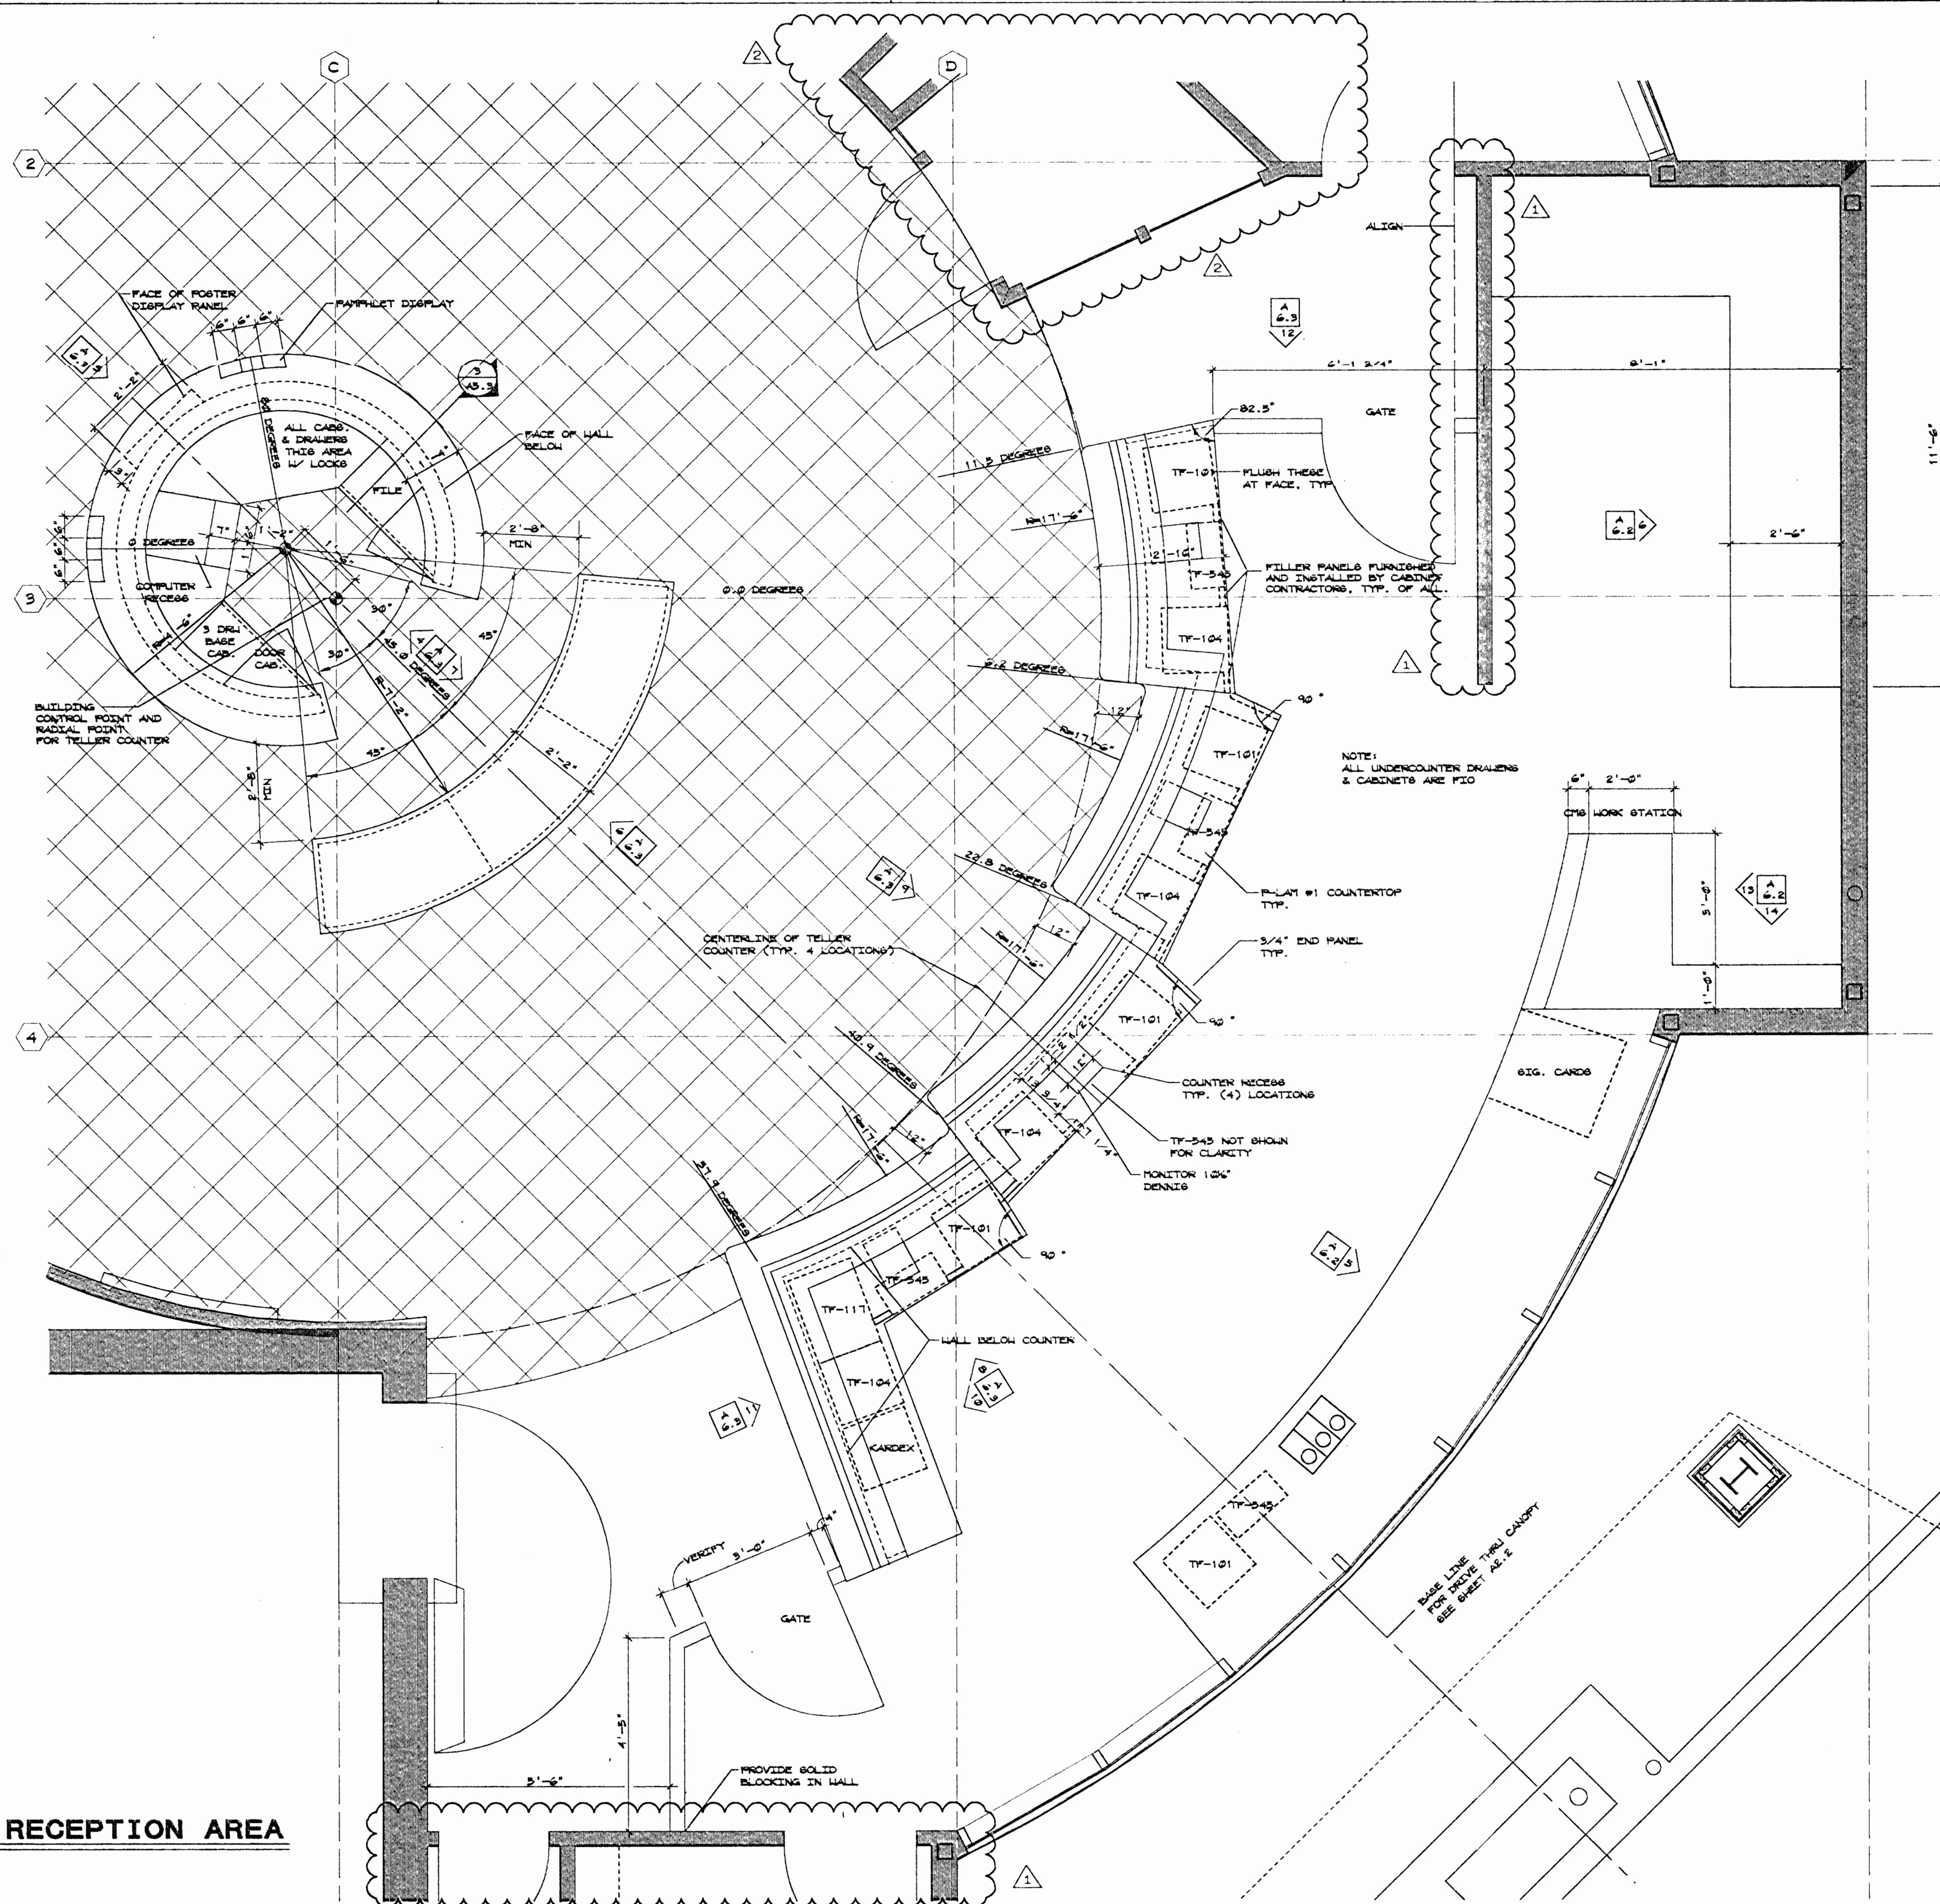

TELLER & RECEPTION AREA
 Scale: 1/2" = 1'-0"

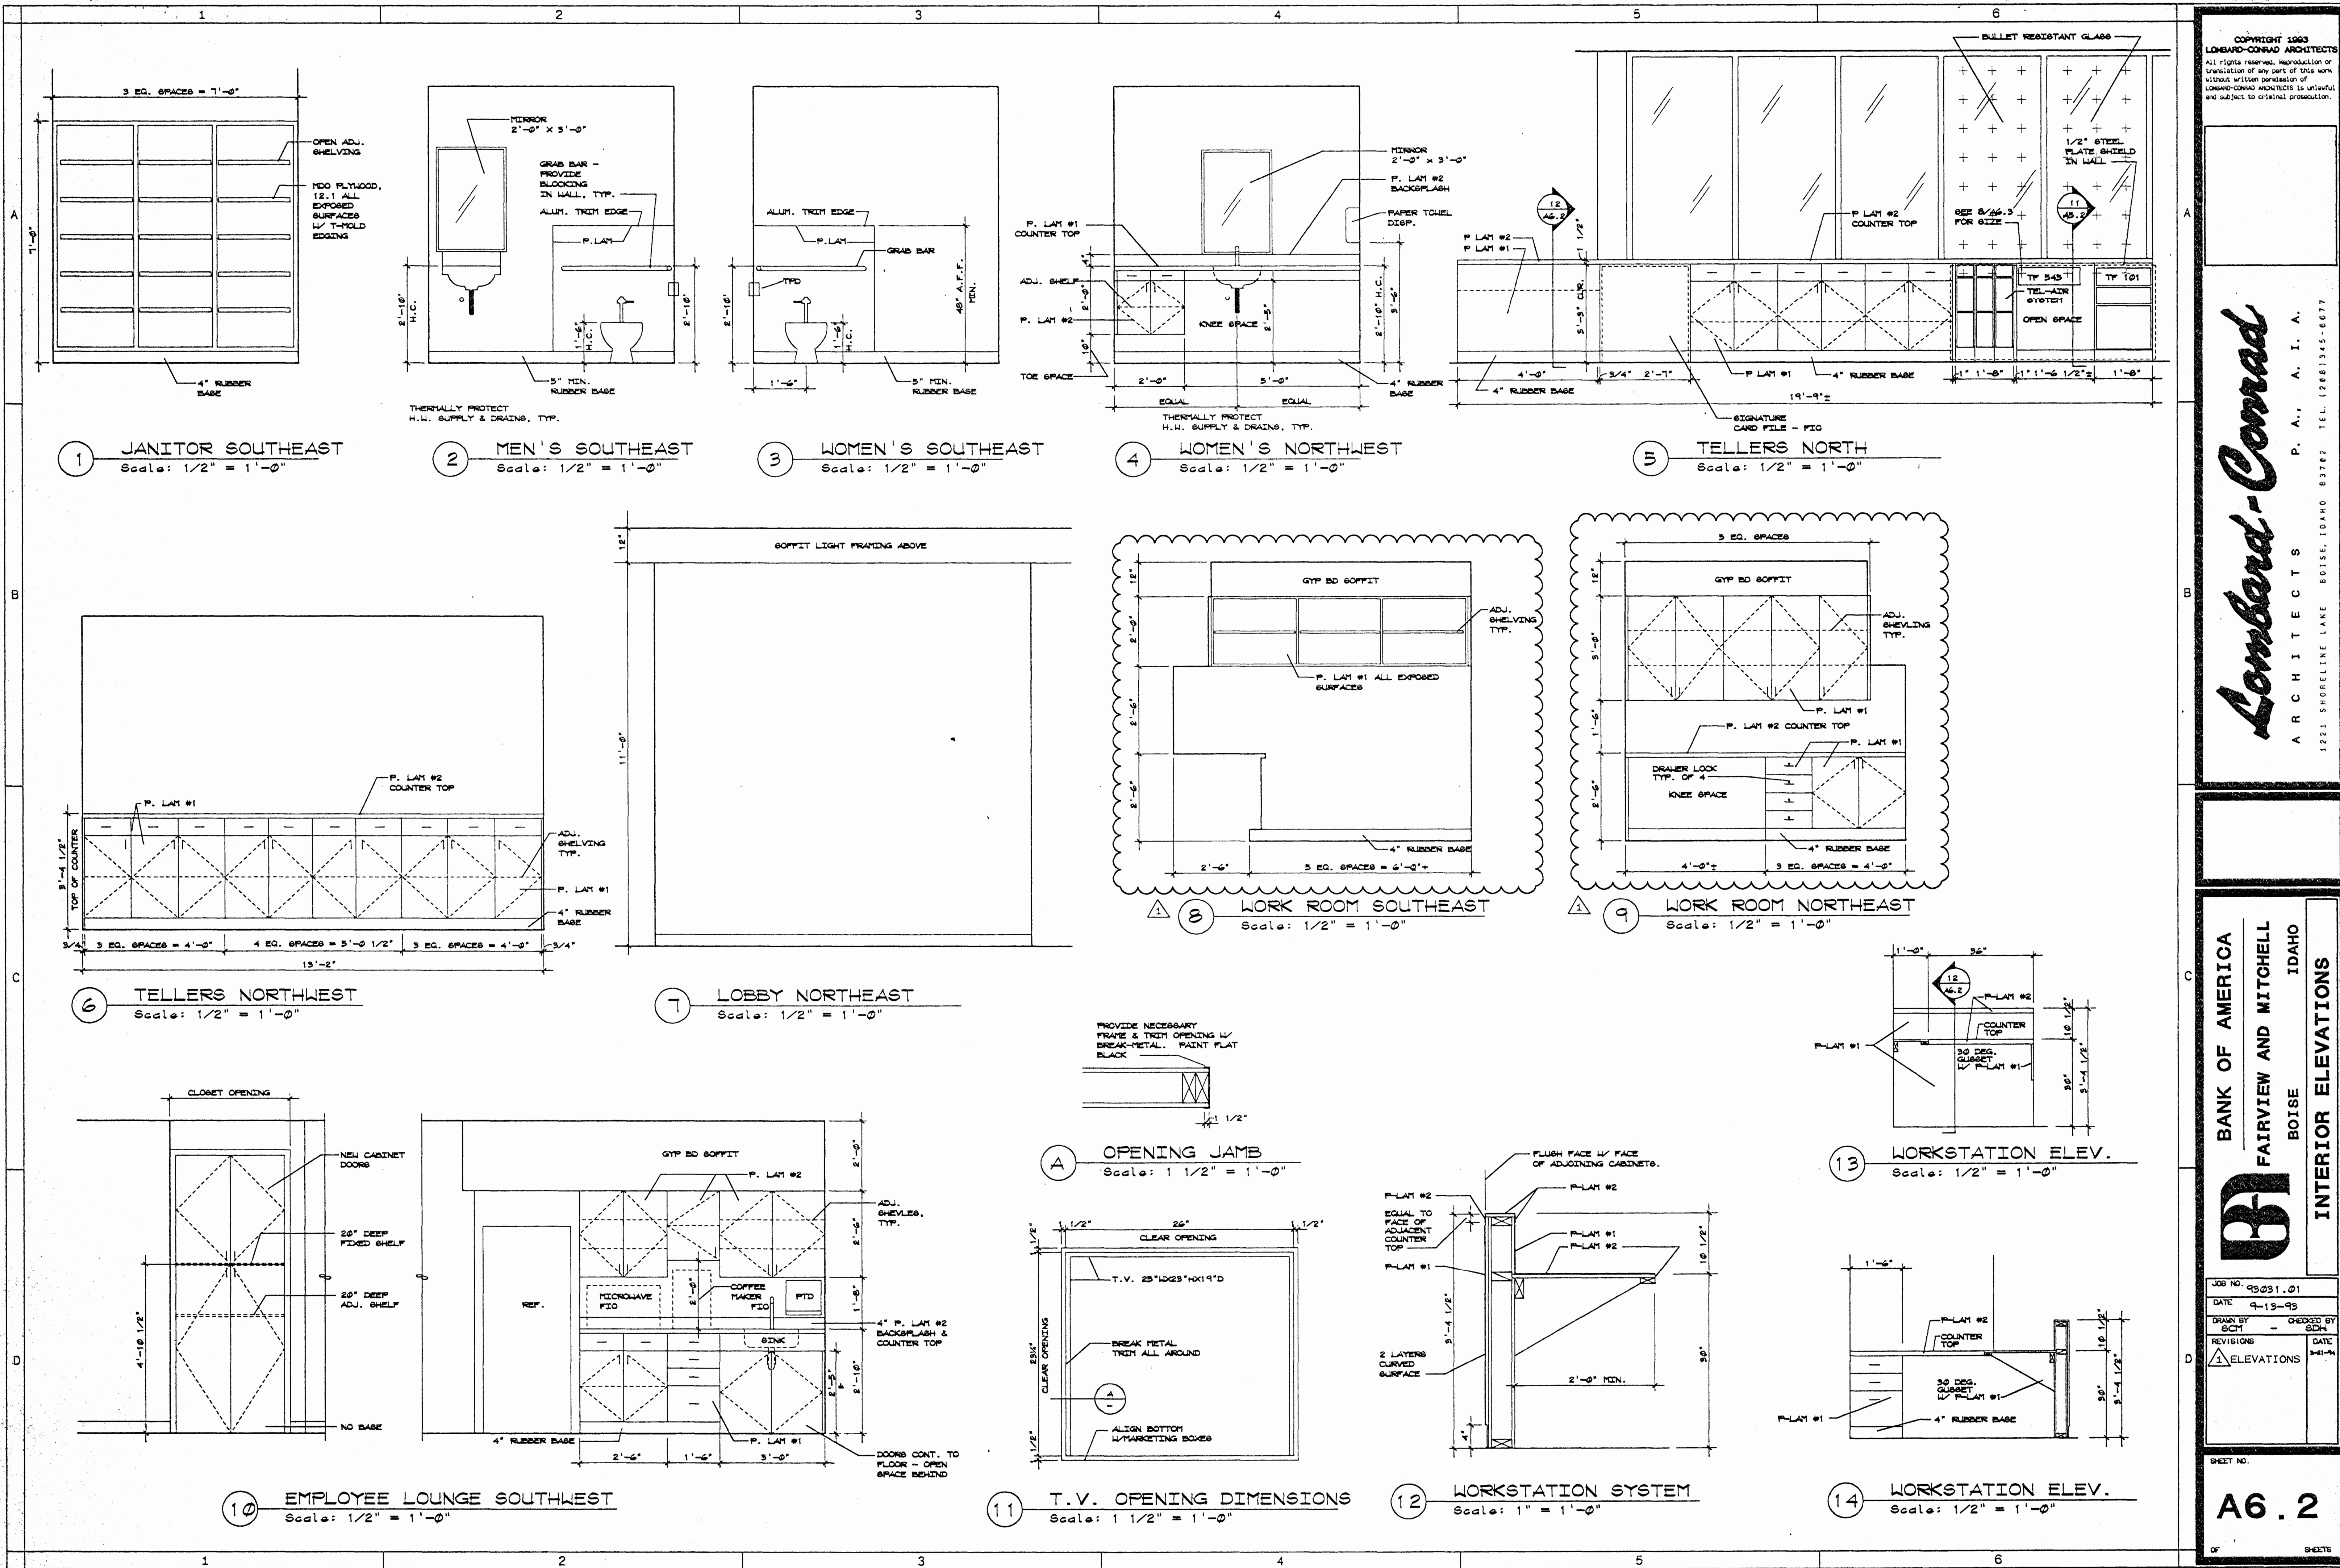

COPYRIGHT 1983
LOMBARD-CONRAD ARCHITECTS
All rights reserved. Reproduction or
transmission of any part of this work
without written permission of
Lombard-Conrad Architects is unlawful
and subject to criminal prosecution.
















Lombard-Conrad
ARCHITECTS
1221 SHORELINE LANE BOISE, IDAHO 83762 TEL. (208) 345-6677

P. A., A. I. A.


BANK OF AMERICA
FAIRVIEW AND MITCHELL
BOISE IDAHO
INTERIOR ELEVATIONS

JOB NO. 95031.01
DATE 9-13-93
DRAWN BY SCB
CHECKED BY
REVISIONS
1 ELEVATIONS
DATE 12-1-93

SHEET NO.
A6.2
OF SHEETS

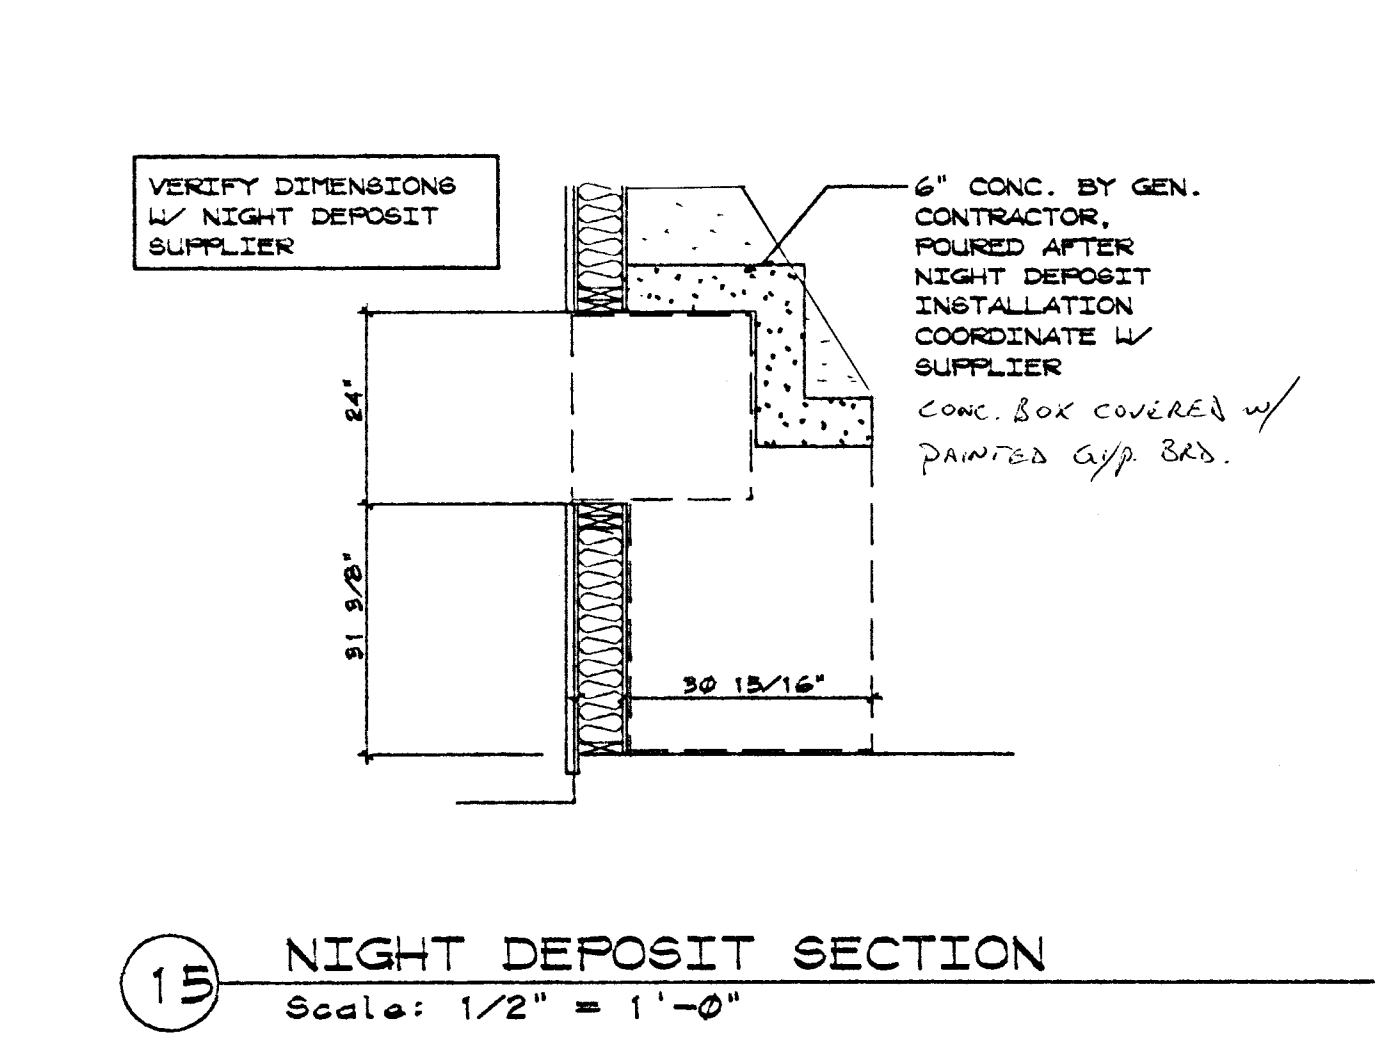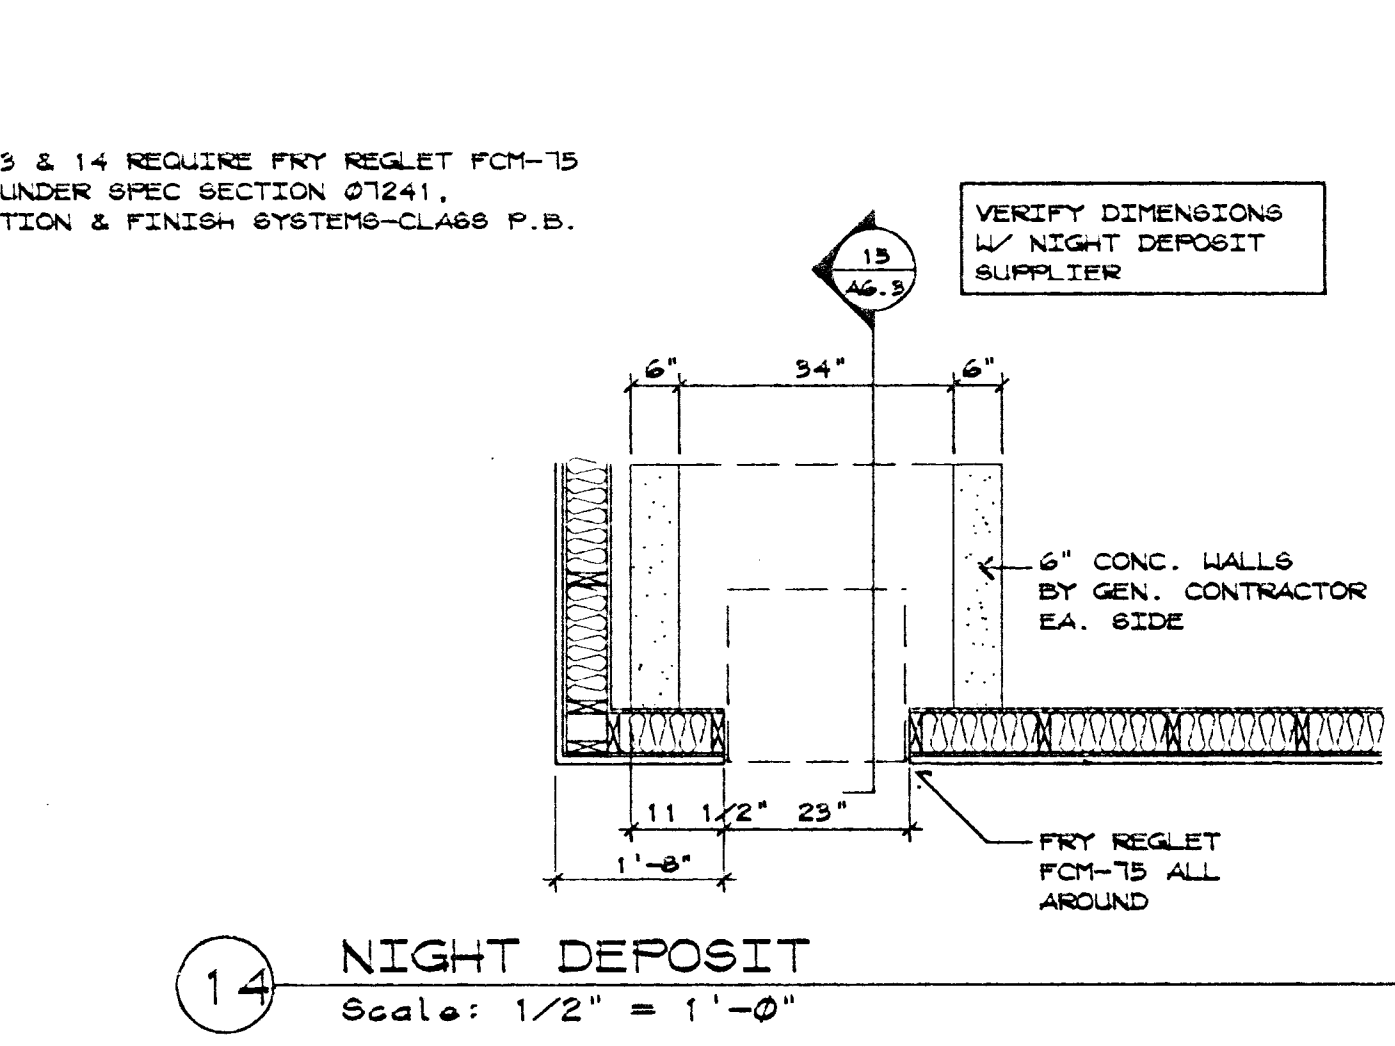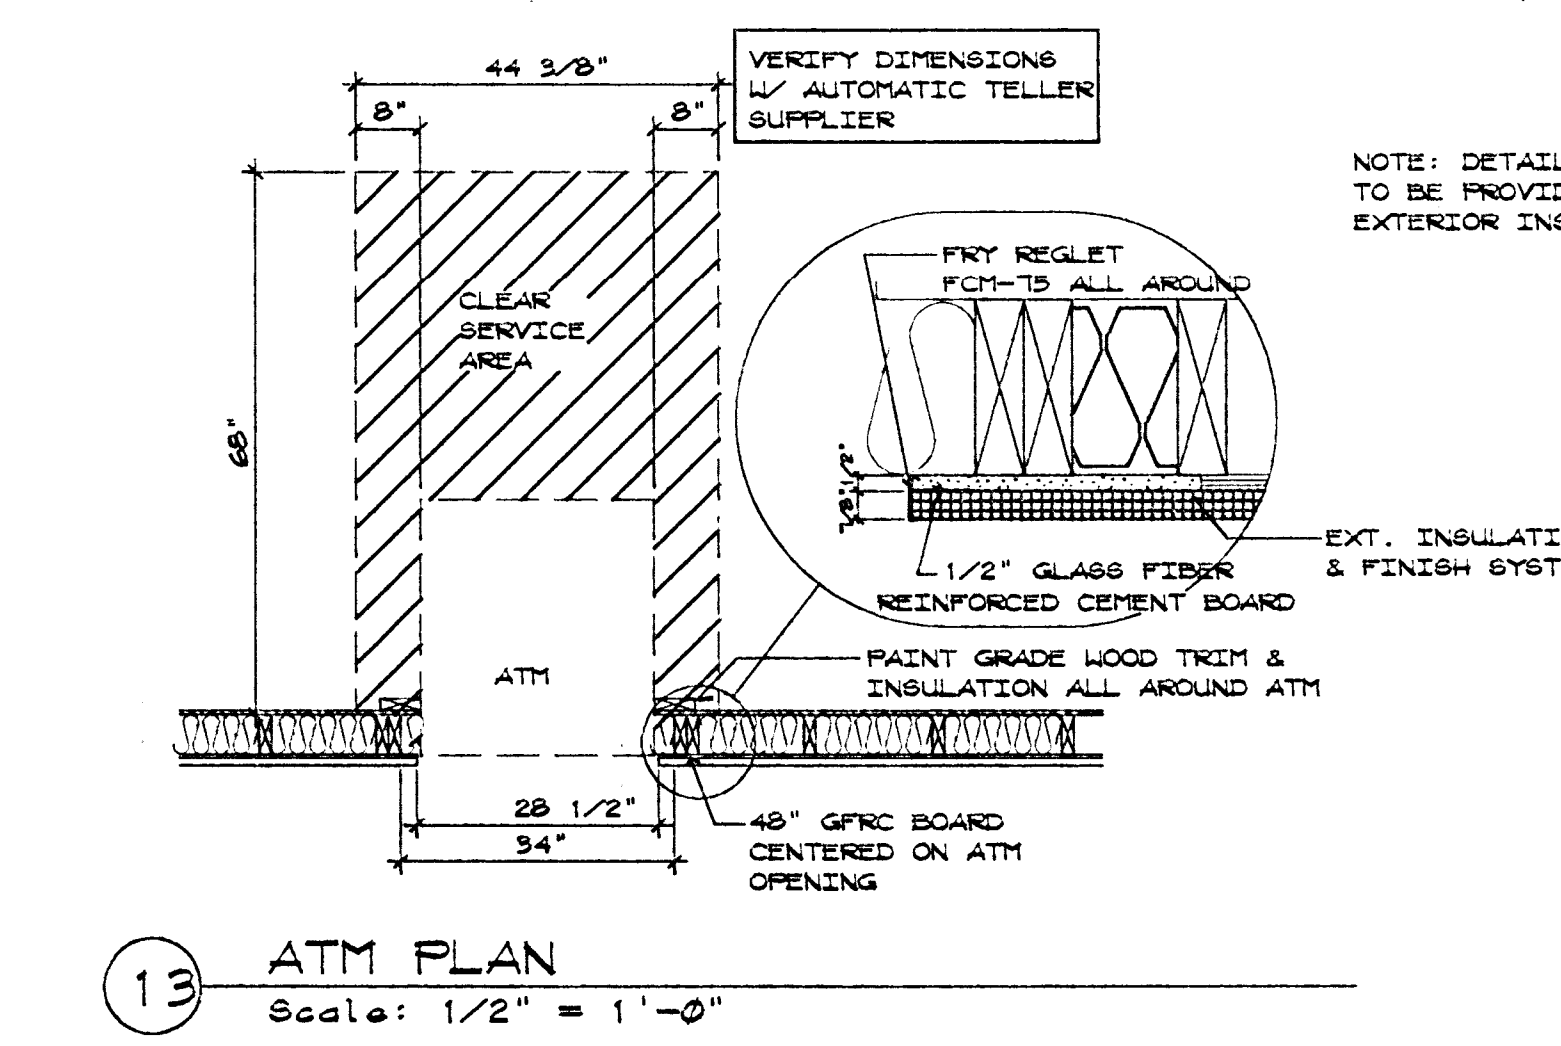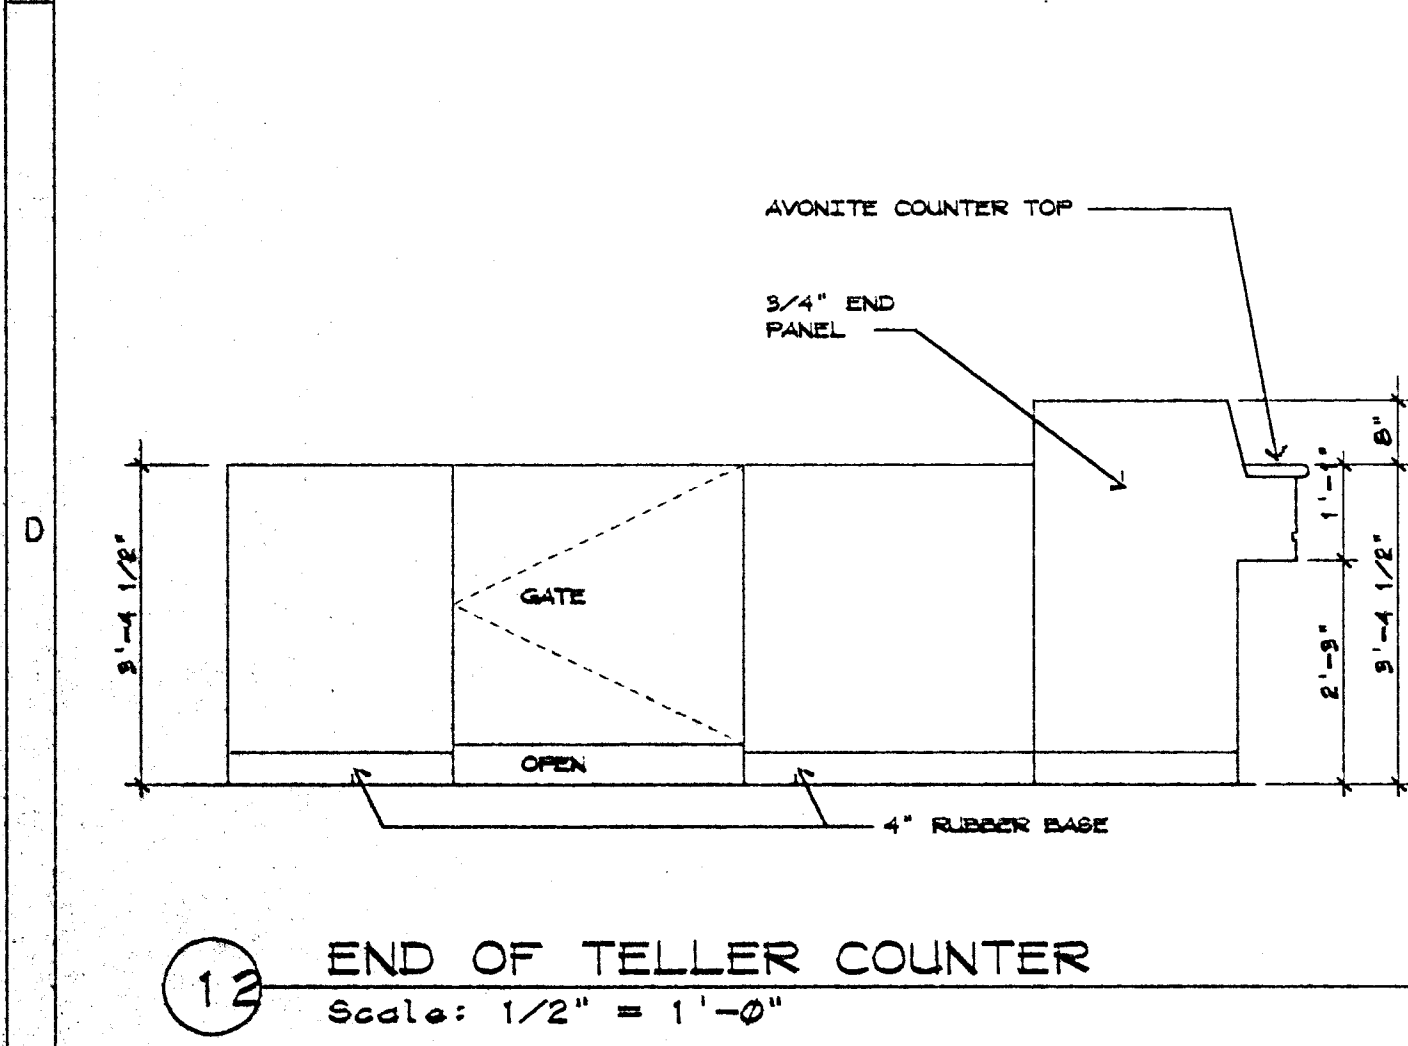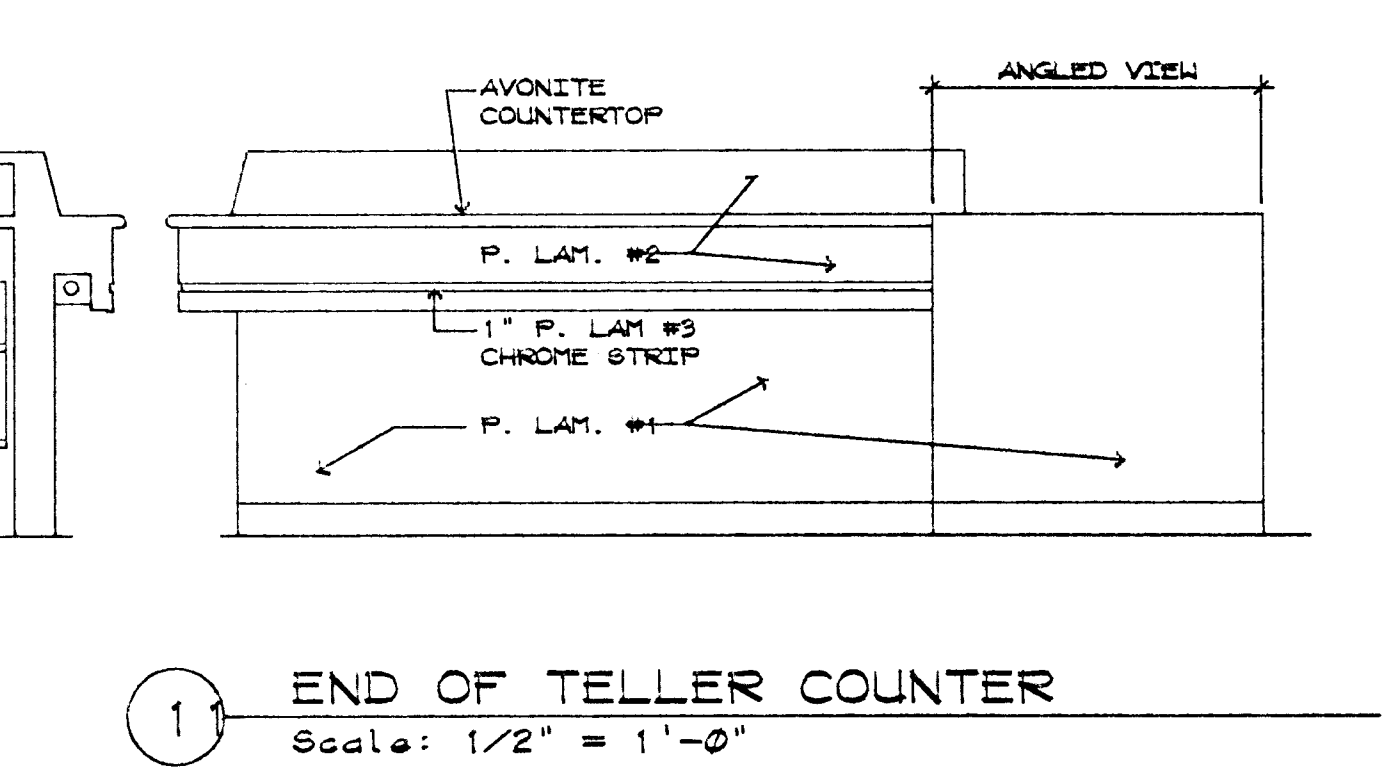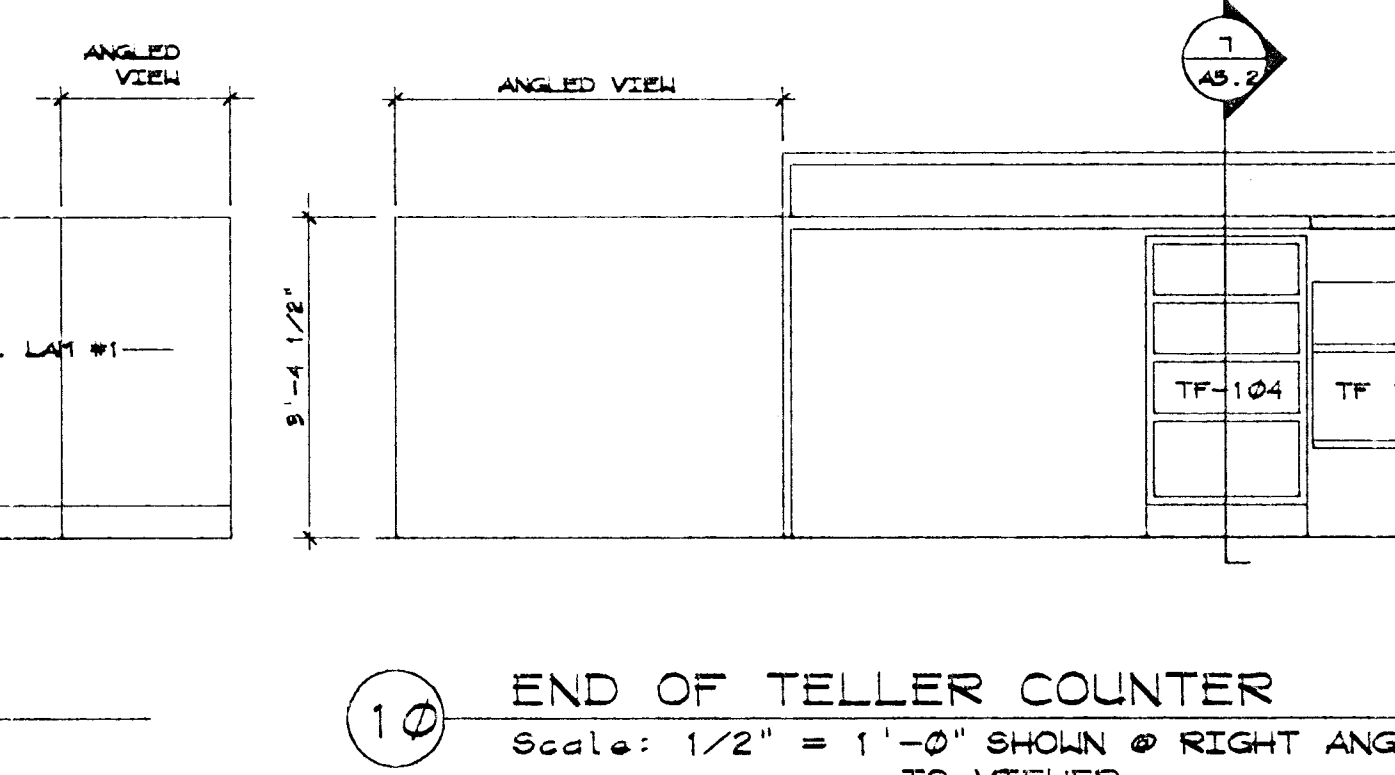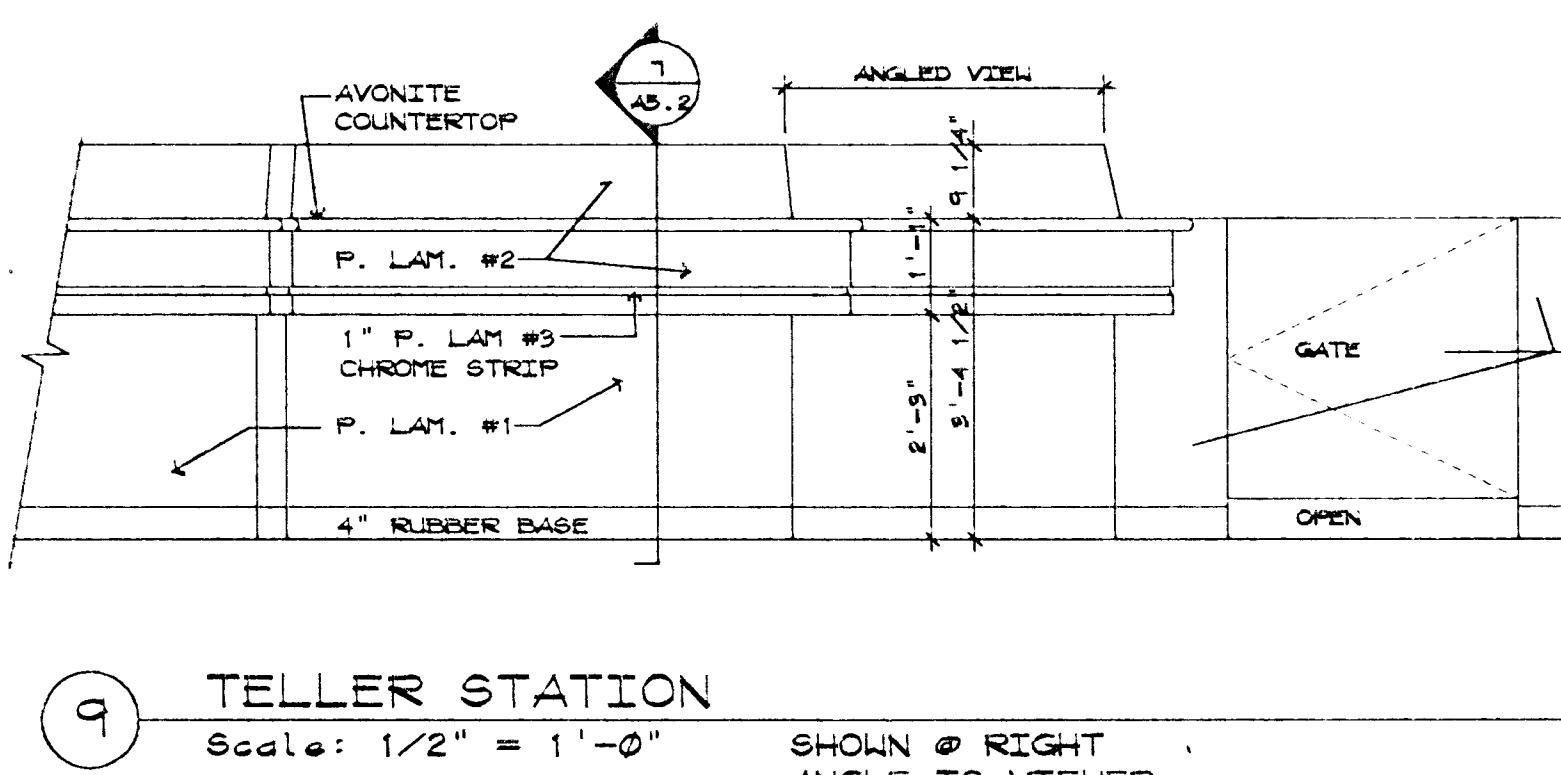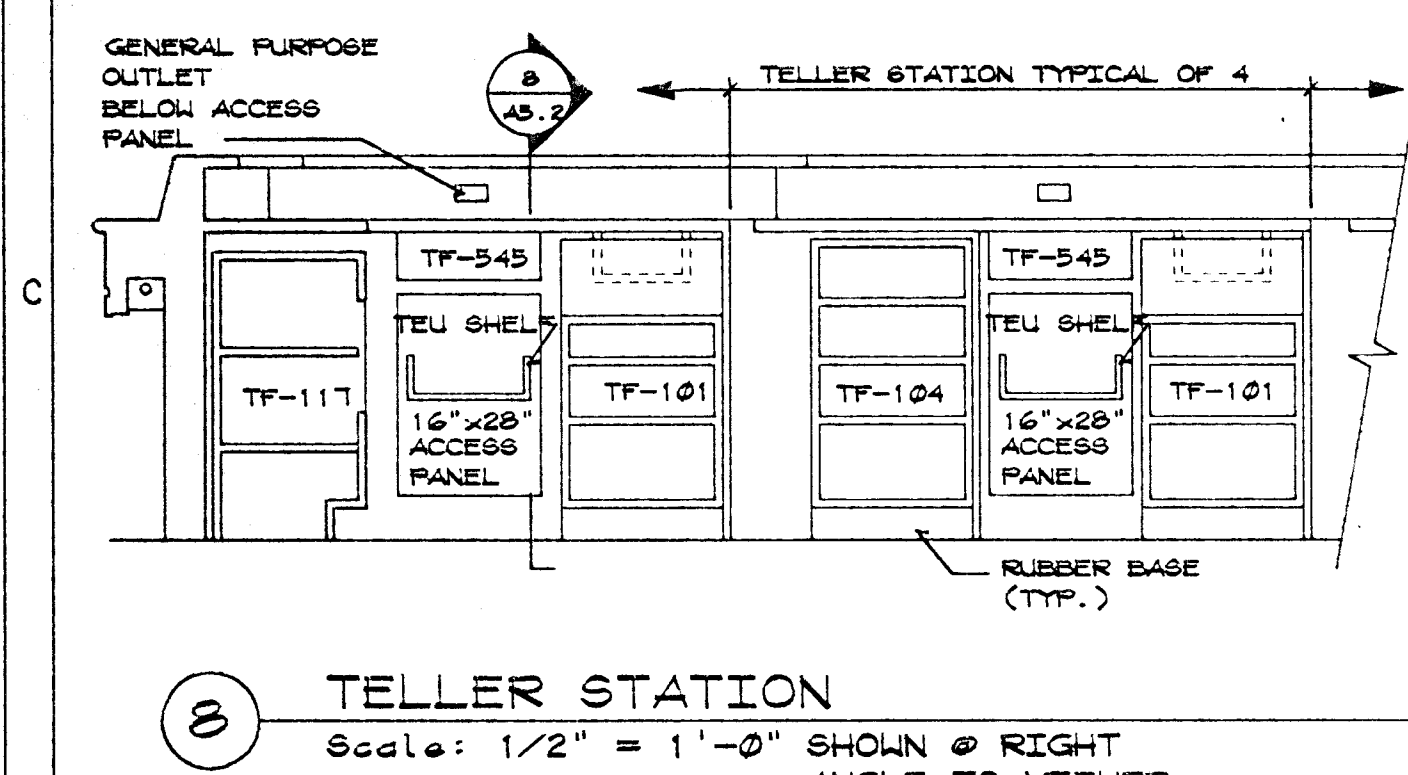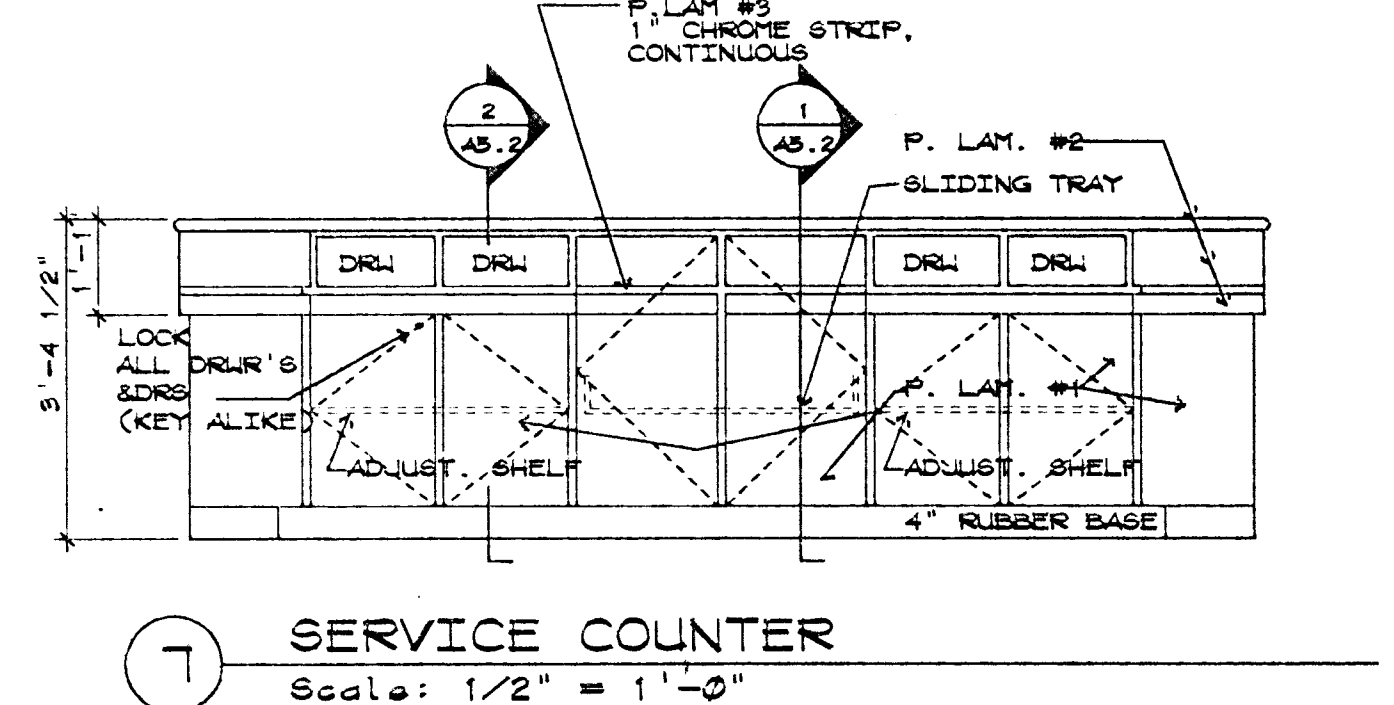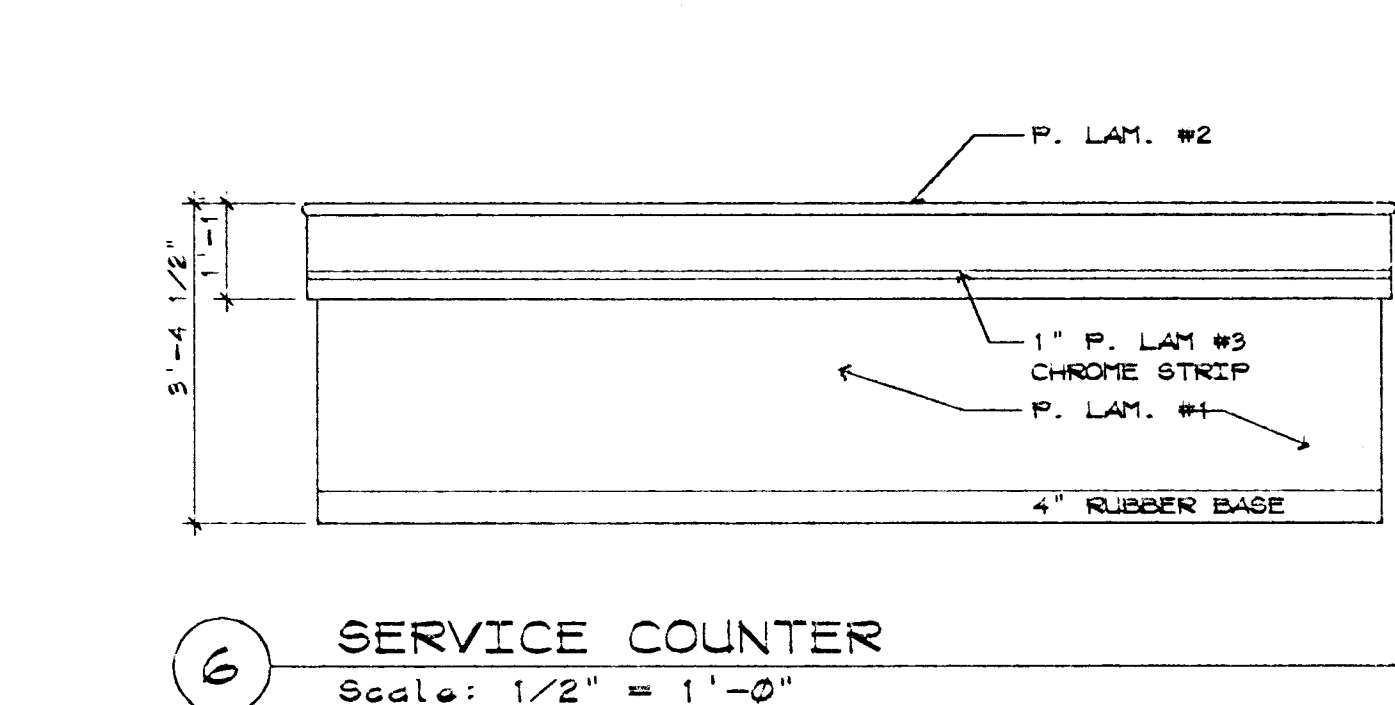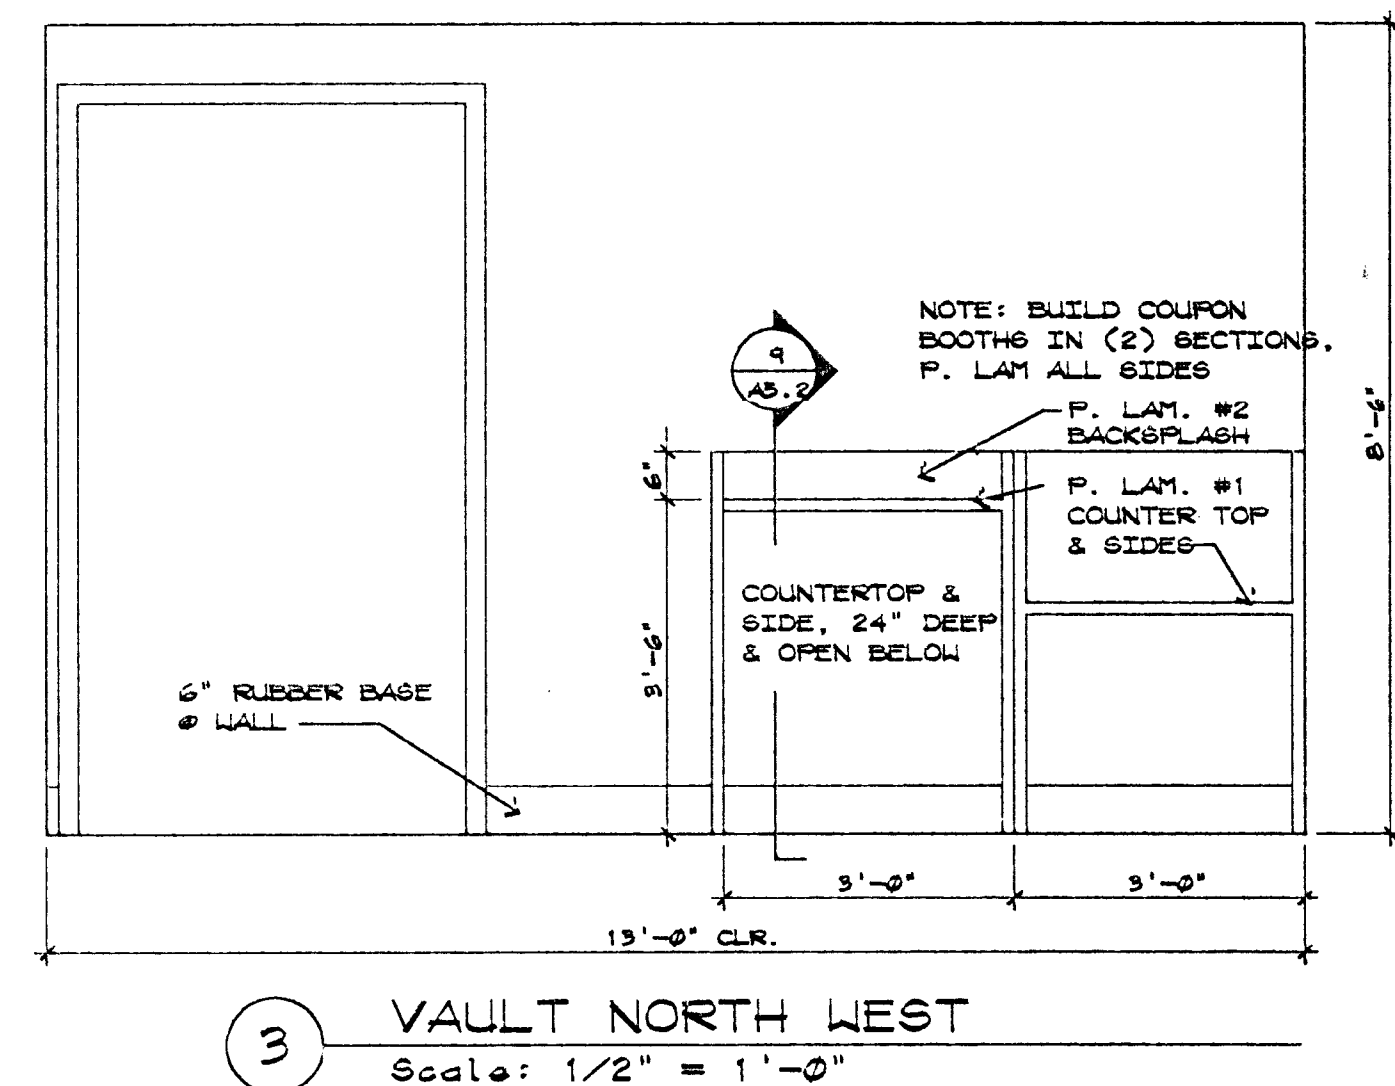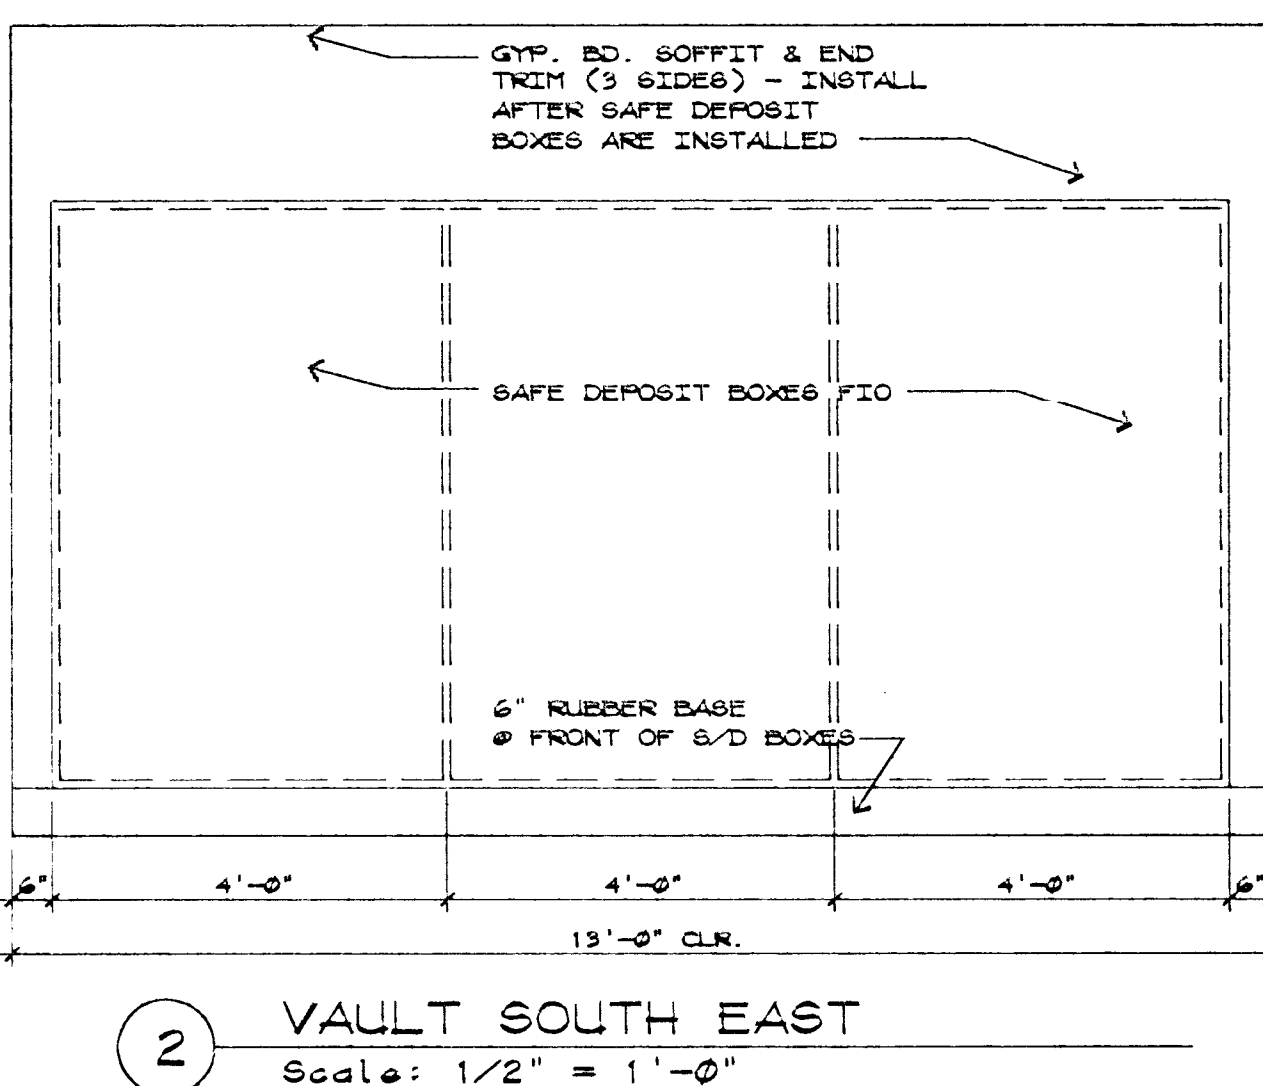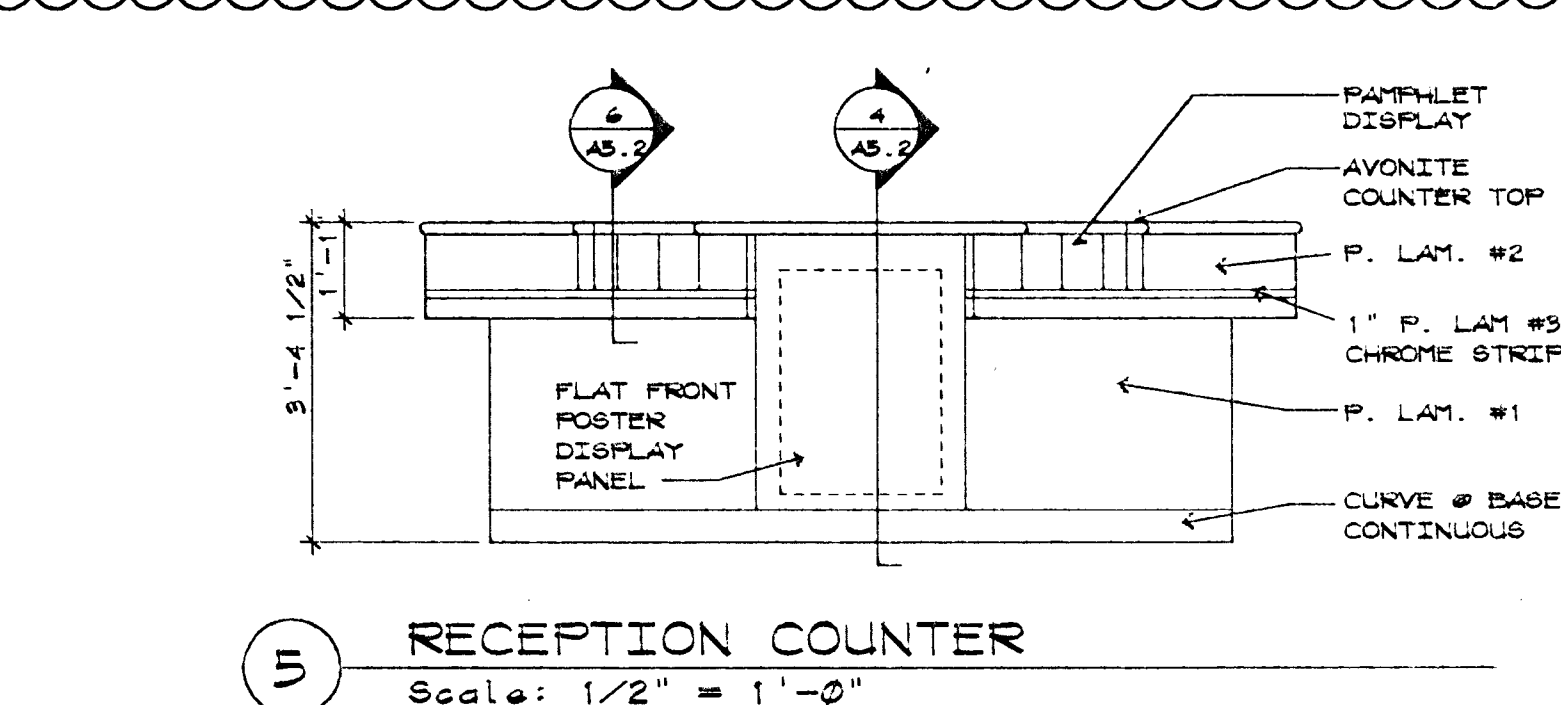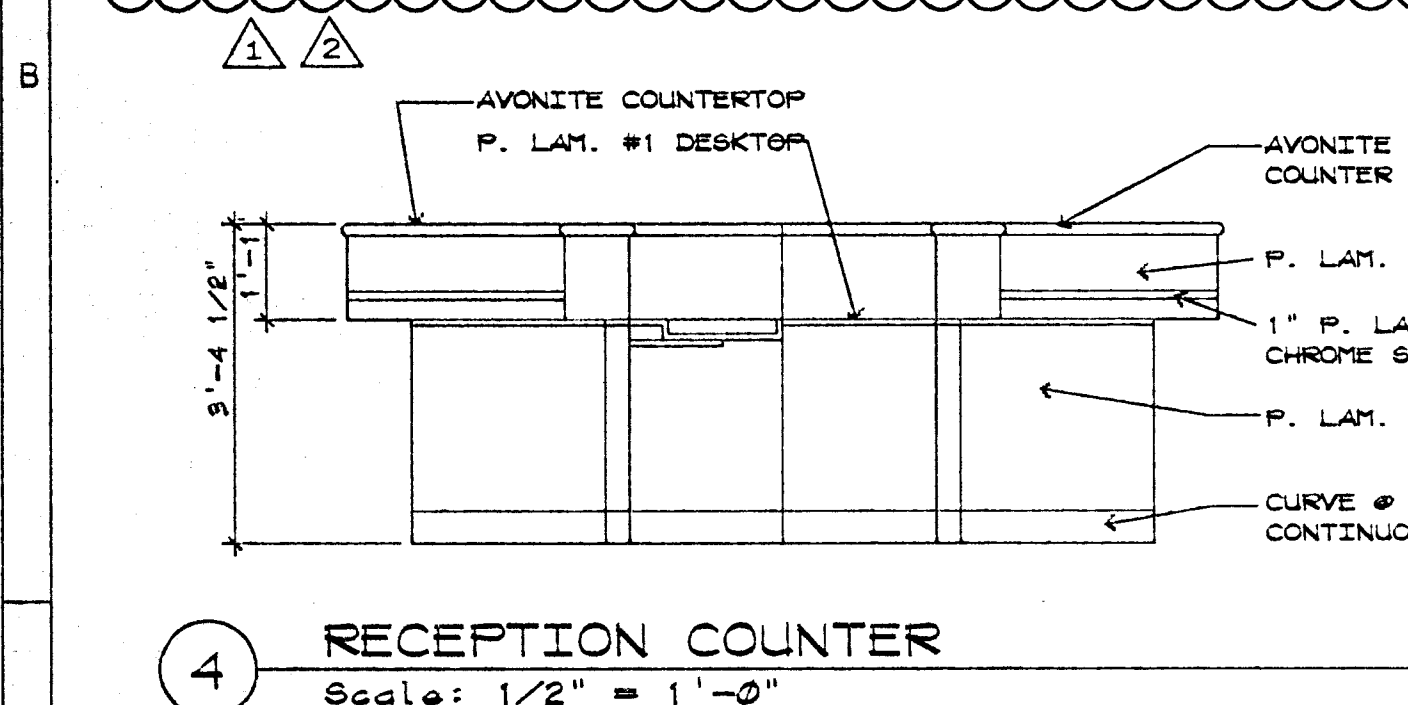
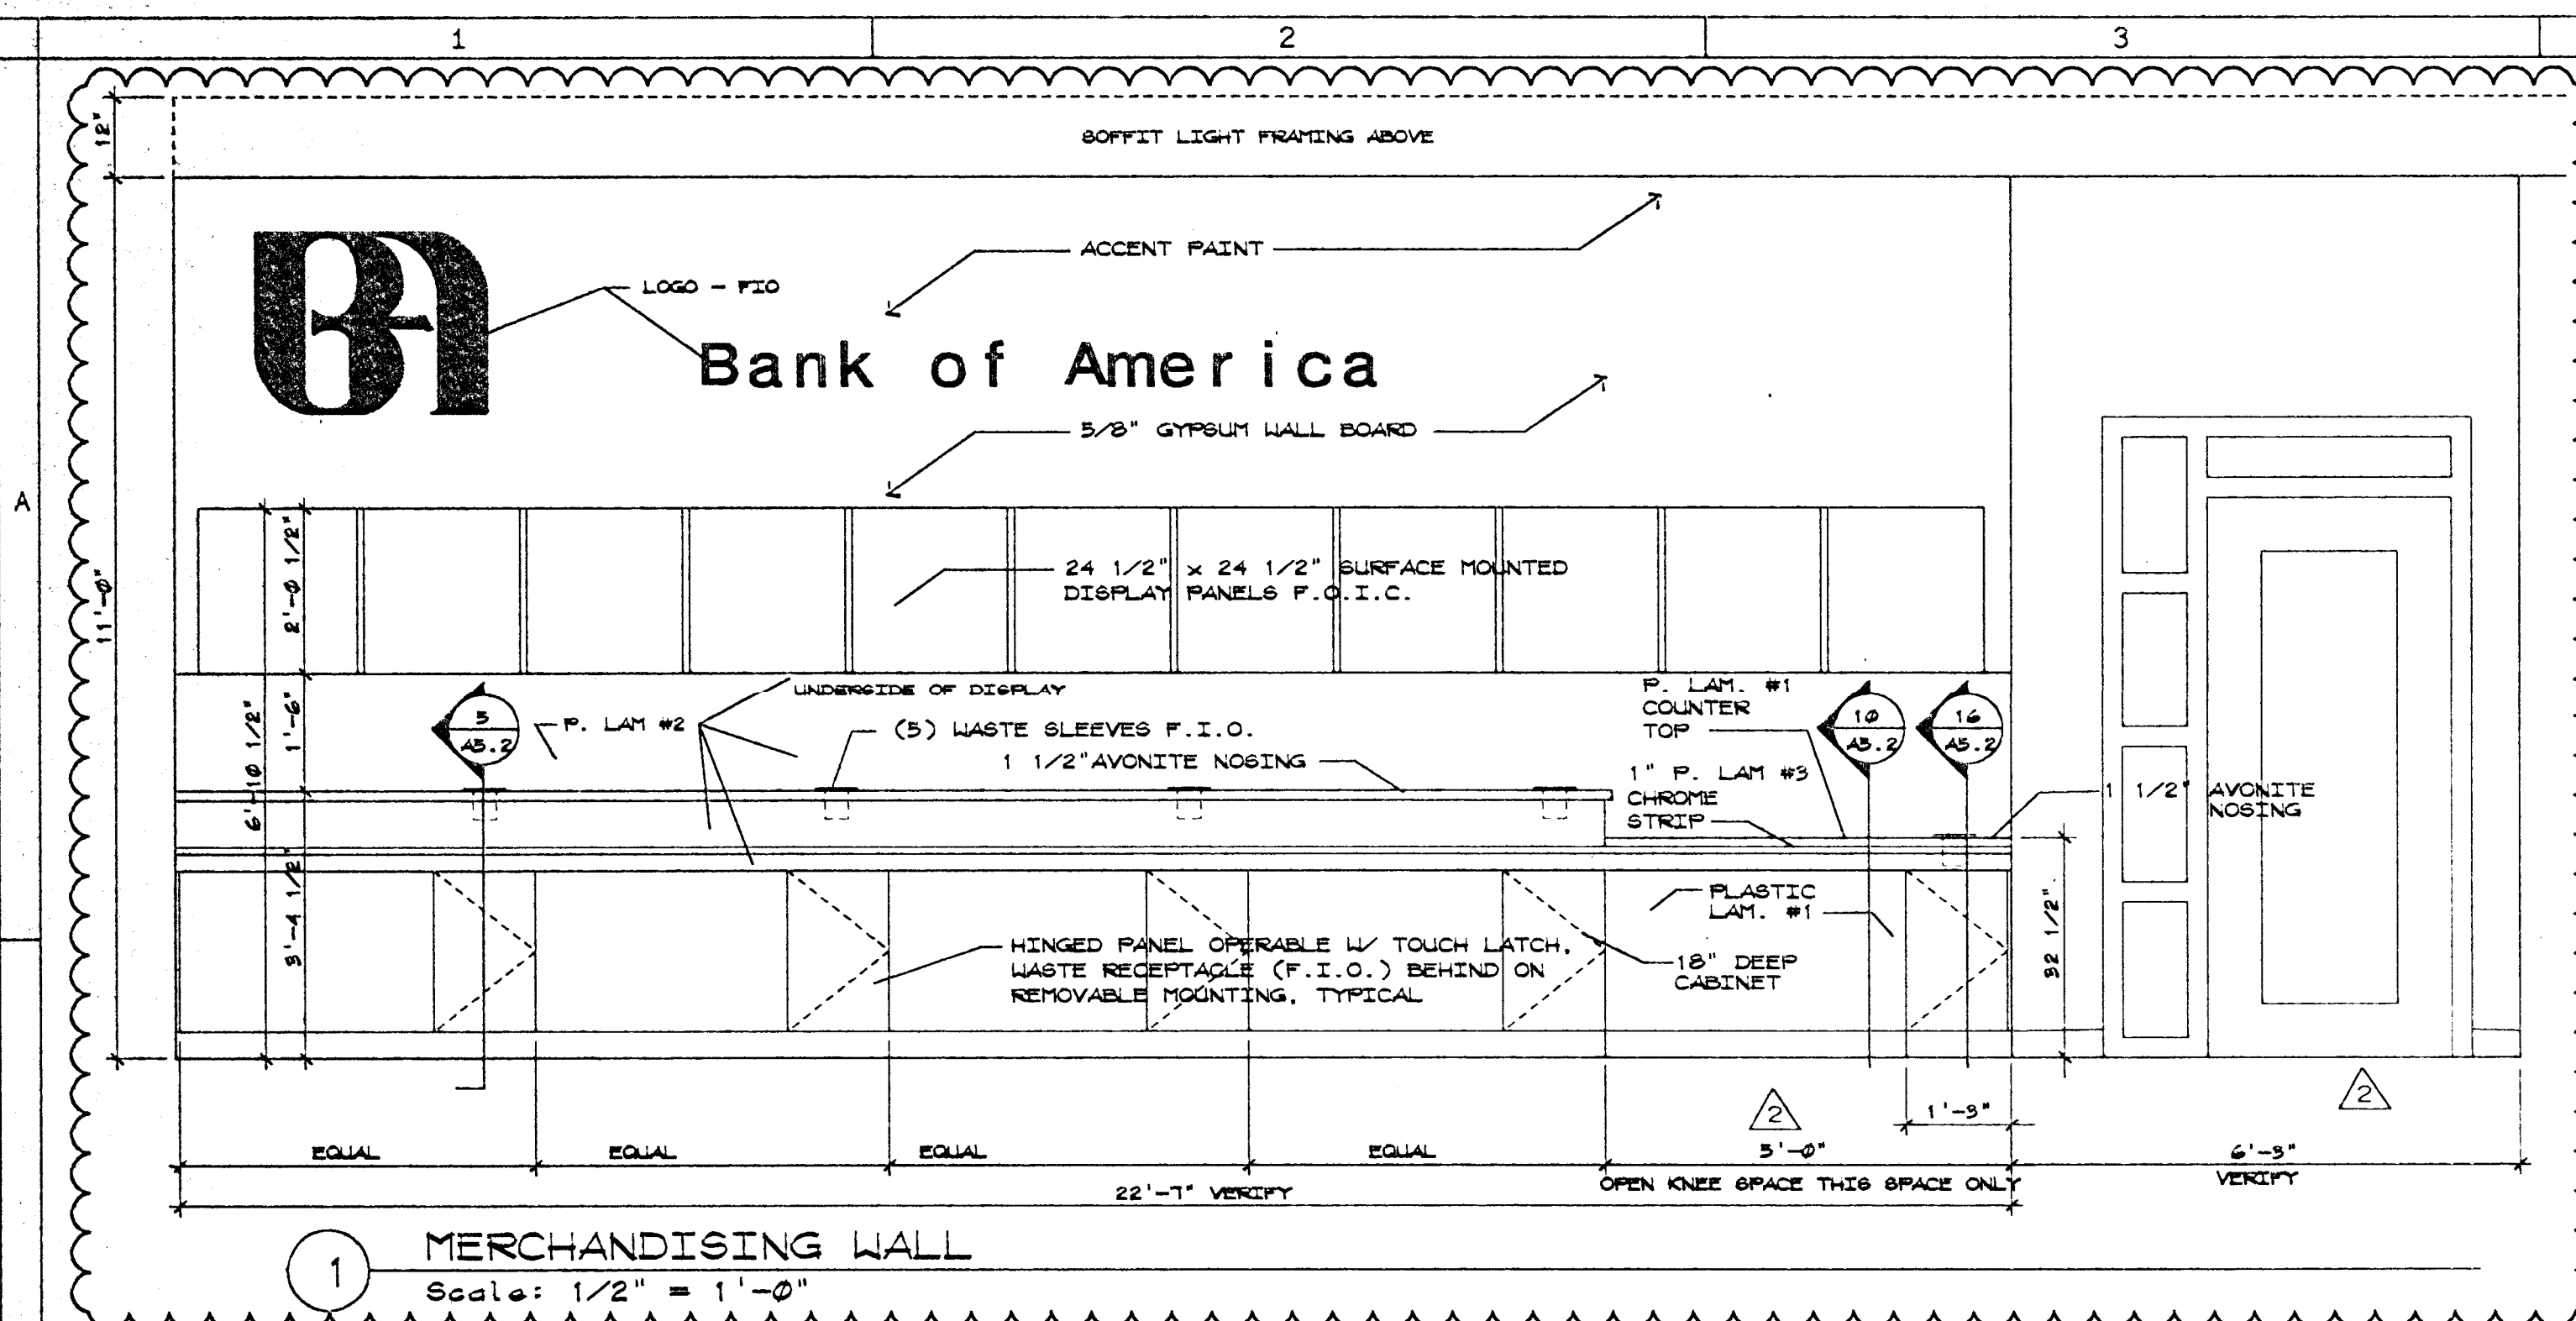


NOTE: DETAILS 13 & 14 REQUIRE FRY REGLET FCM-75 TO BE PROVIDED UNDER SPEC SECTION 07241, EXTERIOR INSULATION & FINISH SYSTEMS-CLASS F.B.

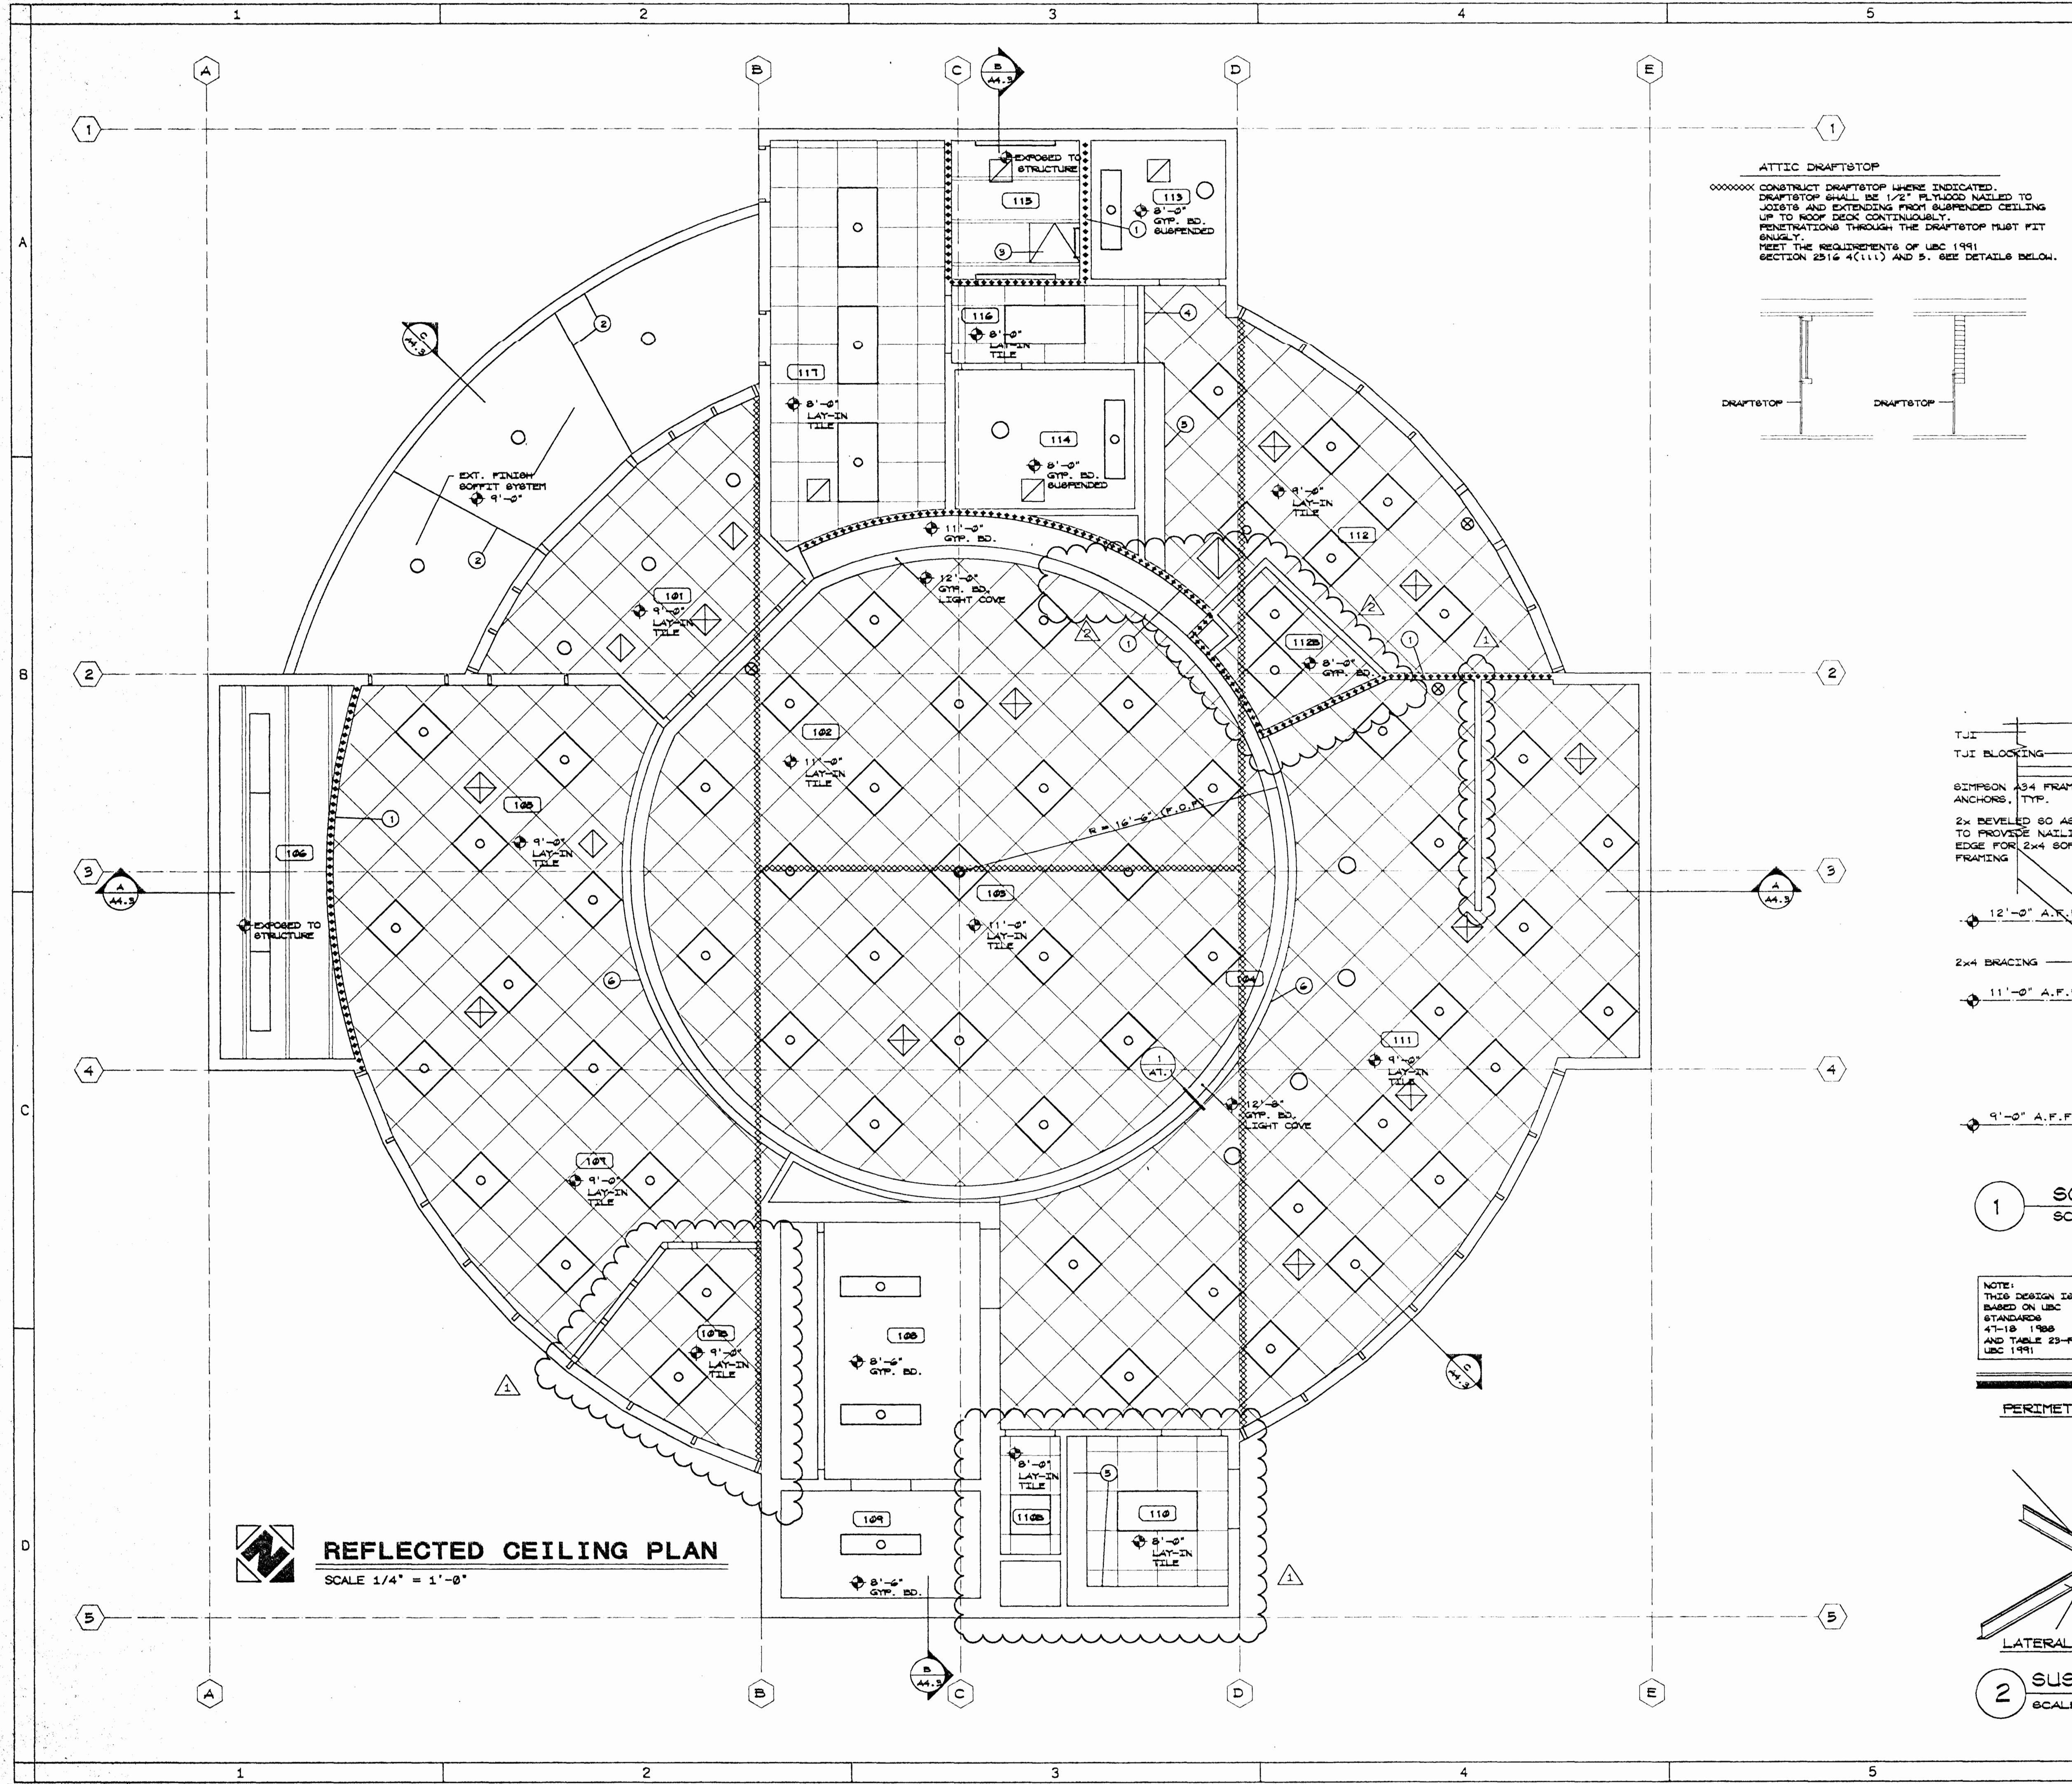

CODED NOTES

- FULL HEIGHT WALL TO UNDERSIDE OF ROOF DECK
- CONTROL JOINT, TYP.
- 2'-0" x 2'-6" ROOF ACCESS HATCH
- GYP. BOARD HEADER AT 7'-11" HEIGHT
- GYP. BOARD SOFFIT AT 7'-0" HEIGHT
- GYP. BOARD HEADER AT 8'-11" HEIGHT
- SIGN - "CASH MACHINE ONLY", F.I.O.
- SIGN - "OPEN/CLOSED" - CENTERED ON DRIVE-UP LANE, F.I.O.
- SIGN - "11'-0" CLEAR", F.I.O.
- SIGN - "12'-6" CLEAR", F.I.O.

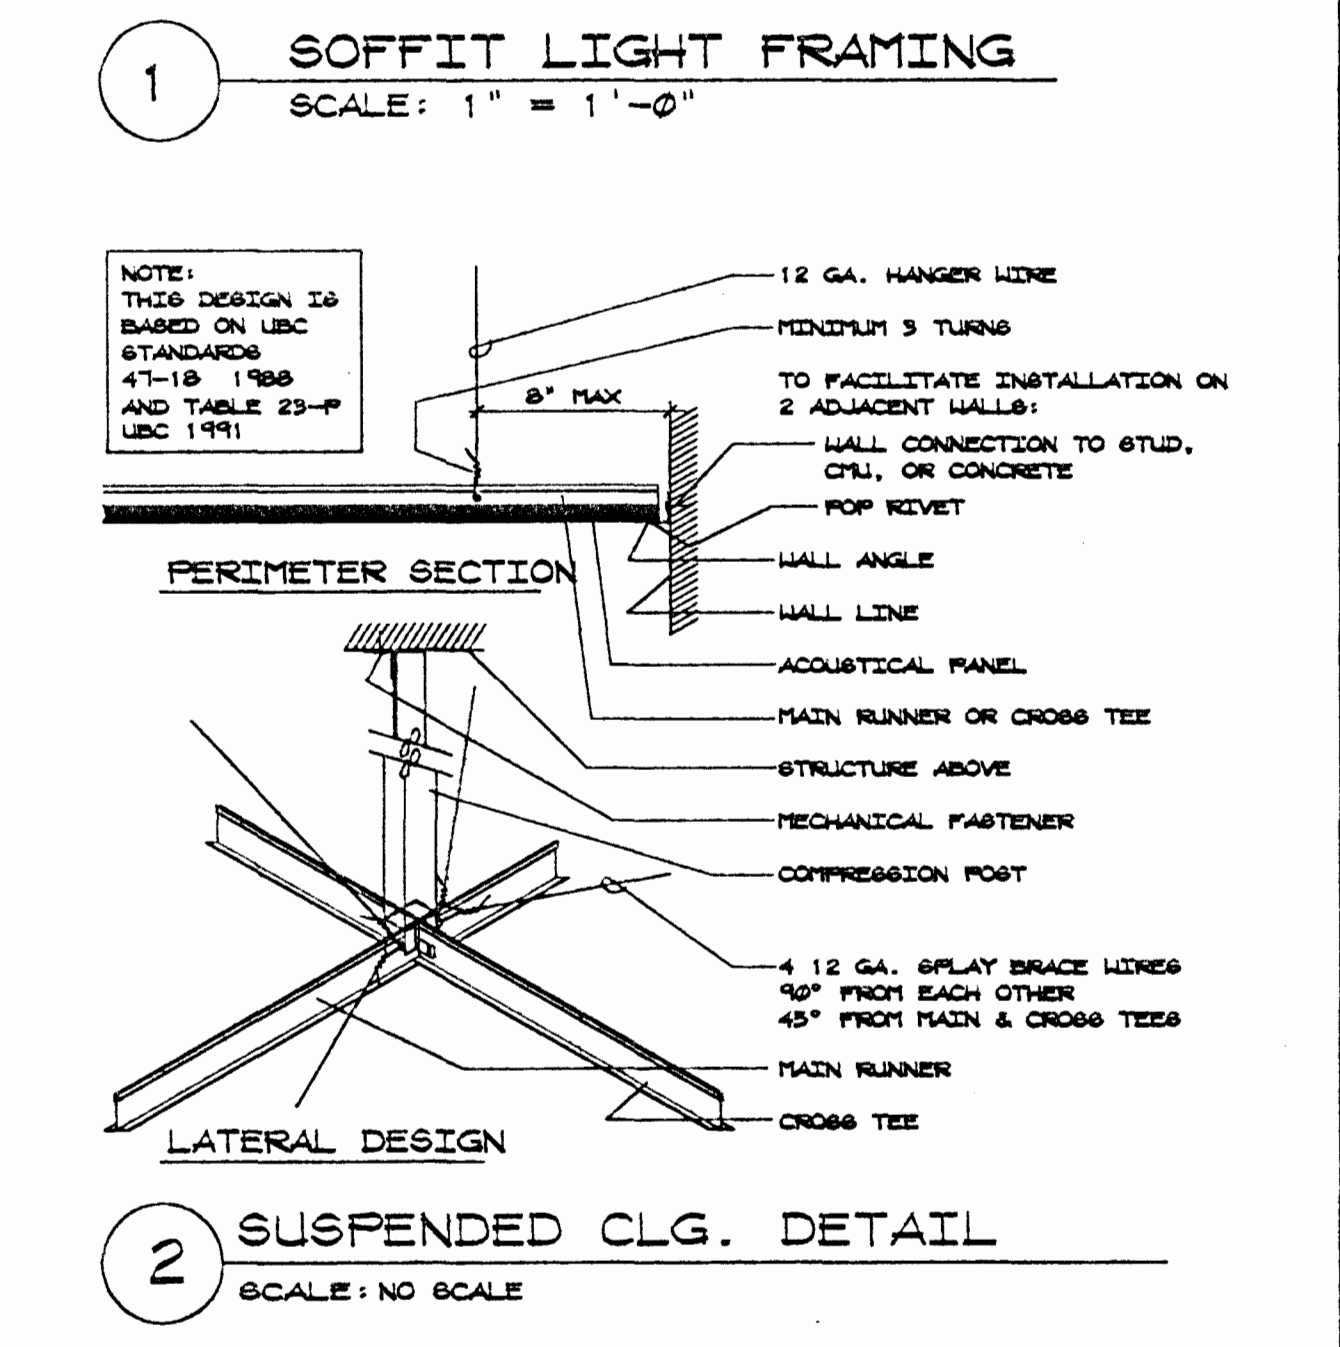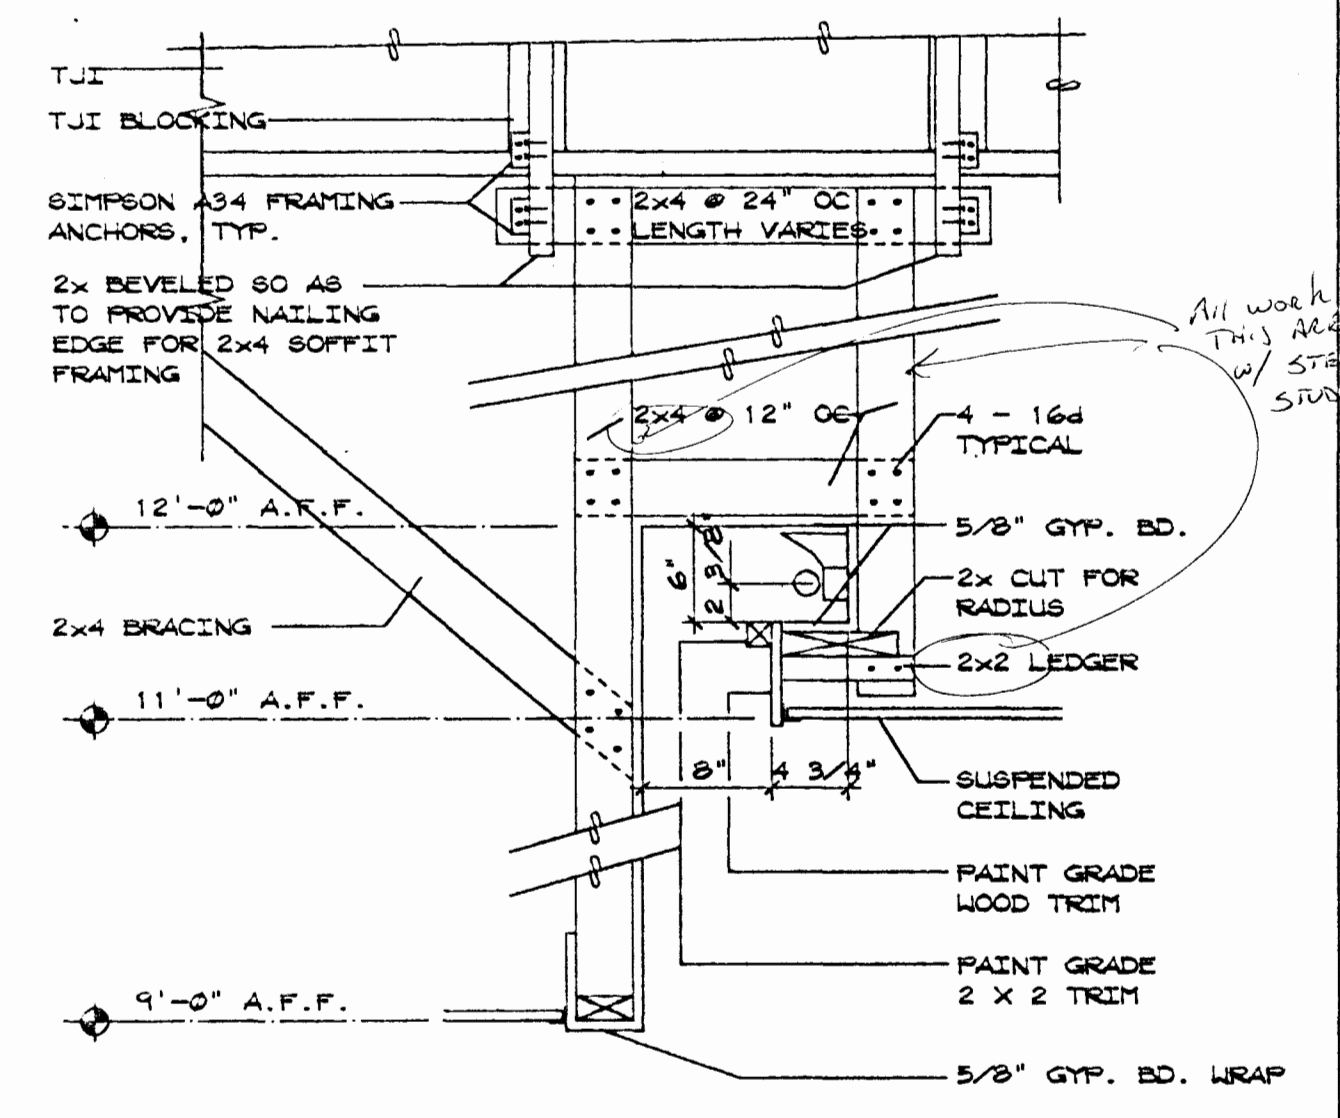



COPYRIGHT 1993
LOWE-CONRAD ARCHITECTS
All rights reserved. Reproduction or translation of any part of this work without written permission of LOWE-CONRAD ARCHITECTS is unlawful and subject to criminal prosecution.

Low Conrad-Conrad
ARCHITECTS
P. A., A. I. A.
1221 SHORELINE LANE BOISE, IDAHO 83702 TEL. (208) 345-6677

BANK OF AMERICA
FAIRVIEW AND MITCHELL
BOISE IDAHO
REFLECTED CEILING PLAN

JOB NO. 99031.01
DATE 9-19-93
DRAWN BY SCH - CHECKED BY SCH
REVISIONS
1 CEILING 3-1-94
2 CEILING 4-1-94

SHEET NO.
A7.1
OF SHEETS

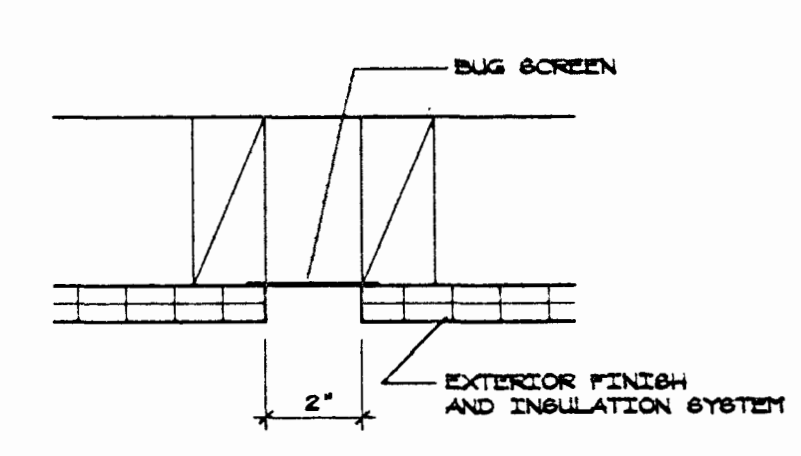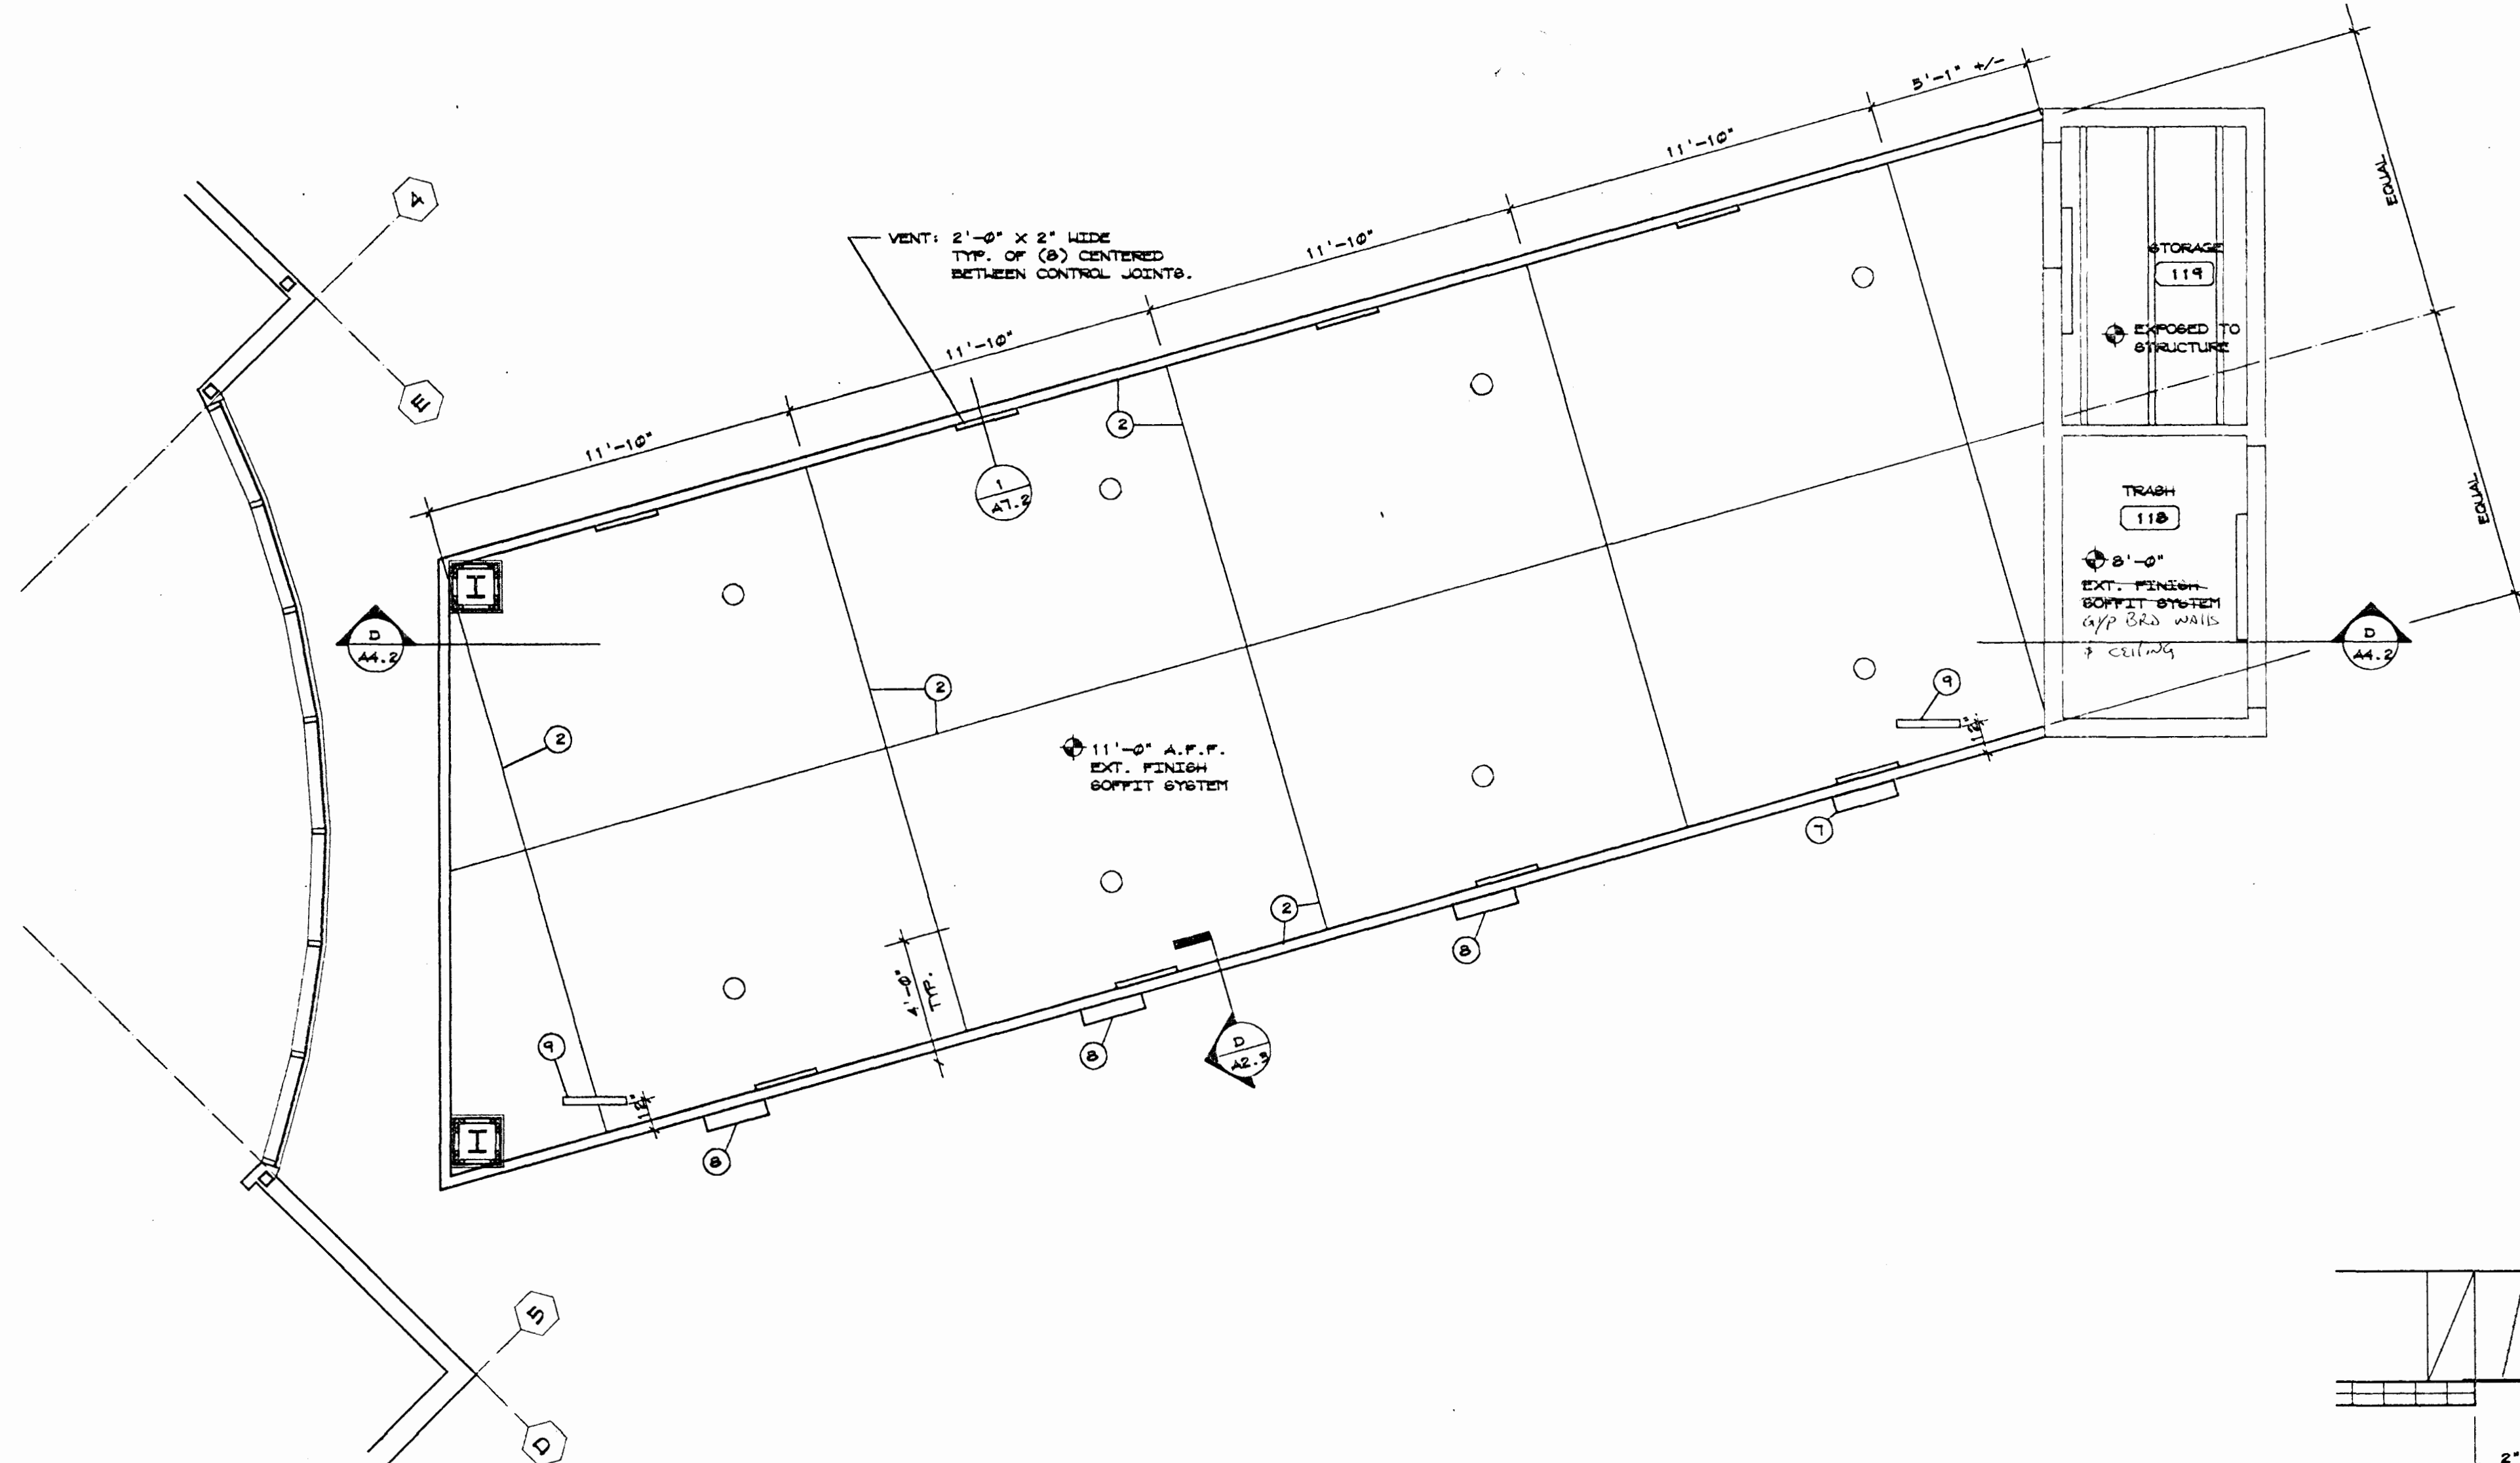





1 VENT DETAIL
SCALE: 3/4" = 1'-0"

 **CANOPY REFLECTED CEILING PLAN**
SCALE 1/4" = 1'-0"

CODED NOTES


- ① FULL HEIGHT WALL TO UNDERSIDE OF ROOF DECK
- ② CONTROL JOINT, TYP.
- ③ 2'-0" x 2'-6" ROOF ACCESS HATCH
- ④ GYPSUM BOARD HEADER AT 7'-11" HEIGHT
- ⑤ GYPSUM BOARD SOFFIT AT 7'-0" HEIGHT
- ⑥ GYPSUM BOARD HEADER AT 8'-11" HEIGHT
- ⑦ SIGN — "CASH MACHINE ONLY", F.I.O.
- ⑧ SIGN — "OPEN/CLOSED" — CENTERED ON DRIVE-UP LANE, F.I.O.
- ⑨ SIGN — "11'-0" CLEAR", F.I.O.

    CEILING PLAN-LEGEND

-  CEILING ACCESS PANEL
-  CEILING HEIGHT
-  LIGHT FIXTURES
-  SUPPLY DIFFUSERS
-  RETURN AIR REGISTER
-  EXIT LIGHT

COPYRIGHT 1993
LOMBARD-CONRAD ARCHITECTS

All rights reserved. Reproduction or translation of any part of this work without written permission of LOMBARD-CONRAD ARCHITECTS is unlawful and subject to criminal prosecution.

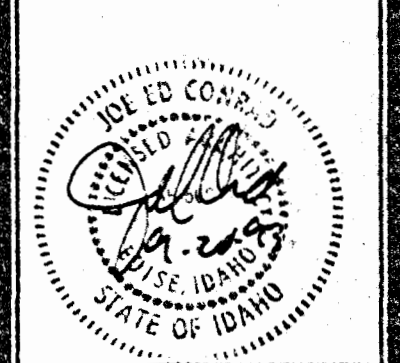

Lombard-Conrad
ARCHITECTS
P. A., A. I. A.
1221 SHORELINE LANE BOISE, IDAHO 83782 TEL. (208) 345-6677

BANK OF AMERICA
FAIRVIEW AND MITCHELL
BOISE IDAHO


CANOPY REFLECTED CLG. PLAN

JOB NO. 93051.01	
DATE 9-13-93	
DRAWN BY DNS	CHECKED BY SCH
REVISIONS	DATE

SHEET NO.

A7.2

OF SHEETS

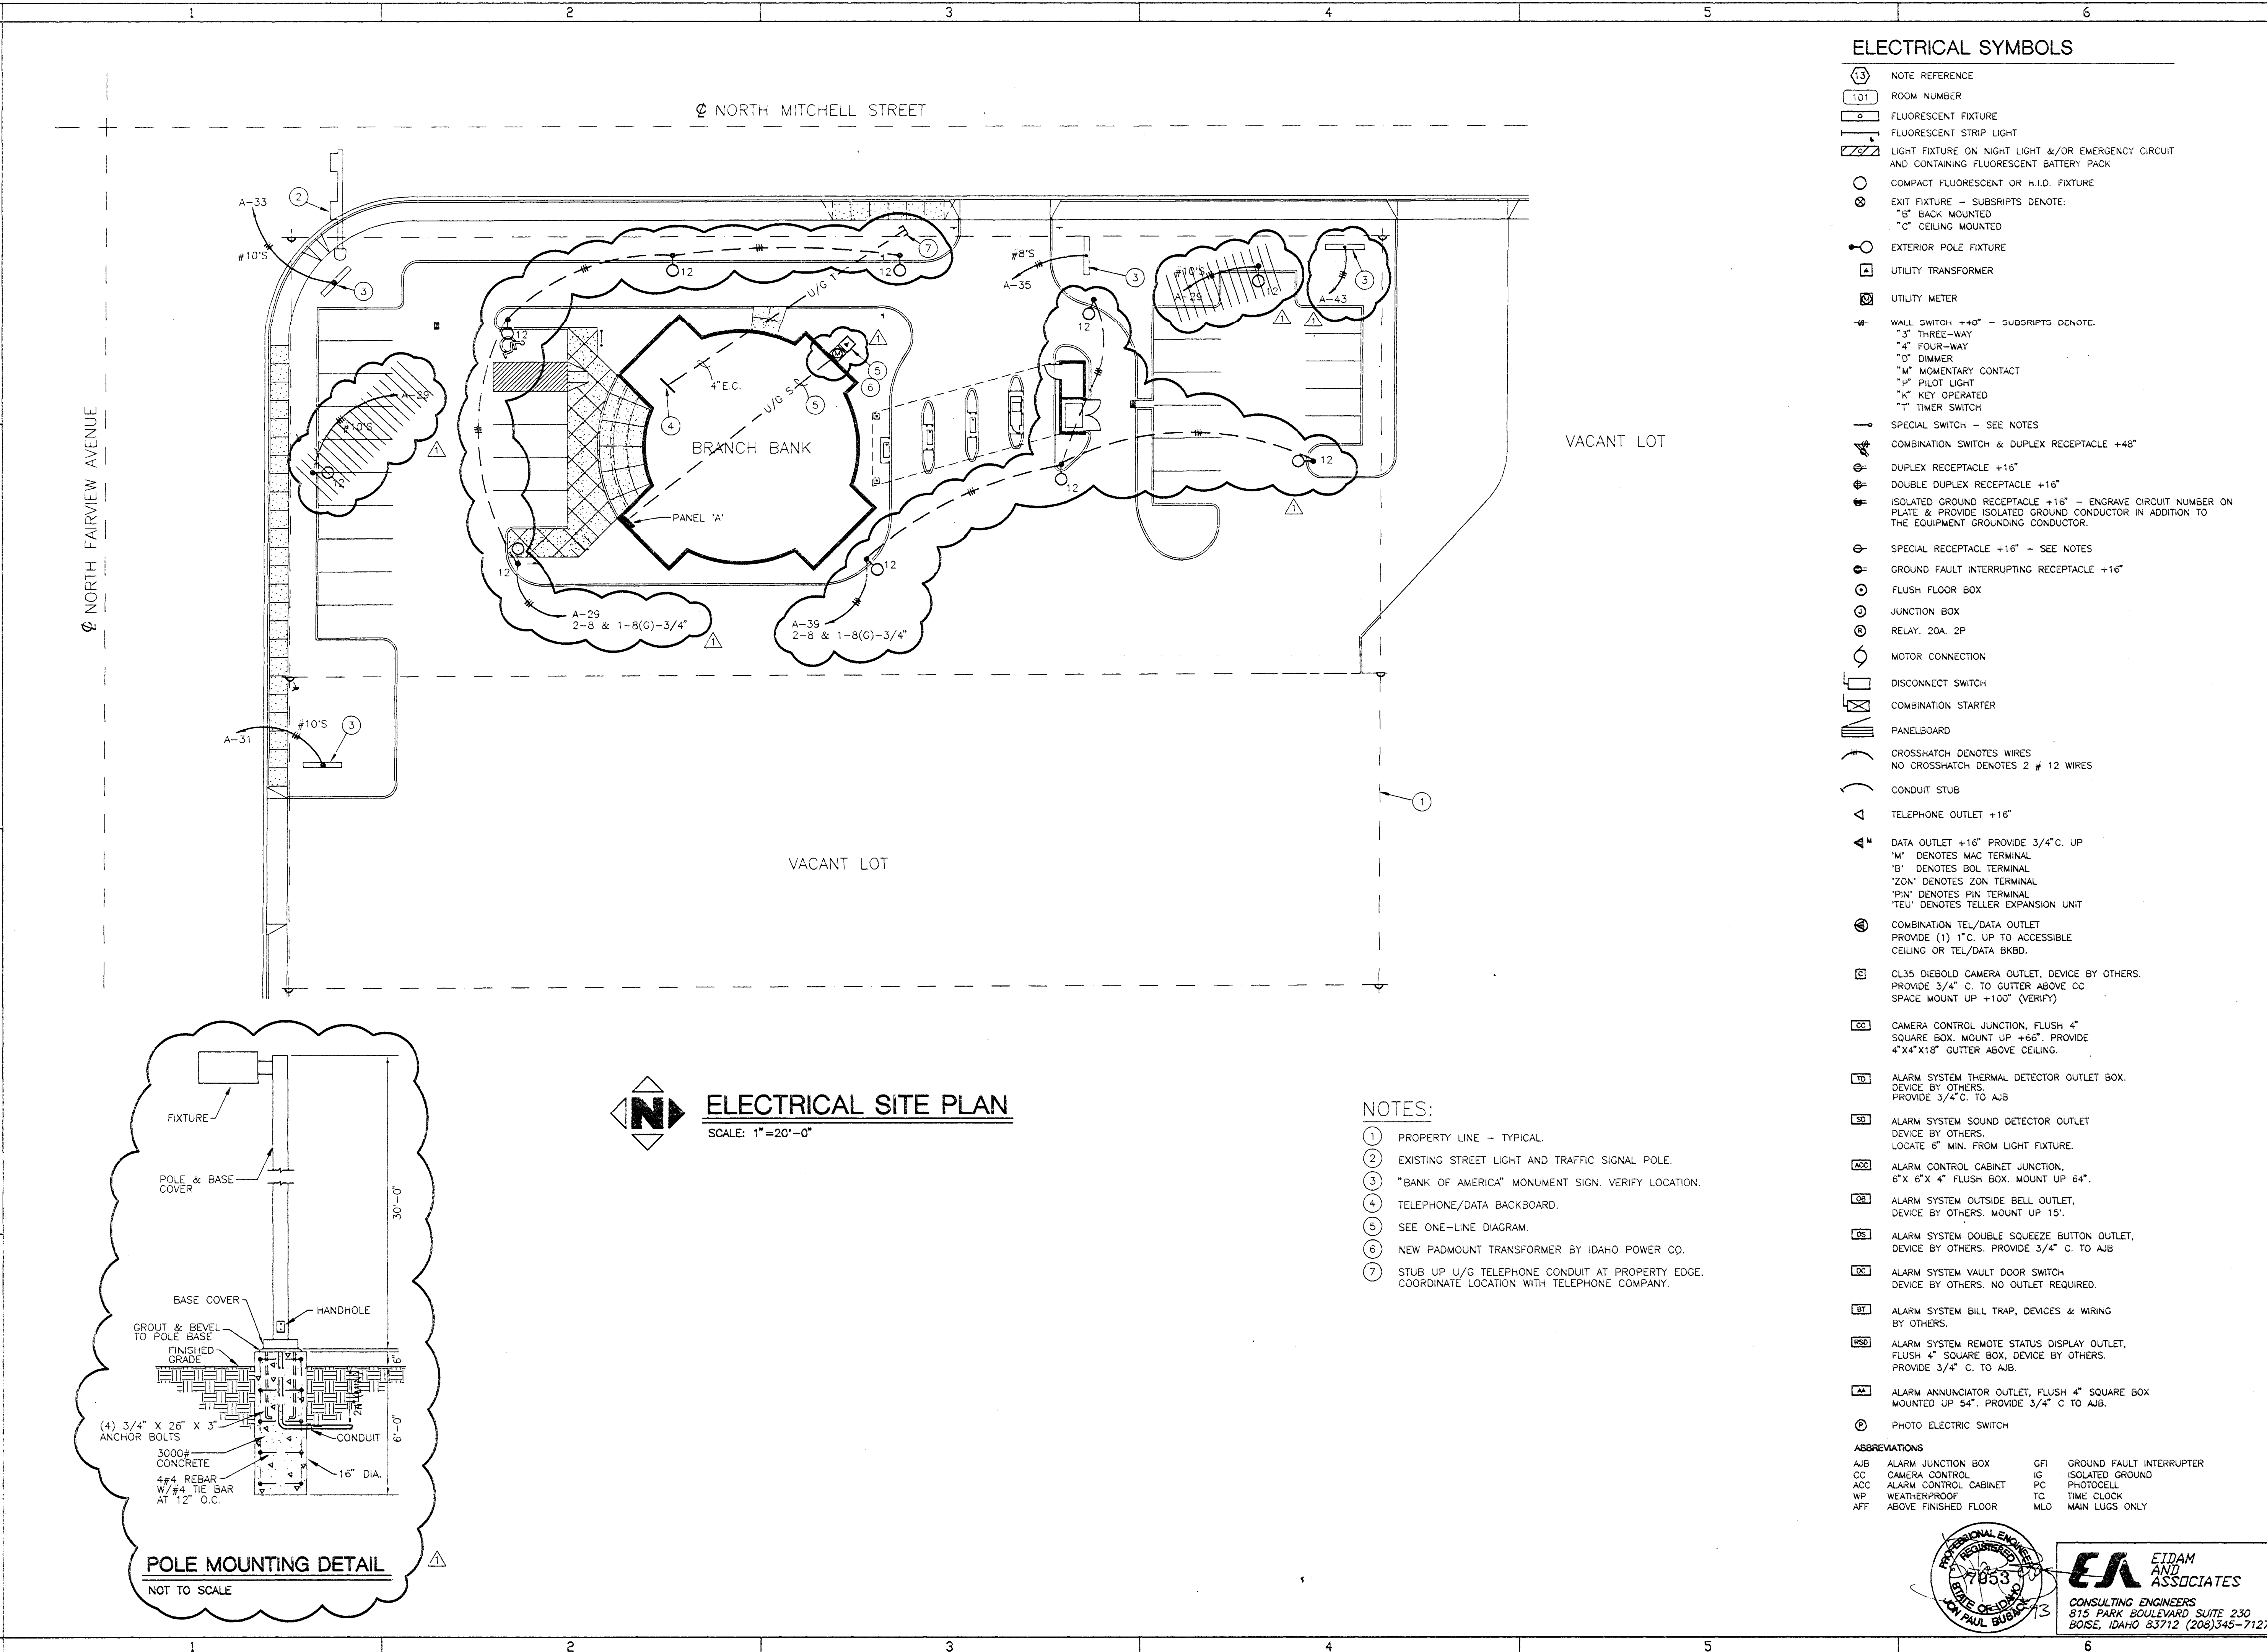


ELECTRICAL SYMBOLS

- NOTE REFERENCE
- ROOM NUMBER
- FLUORESCENT FIXTURE
- FLUORESCENT STRIP LIGHT
- LIGHT FIXTURE ON NIGHT LIGHT &/OR EMERGENCY CIRCUIT AND CONTAINING FLUORESCENT BATTERY PACK
- COMPACT FLUORESCENT OR H.I.D. FIXTURE
- EXIT FIXTURE - SUBSCRIPTS DENOTE:
"B" BACK MOUNTED
"C" CEILING MOUNTED
- EXTERIOR POLE FIXTURE
- UTILITY TRANSFORMER
- UTILITY METER
- WALL SWITCH +40" - SUBSCRIPTS DENOTE:
"3" THREE-WAY
"4" FOUR-WAY
"D" DIMMER
"M" MOMENTARY CONTACT
"P" PILOT LIGHT
"K" KEY OPERATED
"T" TIMER SWITCH
- SPECIAL SWITCH - SEE NOTES
- COMBINATION SWITCH & DUPLEX RECEPTACLE +48"
- DUPLEX RECEPTACLE +16"
- DOUBLE DUPLEX RECEPTACLE +16"
- ISOLATED GROUND RECEPTACLE +16" - ENGRAVE CIRCUIT NUMBER ON PLATE & PROVIDE ISOLATED GROUND CONDUCTOR IN ADDITION TO THE EQUIPMENT GROUNDING CONDUCTOR.
- SPECIAL RECEPTACLE +16" - SEE NOTES
- GROUND FAULT INTERRUPTING RECEPTACLE +16"
- FLUSH FLOOR BOX
- JUNCTION BOX
- RELAY, 20A, 2P
- MOTOR CONNECTION
- DISCONNECT SWITCH
- COMBINATION STARTER
- PANELBOARD
- CROSSHATCH DENOTES WIRES
NO CROSSHATCH DENOTES 2 # 12 WIRES
- CONDUIT STUB
- TELEPHONE OUTLET +16"
- DATA OUTLET +16" PROVIDE 3/4" C. UP
"M" DENOTES MAC TERMINAL
"B" DENOTES BOL TERMINAL
"ZON" DENOTES ZON TERMINAL
"PIN" DENOTES PIN TERMINAL
"TEU" DENOTES TELLER EXPANSION UNIT
- COMBINATION TEL/DATA OUTLET
PROVIDE (1) 1" C. UP TO ACCESSIBLE
CEILING OR TEL/DATA BKBD.
- CL35 DIEBOLD CAMERA OUTLET, DEVICE BY OTHERS.
PROVIDE 3/4" C. TO GUTTER ABOVE CC
SPACE MOUNT UP +100" (VERIFY)
- CAMERA CONTROL JUNCTION, FLUSH 4" SQUARE BOX, MOUNT UP +66". PROVIDE 4"x4"x18" GUTTER ABOVE CEILING.
- ALARM SYSTEM THERMAL DETECTOR OUTLET BOX, DEVICE BY OTHERS.
PROVIDE 3/4" C. TO AJB
- ALARM SYSTEM SOUND DETECTOR OUTLET
DEVICE BY OTHERS.
LOCATE 6" MIN. FROM LIGHT FIXTURE.
- ALARM CONTROL CABINET JUNCTION, 6"x6"x4" FLUSH BOX, MOUNT UP 64".
- ALARM SYSTEM OUTSIDE BELL OUTLET, DEVICE BY OTHERS, MOUNT UP 15".
- ALARM SYSTEM DOUBLE SQUEEZE BUTTON OUTLET, DEVICE BY OTHERS, PROVIDE 3/4" C. TO AJB
- ALARM SYSTEM VAULT DOOR SWITCH
DEVICE BY OTHERS, NO OUTLET REQUIRED.
- ALARM SYSTEM BILL TRAP, DEVICES & WIRING BY OTHERS.
- ALARM SYSTEM REMOTE STATUS DISPLAY OUTLET, FLUSH 4" SQUARE BOX, DEVICE BY OTHERS.
PROVIDE 3/4" C. TO AJB.
- ALARM ANNUNCIATOR OUTLET, FLUSH 4" SQUARE BOX MOUNTED UP 54". PROVIDE 3/4" C. TO AJB.
- PHOTO ELECTRIC SWITCH

ABBREVIATIONS	
AJB	ALARM JUNCTION BOX
CC	CAMERA CONTROL
ACC	ALARM CONTROL CABINET
WP	WEATHERPROOF
AFF	ABOVE FINISHED FLOOR
GFI	GROUND FAULT INTERRUPTER
IG	ISOLATED GROUND
PC	PHOTOCELL
TC	TIME CLOCK
MLO	MAIN LUGS ONLY


- NOTES:
- 1 PROPERTY LINE - TYPICAL.
 - 2 EXISTING STREET LIGHT AND TRAFFIC SIGNAL POLE.
 - 3 "BANK OF AMERICA" MONUMENT SIGN. VERIFY LOCATION.
 - 4 TELEPHONE/DATA BACKBOARD.
 - 5 SEE ONE-LINE DIAGRAM.
 - 6 NEW PADMOUNT TRANSFORMER BY IDAHO POWER CO.
 - 7 STUB UP U/G TELEPHONE CONDUIT AT PROPERTY EDGE. COORDINATE LOCATION WITH TELEPHONE COMPANY.

ELECTRICAL SITE PLAN
SCALE: 1"=20'-0"

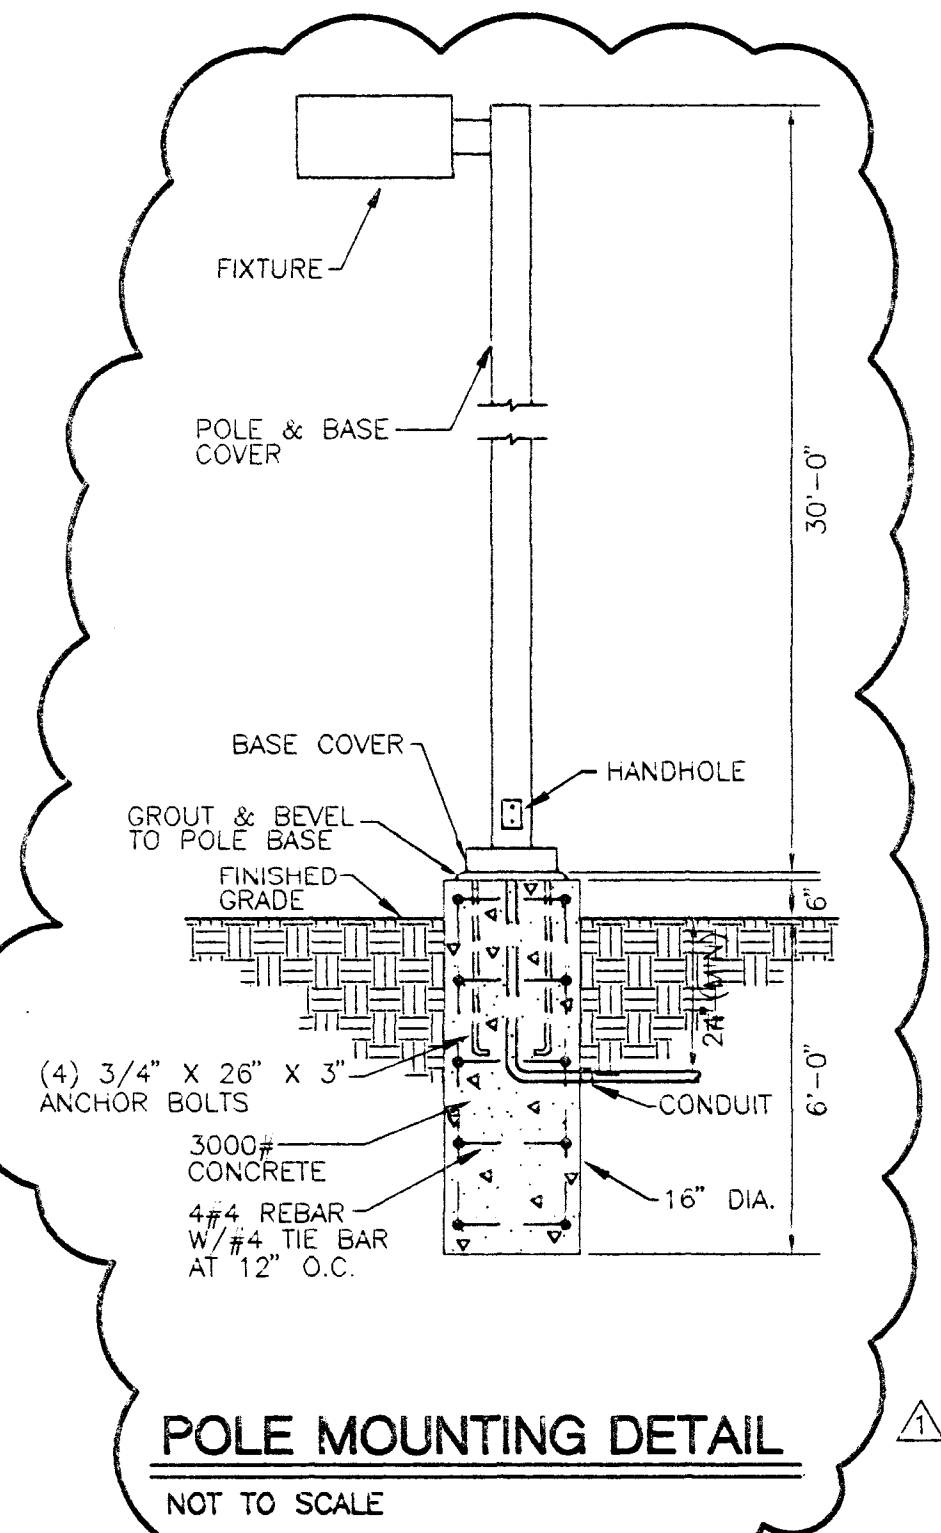


Lombard-Conrad
ARCHITECTS
1221 SHORELINE LANE BOISE, IDAHO 83725 TEL (208)345-6677

BANK OF AMERICA
FAIRVIEW AND MITCHELL
BOISE IDAHO

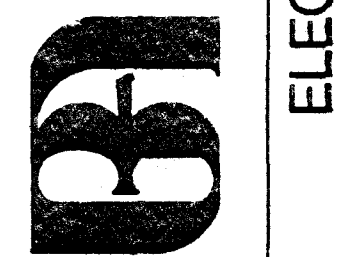


JOB NO.	93031.01
DATE	9-15-93
DRAWN BY	DME
CHECKED BY	PB/GE
REVISIONS	
FLOOR PLAN	3/21/94

SHEET NO.
E1.0

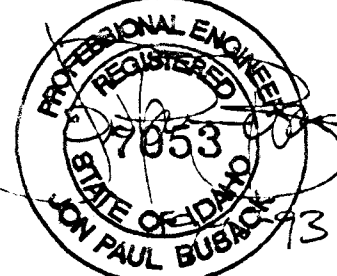

EJ EJDAM AND ASSOCIATES
CONSULTING ENGINEERS
815 PARK BOULEVARD, SUITE 230
BOISE, IDAHO 83712 (208)345-7127

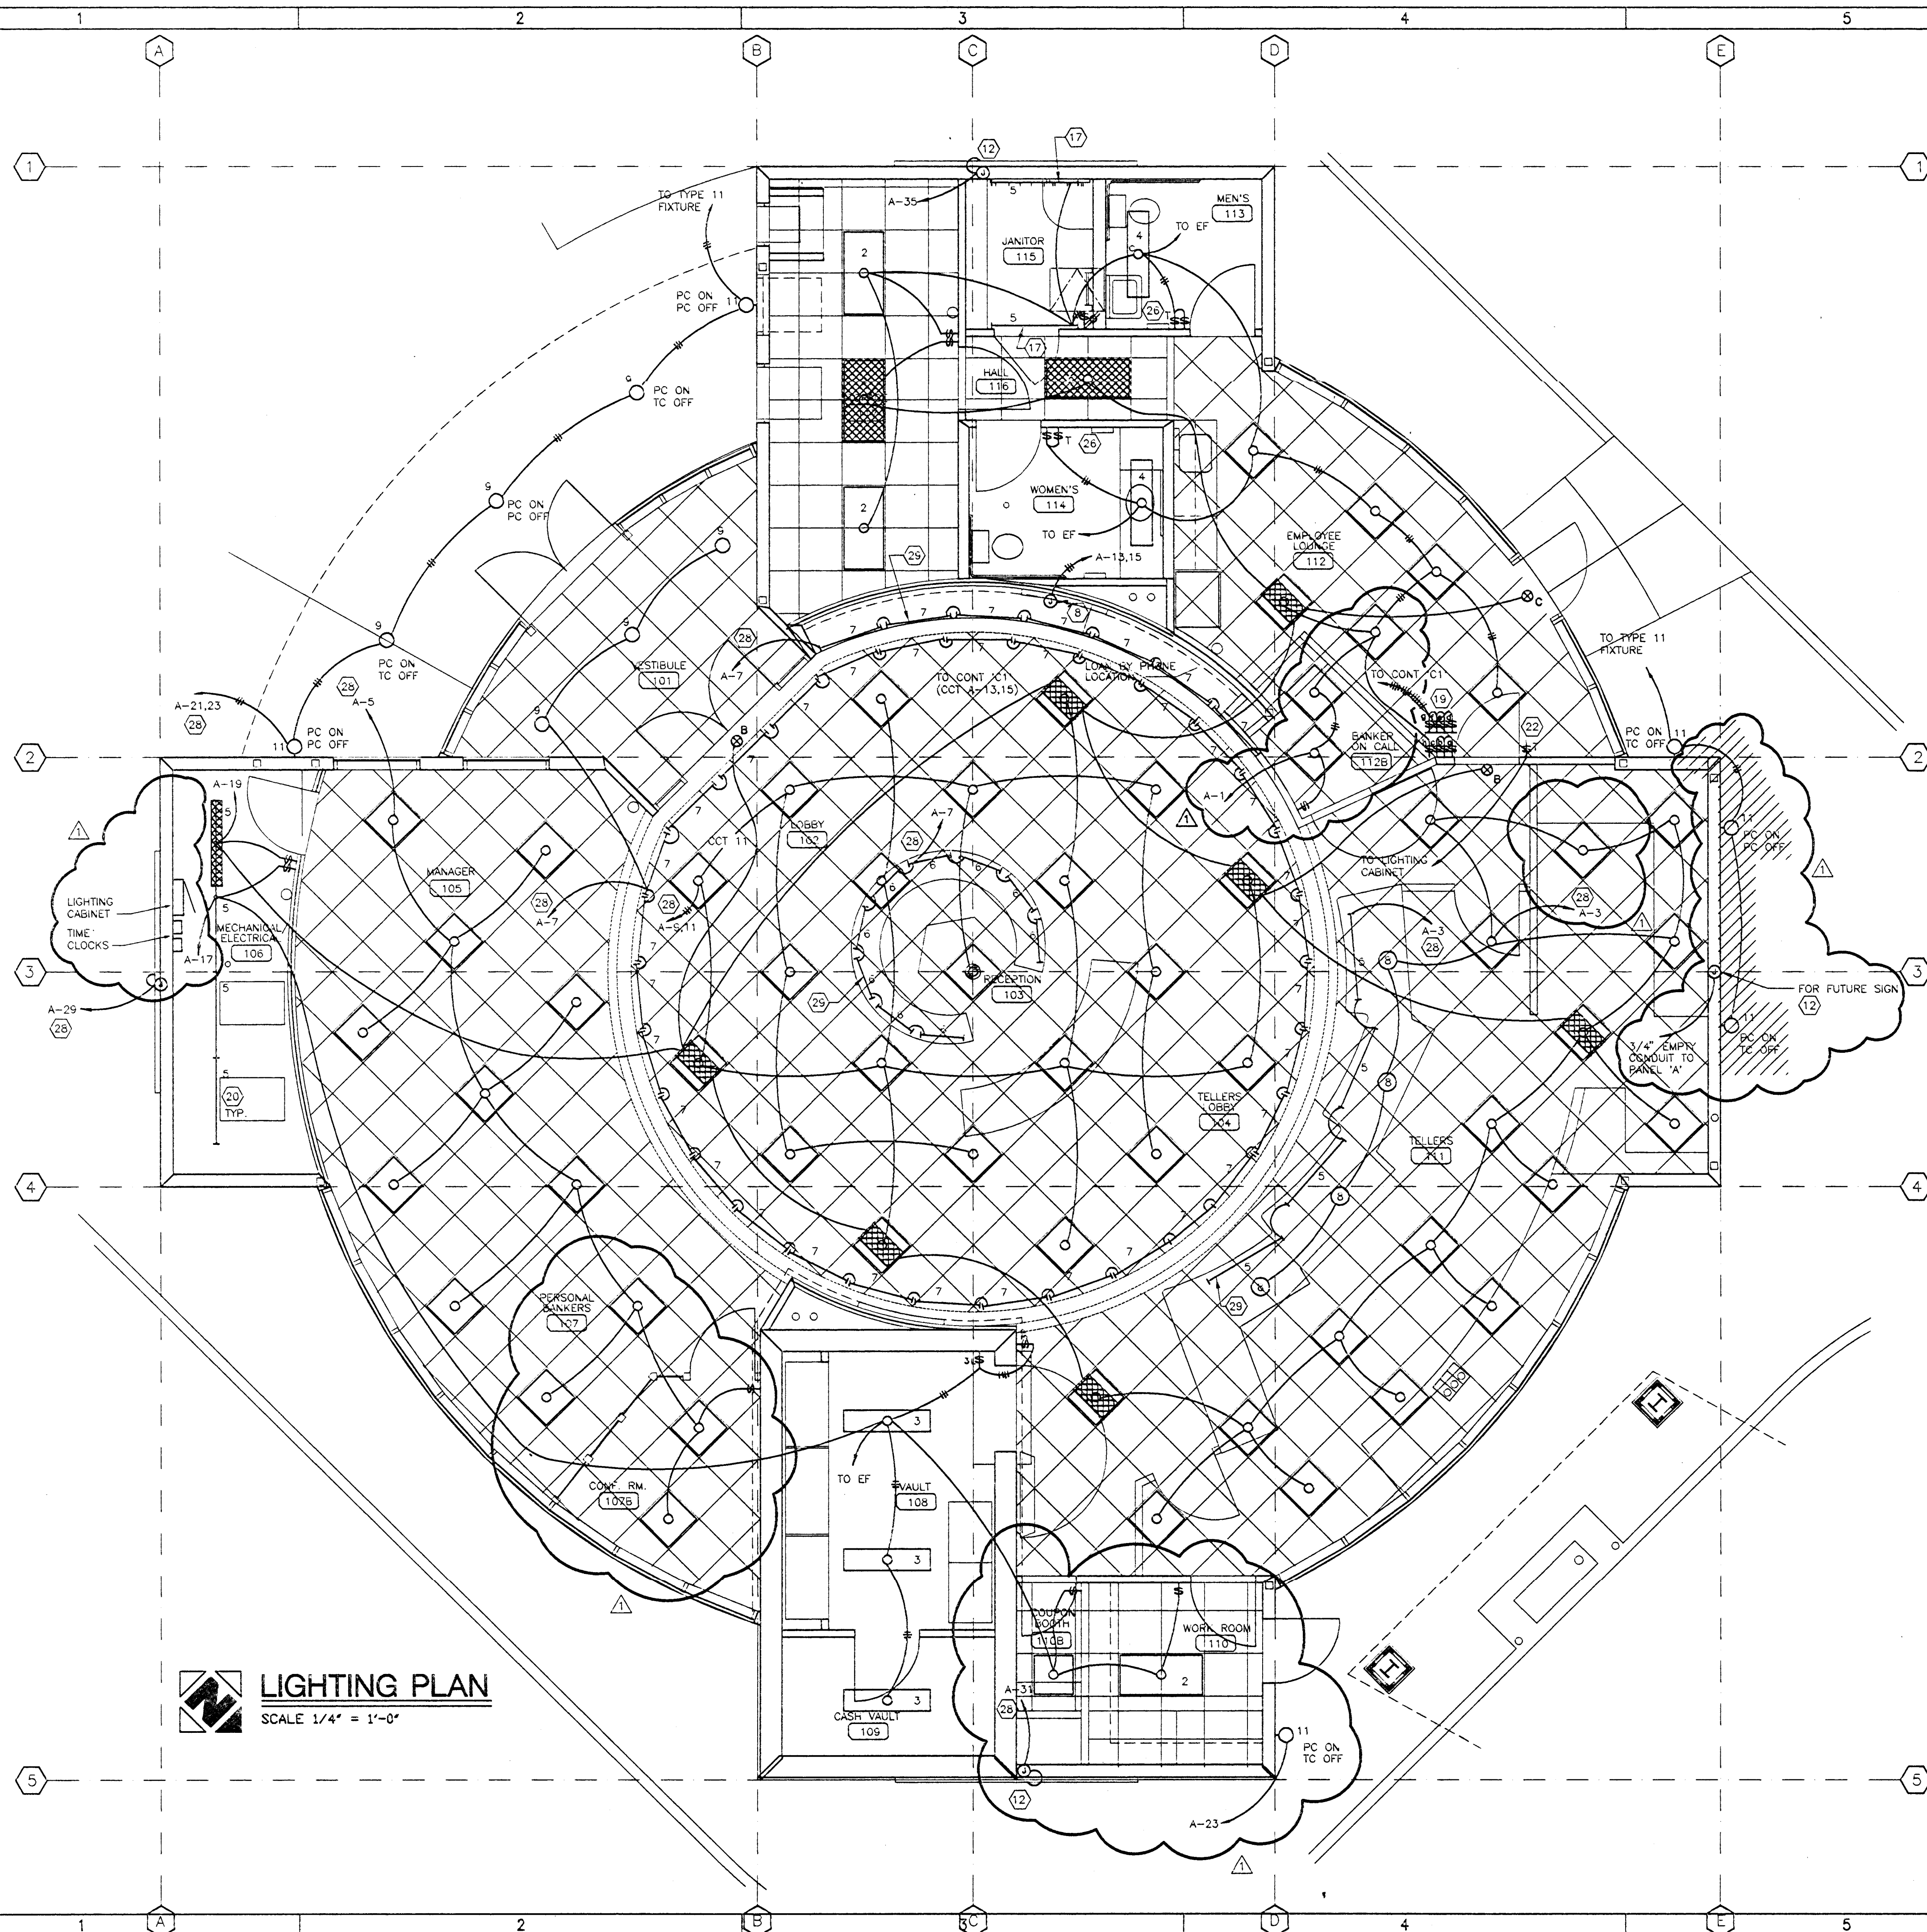

ELECTRICAL NOTES


- (1) OUTLET BOX & WP SWITCH FOR OWNER PROVIDED DRIVE-UP LANE SIGNS.
- (2) STUB CONDUITS UP 3" THROUGH BUCK PLAT OPENINGS. (TYPICAL)
- (3) (4) MAINTAINED SPDT - CENTER OFF SWITCHES IN A 4-GANG PLATE. ENGRAVE PLATE ABOVE EACH SWITCH "OPEN" & BELOW EACH SWITCH "CLOSED". ENGRAVE ACROSS THE TOP OF THE PLATE "DRIVE UP SIGNS".
- (4) CANOPY LIGHT OVER-RIDE SWITCH ENGRAVE PLATE "LIGHTING OVERRIDE".
- (5) PROVIDE TIME DELAY RELAY FOR EXHAUST FAN TO ALLOW FAN TO RUN 5 MINUTES AFTER LIGHT IS SWITCHED OFF.
- (6) PROVIDE ALARM & POWER CONNECTIONS TO NIGHT DEPOSIT AS DIRECTED BY SUPPLIER.
- (7) MOUNT 4" SQUARE J-BOX FLUSH WITH CONCRETE ENCLOSURE AS DIRECTED AT NIGHT DEPOSIT SUPPLIER.
- (8) JUNCTION BOX IN ACCESSIBLE CEILING TO SERVE ILLUMINATED MARKETING DISPLAYS. PROVIDE FLEX CONNECTION APPROXIMATELY 72" ABOVE FLOOR. VERIFY ALL REQUIREMENTS WITH DISPLAY SUPPLIER.
- (9) SEE ELEVATION AT ATM FOR ARRANGEMENT OF OUTLETS SERVING THE ATM'S.
- (10) SEE ELEVATION AT TELLER STATION FOR ARRANGEMENT OF OUTLETS SERVING THE TELLER LINE.
- (11) PROVIDE PLASTIC SHATTER-SHIELD SLEEVES FOR LAMPS BELOW COUNTER VALENCE.
- (12) CONNECTION TO ILLUMINATED SIGN VERIFY ROUGH-IN & CONNECTION REQUIREMENTS WITH SIGN SUPPLIER.
- (13) ALL RACEWAYS PASSING THRU THE CEILING OR WALLS OF THE VAULT SHALL BE OFFSET WITHIN THE CEILING OR WALL BY 2" MINIMUM.
- (14) CONNECTIONS TO VAULT VENTILATOR VERIFY ROUGH-IN & CONNECTION REQUIREMENTS WITH VENTILATOR SUPPLIER.
- (15) SINGLE NEMA 5-20R RECEPTACLE FOR COPIER.
- (16) OUTLETS FOR CONNECTION OF POWER, TELEPHONE/DATA & ALARM TO THE FURNITURE PARTITION. MAKE EACH CONDUIT CONNECTION AND THE POWER CONNECTION.
- (17) PROVIDE WIRE GUARDS & MOUNT ON WALL AT 8'-0".
- (18) PROVIDE WIRE GUARD & COLD WEATHER BALLAST. MOUNT UP 8'-0".
- (19) (2) 4-GANG SWITCH PLATES, STACKED.

SWITCH	CIRCUIT	ENGRAVING
A	A-1	LOUNGE
B	A-3	TELLERS
C	A-5	OFFICES
D	A-7	RECEPTION
E	A-9	LOBBY
F	A-11	LOBBY
G	A-13	MERCHANDISING
H	A-15	MERCHANDISING

- (20) PROVIDE WIRE GUARD, MOUNT ON CONTINUOUS UNI-STRUT SUSPENDED FROM ROOF STRUCTURE WITH CHAIN AT 8'-6" AFF.
- (21) 750W, 120V FAN FORCED WALL HEATER. VERTICALLY MOUNTED UP 12" AFF. ELECTROMODE #EPWH08LT.
- (22) 2-HOUR SPRING WOUND OVER RIDE SWITCH FOR INTERIOR LIGHTING. SEE LIGHTING CONTROL DIAGRAM.
- (23) NOT USED.
- (24) PROVIDE WEATHERPROOF, GFI RECEPTACLE ON THE ROOF NEAR THE MECHANICAL EQUIPMENT.
- (26) TIMER SWITCH, 2 HOUR WITH NO HOLD. MARK TIME #93 SERIES.
- (27) TIMER SWITCH, 24 HR INTERMATIC #1010.
- (28) THRU CONTACTOR. SEE LIGHTING CONTROL DIAGRAM.
- (29) MILLWORK COVE LIGHTING. SEE ARCHITECTURAL DETAILS.
- (30) COORDINATE ALL ALARM OUTLET LOCATIONS WITH SECURITY SYSTEM VENDOR PRIOR TO ROUGH-IN.
- (31) LOCATE CAMERA CONTROL ABOVE ALARM ANNUNCIATOR.
- (32) ALL DEVICES ALONG THIS COUNTER SHALL BE INSTALLED FACE UP IN TROUGH IMMEDIATELY BELOW WINDOW FRAME. SEE ARCHITECTURAL DETAILS.
- (33) (1) 1/2" C WITH 8#14'S TO RESPECTIVE FURNACE. COORDINATE WITH MECHANICAL FOR FINAL TERMINATIONS.
- (34) (1) 1/2" C WITH 2#14'S TO RESPECTIVE CONDENSING UNIT. COORDINATE WITH MECHANICAL FOR FINAL TERMINATIONS.

Lombard-Conrad
ARCHITECTS
1221 SHORELINE LANE BOISE, IDAHO
P. A., A. I. A. TEL (208) 345-6877

BANK OF AMERICA
FAIRVIEW AND MITCHELL
BOISE, IDAHO
LIGHTING PLAN

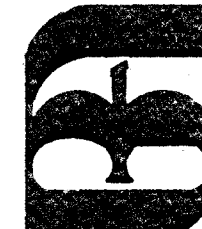


JOB NO. 93031.01
DATE 9-15-93
DRAWN BY TIME
CHECKED BY PB/GE
REVISIONS DATE
FLOOR PLAN 3/21/94

SHEET NO.

E2.1

OF SHEETS


E.A. EIDAM AND ASSOCIATES
CONSULTING ENGINEERS
815 PARK BOULEVARD SUITE 230
BOISE, IDAHO 83712 (208) 345-7127

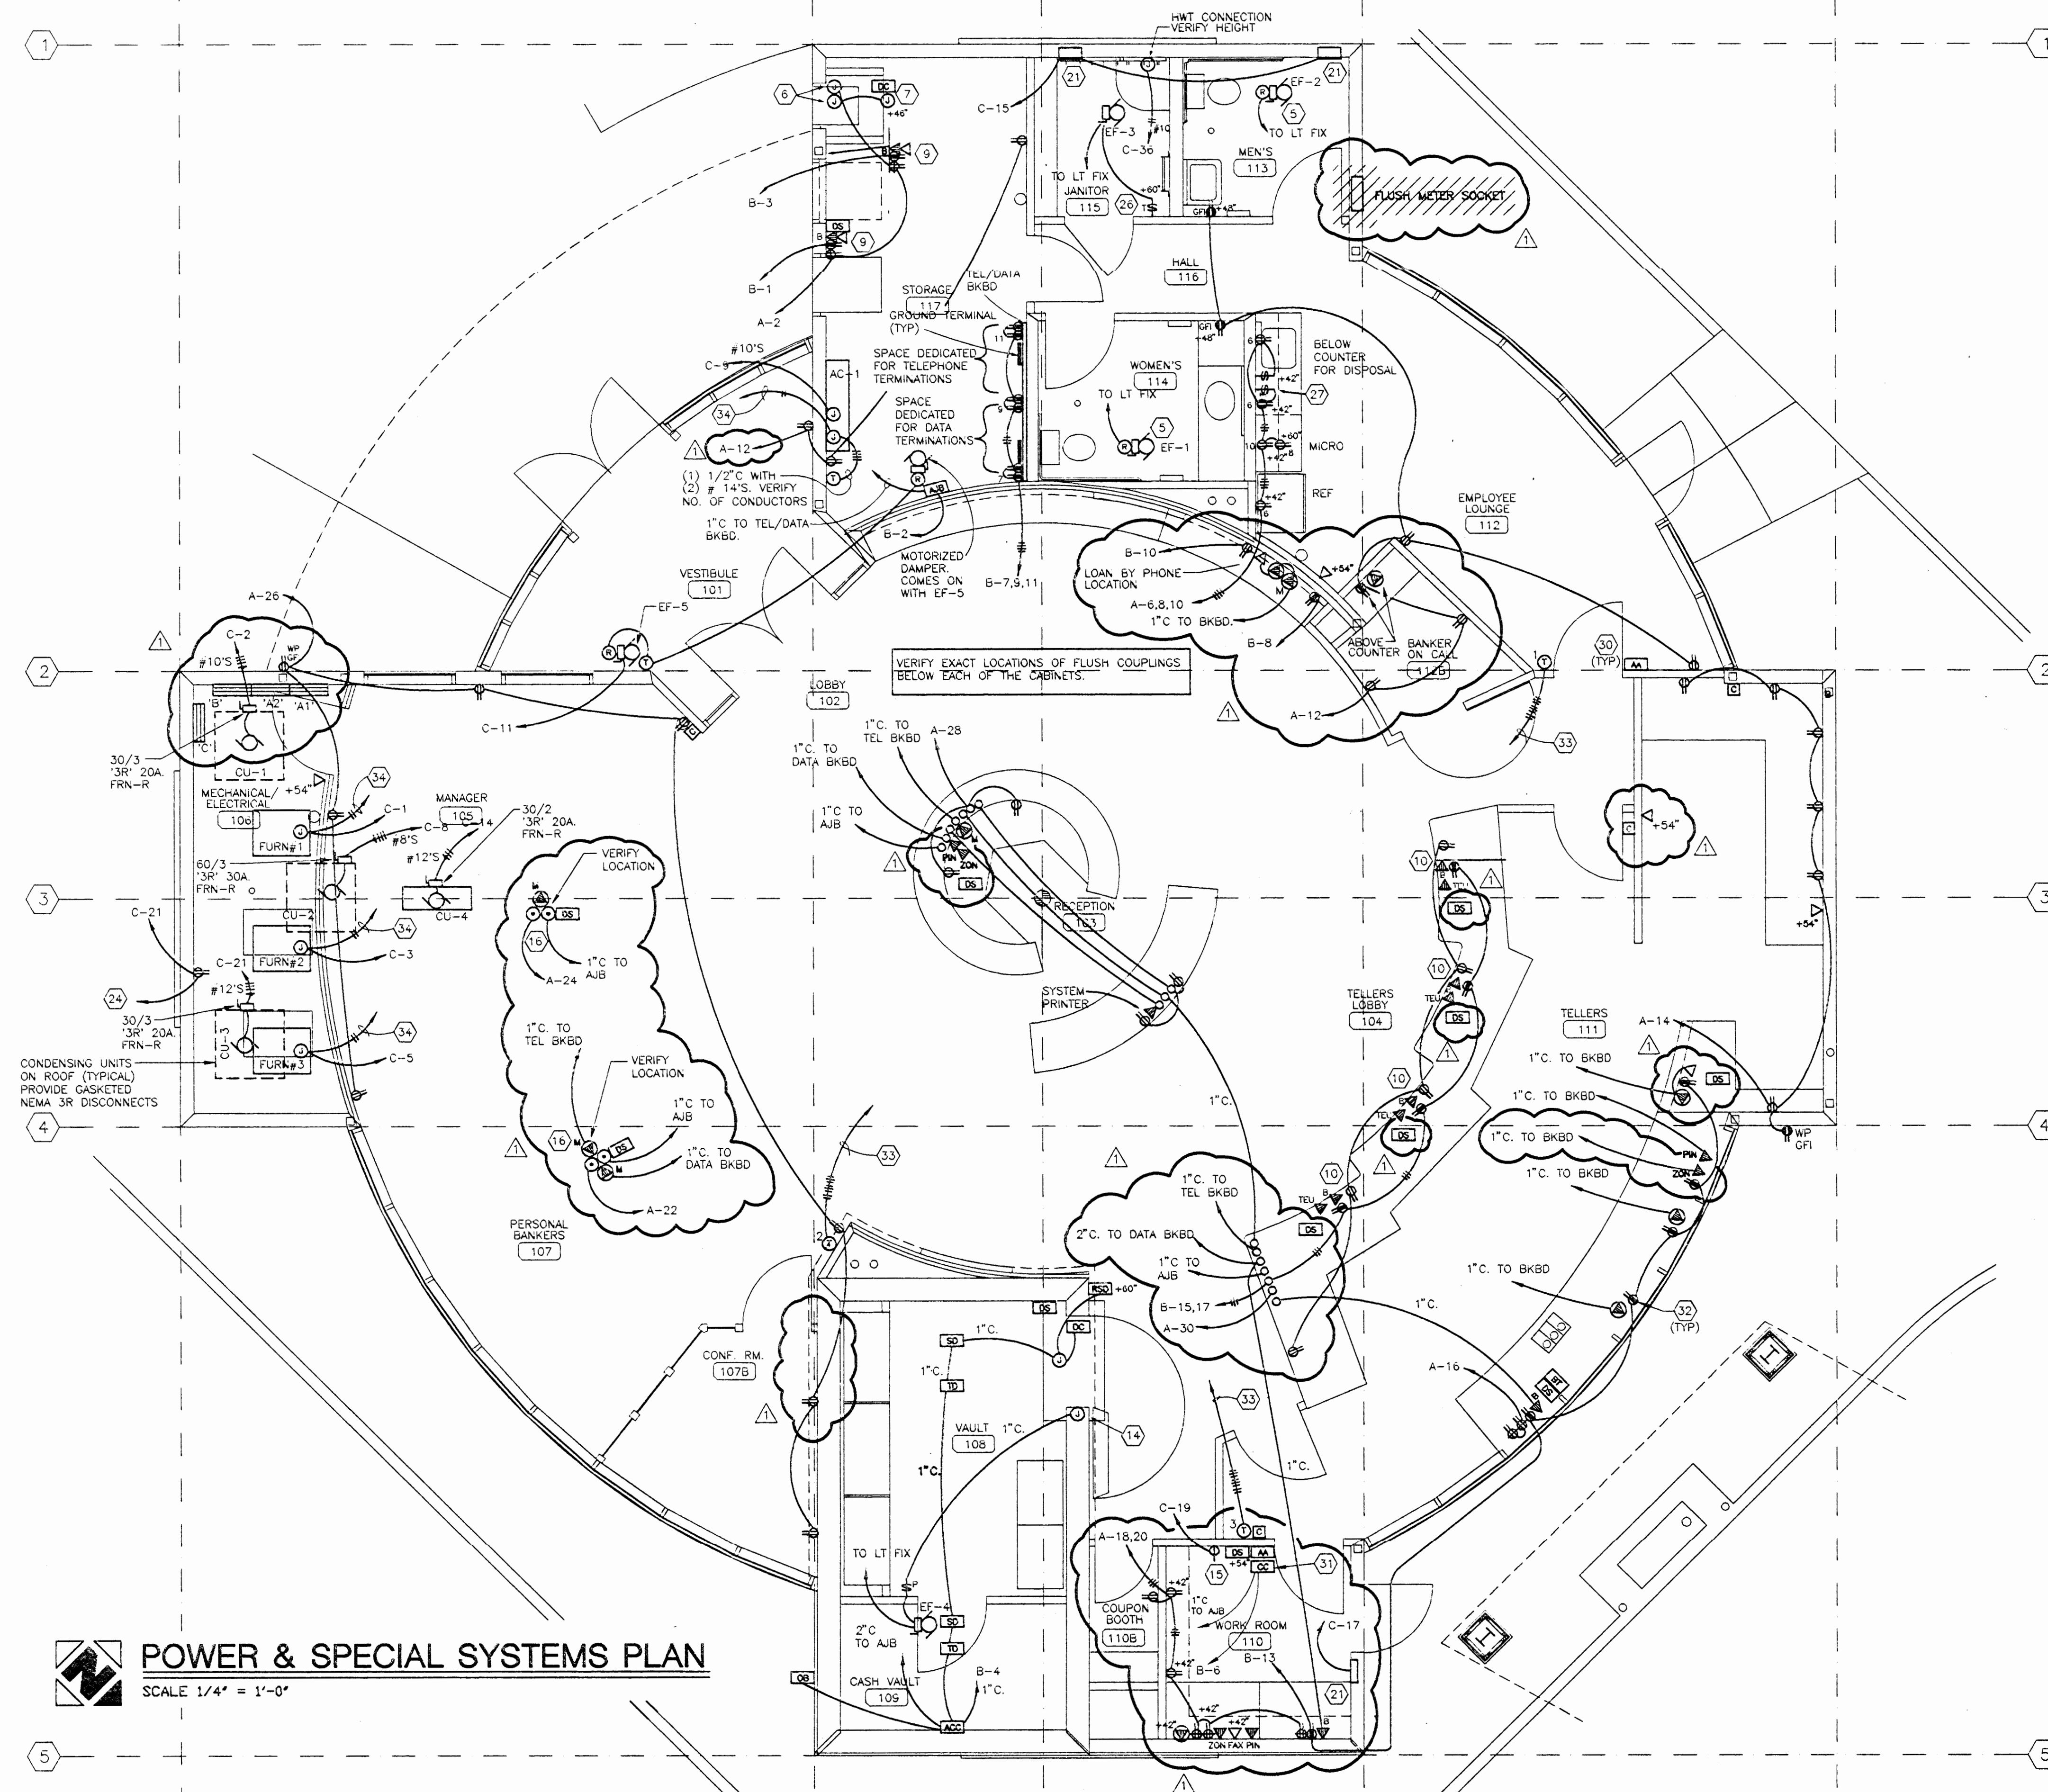

ELECTRICAL NOTES


1. OUTLET BOX & WP SWITCH FOR OWNER PROVIDED DRIVE-UP LANE SIGNS.
2. STUB CONDUITS UP 3" THROUGH BUCK PLAT OPENINGS. (TYPICAL)
3. (4) MAINTAINED SPDT - CENTER OFF SWITCHES IN A 4-GANG PLATE. ENGRAVE PLATE ABOVE EACH SWITCH "OPEN" & BELOW EACH SWITCH "CLOSED". ENGRAVE ACROSS THE TOP OF THE PLATE "DRIVE UP SIGNS".
4. CANOPY LIGHT OVER-RIDE SWITCH ENGRAVE PLATE "LIGHTING OVERRIDE".
5. PROVIDE TIME DELAY RELAY FOR EXHAUST FAN TO ALLOW FAN TO RUN 5 MINUTES AFTER LIGHT IS SWITCHED OFF.
6. PROVIDE ALARM & POWER CONNECTIONS TO NIGHT DEPOSIT AS DIRECTED BY SUPPLIER.
7. MOUNT 4" SQUARE J-BOX FLUSH WITH CONCRETE ENCLOSURE AS DIRECTED AT NIGHT DEPOSIT SUPPLIER.
8. JUNCTION BOX IN ACCESSIBLE CEILING TO SERVE ILLUMINATED MARKETING DISPLAYS. PROVIDE FLEX CONNECTION APPROXIMATELY 72" ABOVE FLOOR. VERIFY ALL REQUIREMENTS WITH DISPLAY SUPPLIER.
9. SEE ELEVATION AT ATM FOR ARRANGEMENT OF OUTLETS SERVING THE ATM'S.
10. SEE ELEVATION AT TELLER STATION FOR ARRANGEMENT OF OUTLETS SERVING THE TELLER LINE.
11. PROVIDE PLASTIC SHATTER-SHIELD SLEEVES FOR LAMPS BELOW COUNTER VALENCE.
12. CONNECTION TO ILLUMINATED SIGN VERIFY ROUGH-IN & CONNECTION REQUIREMENTS WITH SIGN SUPPLIER.
13. ALL RACEWAYS PASSING THRU THE CEILING OR WALLS OF THE VAULT SHALL BE OFFSET WITHIN THE CEILING OR WALL BY 2" MINIMUM.
14. CONNECTIONS TO VAULT VENTILATOR VERIFY ROUGH-IN & CONNECTION REQUIREMENTS WITH VENTILATOR SUPPLIER.
15. SINGLE NEMA 5-20R RECEPTACLE FOR COPIER.
16. OUTLETS FOR CONNECTION OF POWER, TELEPHONE/DATA & ALARM TO THE FURNITURE PARTITION. MAKE EACH CONDUIT CONNECTION AND THE POWER CONNECTION.
17. PROVIDE WIRE GUARDS & MOUNT ON WALL AT 8'-0".
18. PROVIDE WIRE GUARD & COLD WEATHER BALLAST. MOUNT UP 8'-0".
19. (2) 4-GANG SWITCH PLATES, STACKED.

20. PROVIDE WIRE GUARD, MOUNT ON CONTINUOUS UNI-STRUT SUSPENDED FROM ROOF STRUCTURE WITH CHAIN AT 8'-6" AFF.
21. 750W, 120V FAN FORCED WALL HEATER. VERTICALLY MOUNTED UP 12" AFF. ELECTROMODE #EPWHS1T.
22. 2-HOUR SPRING WOUND OVER RIDE SWITCH FOR INTERIOR LIGHTING. SEE LIGHTING CONTROL DIAGRAM.
23. NOT USED.
24. PROVIDE WEATHERPROOF, GFI RECEPTACLE ON THE ROOF NEAR THE MECHANICAL EQUIPMENT.
25. TIMER SWITCH, 2 HOUR WITH NO HOLD. MARK TIME #93 SERIES.
26. TIMER SWITCH, 24 HR INTERMATIC #1010.
27. THRU CONTACTOR. SEE LIGHTING CONTROL DIAGRAM.
28. MILLWORK COVE LIGHTING. SEE ARCHITECTURAL DETAILS.
29. COORDINATE ALL ALARM OUTLET LOCATIONS WITH SECURITY SYSTEM VENDOR PRIOR TO ROUGH-IN.
30. LOCATE CAMERA CONTROL ABOVE ALARM ANNUNCIATOR.
31. ALL DEVICES ALONG THIS COUNTER SHALL BE INSTALLED FACE UP IN TROUGH IMMEDIATELY BELOW WINDOW FRAME. SEE ARCHITECTURAL DETAILS.
32. (1) 1/2" C WITH 2#14'S TO RESPECTIVE FURNACE. COORDINATE WITH MECHANICAL FOR FINAL TERMINATIONS.
33. (1) 1/2" C WITH 2#14'S TO RESPECTIVE CONDENSING UNIT. COORDINATE WITH MECHANICAL FOR FINAL TERMINATIONS.

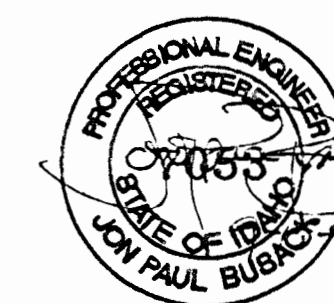

EJ EIDAM AND ASSOCIATES
CONSULTING ENGINEERS
815 PARK BOULEVARD SUITE 230
BOISE, IDAHO 83712 (208)345-7127

BANK OF AMERICA
FAIRVIEW AND MITCHELL
BOISE IDAHO

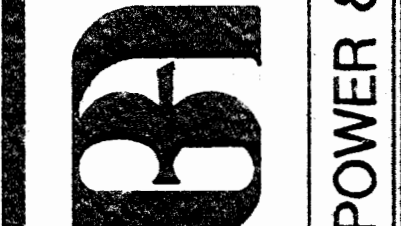


JOB NO. 93031.01
DATE 9-15-93
DRAWN BY JME
CHECKED BY PB/GE
REVISIONS
DATE 3/21/94
FLOOR PLAN

SHEET NO. **E2.2**
OF SHEETS


Lombard-Conrad
ARCHITECTS
1221 SHORELINE LANE BOISE, IDAHO TEL (208)345-6677

POWER & SPECIAL SYSTEMS PLAN

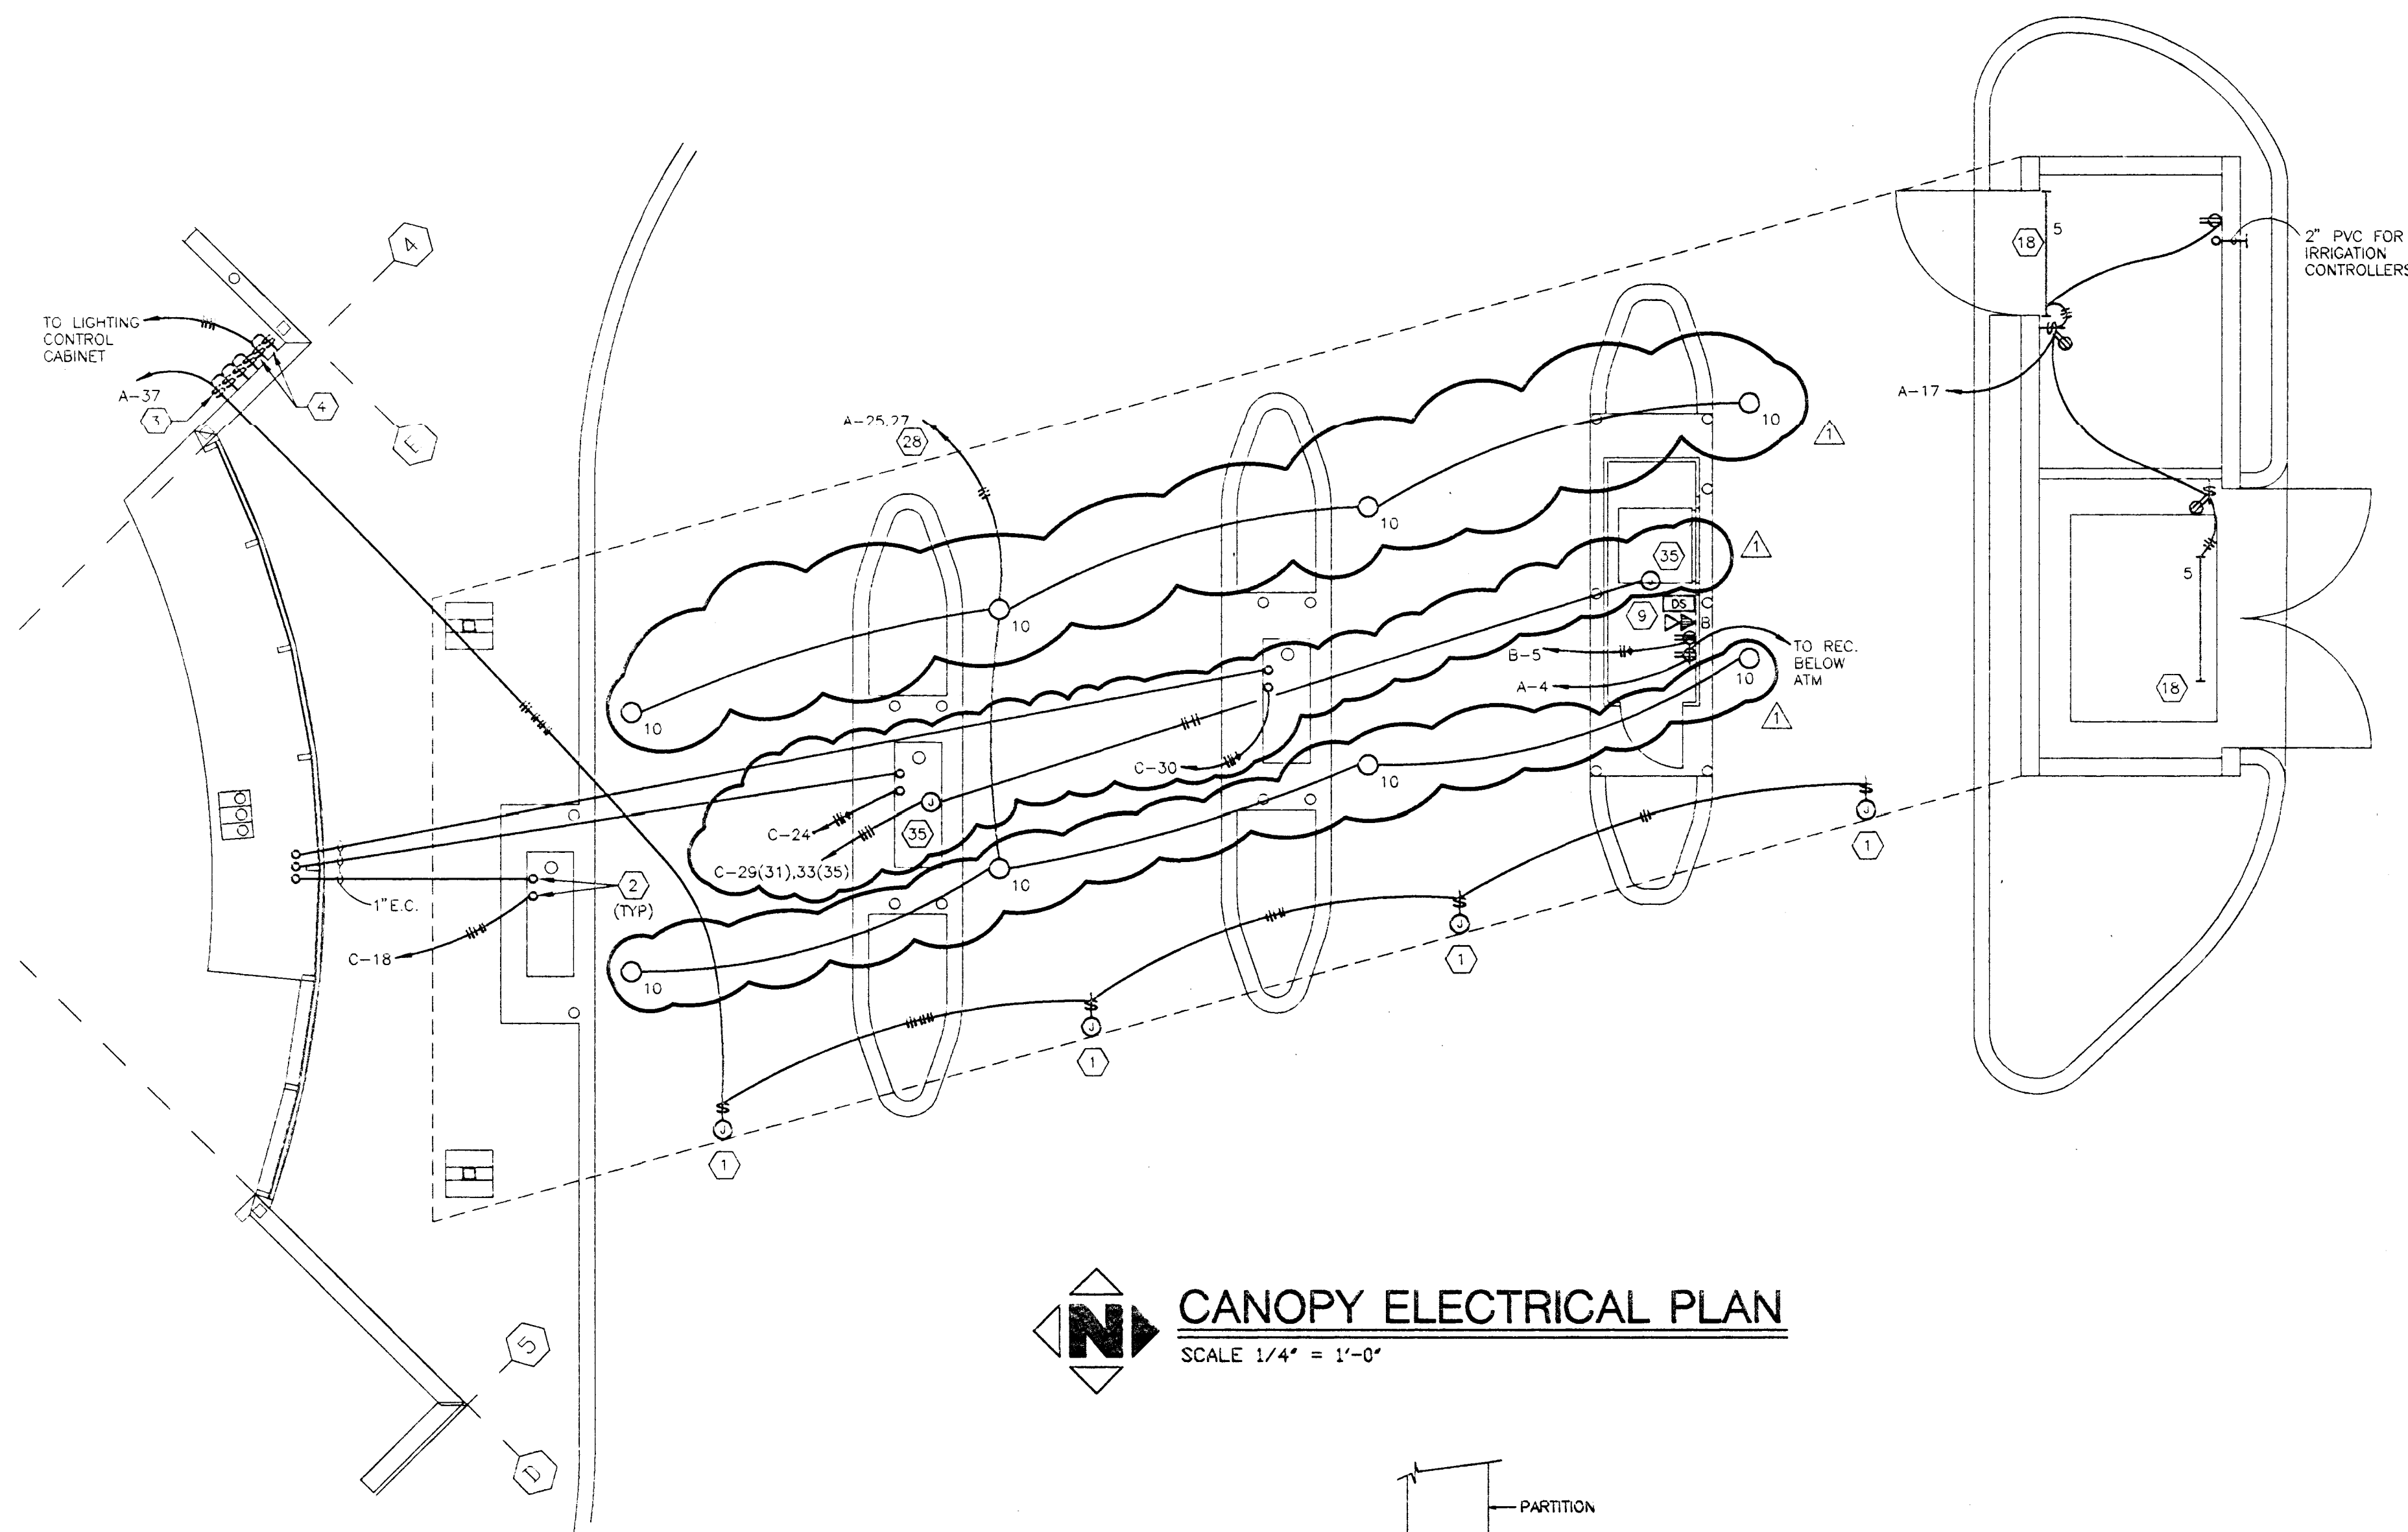


CANOPY ELECTRICAL PLAN

SCALE 1/4" = 1'-0"

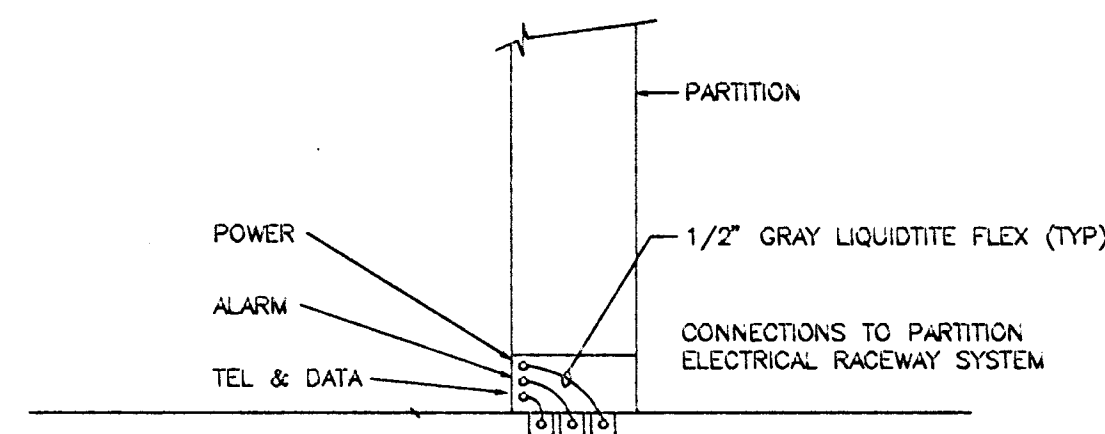


2 POWERED PARTITION CONNECTION

E3.1 NTS

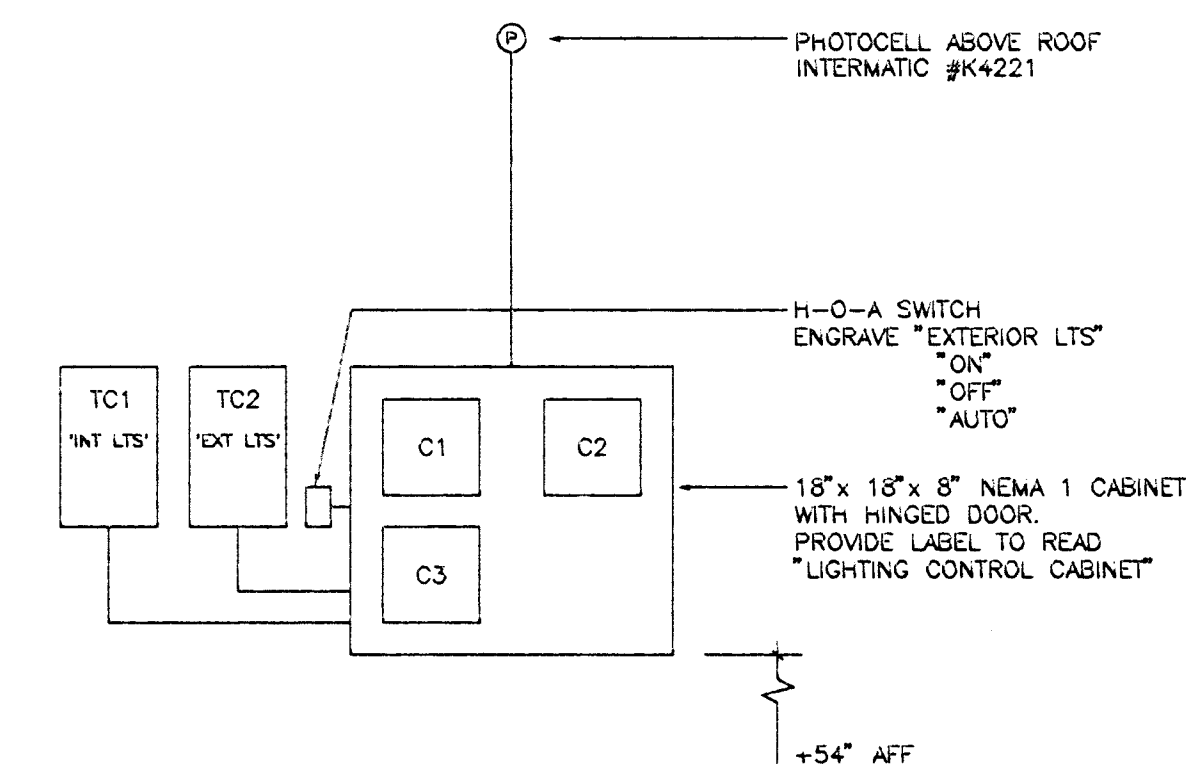


1 LIGHTING CABINET ELEVATION

E3.1 NTS

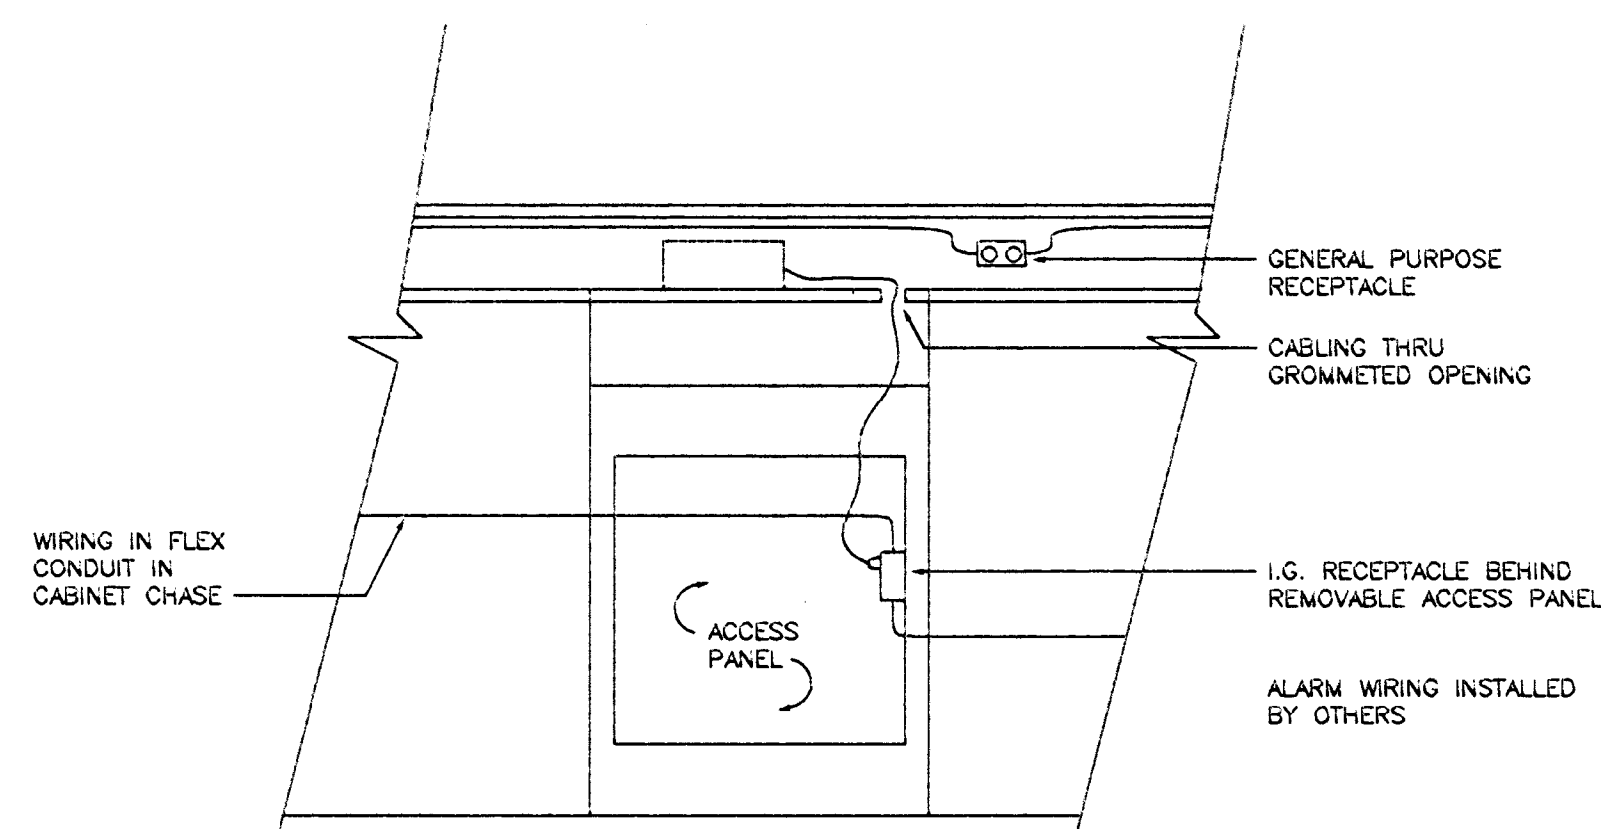

3 TELLER STATION ELEVATION

E3.1 NTS

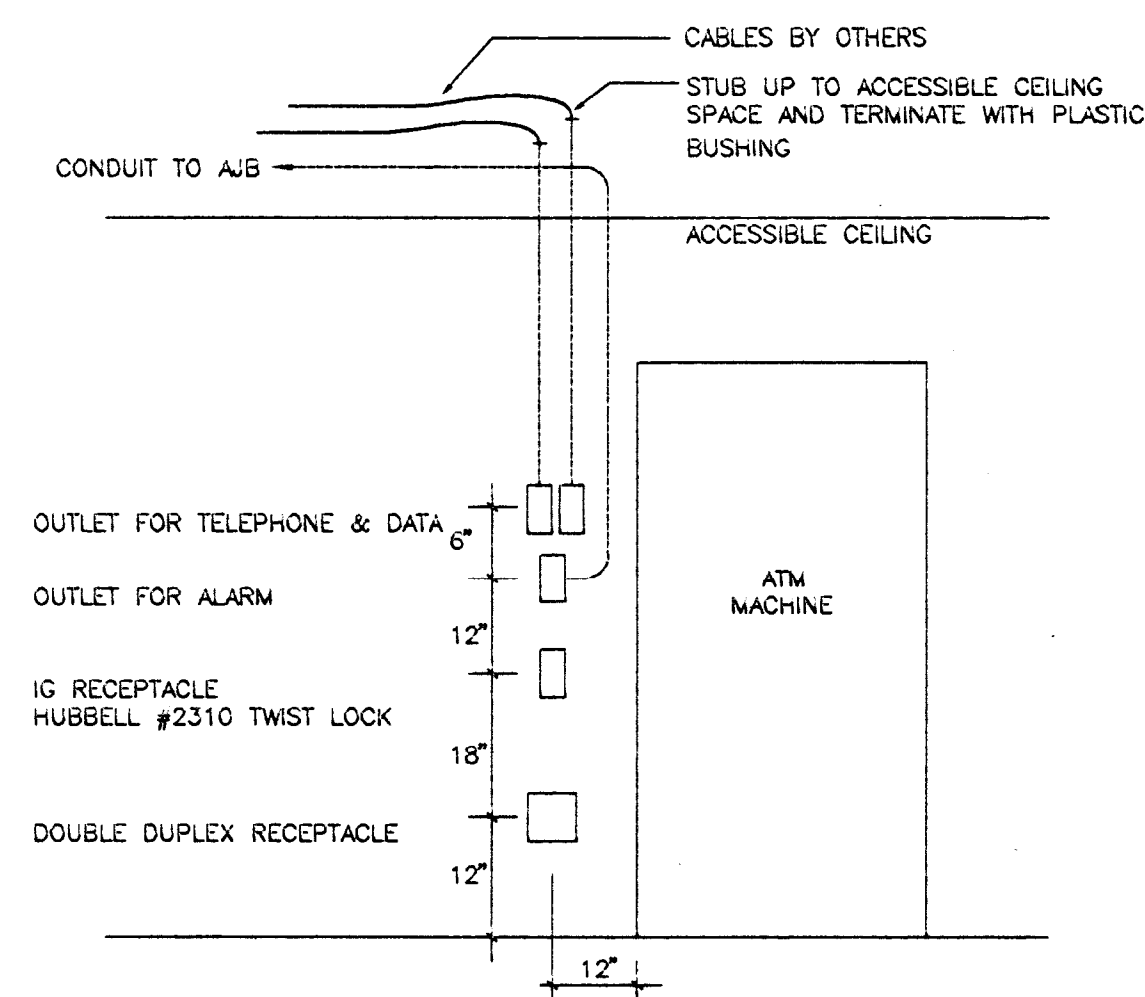

4 ELEVATION AT ATM


E3.1 NTS

ELECTRICAL NOTES

- 1 OUTLET BOX & WP SWITCH FOR OWNER PROVIDED DRIVE-UP LANE SIGNS.
- 2 STUB CONDUITS UP 3" THROUGH BUCK PLAT OPENINGS. (TYPICAL)
- 3 (4) MAINTAINED SPDT - CENTER OFF SWITCHES IN A 4-GANG PLATE. ENGRAVE PLATE ABOVE EACH SWITCH "OPEN" & BELOW EACH SWITCH "CLOSED". ENGRAVE ACROSS THE TOP OF THE PLATE "DRIVE UP SIGNS".
- 4 CANOPY LIGHT OVER-RIDE SWITCH ENGRAVE PLATE "LIGHTING OVERRIDE".
- 5 PROVIDE TIME DELAY RELAY FOR EXHAUST FAN TO ALLOW FAN TO RUN 5 MINUTES AFTER LIGHT IS SWITCHED OFF.
- 6 PROVIDE ALARM & POWER CONNECTIONS TO NIGHT DEPOSIT AS DIRECTED BY SUPPLIER.
- 7 MOUNT 4" SQUARE J-BOX FLUSH WITH CONCRETE ENCLOSURE AS DIRECTED AT NIGHT DEPOSIT SUPPLIER.
- 8 JUNCTION BOX IN ACCESSIBLE CEILING TO SERVE ILLUMINATED MARKETING DISPLAYS. PROVIDE FLEX CONNECTION APPROXIMATELY 72" ABOVE FLOOR. VERIFY ALL REQUIREMENTS WITH DISPLAY SUPPLIER.
- 9 SEE ELEVATION AT ATM FOR ARRANGEMENT OF OUTLETS SERVING THE ATM'S.
- 10 SEE ELEVATION AT TELLER STATION FOR ARRANGEMENT OF OUTLETS SERVING THE TELLER LINE.
- 11 PROVIDE PLASTIC SHATTER-SHIELD SLEEVES FOR LAMPS BELOW COUNTER VALENCE.
- 12 CONNECTION TO ILLUMINATED SIGN VERIFY ROUGH-IN & CONNECTION REQUIREMENTS WITH SIGN SUPPLIER.
- 13 ALL RACEWAYS PASSING THRU THE CEILING OR WALLS OF THE VAULT SHALL BE OFFSET WITHIN THE CEILING OR WALL BY 2" MINIMUM.
- 14 CONNECTIONS TO VAULT VENTILATOR VERIFY ROUGH-IN & CONNECTION REQUIREMENTS WITH VENTILATOR SUPPLIER.
- 15 SINGLE NEMA 5-20R RECEPTACLE FOR COPIER.
- 16 OUTLETS FOR CONNECTION OF POWER, TELEPHONE/DATA & ALARM TO THE FURNITURE PARTITION. MAKE EACH CONDUIT CONNECTION AND THE POWER CONNECTION.
- 17 PROVIDE WIRE GUARDS & MOUNT ON WALL AT 8'-0".
- 18 PROVIDE WIRE GUARD & COLD WEATHER BALLAST. MOUNT UP 8'-0".
- 19 (2) 4-GANG SWITCH PLATES, STACKED.


SWITCH	CIRCUIT	ENGRAVING
A	A-1	LOUNGE
B	A-3	TELLERS
C	A-5	OFFICES
D	A-7	RECEPTION
E	A-9	LOBBY
F	A-11	LOBBY
G	A-13	MERCHANDISING
H	A-15	MERCHANDISING

- 20 PROVIDE WIRE GUARD, MOUNT ON CONTINUOUS UNI-STRUT SUSPENDED FROM ROOF STRUCTURE WITH CHAIN AT 8'-6" AFF.
- 21 750W, 120V FAN FORCED WALL HEATER. VERTICALLY MOUNTED UP 12" AFF. ELECTROMODE #EPWH08LT.
- 22 2-HOUR SPRING WOUND OVER RIDE SWITCH FOR INTERIOR LIGHTING. SEE LIGHTING CONTROL DIAGRAM.
- 23 NOT USED.
- 24 PROVIDE WEATHERPROOF, GFI RECEPTACLE ON THE ROOF NEAR THE MECHANICAL EQUIPMENT.
- 26 TIMER SWITCH, 2 HOUR WITH NO HOLD. MARK TIME #93 SERIES.
- 27 TIMER SWITCH, 24 HR INTERMATIC #1010.
- 28 THRU CONTACTOR. SEE LIGHTING CONTROL DIAGRAM.
- 29 MILLWORK COVE LIGHTING. SEE ARCHITECTURAL DETAILS.
- 30 COORDINATE ALL ALARM OUTLET LOCATIONS WITH SECURITY SYSTEM VENDOR PRIOR TO ROUGH-IN.
- 31 LOCATE CAMERA CONTROL ABOVE ALARM ANNUNCIATOR.
- 32 ALL DEVICES ALONG THIS COUNTER SHALL BE INSTALLED FACE UP IN TROUGH IMMEDIATELY BELOW WINDOW FRAME. SEE ARCHITECTURAL DETAILS.
- 33 (1) 1/2"C WITH 8#14'S TO RESPECTIVE FURNACE. COORDINATE WITH MECHANICAL FOR FINAL TERMINATIONS.
- 34 (1) 1/2"C WITH 2#14'S TO RESPECTIVE CONDENSING UNIT. COORDINATE WITH MECHANICAL FOR FINAL TERMINATIONS.
- 35 WEATHERPROOF HEAT TAPE CONNECTIONS ON ROOF AT MAIN AND OVERFLOW DRAINS. RUN HEAT TAPE TO DAYLIGHT ENDS OF DRAINS. VERIFY LENGTHS AND LOCATIONS WITH MECHANICAL.

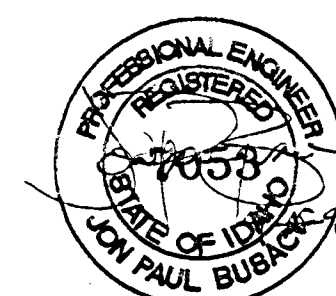

ETDAM AND ASSOCIATES
CONSULTING ENGINEERS
815 PARK BOULEVARD SUITE 230
BOISE, IDAHO 83712 (208)345-7127

BANK OF AMERICA
FAIRVIEW AND MITCHELL
BOISE IDAHO
CANOPY ELECTRICAL PLAN

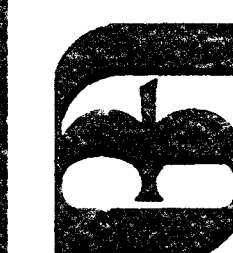

JOB NO. 93031.01
DATE 9-15-93
DRAWN BY DME
CHECKED BY PB/GE
REVISIONS
FLOOR PLAN DATE 9/21/94

SHEET NO.

E3.1

OF SHEETS

① PROVIDE BREAKER LOCK

1



E4.1 NTS

4



E4.1 NT

EXIT LITHONIA "SIGNATURE" SERIES
(2) 5W OR 7W COMPACT FLUORESCENT LAMPS
BACK MOUNTED UP 116" OR AS NOTED
"C" DENOTES CEILING MOUNTED, "B" DENOTES BACK MOUNTED
ALL WHITE FINISH
GREEN STENCIL FACE
SELF-CONTAINED BATTERY

1. LITHONIA #2P4C-2031-9-LS-120-ES
(2)FB31-T8 LAMPS
RECESS MOUNTED (T-BAR)
ACCEPTABLE MANUFACTURERS: COLUMBIA, METALUX, DAY-BRIGHT
2. LITHONIA #2SPGA-232-RW-K12-120-ES
(2)F32T8 LAMPS
RECESS MOUNTED (T-BAR)
ACCEPTABLE MANUFACTURERS: COLUMBIA, METALUX, DAY-BRIGHT
3. LITHONIA #AW-232-120-ES
(2) F32T8 LAMPS
SURFACE MOUNTED
ACCEPTABLE MANUFACTURERS: COLUMBIA, METALUX, DAY-BRIGHT
4. LITHONIA #SPFA-232-RW-K12-120-ES
(2) F32T8 LAMPS
RECESS MOUNTED (GY-PBD)
ACCEPTABLE MANUFACTURERS: COLUMBIA, METALUX, DAY-BRIGHT
5. LITHONIA #S-132-HRS-120-ES
(1) F32T8 LAMP
MOUNTED IN CEILING COVE OR BELOW COUNTERTOP. SEE ARCHITECTURAL DETAILS
PROVIDE WIRE GUARDS & COLD WEATHER BALLASTS WHERE NOTED
ACCEPTABLE MANUFACTURERS: COLUMBIA, METALUX, DAY-BRIGHT, BENJAMIN
6. SAME AS TYPE 5 EXCEPT 2' LONG AND
(1) 24" F17T8 LAMP
7. SAME AS TYPE 5 EXCEPT 3' LONG AND
(1) 36" F25T8 LAMP
8. LITHONIA #AF-2/26-DTT-SAR-120-ES
(2) 28W DTT 30K LAMPS
RECESS MOUNTED
8" DIAMETER SPECULAR CLEAR ALZAK REFLECTOR
ACCEPTABLE MANUFACTURERS: HALO,PRESCOLITE
9. LITHONIA #AH-70W-GAR
(1) 70W M.H. LAMP
RECESS MOUNTED
6" DIAMETER SPECULAR CLEAR ALZAK SELF-FLANGE REFLECTOR
ACCEPTABLE MANUFACTURERS: HALO,PRESCOLITE
10. LITHONIA #LGH-100W-9RW-T73
(1) 100W M.H. LAMP
RECESS MOUNTED
5" DIAMETER WHITE SPLAY, FREZNE LENS
ACCEPTABLE MANUFACTURERS: KURT VERSEN, PRESOLITE
11. MOLDCAST #MDL-1-02-16-120V-1FU
(1) 100W M.H. LAMP
RECESS WALL MOUNTED UP 9"-0" TO TOP
ACCEPTABLE MANUFACTURERS: LITHONIA
12. LITHONIA #KAR2-400W-R3-208-RP05-DBL WITH RTA-30-8E-DBL POLE.
(1) 400W M.H. LAMP, ROUND TYPE III SHOEBOX ON 30" ROUND TAPERED
ALUMINUM POLE, BLACK
ACCEPTABLE MANUFACTURERS: SPAULDING

NOTES

1. ALL FIXTURES ARE TYPE #1 UNLESS NOTED OTHERWISE
-  2. PROVIDE FLUORESCENT BATTERY PACK FOR SHADED FIXTURES

Lombard-Conrad

A R C H I T E C T S P. A. A. I. A.
221 SHORELINE LANE BOISE, IDAHO
TEL. (208) 345-6677

BANK OF AMERICA
FAIRVIEW AND MITCHELL
BOISE IDAHO

JOB NO. 93031.01

DATE	9-15-93
------	---------

7-15-75	
DRAWN BY	C

DME
DO NOT WRITE

REVISIONS
1 FLOOR PLAN

1 FLOOR PLAN

100

100

SHEET NO.

E4-


E4.

100

DF

2 NORTH FAIRVIEW AVENUE

2 NORTH MITCHELL STREET

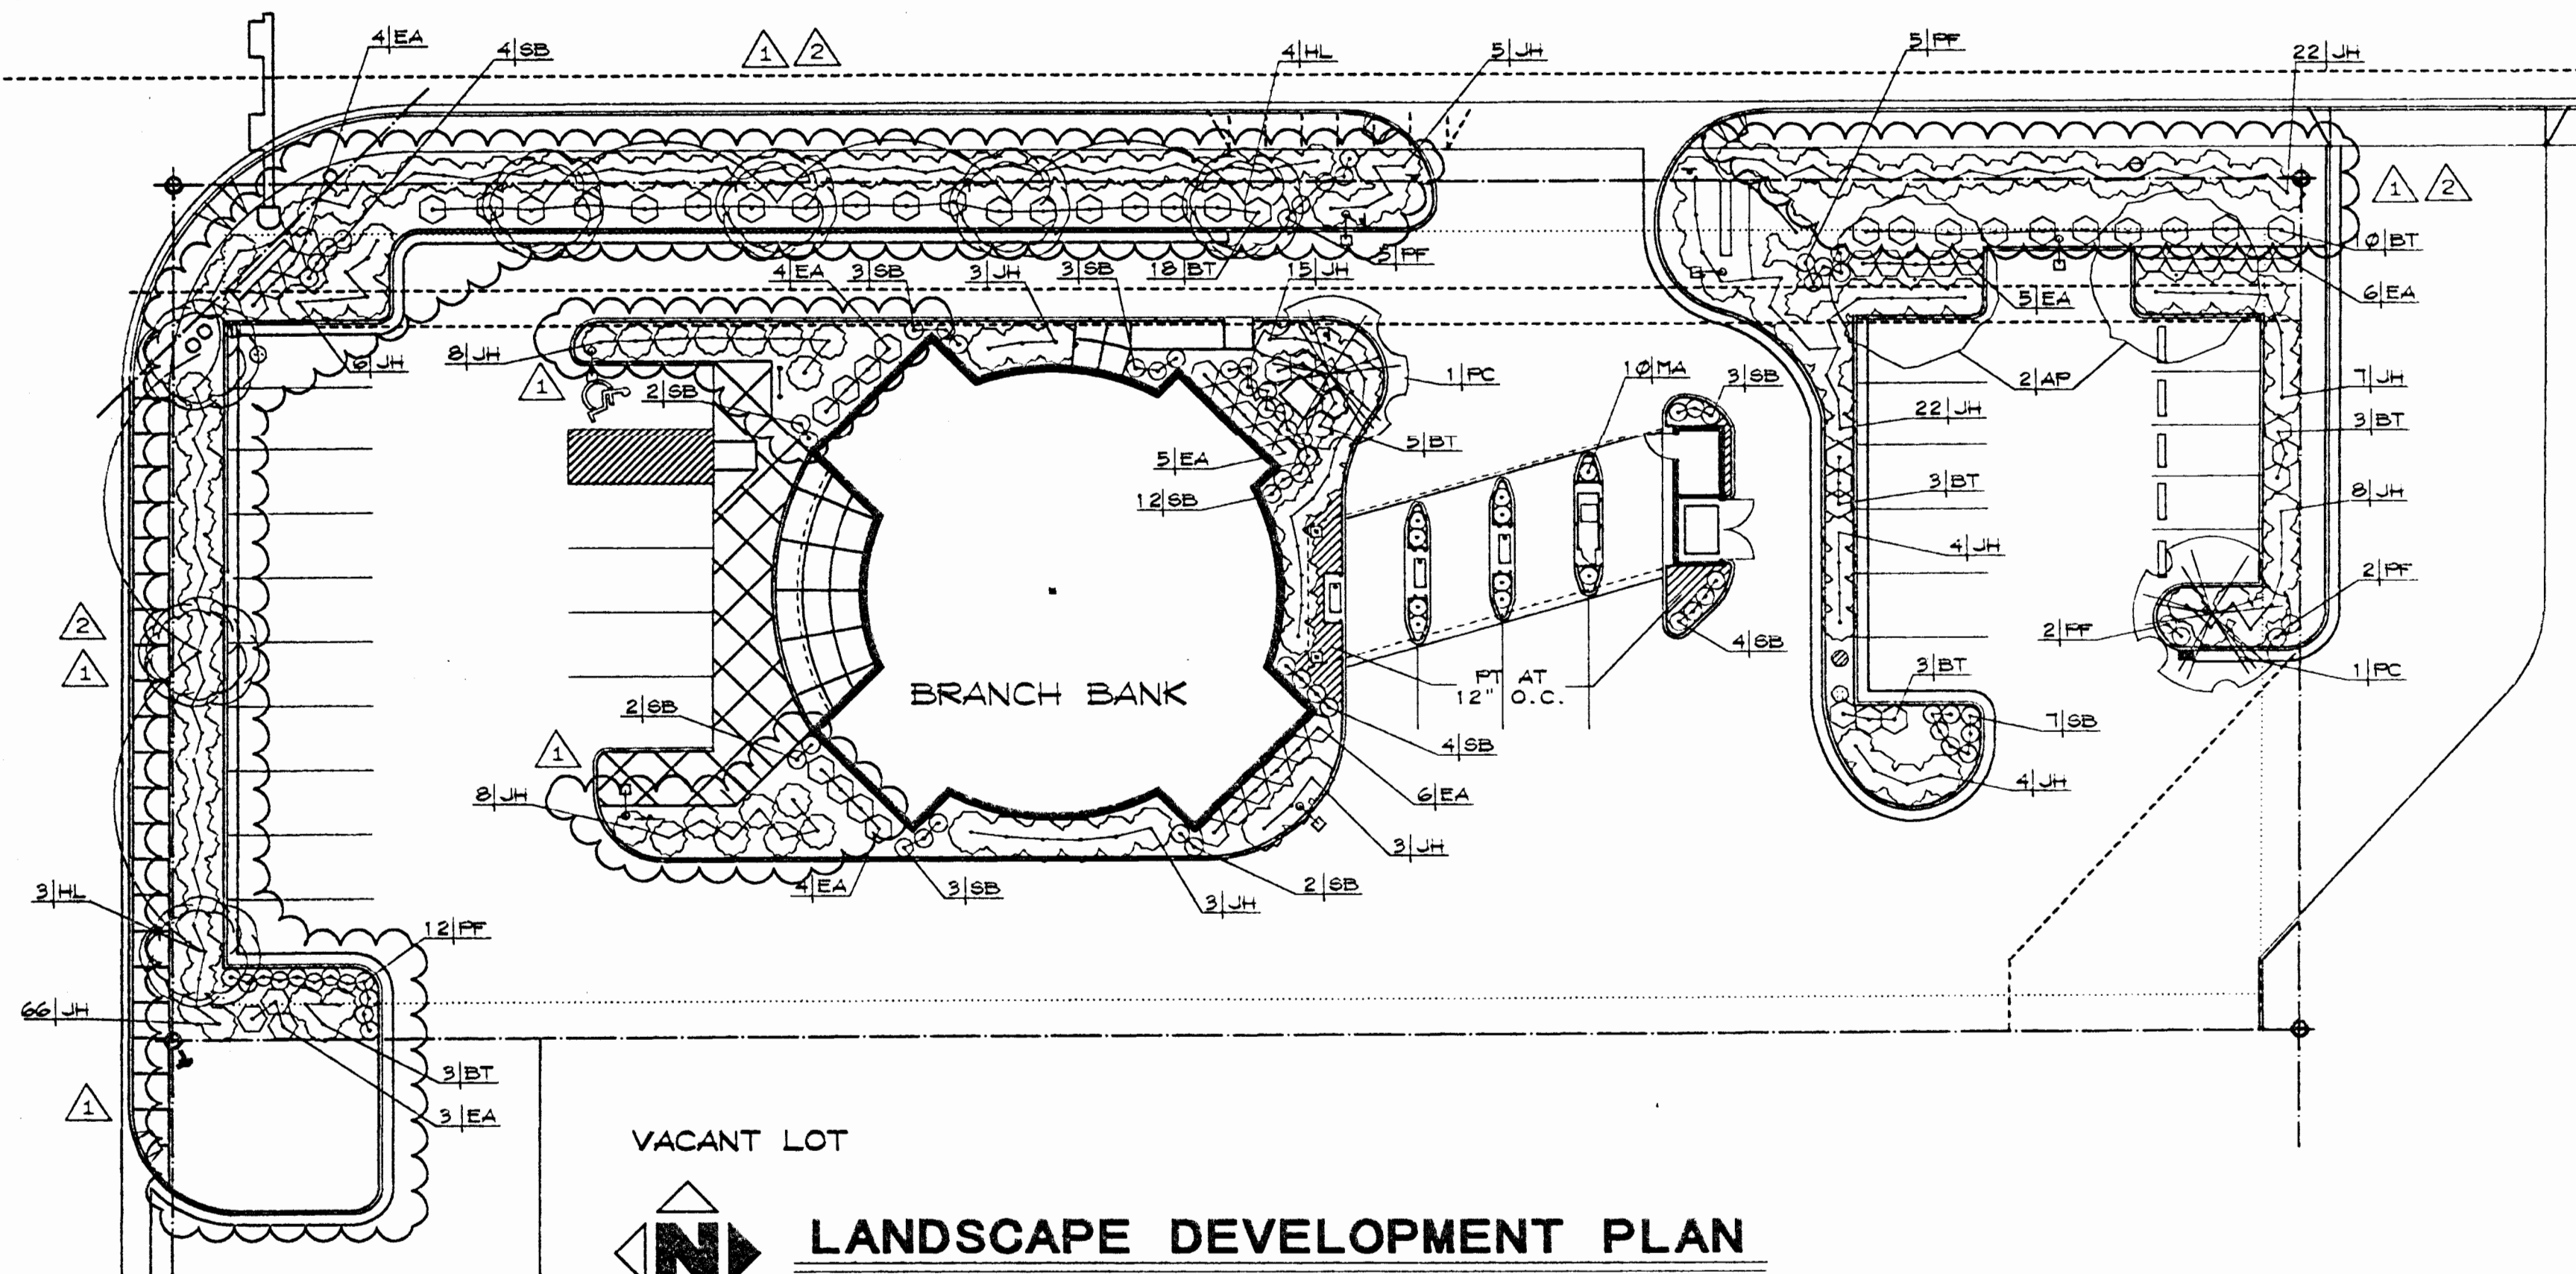

VACANT LOT



LANDSCAPE DEVELOPMENT PLAN


SCALE: 1"=20'-0"

PLANT SCHEDULE


KEY	BOTANICAL NAME (COMMON NAME)	(SOME PLANT TYPE CHANGES PER OWNER DIRECTION.)	PLANTING SIZE
TREES			
AP	ACER PLATANOIDES 'DEBORAH' (DEBORAH MAPLE)		2" B & B
HL	GLEDITSIA TRIACANTHOS INERMIS SHADEMASTER (SHADEMASTER HONEYLOCUST)		2" B & B
MP	MALUS 'PRAIRIFIRE' (PRAIRIFIRE CRAB)		2" B & B
PC	PRUNUS CERASIFERA 'NEUPORT' (NEUPORT PLUM)		2" B & B
SHRUBS			
BT	BERBERIS THUNBERGII 'ATROPURPUREA' (RED-LEAF BARBERRY)		2 GAL.
EA	EUONYMUS ALTA 'COMPACTA' (DWARF BURNING BUSH)		5 GAL.
JH	JUNIPERUS HORIZONTALIS PLUMOSA 'YOUNGSTOWN' (YOUNGSTOWN JUNIPER)		5 GAL.
MA	MAHONIA AQUIFOLIUM 'COMPACTA' (COMPACT OREGON GRAPE)		1 GAL.
FT	PACHYSANDRA TERMINALIS (JAPANESE SPURGE)		2" FOTS (PLANT AT 12" O.C. EA. WAY)
FF	POTENTILLA FRUTICOSA 'GOLD DROP' (GOLD DROP SHRUBBY CINQUEFOIL)		1 GAL.
PL	PRUNUS LAUROCERASUS 'OTTO LUYKEN' (OTTO LUYKENS LAUREL)		5 GAL.
SB	SPIRAEA BUNALDA 'COCCINEA' (DWARF RED SPIREA)		1 GAL.

PLANTING AND IRRIGATION NOTES


- ALL PLANT MATERIAL SHALL CONFORM TO THE AMERICAN NURSERYMAN STANDARDS FOR TYPE AND SIZE SHOWN.
- ALL PLANTING BEDS AND TREE WELLS SHALL BE COVERED WITH A MINIMUM OF 3" OF SMALL (1" MINUS) BARK CHIPS.
- ALL LAWN AREAS SHALL BE SODDED WITH A 100 PERCENT BONSAI PESCUE (PESTUCA ARUNDINACEA 'BONSAI').
- ALL SODDED AREAS SHALL HAVE 6" OF TOPSOIL AND ALL PLANTING BEDS SHALL HAVE 12" OF TOPSOIL.
- ALL MOW STRIPS SHALL BE CONTINUOUS CONCRETE WITH 6" WIDE SURFACE, 6" WIDE BASE, AND 6" DEEP. SEE DETAIL 1/L1.1.
- ALL LANDSCAPED AREAS SHALL HAVE AN AUTOMATIC UNDERGROUND SPRINKLER SYSTEM WHICH INSURES COMPLETE COVERAGE AND PROPERLY ZONED FOR REQUIRED WATER USES.
- TOP SOIL AND GRADING BY GENERAL CONTRACTOR +1/10.
- SPRINKLER SYSTEM WILL BE A BIDDER DESIGNED FULLY AUTOMATIC SYSTEM, INSTALLED ACCORDING TO MANUFACTURER'S SPECIFICATIONS AND SPACING. MATERIALS WILL BE AS FOLLOWS:
 - ANTEIX VALVE BOXES, HEADS TO BE 35 P FOR LAWNS, 36 P FOR SHRUBS (WEATHERMATIC).
 - 14 GAUGE SINGLE STRAND WIRE.
 - 4" CLASS 100 PVC SLEEVING FOR MAINLINE.
 - ALL VALVES 1 1/2" SERIES WEATHERMATIC.
 - CLASS 100 PVC SLEEVING 2 SIZES LARGER THAN LATERALS.
 - IRKITROL AS AUTOMATIC CONTROLLER (OR EQUAL).
 - 2" WATER SERVICE AND METER BY PLUMBING CONTRACTOR.
- LOCATE CONTROL CLOCK IN GENERATOR ROOM.
- PROVIDE COMPLETE AS-BUILT DRAWINGS OF SPRINKLER SYSTEM.
- ALL SPRINKLER SYSTEM LINES UNDER CONCRETE SLABS AND ASPHALT SHALL BE SLEEVED AND GRADED.
- COORDINATE SHRUB HEADS AND PIPING WITH SHRUBS AND TREE LOCATIONS.
- LOCATE CONTROLLER IN STORAGE ROOM IN DRIVE-THRU CANOPY. SLEEVE BY ELECTRICAL CONTRACTOR.

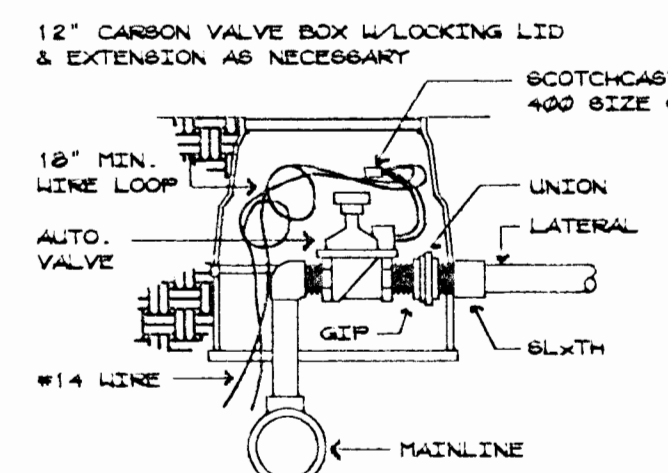


VALVE BOX

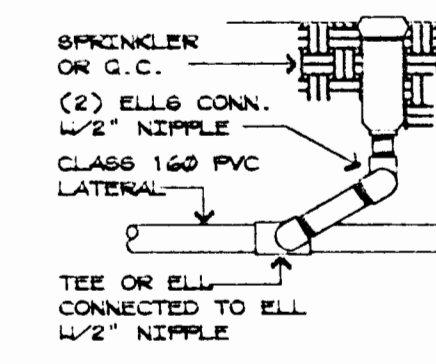

RISER DETAIL

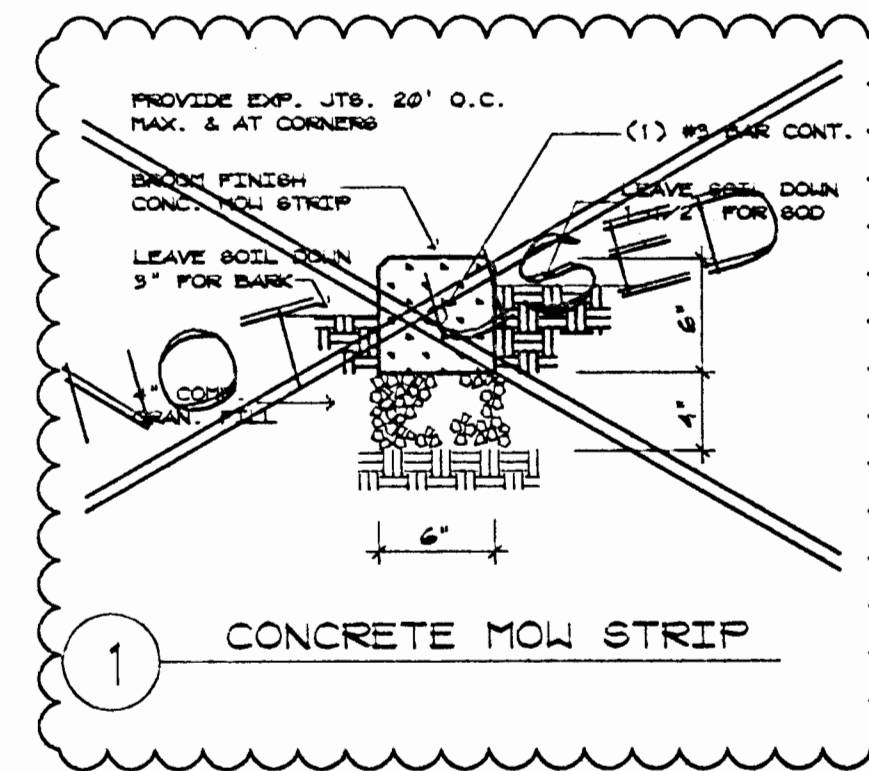

CONCRETE MOW STRIP

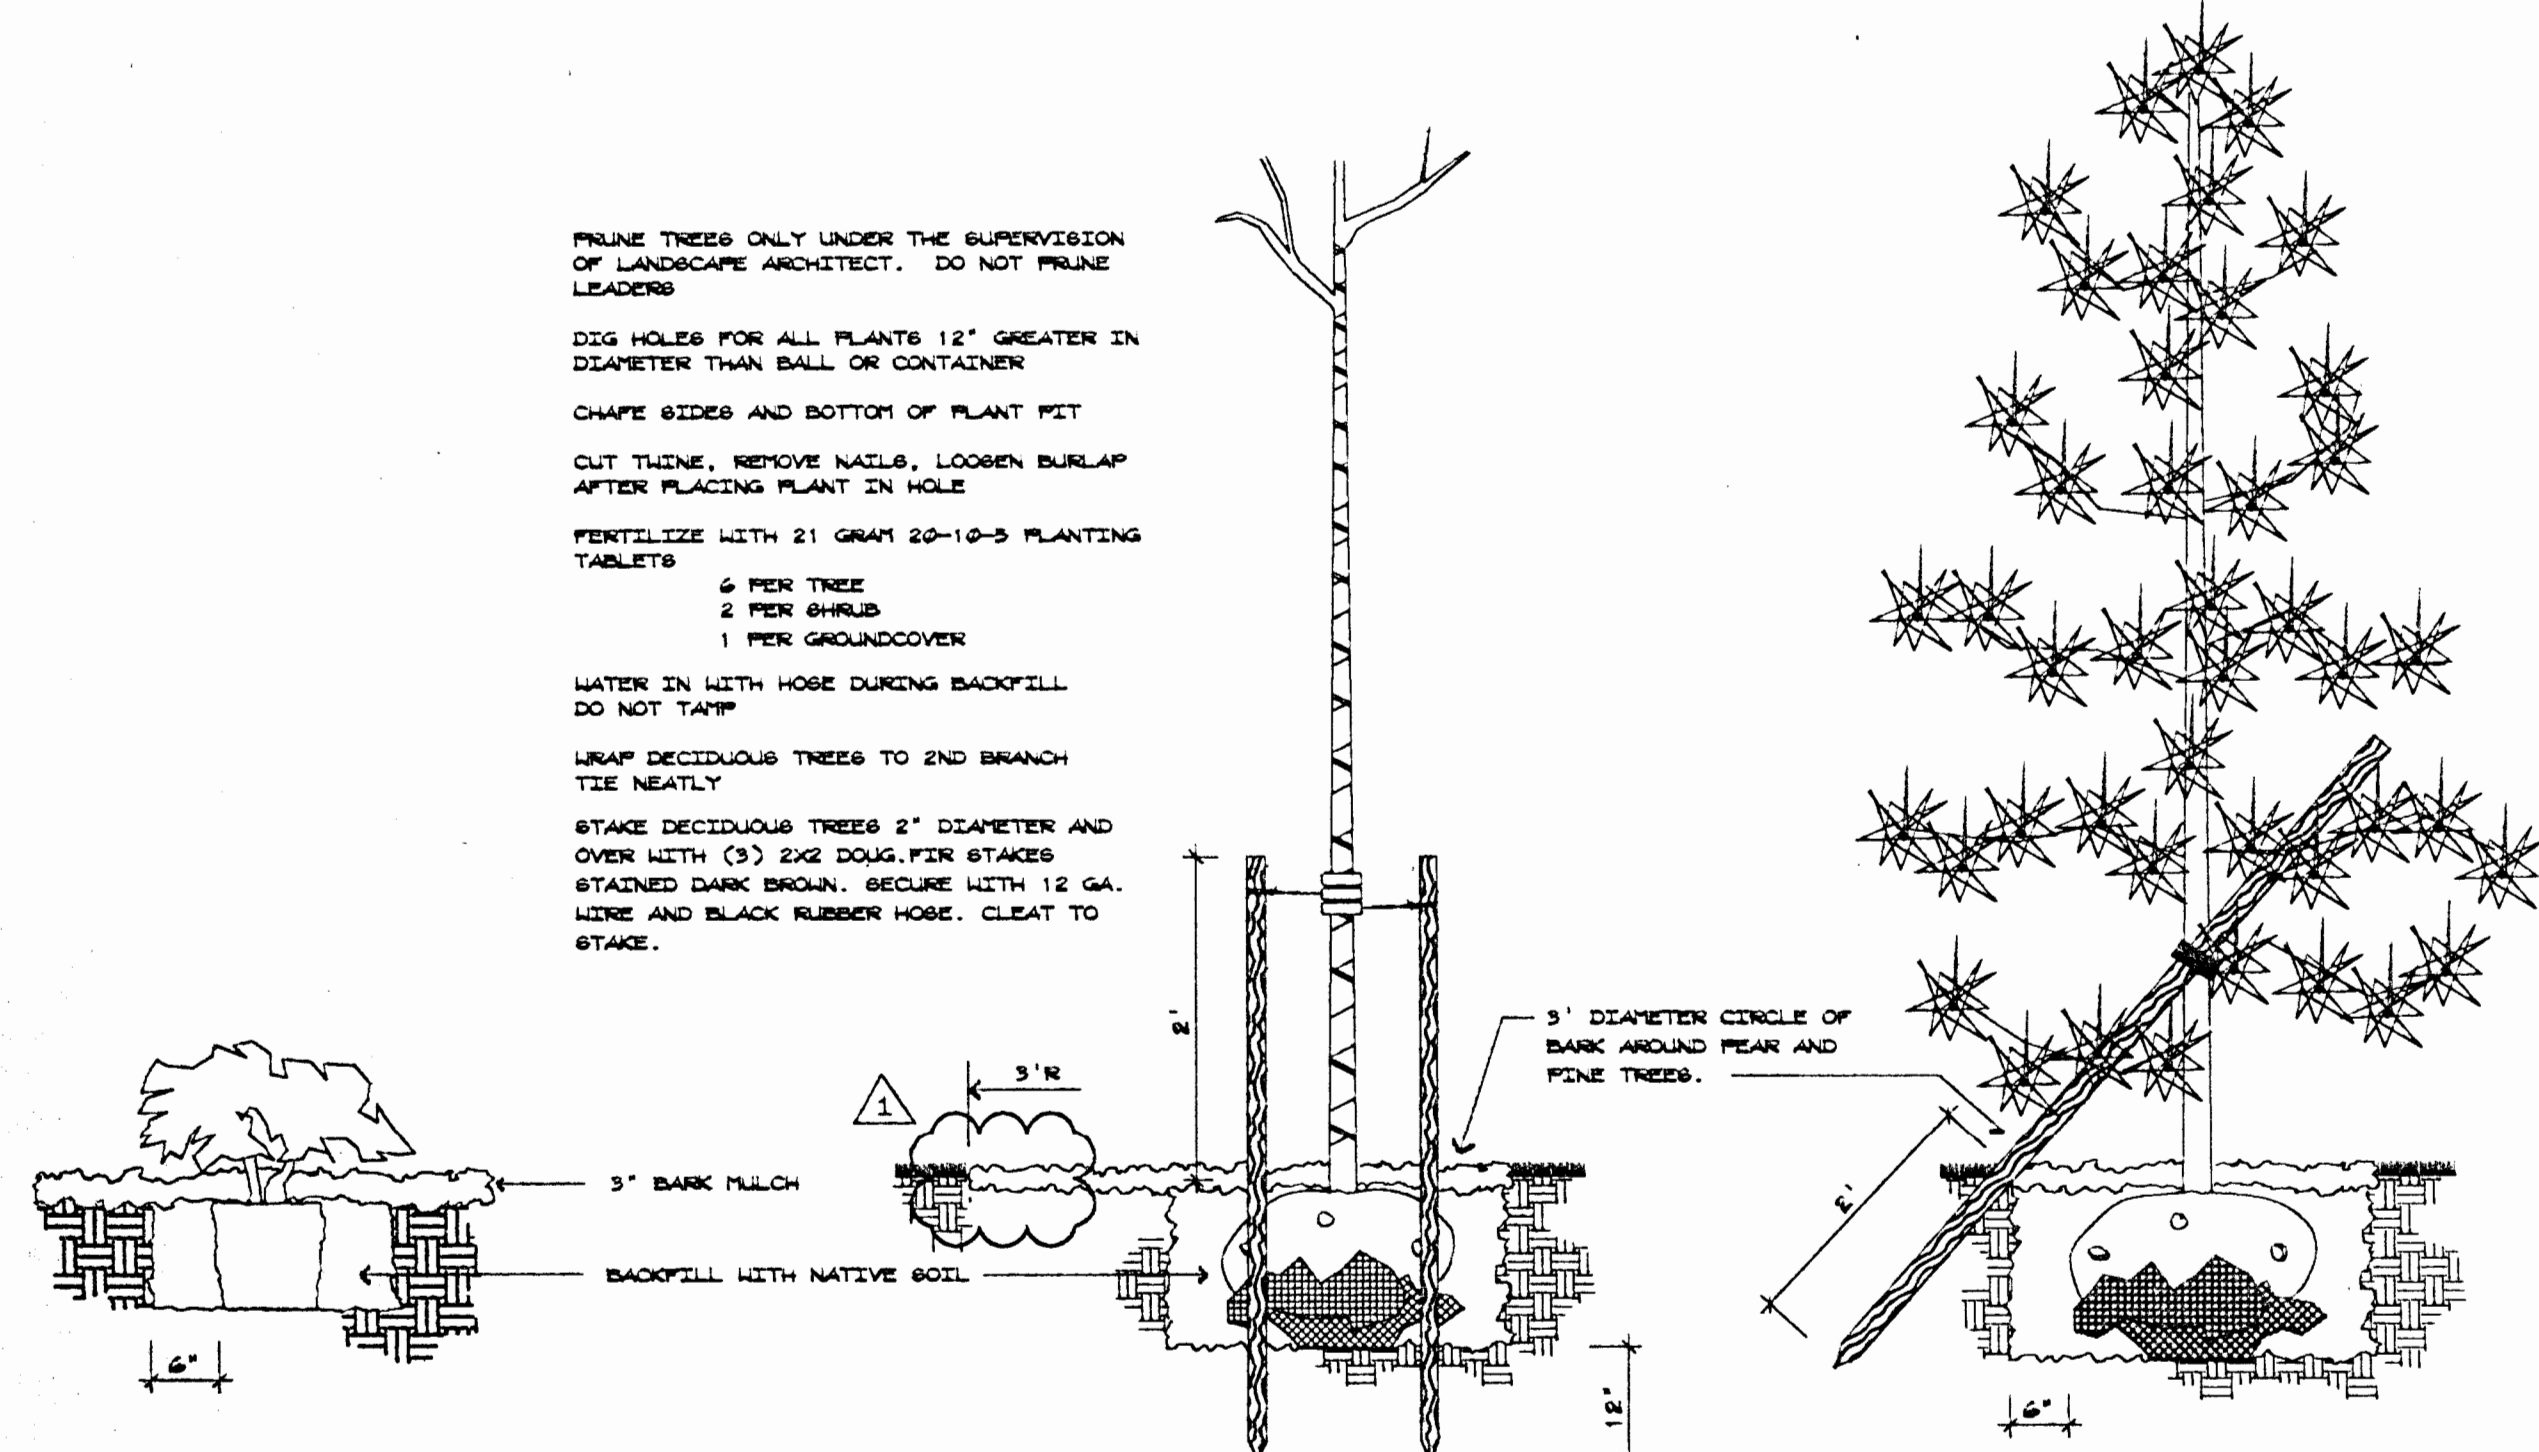


SHRUB

TREE

CONIFER TREE

PLANTING DETAILS

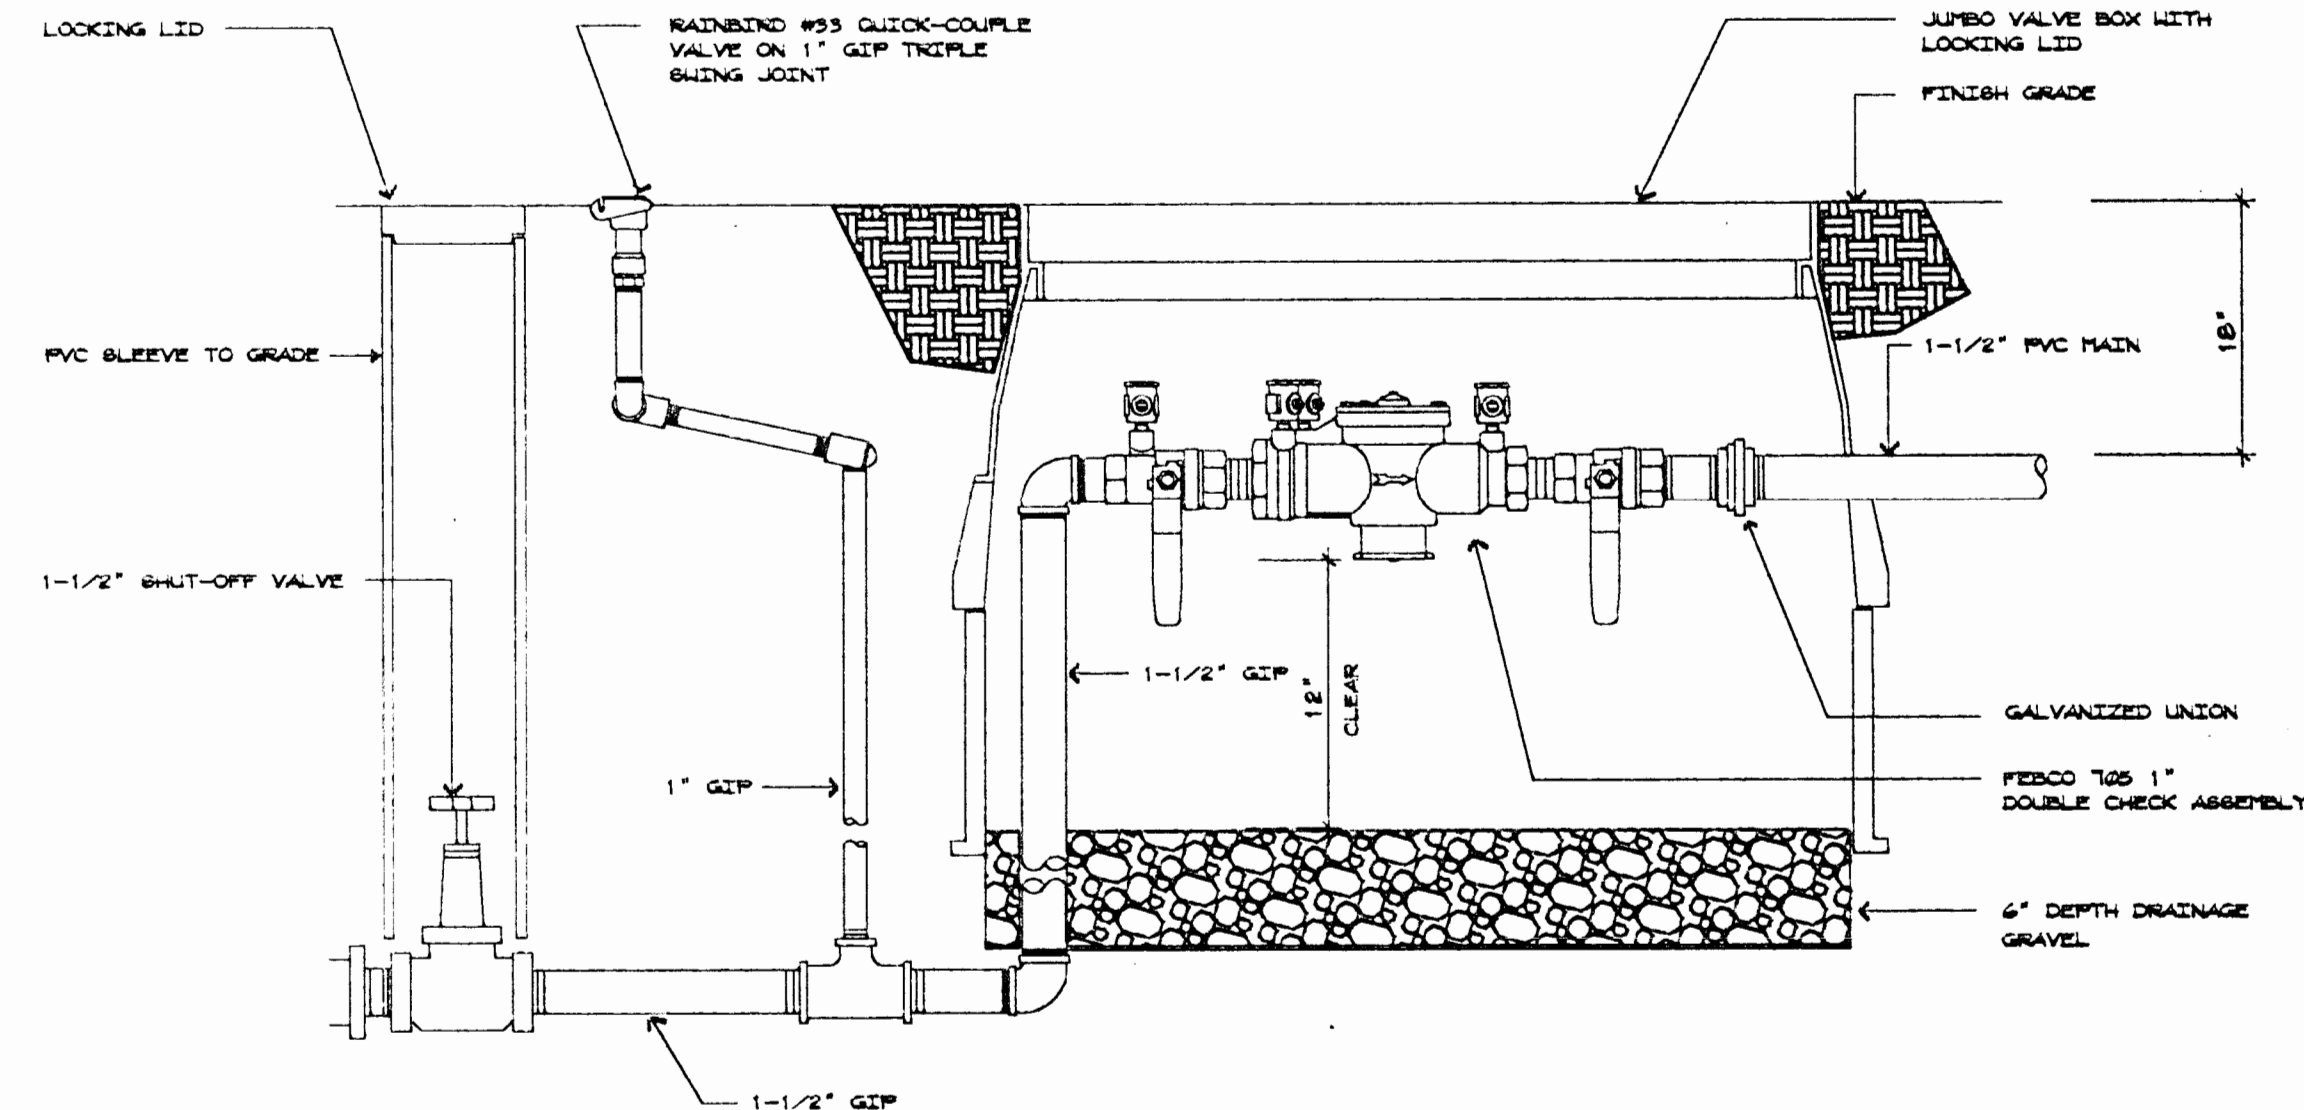

POINT OF CONNECTION

COPYRIGHT 1993
Lombard-Conrad ARCHITECTS
All rights reserved. Reproduction or translation of any part of this work without written permission of Lombard-Conrad Architects is unlawful and subject to criminal prosecution.

Lombard-Conrad
ARCHITECTS
P. A., A. I. A.
1221 SHORELINE LANE BOISE, IDAHO 83782 TEL: (208)345-6677

BANK OF AMERICA
FAIRVIEW AND MITCHELL
BOISE IDAHO

B
LANDSCAPE / IRRIGATION PLAN

JOB NO: 93031.01
DATE: 9-13-93
DRAWN BY: SCH
CHECKED BY: SCH
REVISIONS: 1. SHRUBS
2. SHRUBS
DATE: 9-14-93
BY: SCH

SHEET NO.
L1-1
OF 2 SHEETS

CONDENSING UNIT SCHEDULE						
NO.	CFM	HP	CHAR	BTU	ENT.AIR	MANUFACTURER
1	1100	15.6	208/3	41,400	95°F/63°F	'LENNOX' HS19-463V
2	2000	24.3	208/3	60,400	95°F/63°F	'LENNOX' HS19-653V
3	1100	14.5	208/3	36,000	95°F/63°F	'LENNOX' HS19-413V
4	480	16.0	208/1	18,000	95°F/63°F	'MITSUBISHI' PU-18G6-US

PROVIDE WITH LOW AMBIENT KITS

EXHAUST FAN SCHEDULE										
NO.	TYPE	CFM	SPE	HP	CHAR	RPM	TIP SPEED	OV	MANUFACTURER	REMARKS
1	CEILING CENTRIFUGAL	100	.25	1/100	120/1	1550	----	---	'PENN' ZEPHYR Z5	①
2	CEILING CENTRIFUGAL	100	.25	1/100	120/1	1550	----	---	'PENN' ZEPHYR Z5	①
3	CEILING CENTRIFUGAL	100	.25	1/100	120/1	1550	----	---	'PENN' ZEPHYR Z5	①
4	WALL PROPELLER	220	0	----	120/1	900	----	---	'PENN' TRANSFAN TF8	①
5	ROOF MOUNTED	1000	.25	1/4	120/1	1050	----	---	'PENN' DOMEX AB10	② PROVIDE SOUND CURB

① SWITCH AND PILOT OPERATED

② T-STAT OPERATED

FURNACE AND EVAPORATOR SCHEDULE																
NO.	TYPE	CFM	HP	CHAR	S.P.T.	HEATING				COOLING				S.P.E.	FRESH AIR	MANUFACTURER
						A.G.A. INPUT	A.G.A. OUTPUT	ENT. AIR	LVG. AIR	MBH	S/T	ENT. AIR	LVG. AIR			
1	VERT. CONDENSING	1100	1/3	120/1	.50	40	38	66°F	98°F	41.4	.87	81°F	46°F	.30	60	'LENNOX' G21Q3-40 WITH C14-41 COIL
2	VERT. CONDENSING	1950	3/4	120/1	.60	100	95	63°F	106°F	60.4	.96	82°F	54°F	.35	200	'LENNOX' G21Q4/5-100 WITH C14-65 COIL
3	VERT. CONDENSING	1100	1/3	120/1	.50	40	38	60°F	92°F	36.0	.99	82°F	52°F	.30	140	'LENNOX' G21Q3-40 WITH C14-41 COIL

PROVIDE T-STAT PER SPECS.

WALL MOUNTED AIR CONDITIONER W/ELECTRIC HEAT						
NO.	TYPE	CFM	CHAR	HEATING KW	COOLING BTU	MANUFACTURER
1	WALL MOUNTED	600	120/1	1.7	18,000	'MITSUBISHI' PKH-18AG.US

NOTE: AC-1 MATCHED WITH CU-4
PROVIDE T-STAT AND CONTROLS PER SPECS.

FIXTURE SCHEDULE					
SYM	DESCRIPTION	HOT	COLD	WASTE	VENT
P-1	WATER CLOSET	----	1/2"	4"	2"
P-2	LAVATORY - WALL HUNG	1/2"	1/2"	1 1/2"	1 1/2"
P-3	LAVATORY - VANITY MOUNT	1/2"	1/2"	1 1/2"	1 1/2"
P-4	JANITOR SINK	1/2"	1/2"	2"	2"
P-5	LOUNGE ROOM SINK	1/2"	1/2"	1 1/2"	1 1/2"
P-6	WATER HEATER	1"	1"	----	----
P-7	HOSE BIBB	----	3/4"	----	----
P-8	FLOOR DRAIN	----	----	2"	2"


GRILLE AND REGISTER SCHEDULE			
SYMBOL	DESCRIPTION	TYPE	FINISH
CD	CEILING DIFFUSER	'TITUS' TDC	OFF WHITE
RG	RETURN GRILLE	'TITUS' 50F	OFF WHITE
EG	EXHAUST GRILLE	'TITUS' 50F	OFF WHITE
FD	FLOOR DIFFUSER	'TITUS' CT-PP-0 *WITH O.B. DAMPER	ALUMINUM
FAL	FRESH AIR LOUVER	'AIROLITE' 6776	PRIME COAT

1. CONTRACTOR SHALL VERIFY EXACT BUILDING CONSTRUCTION AND CEILING TYPES AND PROVIDE THE CORRECT FRAMES FOR ALL AIR DIFFUSION PRODUCTS AS REQUIRED AND VERIFY ALL COLORS AND FINISHES W/ ARCH. PRIOR TO SUBMITTAL. THE FOLLOWING MANUFACTURERS ARE ACCEPTABLE SUBSTITUTES PROVIDING THEY MEET THE REQUIREMENTS AS SCHEDULED: ANEMOSTAT, CARNES, KREUGER, METALAIRE, TITUS E.H. PRICE AND J&J REGISTER.

2. GRILLES AND REGISTERS INSTALLED IN ALL CEILINGS SHALL BE SECURED AND/OR SUPPORTED IN ACCORDANCE W/ UNIFORM BUILDING CODE STANDARDS FOR SEISMIC DESIGN.

* PROVIDE HEAVY DUTY FLOOR FRAME.

JOB #93033
Engineering Incorporated
2222 Broadway, Boise, Idaho 83706
(208)343-3663 FAX (208)343-9528

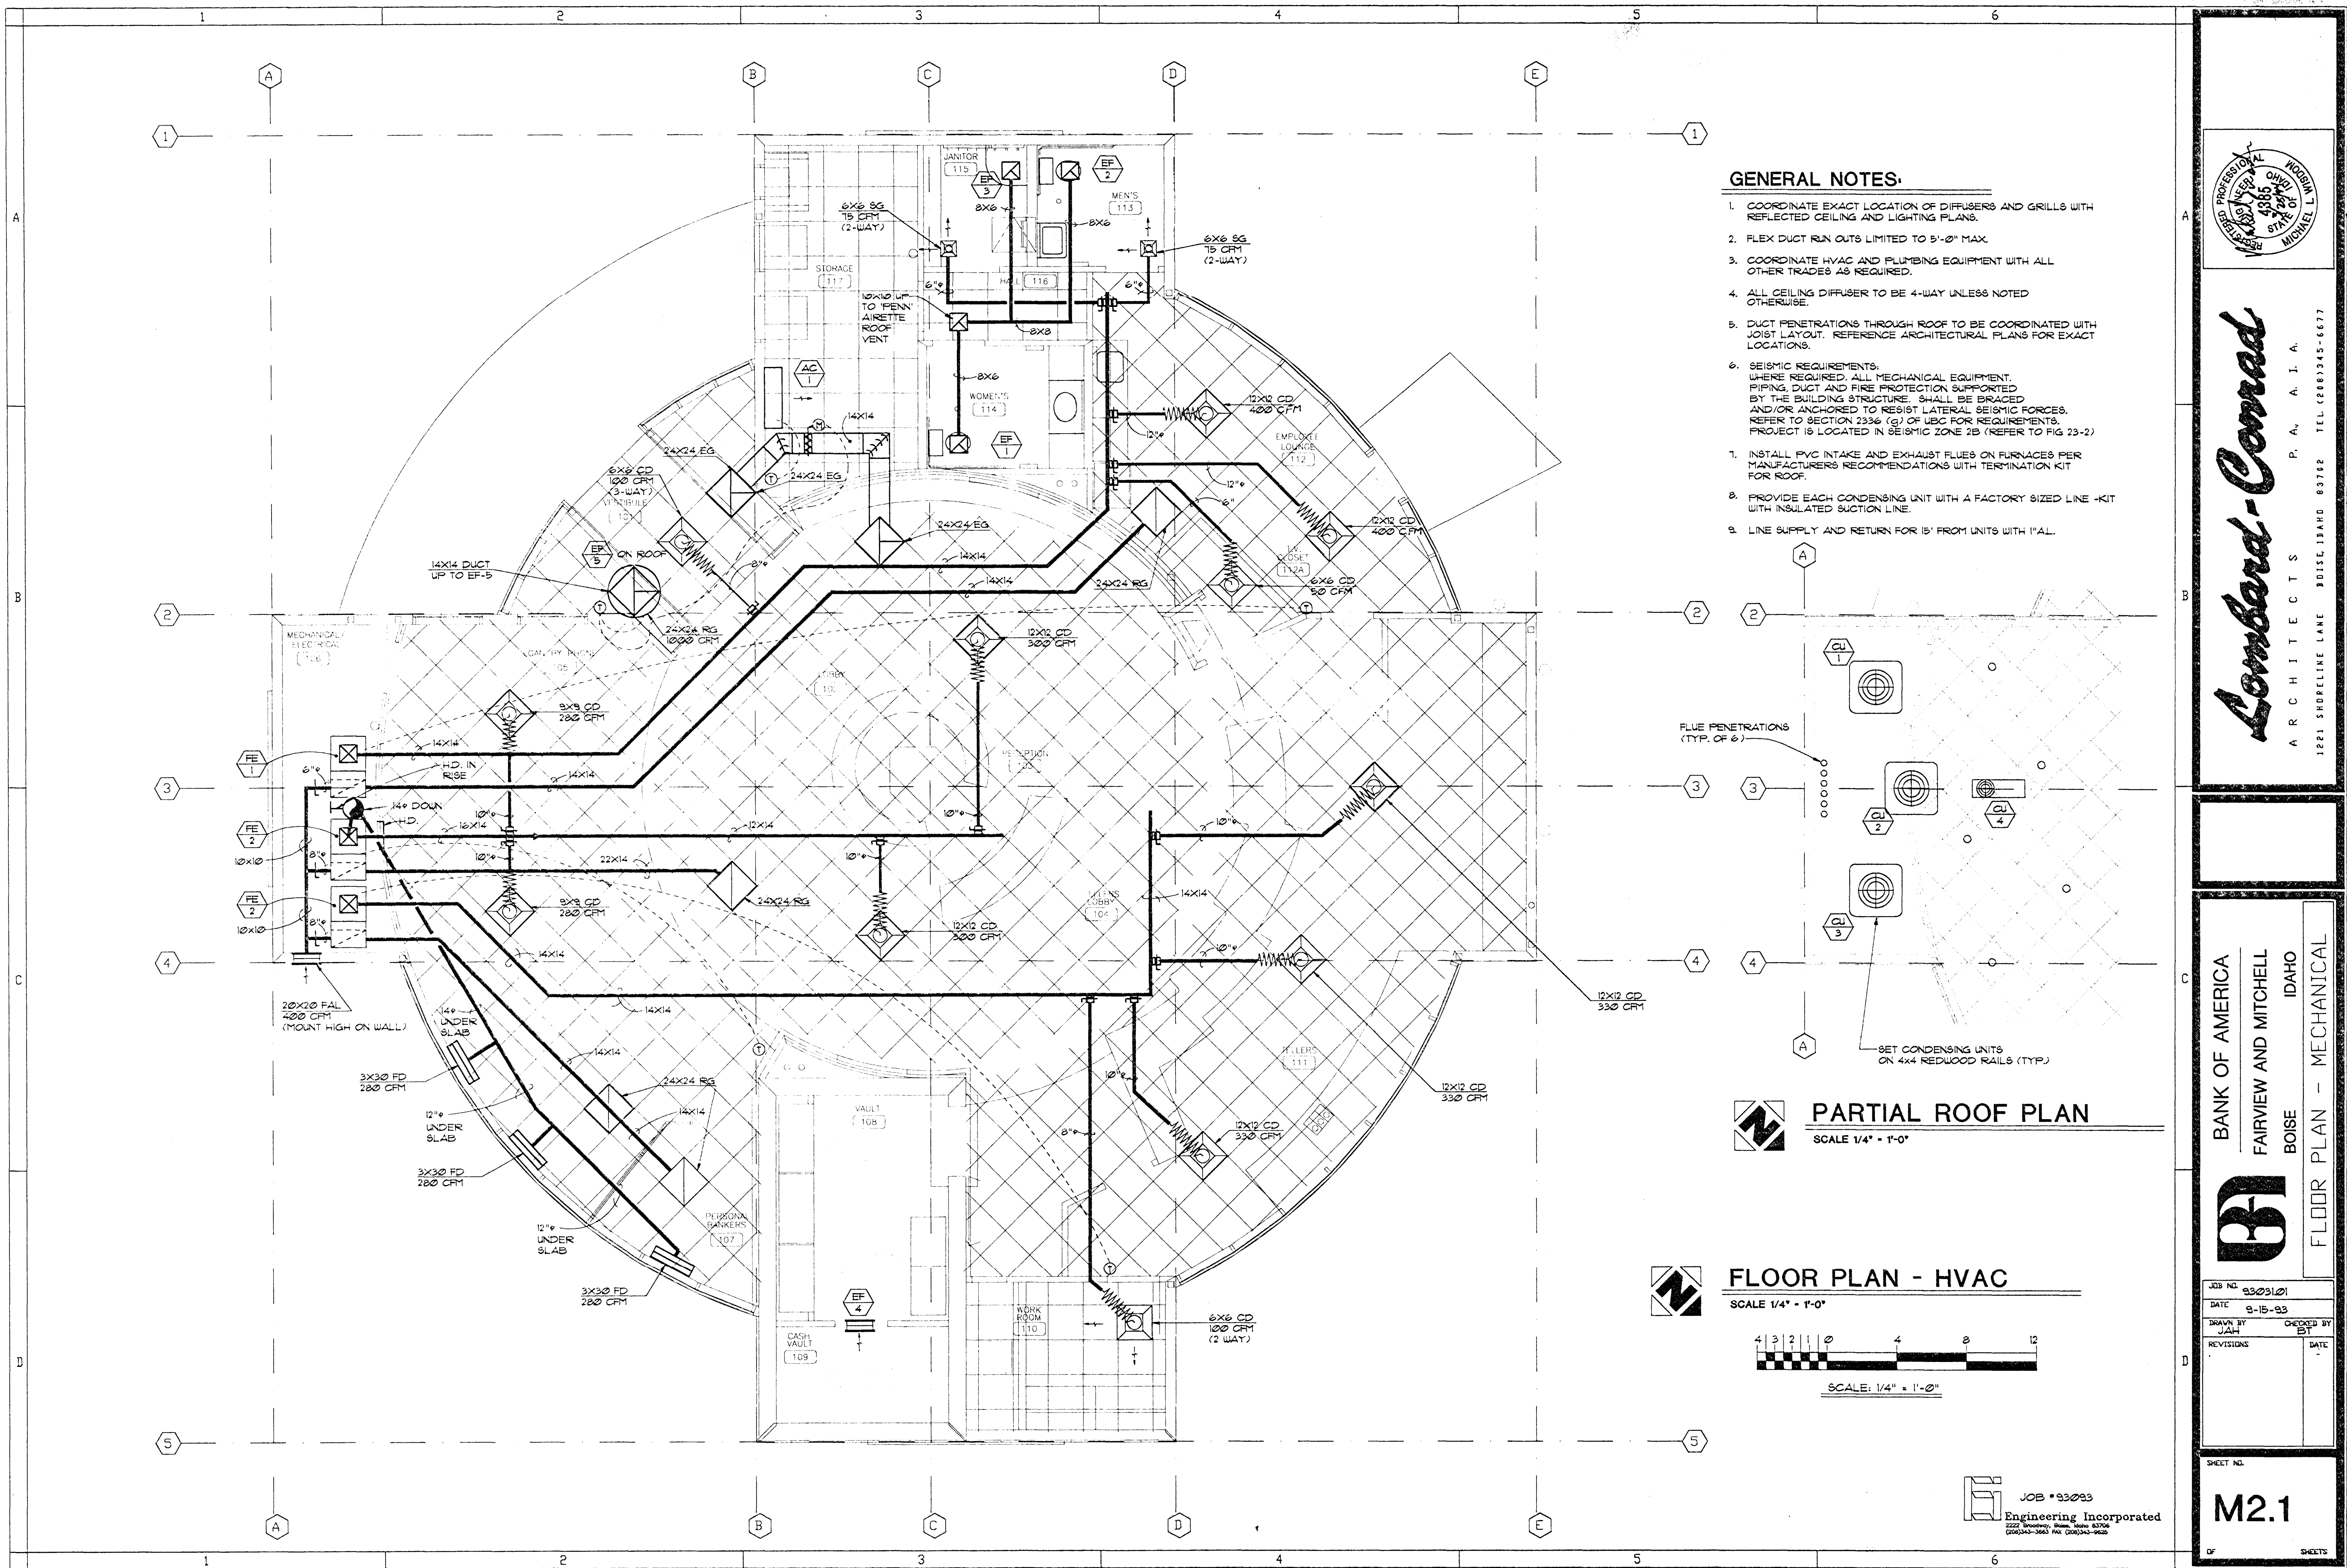


GENERAL NOTES:


- 1. COORDINATE EXACT LOCATION OF DIFFUSERS AND GRILLS WITH REFLECTED CEILING AND LIGHTING PLANS.
- 2. FLEX DUCT RUN OUTS LIMITED TO 5'-0" MAX.
- 3. COORDINATE HVAC AND PLUMBING EQUIPMENT WITH ALL OTHER TRADES AS REQUIRED.
- 4. ALL CEILING DIFFUSER TO BE 4-WAY UNLESS NOTED OTHERWISE.
- 5. DUCT PENETRATIONS THROUGH ROOF TO BE COORDINATED WITH JOIST LAYOUT. REFERENCE ARCHITECTURAL PLANS FOR EXACT LOCATIONS.
- 6. SEISMIC REQUIREMENTS: WHERE REQUIRED, ALL MECHANICAL EQUIPMENT, PIPING, DUCT AND FIRE PROTECTION SUPPORTED BY THE BUILDING STRUCTURE. SHALL BE BRACED AND/OR ANCHORED TO RESIST LATERAL SEISMIC FORCES. PROJECT IS LOCATED IN SEISMIC ZONE 2B (REFER TO FIG 23-2).
- 7. INSTALL PVC INTAKE AND EXHAUST FLUES ON FURNACES PER MANUFACTURER'S RECOMMENDATIONS WITH TERMINATION KIT FOR ROOF.
- 8. PROVIDE EACH CONDENSING UNIT WITH A FACTORY SIZED LINE -KIT WITH INSULATED SUCTION LINE.
- 9. LINE SUPPLY AND RETURN FOR 15' FROM UNITS WITH 1" AL.

PARTIAL ROOF PLAN
SCALE 1/4" = 1'-0"

FLOOR PLAN - HVAC
SCALE 1/4" = 1'-0"

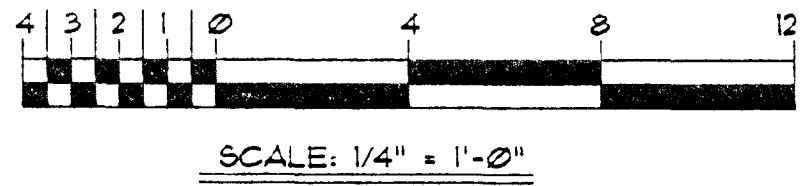


JOB #33093
Engineering Incorporated
2222 Broadway, Suite 300
(208) 342-3663 FAX (208) 342-9600

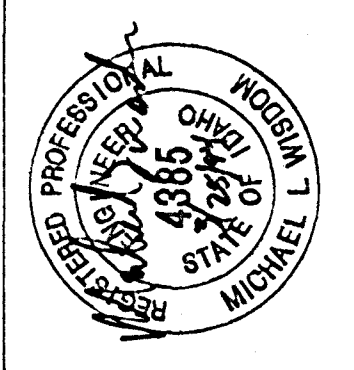

Lombard-Conrad
ARCHITECTS
1221 SHORELINE LANE BOISE, IDAHO 83702 TEL (208) 345-6677

BANK OF AMERICA
FAIRVIEW AND MITCHELL
BOISE IDAHO
FLOOR PLAN - MECHANICAL

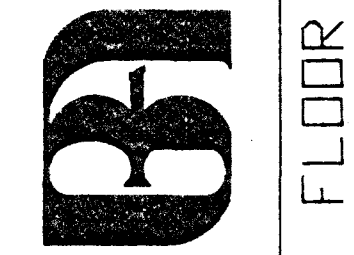


JOB NO.	9309101
DATE	9-15-93
DRAWN BY	JAH
CHECKED BY	BT
REVISIONS	
DATE	

SHEET NO.

M2.1

OF SHEETS

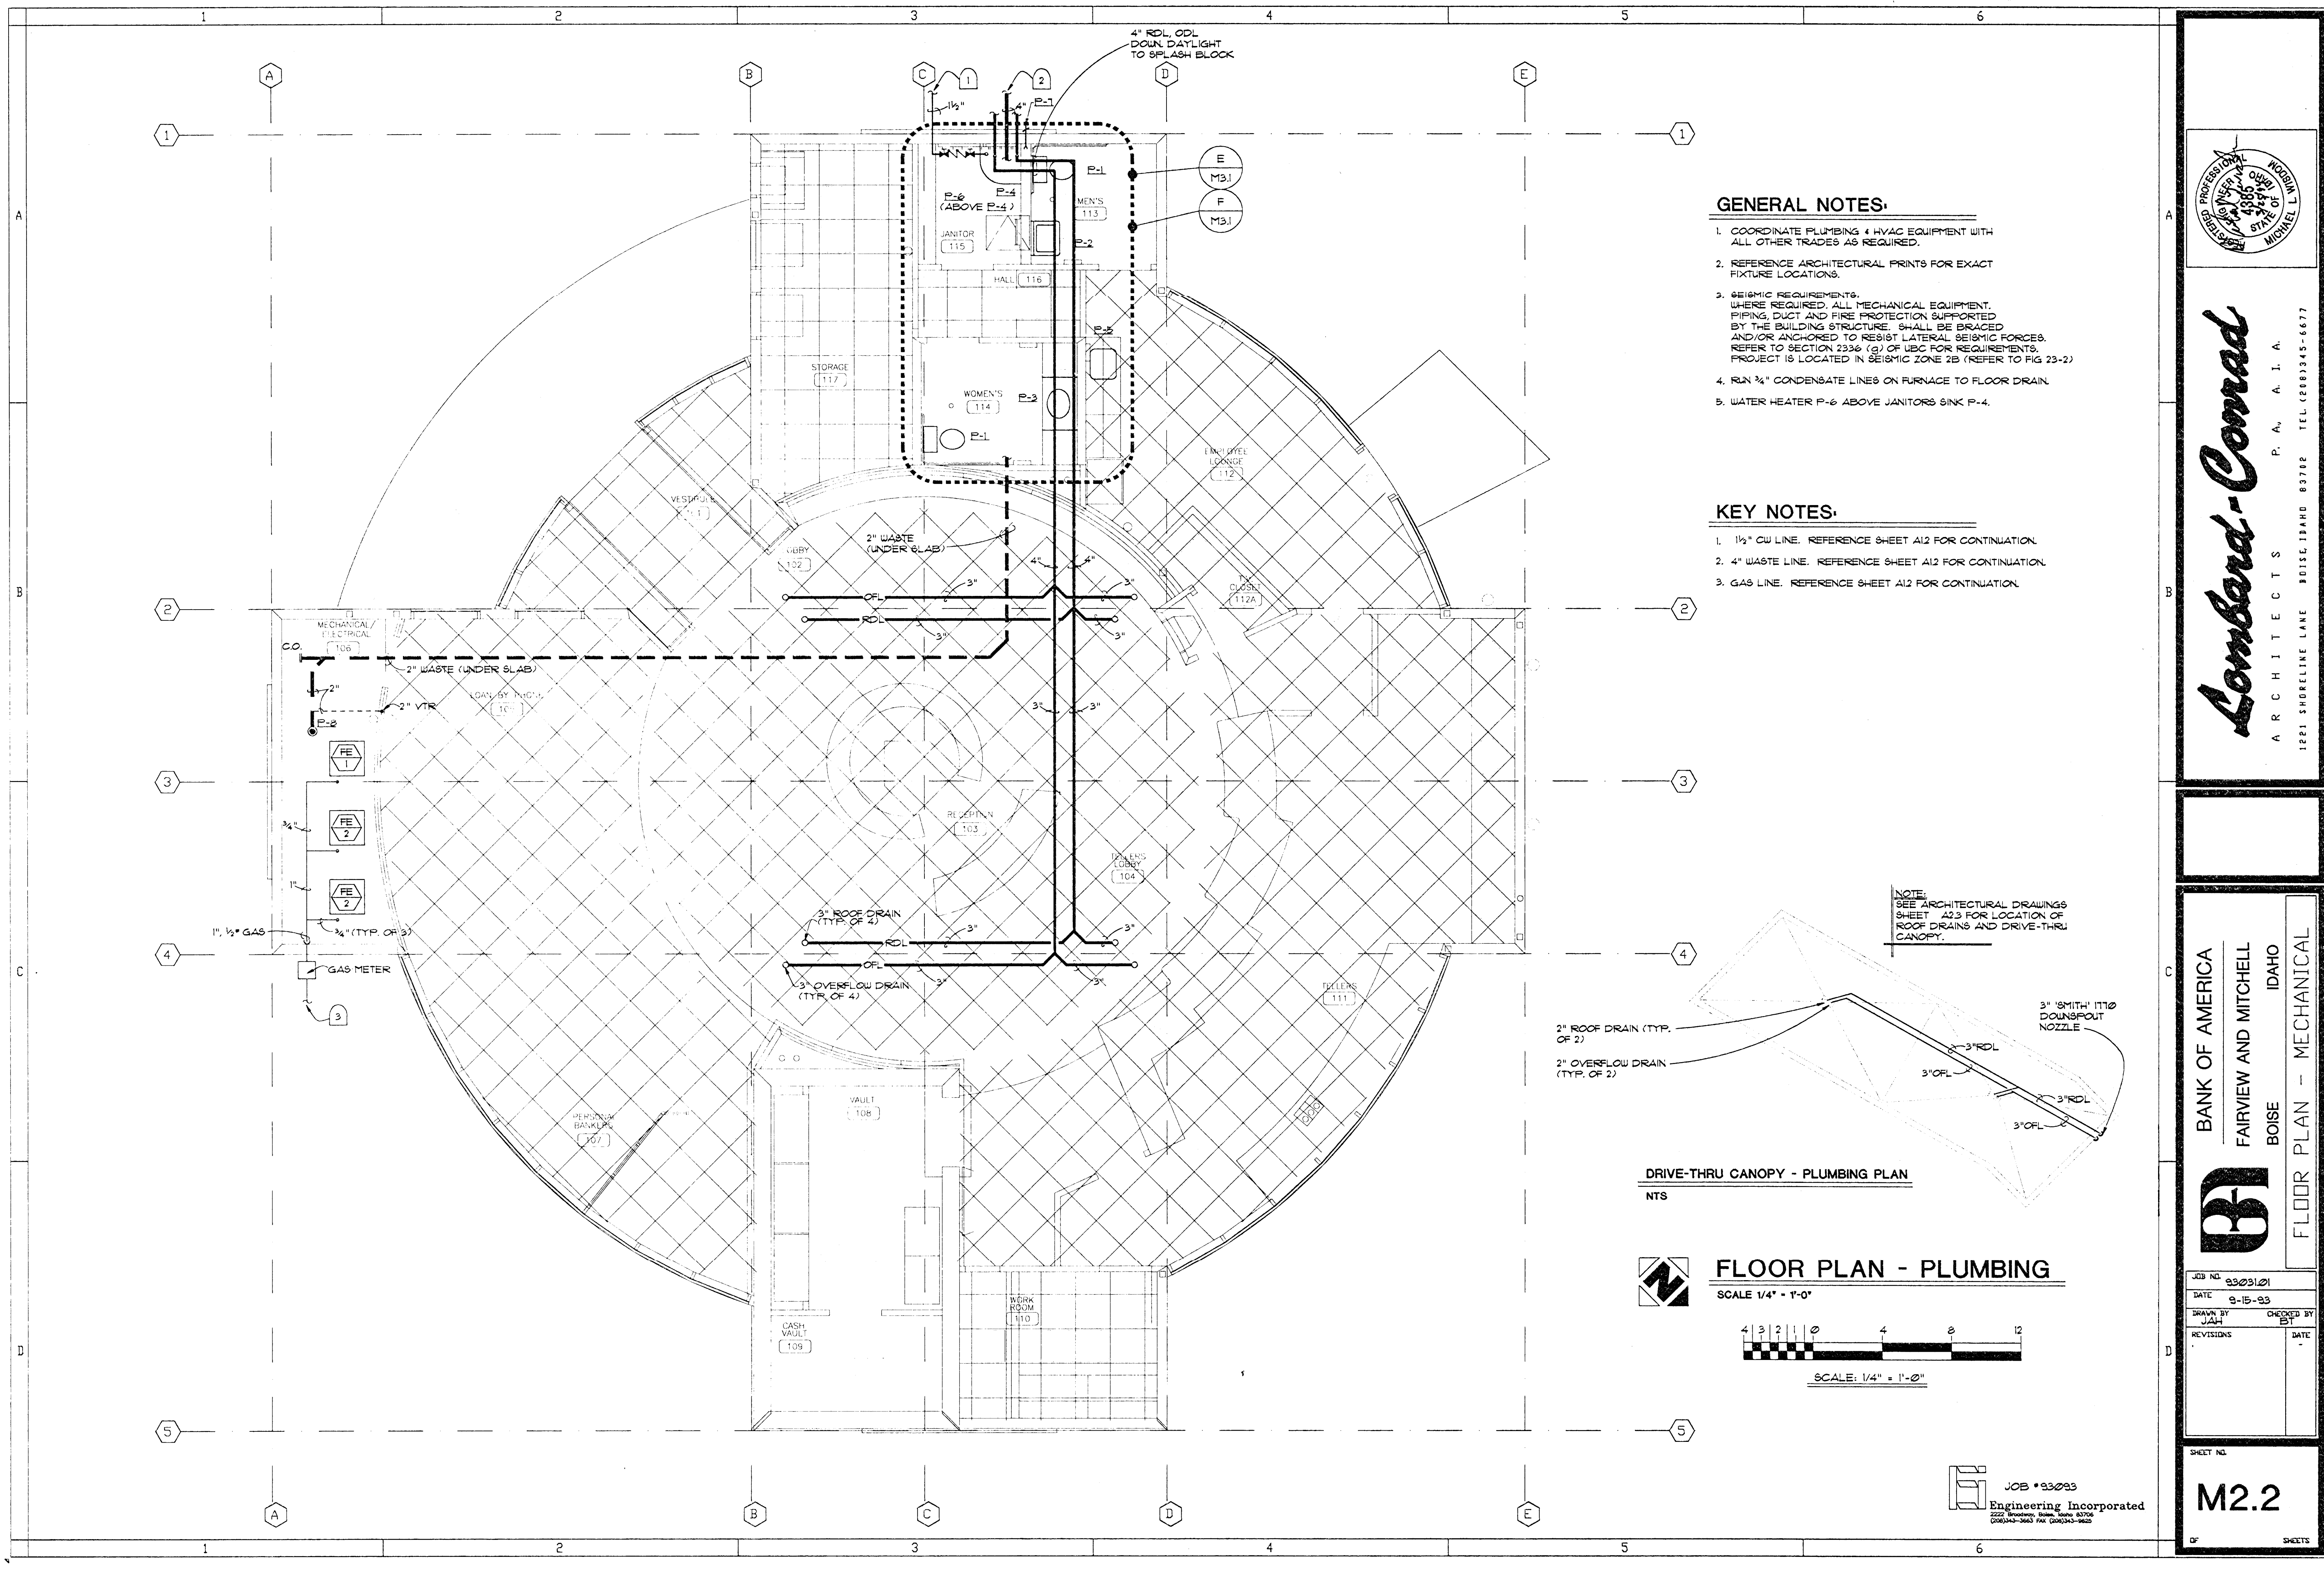


GENERAL NOTES:

1. COORDINATE PLUMBING & HVAC EQUIPMENT WITH ALL OTHER TRADES AS REQUIRED.
2. REFERENCE ARCHITECTURAL PRINTS FOR EXACT FIXTURE LOCATIONS.
3. SEISMIC REQUIREMENTS, WHERE REQUIRED, ALL MECHANICAL EQUIPMENT, PIPING, DUCT AND FIRE PROTECTION SUPPORTED BY THE BUILDING STRUCTURE, SHALL BE BRACED AND/OR ANCHORED TO RESIST LATERAL SEISMIC FORCES. REFER TO SECTION 2336 (g) OF UBC FOR REQUIREMENTS. PROJECT IS LOCATED IN SEISMIC ZONE 2B (REFER TO FIG 23-2)
4. RUN 3/4" CONDENSATE LINES ON FURNACE TO FLOOR DRAIN.
5. WATER HEATER P-6 ABOVE JANITORS SINK P-4.

KEY NOTES:

1. 1/2" CW LINE. REFERENCE SHEET A12 FOR CONTINUATION.
2. 4" WASTE LINE. REFERENCE SHEET A12 FOR CONTINUATION.
3. GAS LINE. REFERENCE SHEET A12 FOR CONTINUATION.

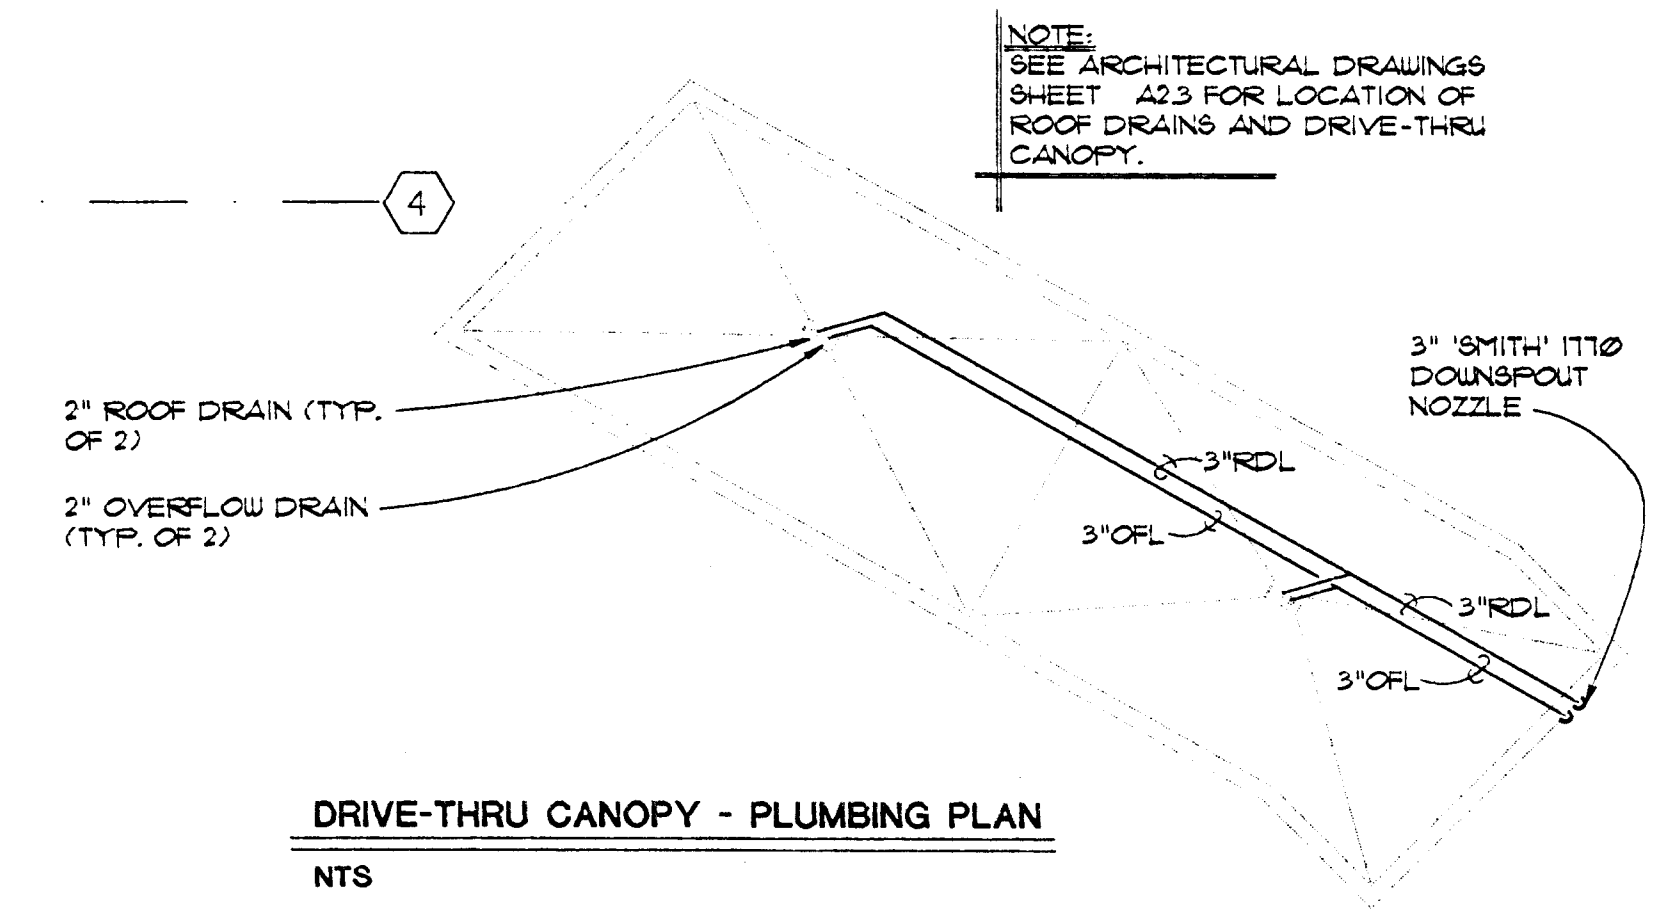

DRIVE-THRU CANOPY - PLUMBING PLAN
NTS




FLOOR PLAN - PLUMBING


SCALE 1/4" = 1'-0"



SCALE: 1/4" = 1'-0"

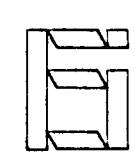


JOB # 23033
Engineering Incorporated
2222 Broadway, Suite 400
(208) 343-3663 FAX (208) 343-3620

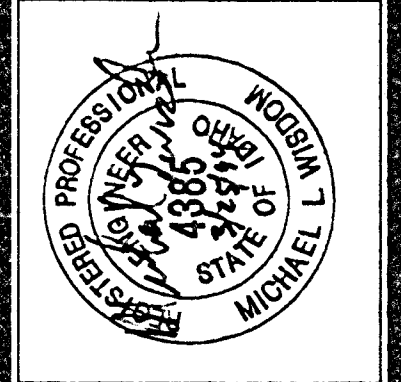






Conrad-Conrad
ARCHITECTS
1221 SHORELINE LANE BOISE, IDAHO 83702 TEL (208) 345-6677
P. A. A. I. A.

BANK OF AMERICA
FAIRVIEW AND MITCHELL
BOISE IDAHO
FLOOR PLAN - MECHANICAL

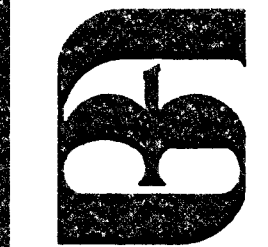

JOB NO.	23031.01
DATE	9-15-83
DRAWN BY	JAH
CHECKED BY	BT
REVISIONS	
DATE	

SHEET NO.
M2.2
SHEETS

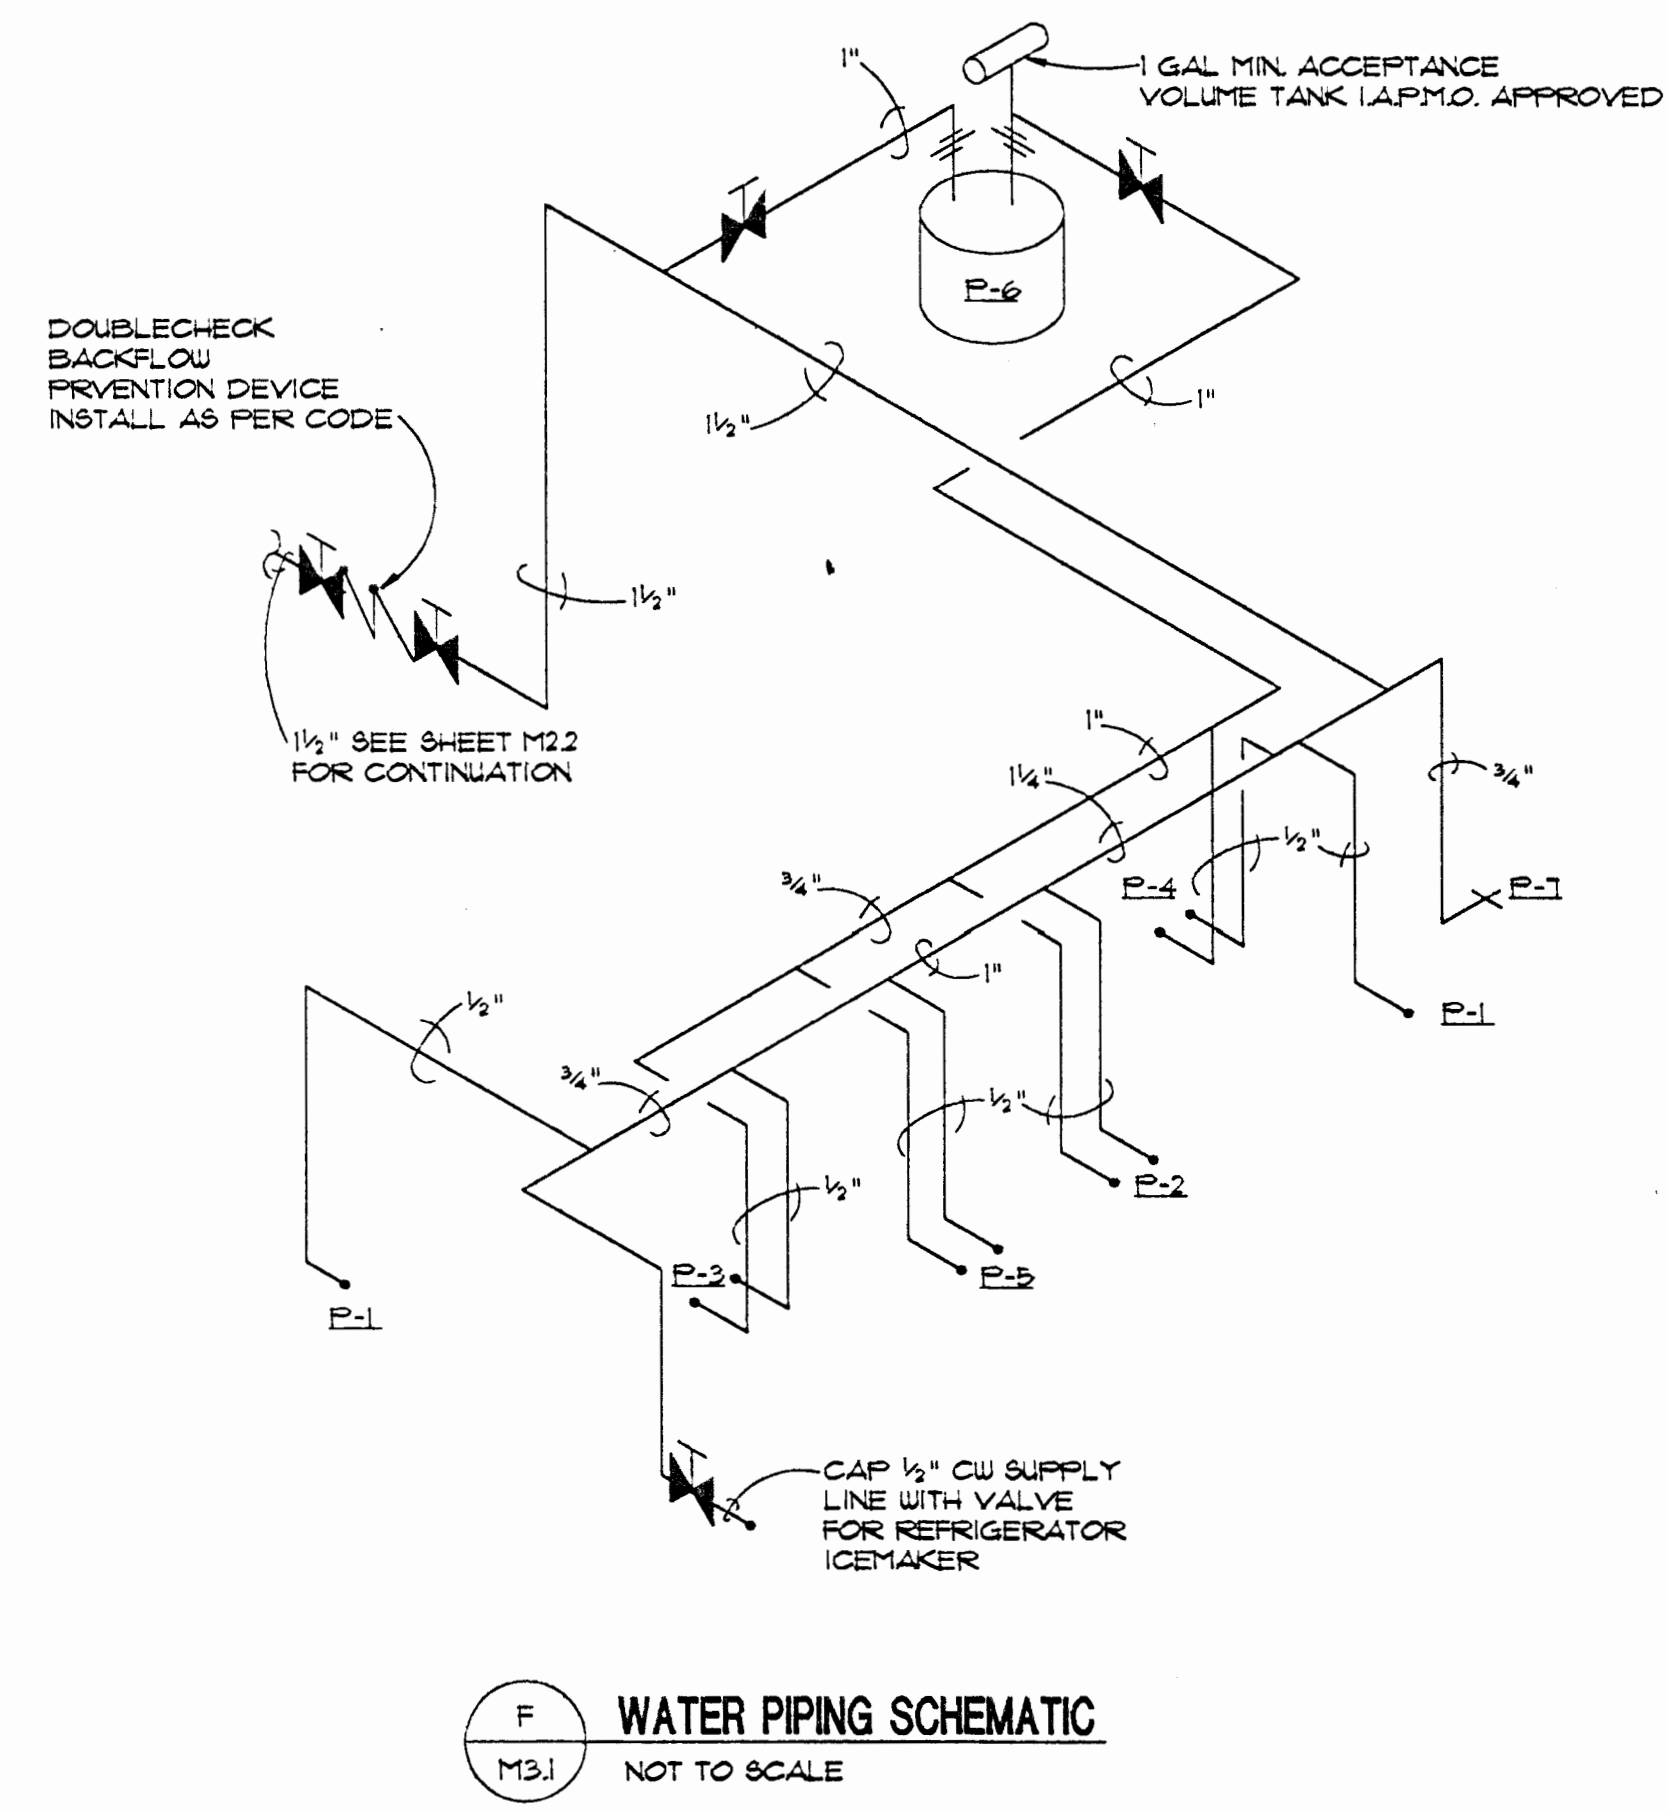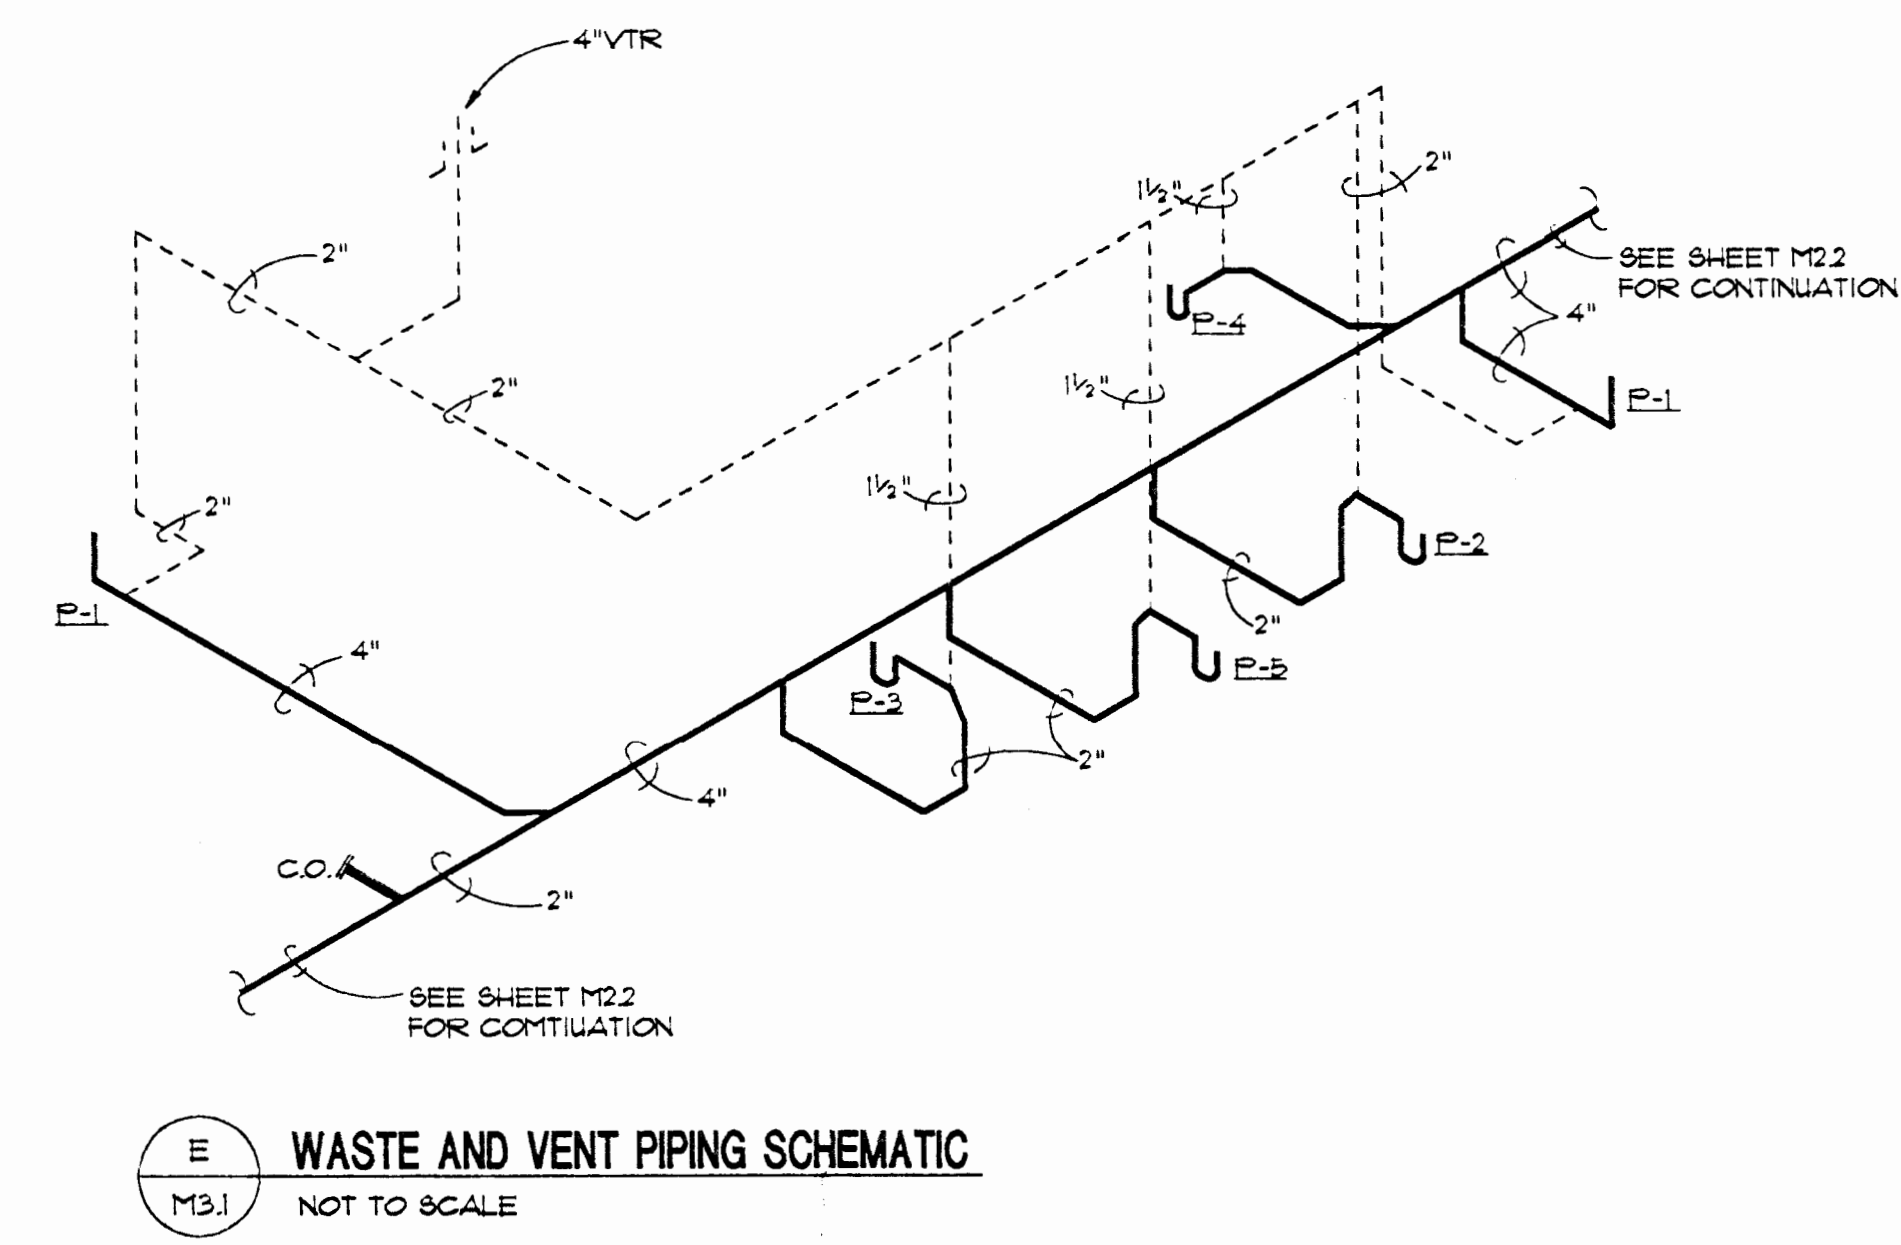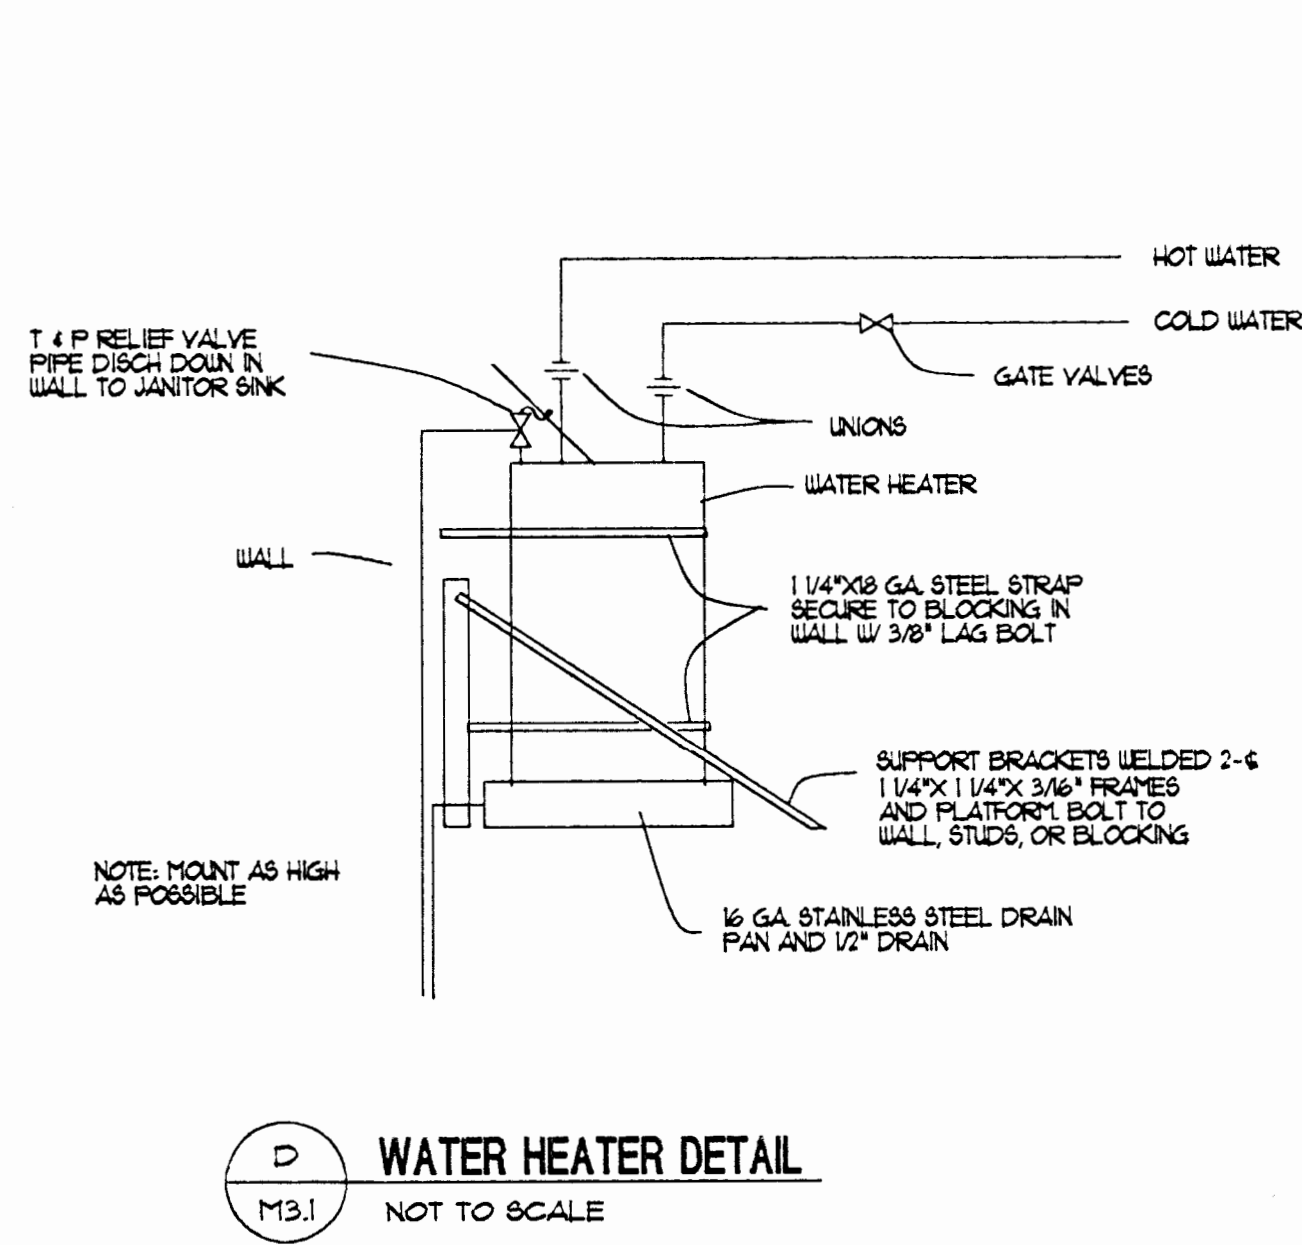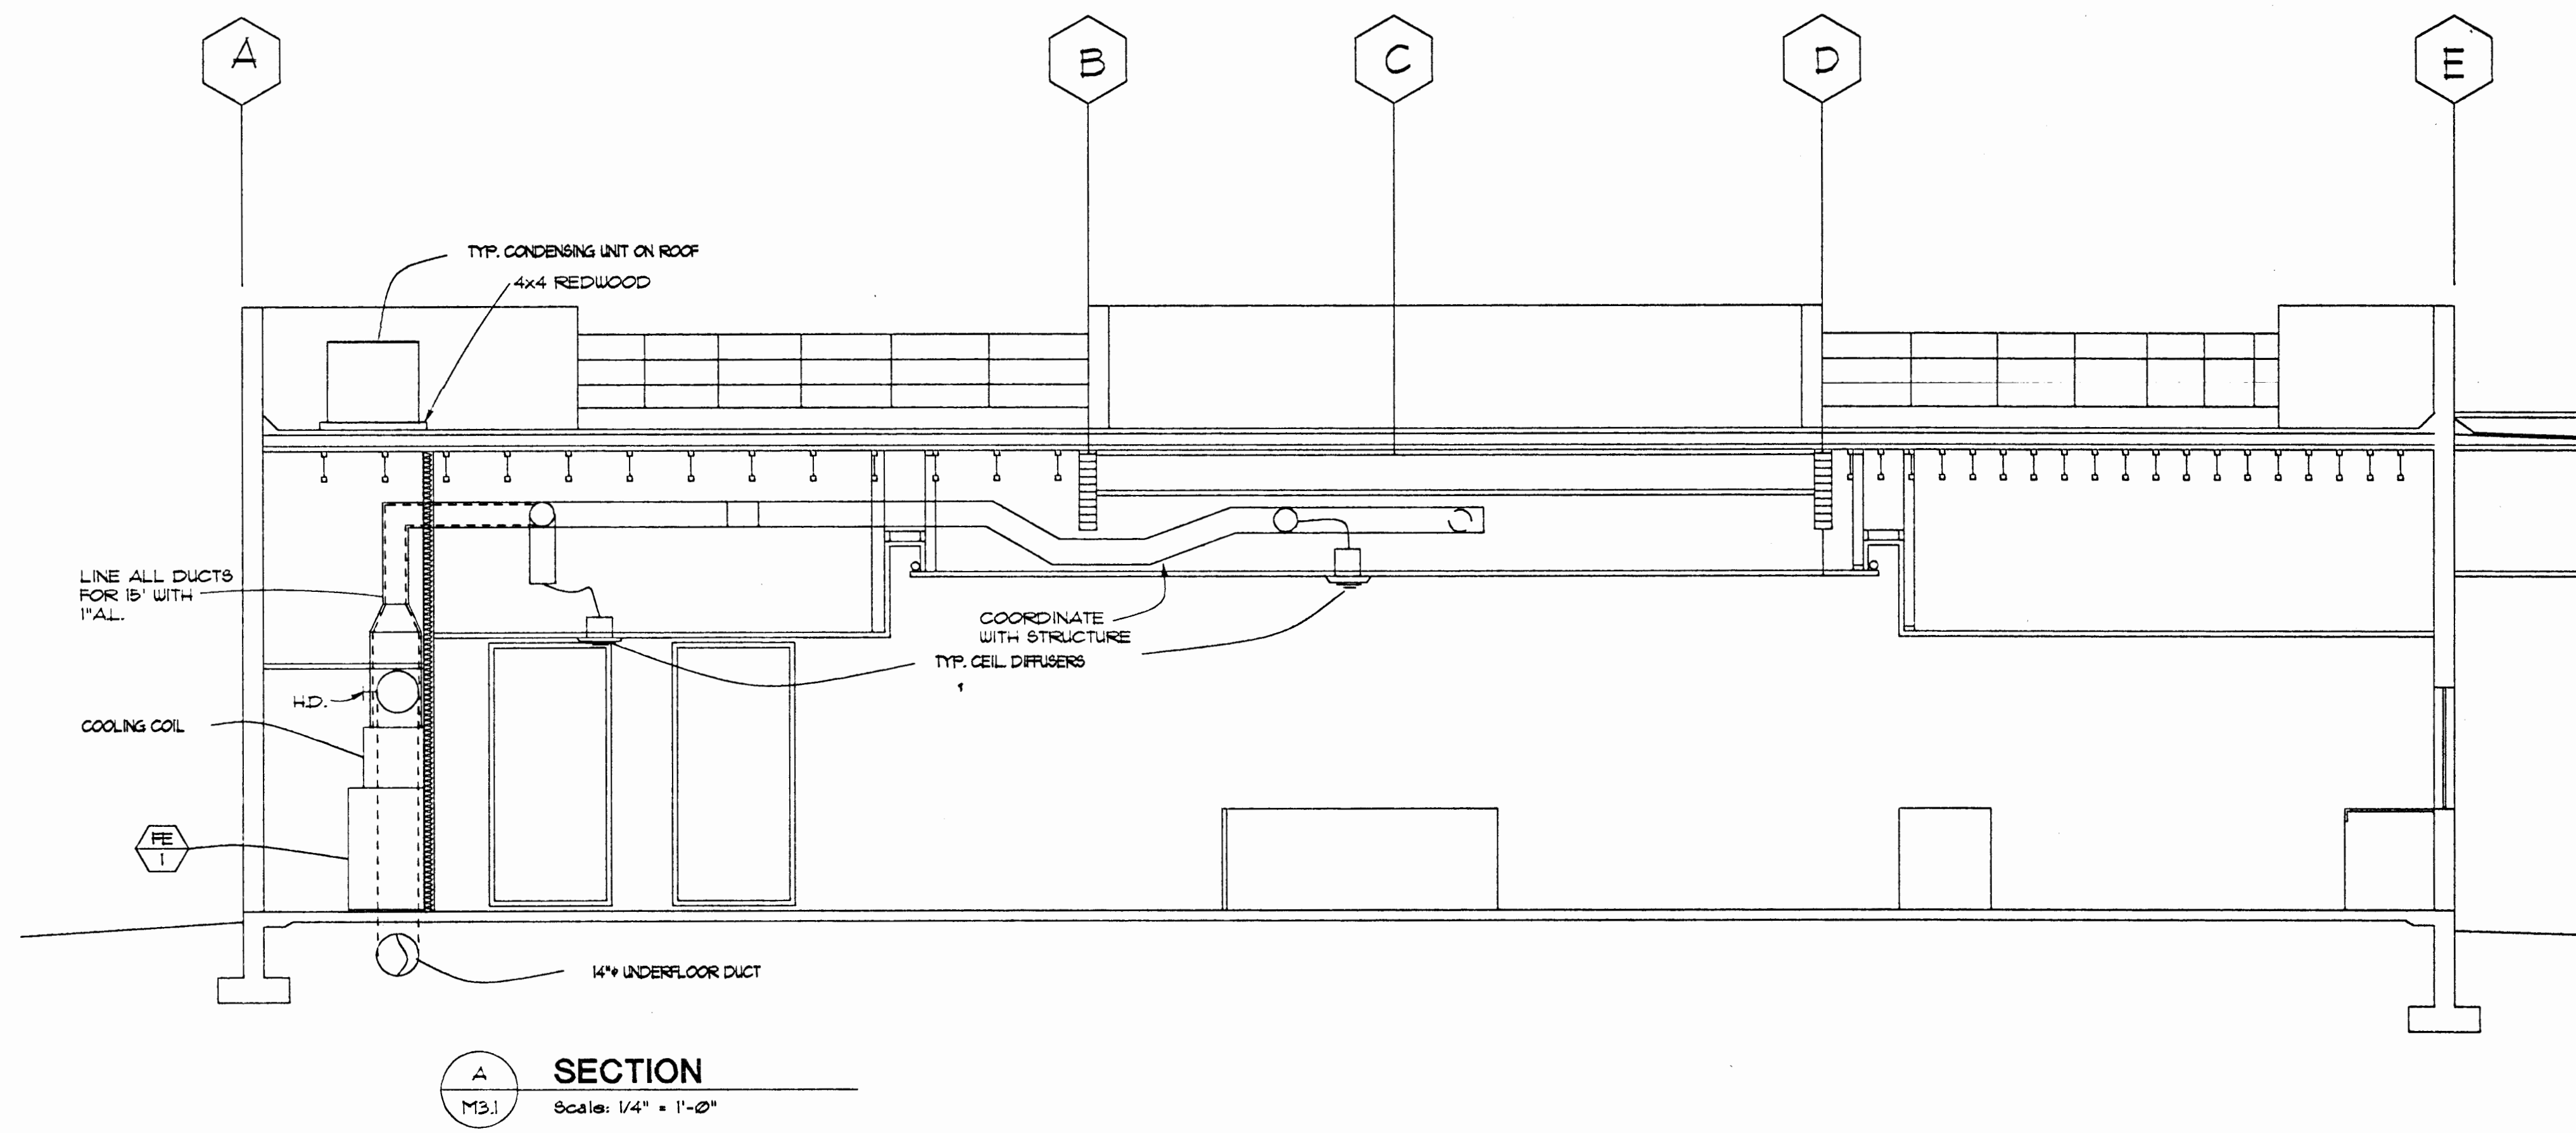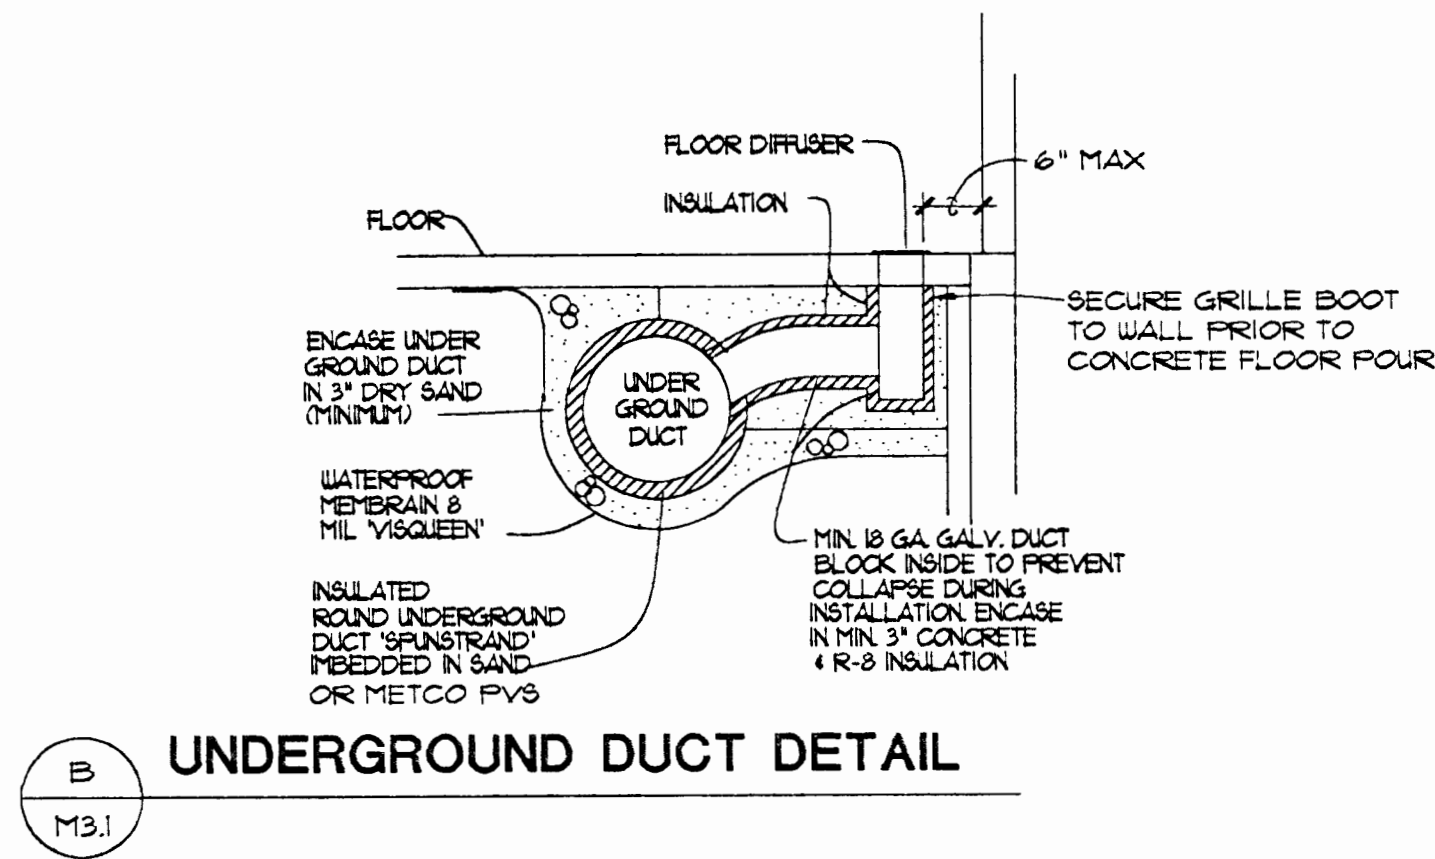

JOB # 93093
Engineering Incorporated
222 Broadway, Suite 300, Boise, Idaho 83720
(208) 343-3667 FAX (208) 343-9862

PROFESSIONAL
REGISTERED
ENGINEER
1485
STATE OF
IDAHO
MICHAEL L.

Lombard-Conrad
ARCHITECTS
1221 SHORELINE LANE BOISE, IDAHO 83702 TEL (208) 345-6677

BANK OF AMERICA
FAIRVIEW AND MITCHELL
BOISE IDAHO


FLOOR PLAN - MECHANICAL

JOB NO. 9303101
DATE 9-15-93
DRAWN BY SKC
CHECKED BY BT
REVISIONS


M3.1

SHEET NO.

M3.1

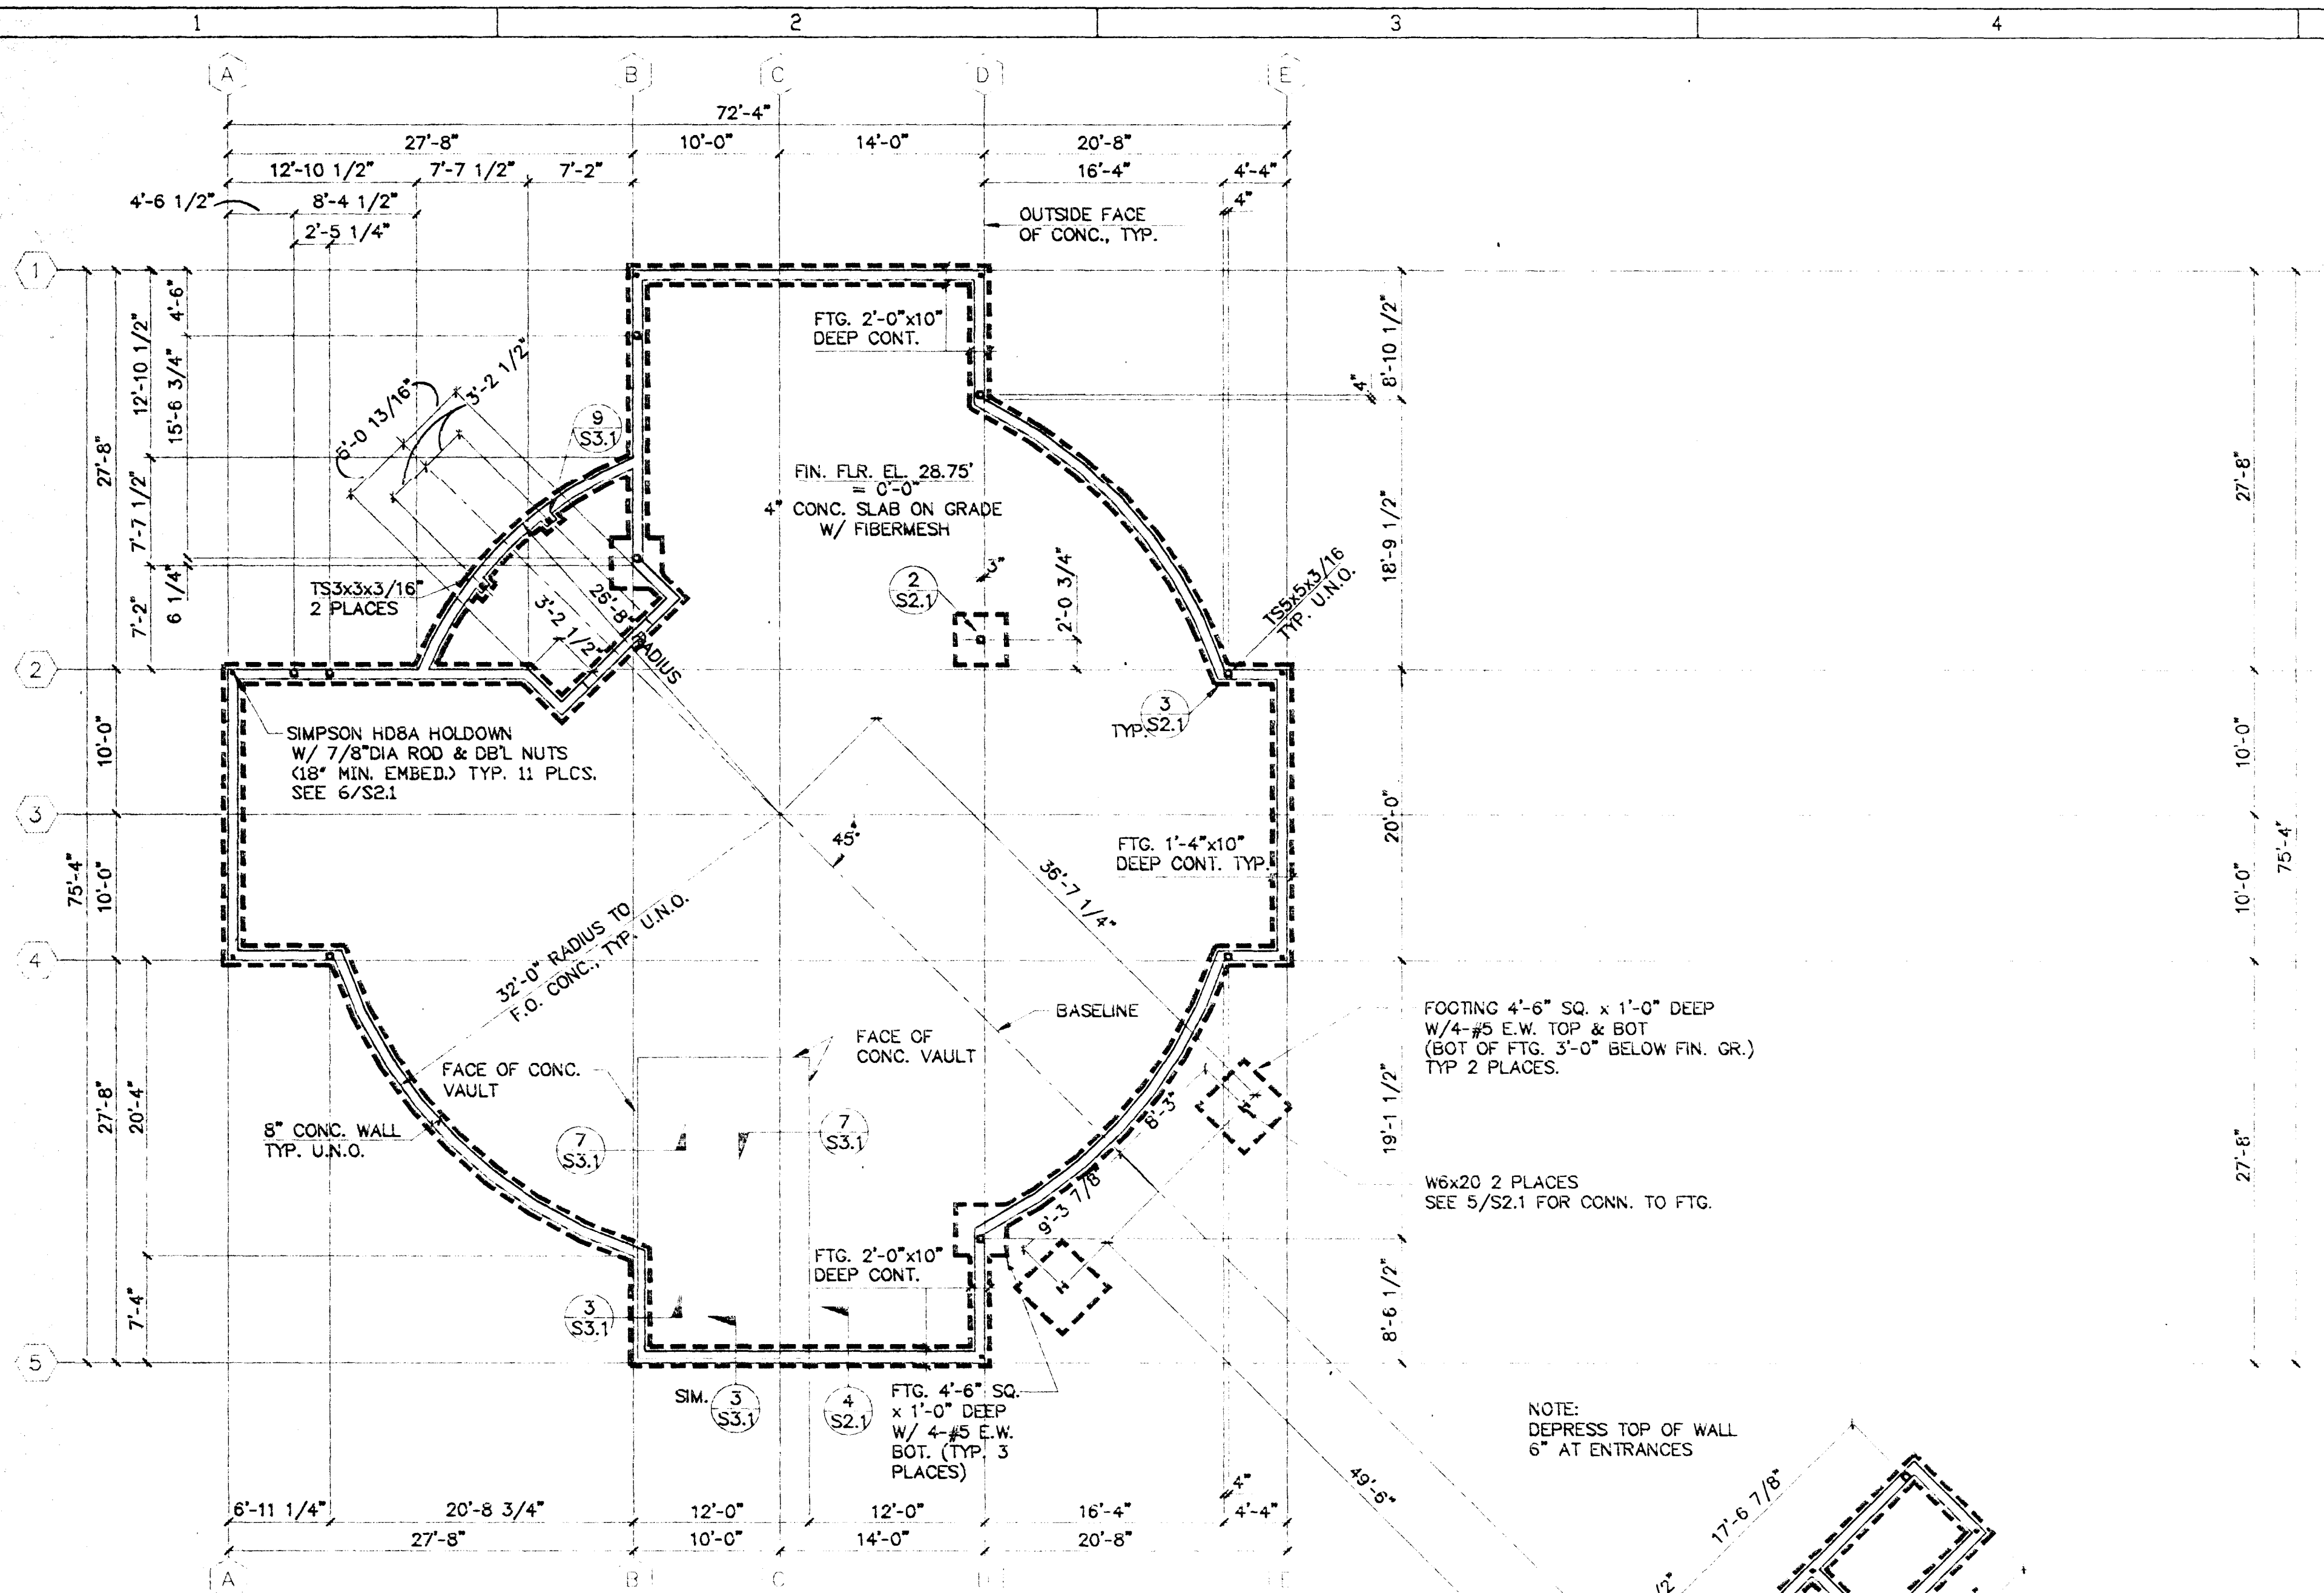


FOUNDATION PLAN

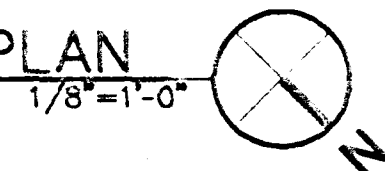

NOTE:
DEPRESS TOP OF WALL
6" AT ENTRANCES

1/8" SAW JOINT AS SOON AS PRACTICAL AFTER POUR. FILL WITH JOINT SEALANT ON DAY AFTER SAWING AT EXPOSED CONCRETE FLOORS. DEPTH OF CUT EQUAL TO ONE FIFTH SLAB DEPTH.

3/4" ROUND x 12" SMOOTH DOWEL @ 24" O.C. CENTERED IN SLAB. GRIND ENDS OF DOWEL TO REMOVE SHEARING BURRS. GREASE OR WRAP ON END TO PREVENT BOND.

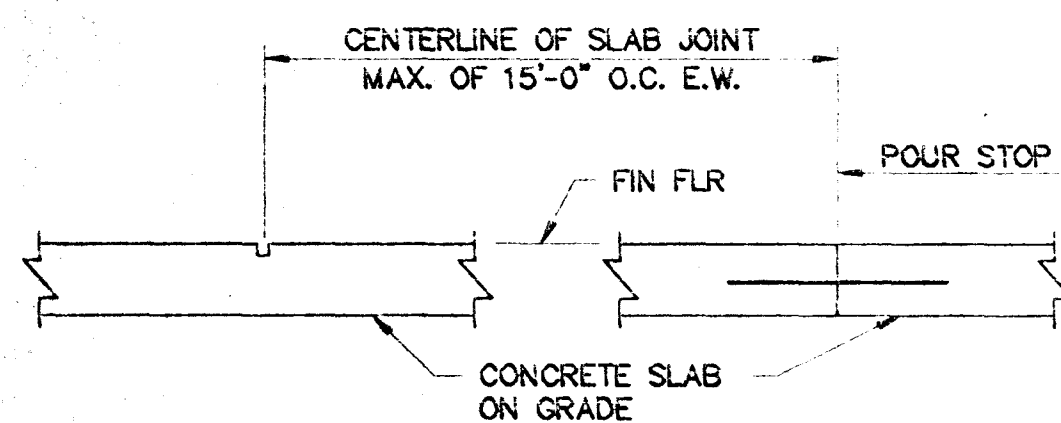


CONTROL JOINT

CONSTRUCTION JOINT

JOINT TYPE IS CONTRACTOR'S OPTION


1 SLAB ON GRADE JOINT DETAIL

3/4" = 1'-0"

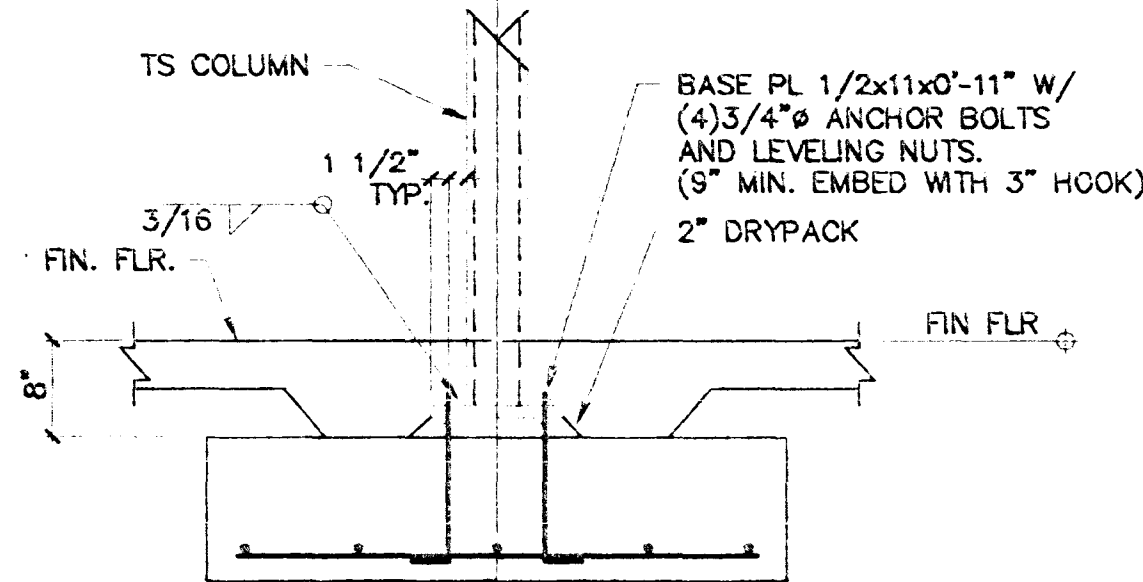


2 COLUMN BASE PLATE AT FTG. PAD DETAIL

3/4" = 1'-0"

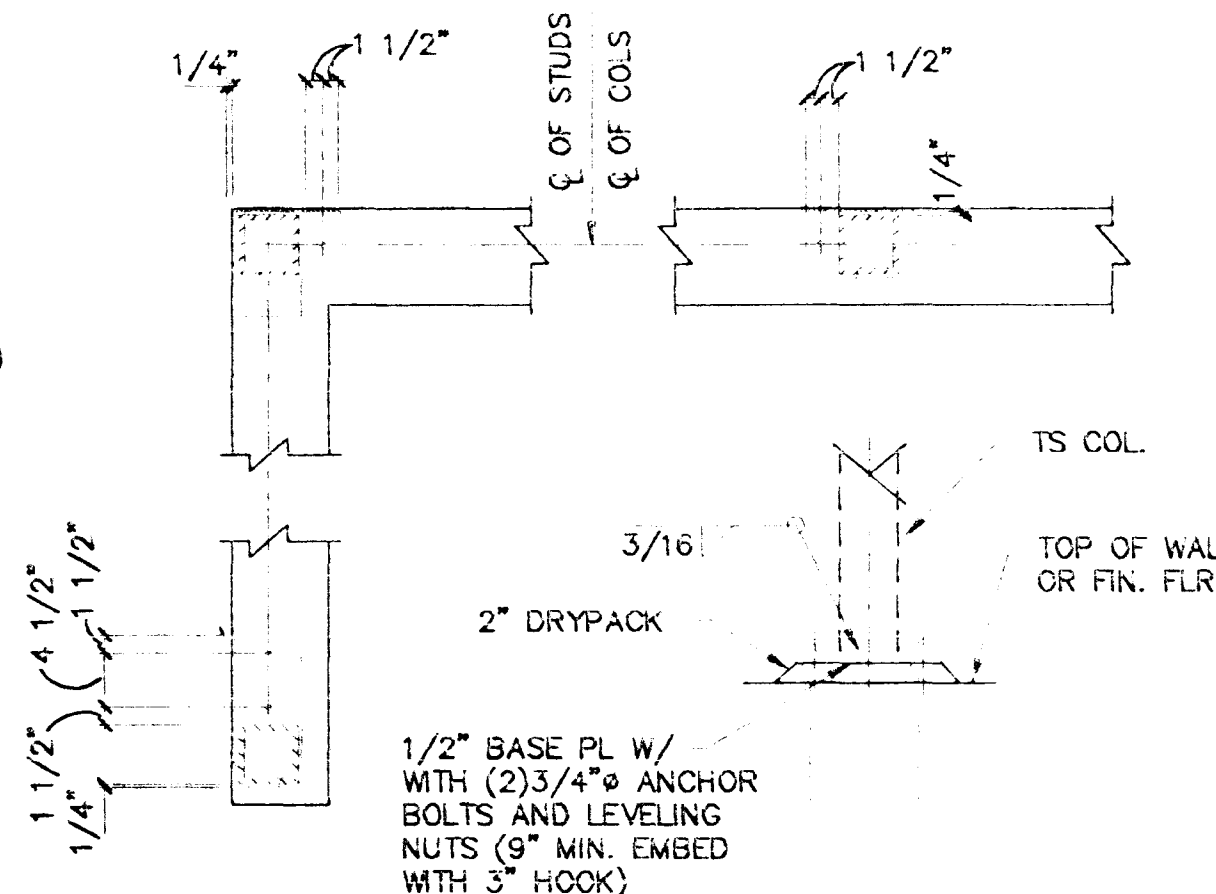


3 COLUMN BASE PLATE AT CONC. WALLS

3/4" = 1'-0"

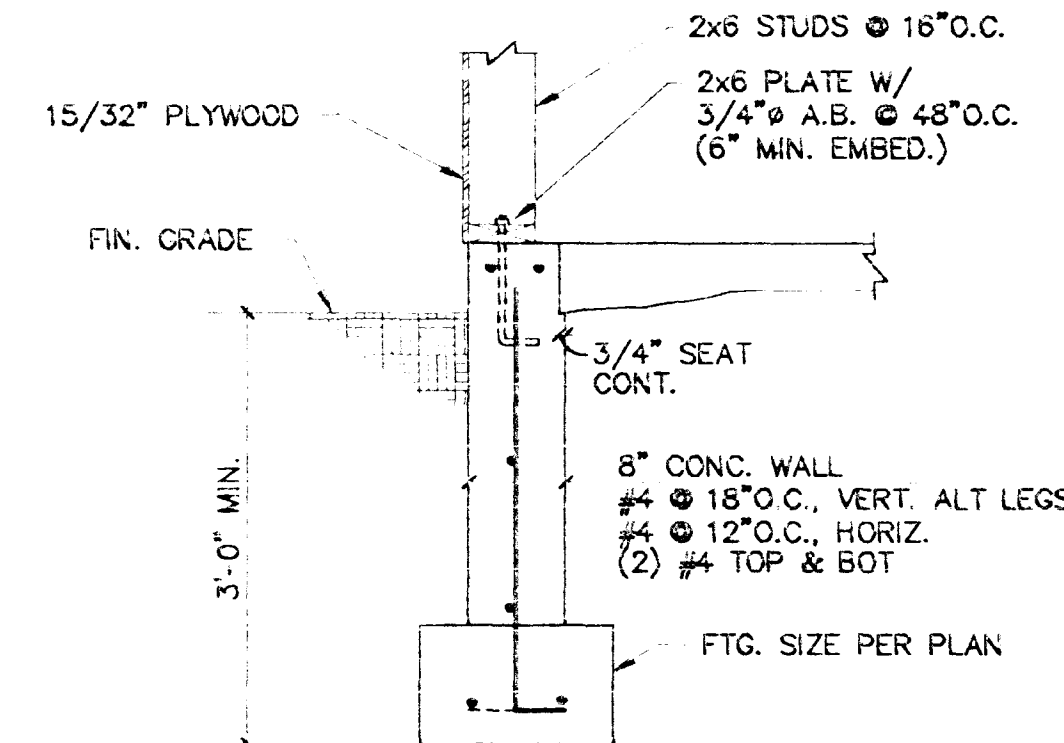


4 WALL SECTION

3/4" = 1'-0"

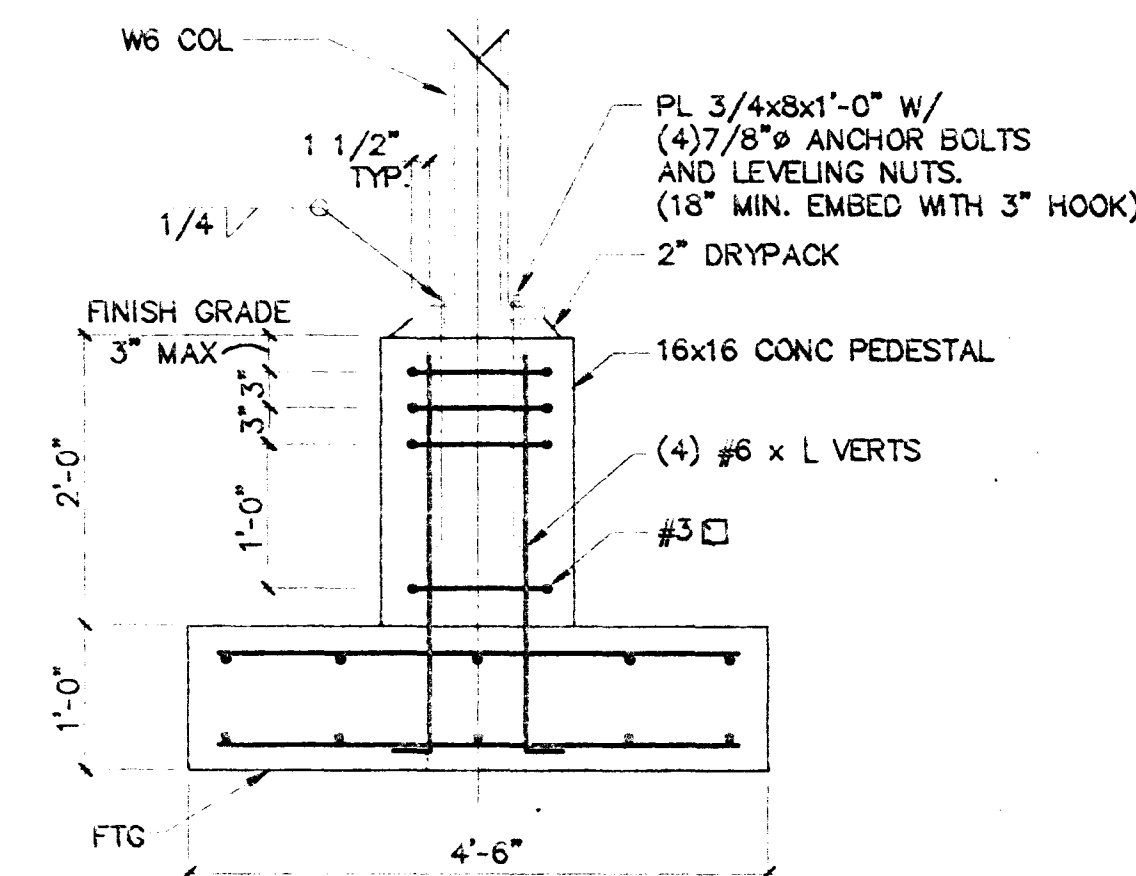

5 W COL TO FOOTING

3/4" = 1'-0"

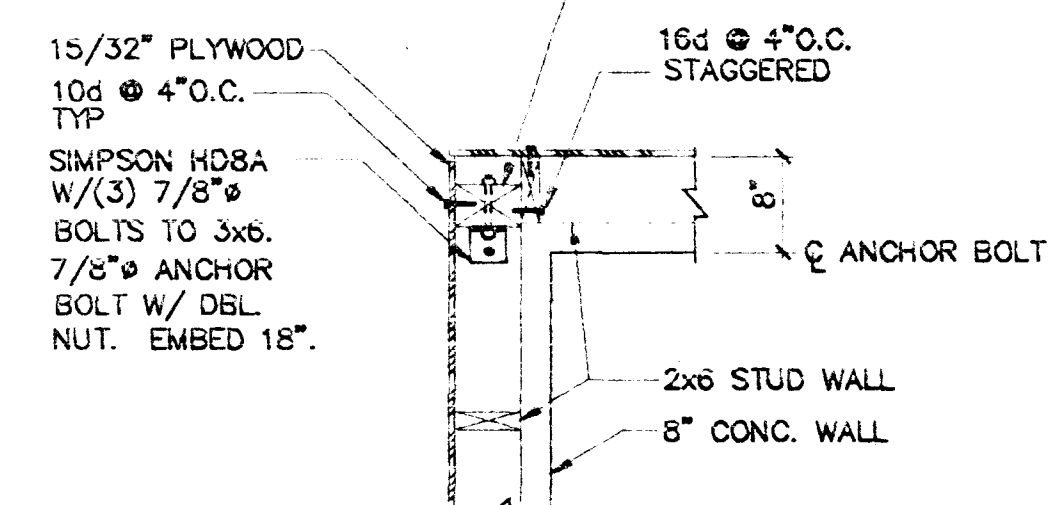


6 SHEAR WALL HOLDOWN

3/4" = 1'-0"

***** STRUCTURAL NOTES *****

1. PLACE FOOTINGS AT DEPTHS INDICATED ON DRAWINGS ON SOLID UNDISTURBED SOIL. MAXIMUM TOTAL LOAD BEARING PRESSURE DOES NOT EXCEED 3000 PSF WITH UBC INCREASES. NO FOOTING SHALL BE PLACED HIGHER THAN ON A 2 HORIZONTAL TO A 1 VERTICAL SLOPE FROM ANY ADJACENT EXCAVATION. FOLLOW RECOMMENDATIONS IN SOILS REPORT BY HOWARD CONSULTANTS, INC, DATED JUNE 8, 1993.
2. BUILDING IS DESIGNED FOR ZONE 2B SEISMIC AND 70 MPH BASIC WIND SPEED, EXPOSURE C PER THE 1991 UNIFORM BUILDING CODE:
ROOF LIVE LOAD = 25 PSF
3. CONCRETE DESIGN IS BASED ON 3500 PSI MINIMUM COMPRESSIVE STRENGTH @ 28 DAYS. LAP ALL REBARS A MINIMUM OF 40 DIAMETERS INCLUDING WALL INTERSECTIONS AND CORNERS. ADD 1-#7 ALL AROUND OPENINGS AND EXTEND 2'-0" PAST EDGES OF OPENINGS.
4. REINFORCING STEEL SHALL BE ASTM A 615, GRADE 60. REINFORCE SLABS AND WALLS WITH REINFORCING SHOWN FOR SIMILAR CONDITIONS IF NOT NOTED OTHERWISE. MINIMUM THICKNESS OF CONCRETE COVER TO BE AS FOLLOWS:
CONCRETE AGAINST EARTH WITH OUT FORMS 3".
FORMED CONCRETE EXPOSED TO WEATHER OR EARTH 2" FOR #6 & LARGER 1 1/2" FOR #5 & SMALLER.
SLABS AND WALLS 3/4".
5. STRUCTURAL STEEL DESIGN IS BASED ON $F_y = 36$ KSI FOR BEAMS AND $F_y = 46$ KSI FOR COLUMNS. ALL BOLTS SHALL BE A307. ADD 1/2" DIA STUD ANCHORS AT 18" EA. SIDE OF COLUMN ADJACENT TO STUDS.
6. GLU-LAM MEMBERS TO BE COMBINATION 24-V3. DESIGN STRESS = 2400 PSI. ALL WOOD FRAMING TO BE NUMBER 2 OR BETTER; 1450F REPETITIVE USE, 1250F SINGLE USE. PLYWOOD ROOF SHEATHING TO BE INDEX NO 32/16. NAIL SHEATHING WITH 10D NAILS 6" O.C. AT ALL PLYWOOD EDGES AND 10" O.C. AT ALL INTERMEDIATE SUPPORTS, EXCEPT AS NOTED. TRUSS JOISTS ARE SIZED ON THE BASIS OF TABLES PREPARED BY THE TRUSS JOIST CORPORATION. WALL SHEATHING TO BE BLOCKED ALL EDGES. NAIL W/ 10d @ 4" O.C. ALL PANEL EDGES & 12" O.C. IN FIELD.

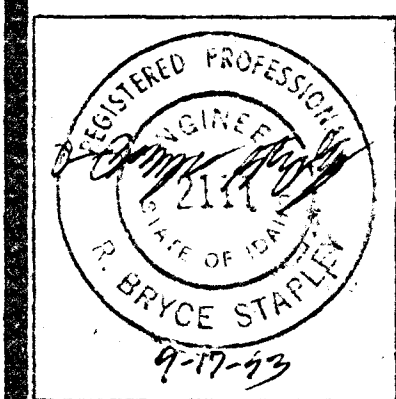

Conrad-Comrad
ARCHITECTS
P. A., A. I. A.
1221 S. BURELL LANE BOISE, IDAHO 83702 TEL (208) 345-6677



BANK OF AMERICA
FAIRVIEW AND MITCHELL
BOISE IDAHO
FOUNDATION PLAN & DETAILS

JOB NO.	93031.01
DATE	9/13/93
DRAWN BY	JIM
CHECKED BY	SMC
REVISIONS	
	DATE


SHEET NO.

S2.1


OF SHEETS

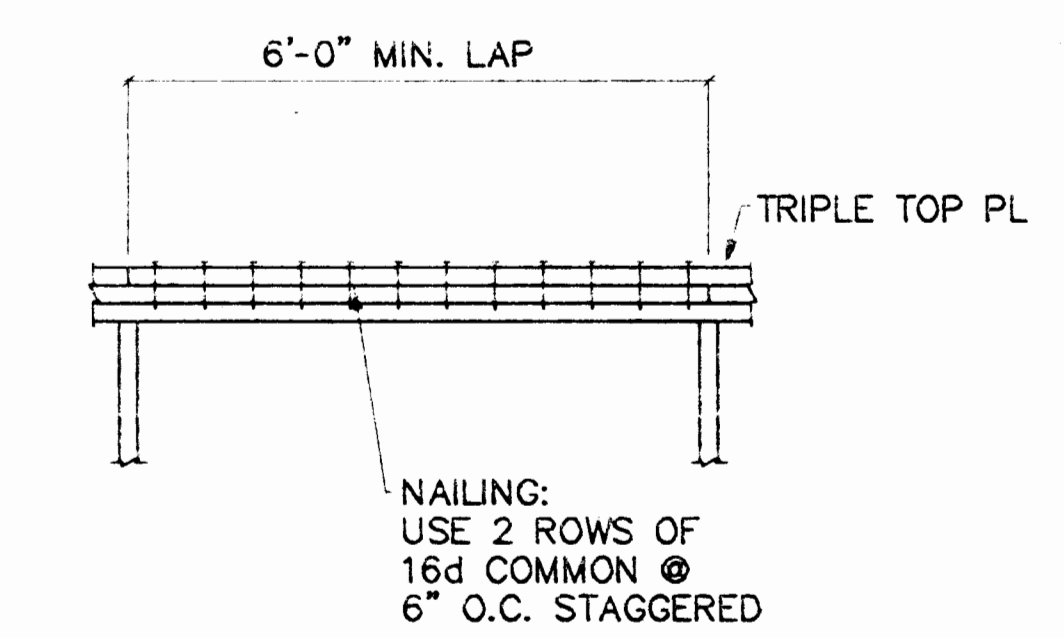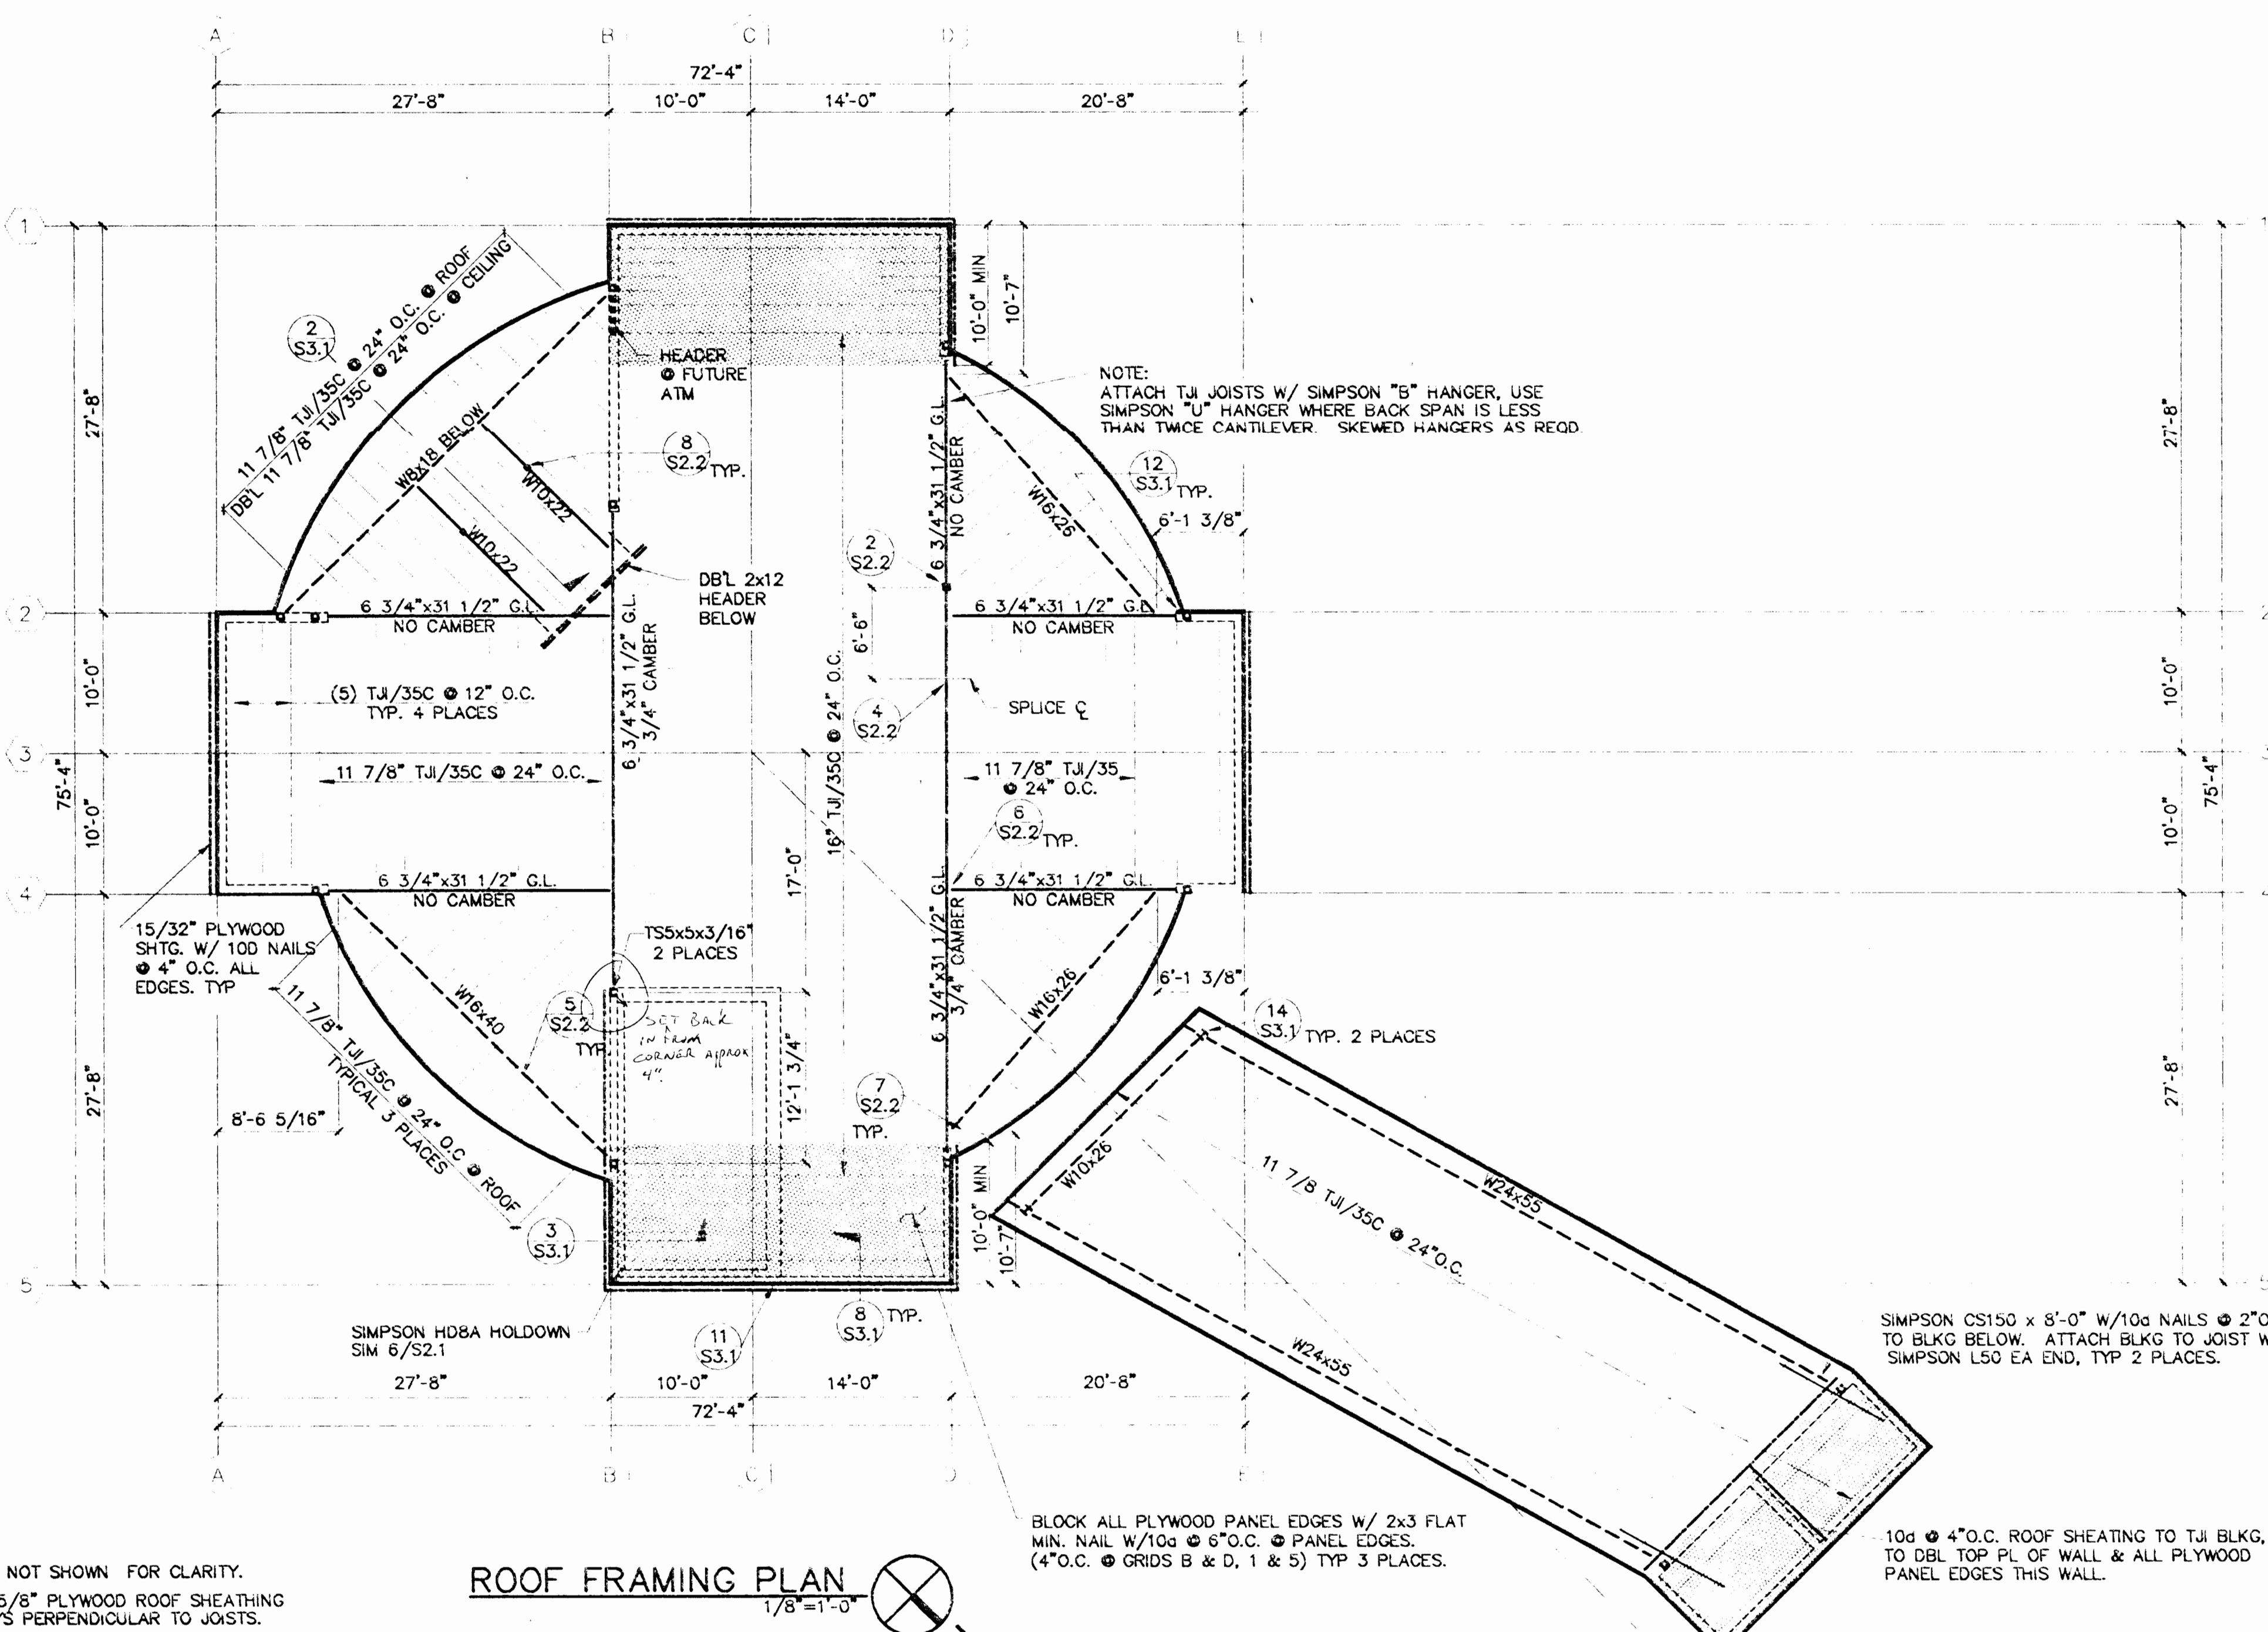


1 TOP PLATE SPLICE CONN.
GRID B & D
1/2" = 1'-0"

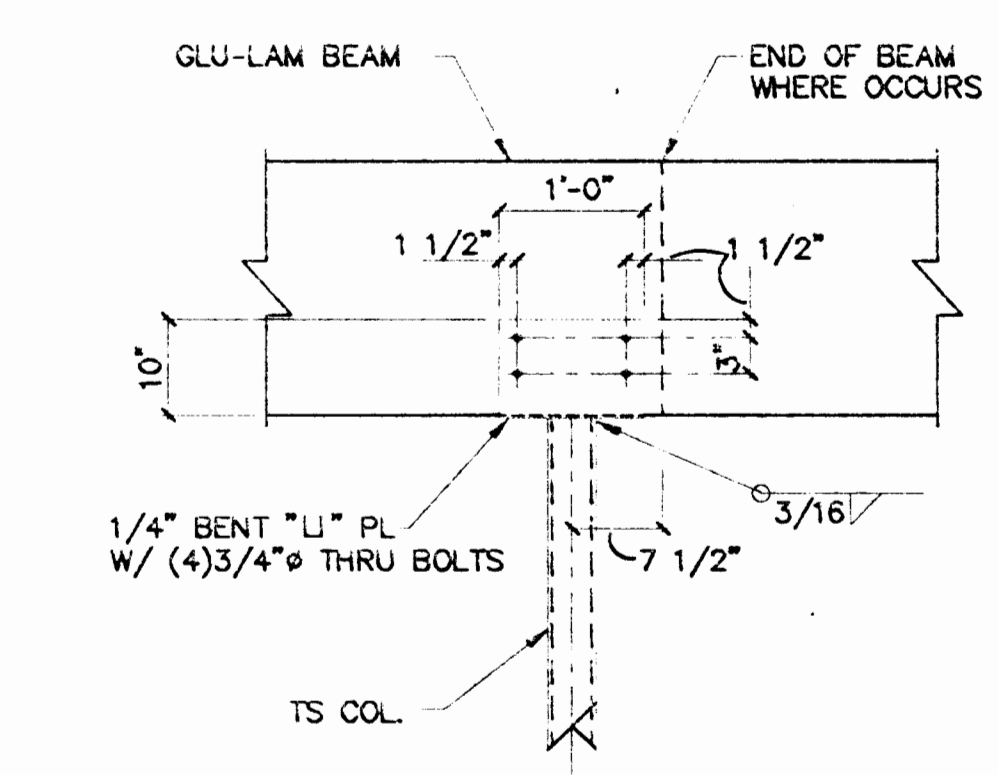


2 WOOD BEAM SADDLE CONNECTION
3/4" = 1'-0"

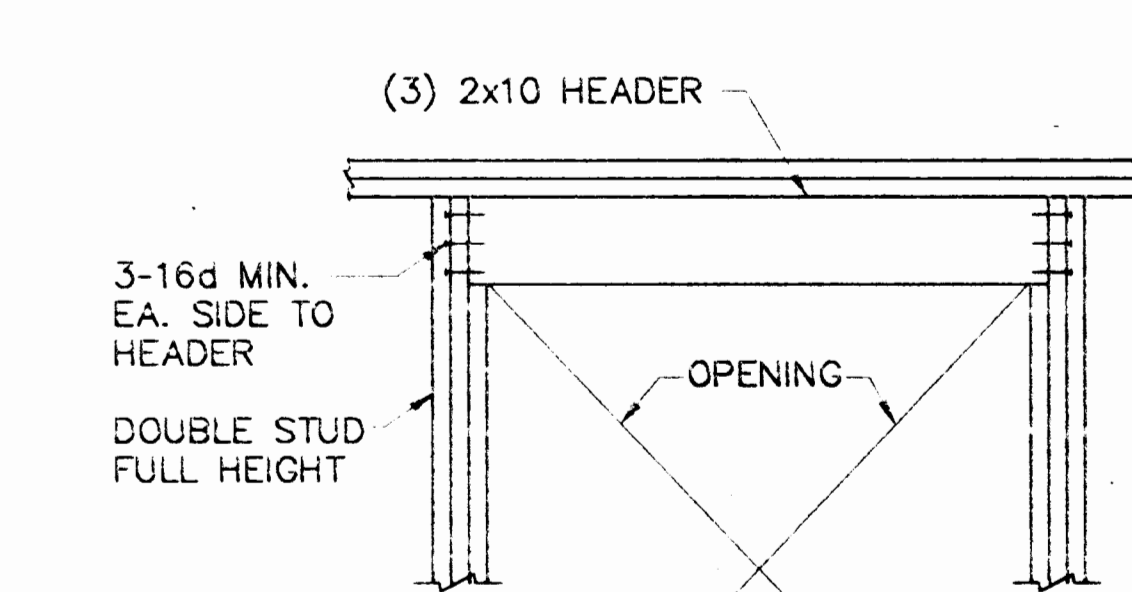


3 WOOD HEADER DETAIL

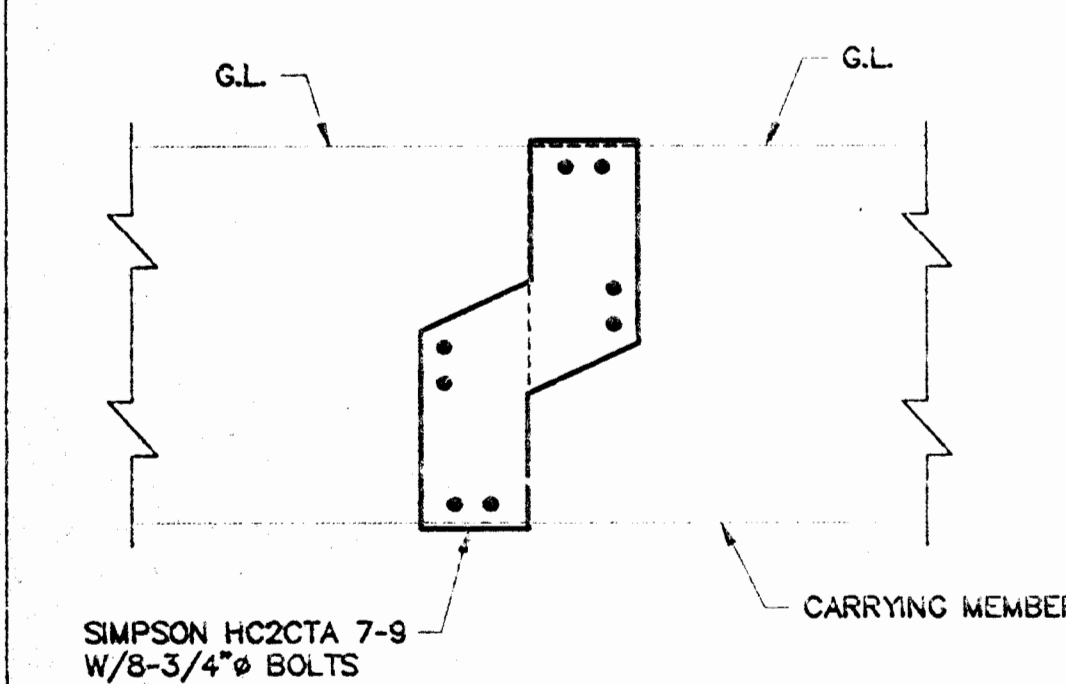


4 BEAM HANGER CONN. DETAIL
3/4" = 1'-0"

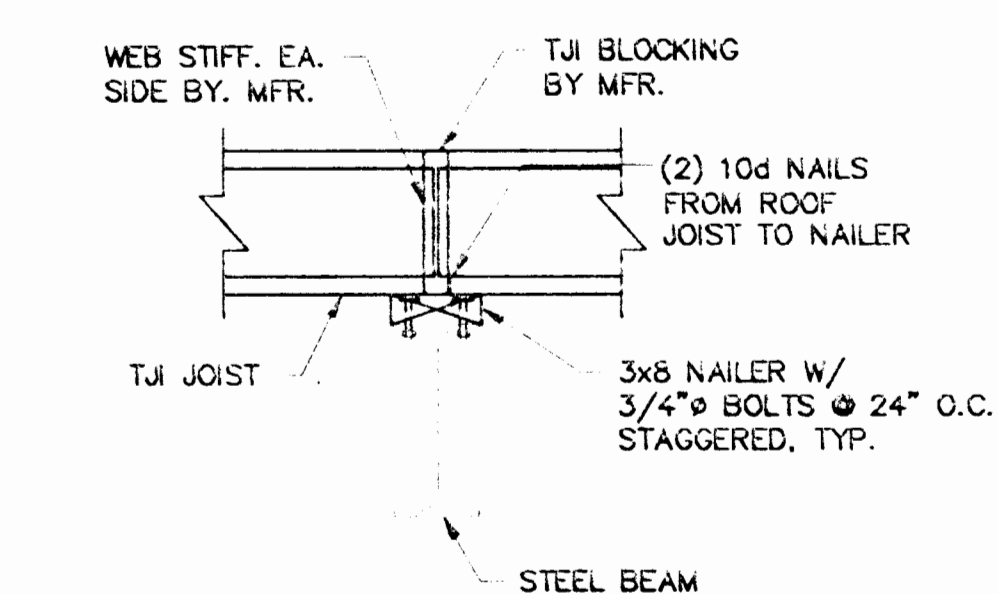


5 JOIST TO BEAM CONN. DETAIL
3/4" = 1'-0"

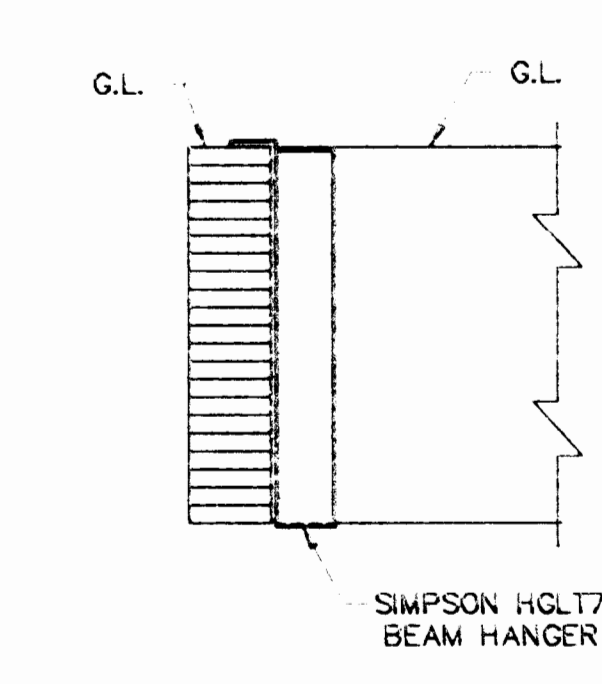


6 G.L. BM. TO BM. CONN. DETAIL
3/4" = 1'-0"

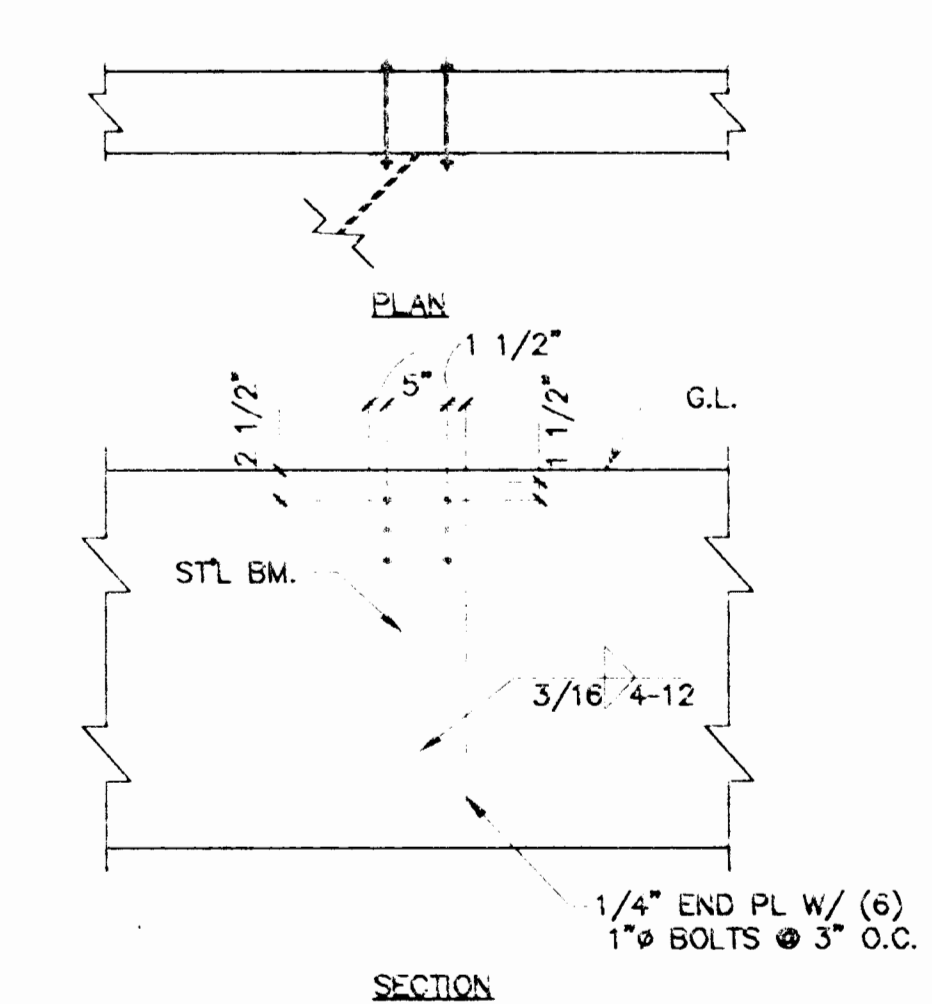

7 STL BM. TO G.L. CONNECTION
3/4" = 1'-0"

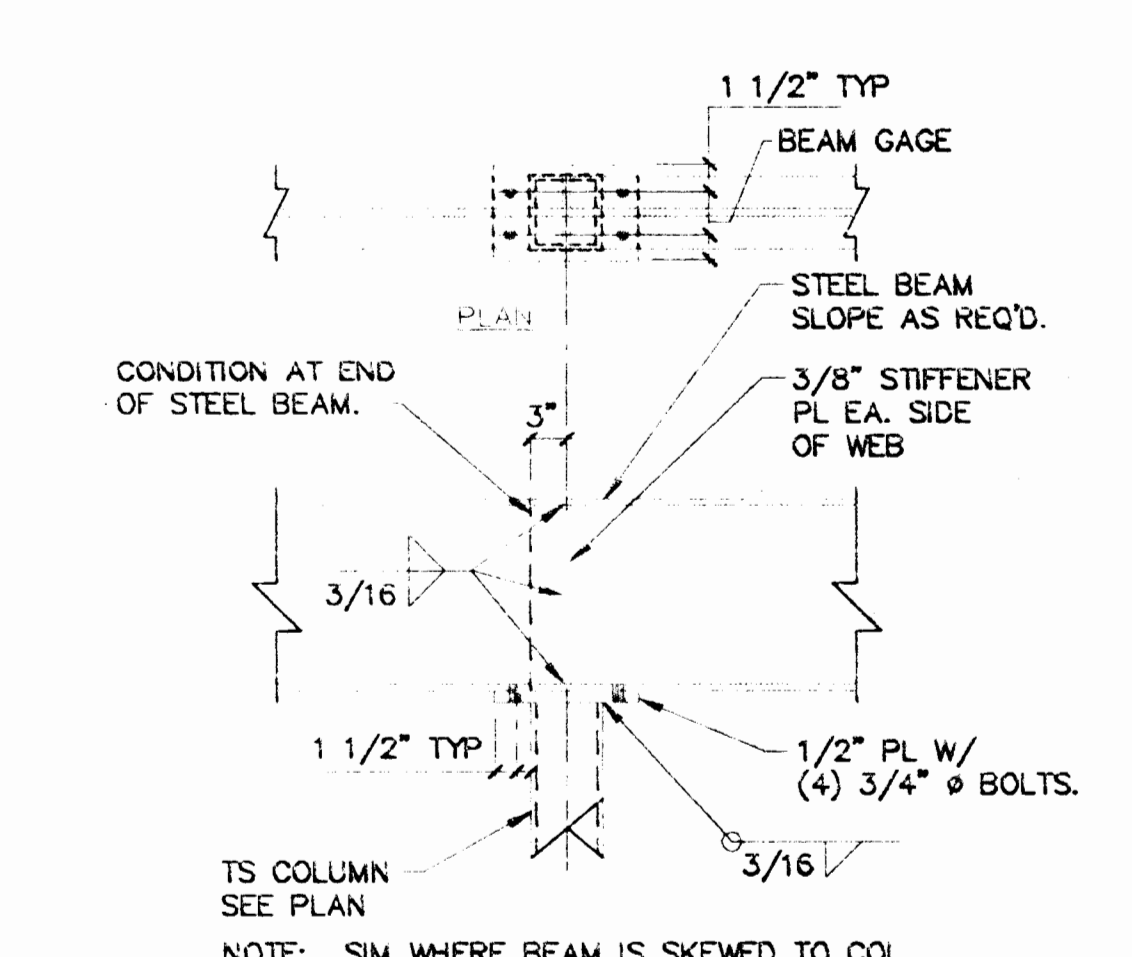

8 COLUMN CAP PLATE DETAIL
3/4" = 1'-0"

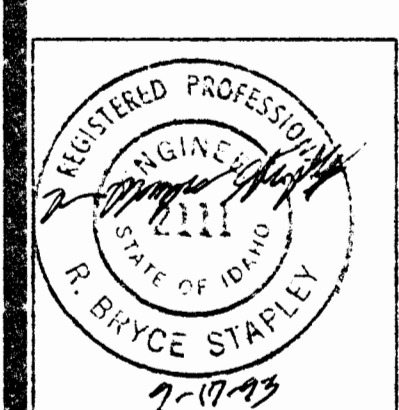


Comard-Conrad
ARCHITECTS
1221 SHORELINE LANE BOISE, IDAHO 83702
P. A., A. I. A.
TEL (208) 345-6677


BANK OF AMERICA
FAIRVIEW AND MITCHELL
BOISE IDAHO
ROOF FRAMING PLAN & DETAILS

JOB NO. 93031.01
DATE 9/13/93
DRAWN BY JIM
CHECKED BY SMC
REVISIONS
DATE


SHEET NO.
S2.2
OF SHEETS

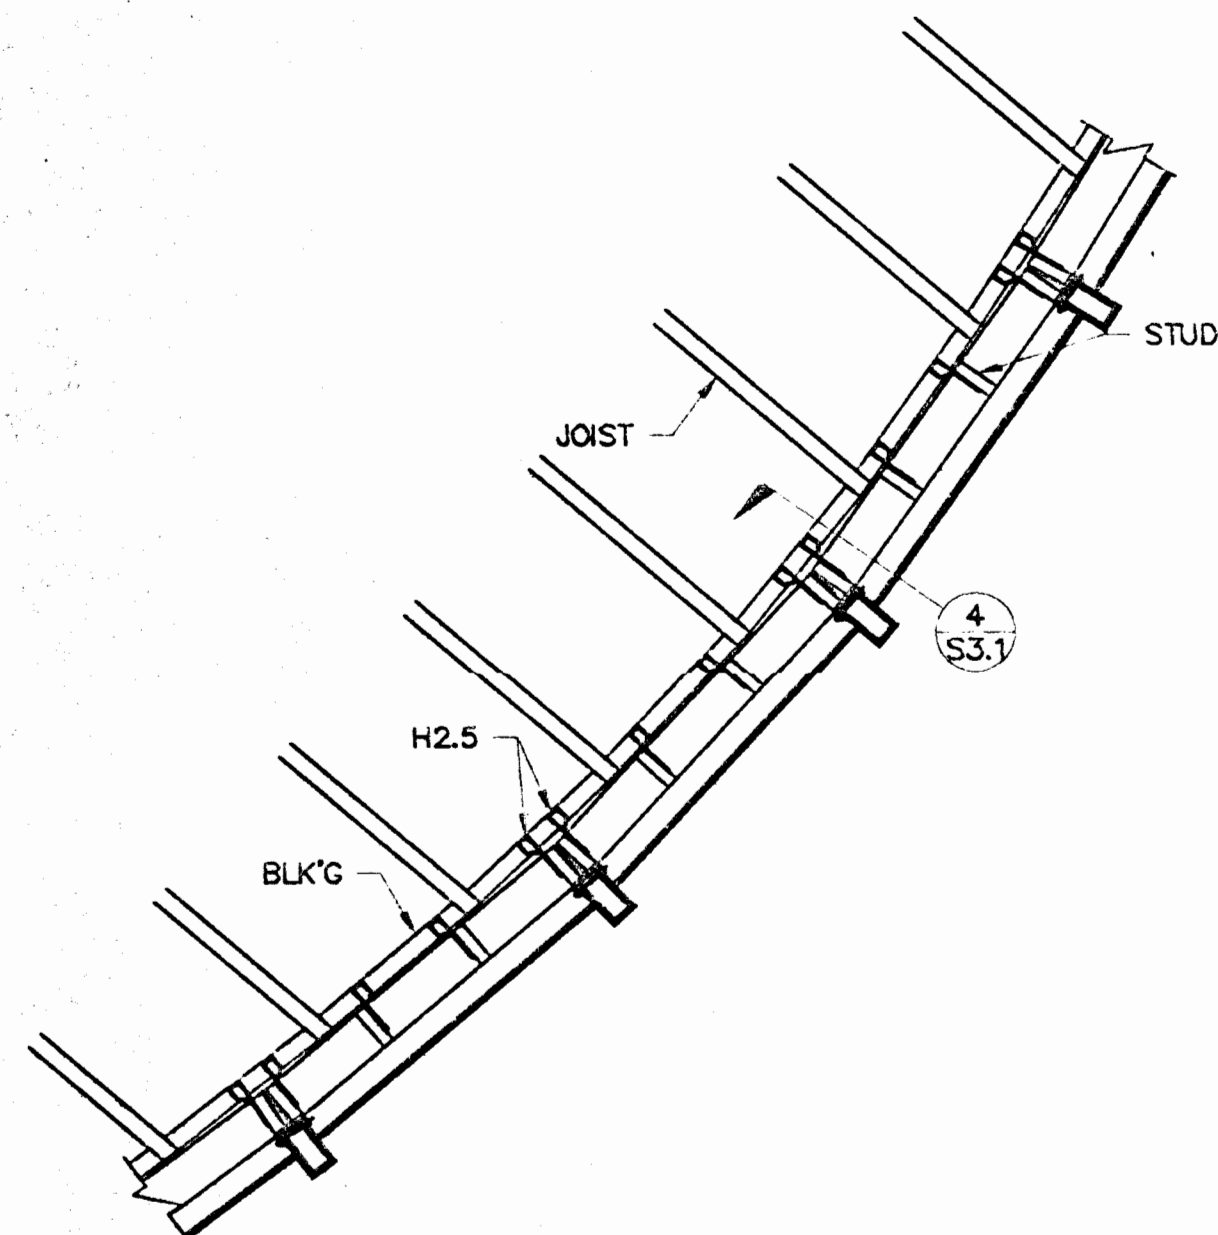


1 PARTIAL ROOF FRAMING PLAN
1/2"=1'-0"

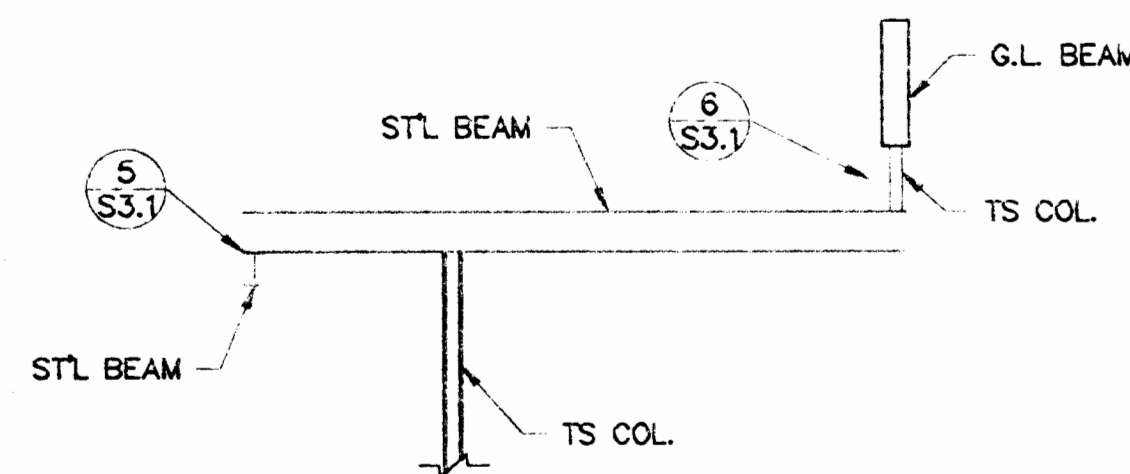


2 STL FRAMING ELEV. @ ENTRY
1/4"=1'-0"

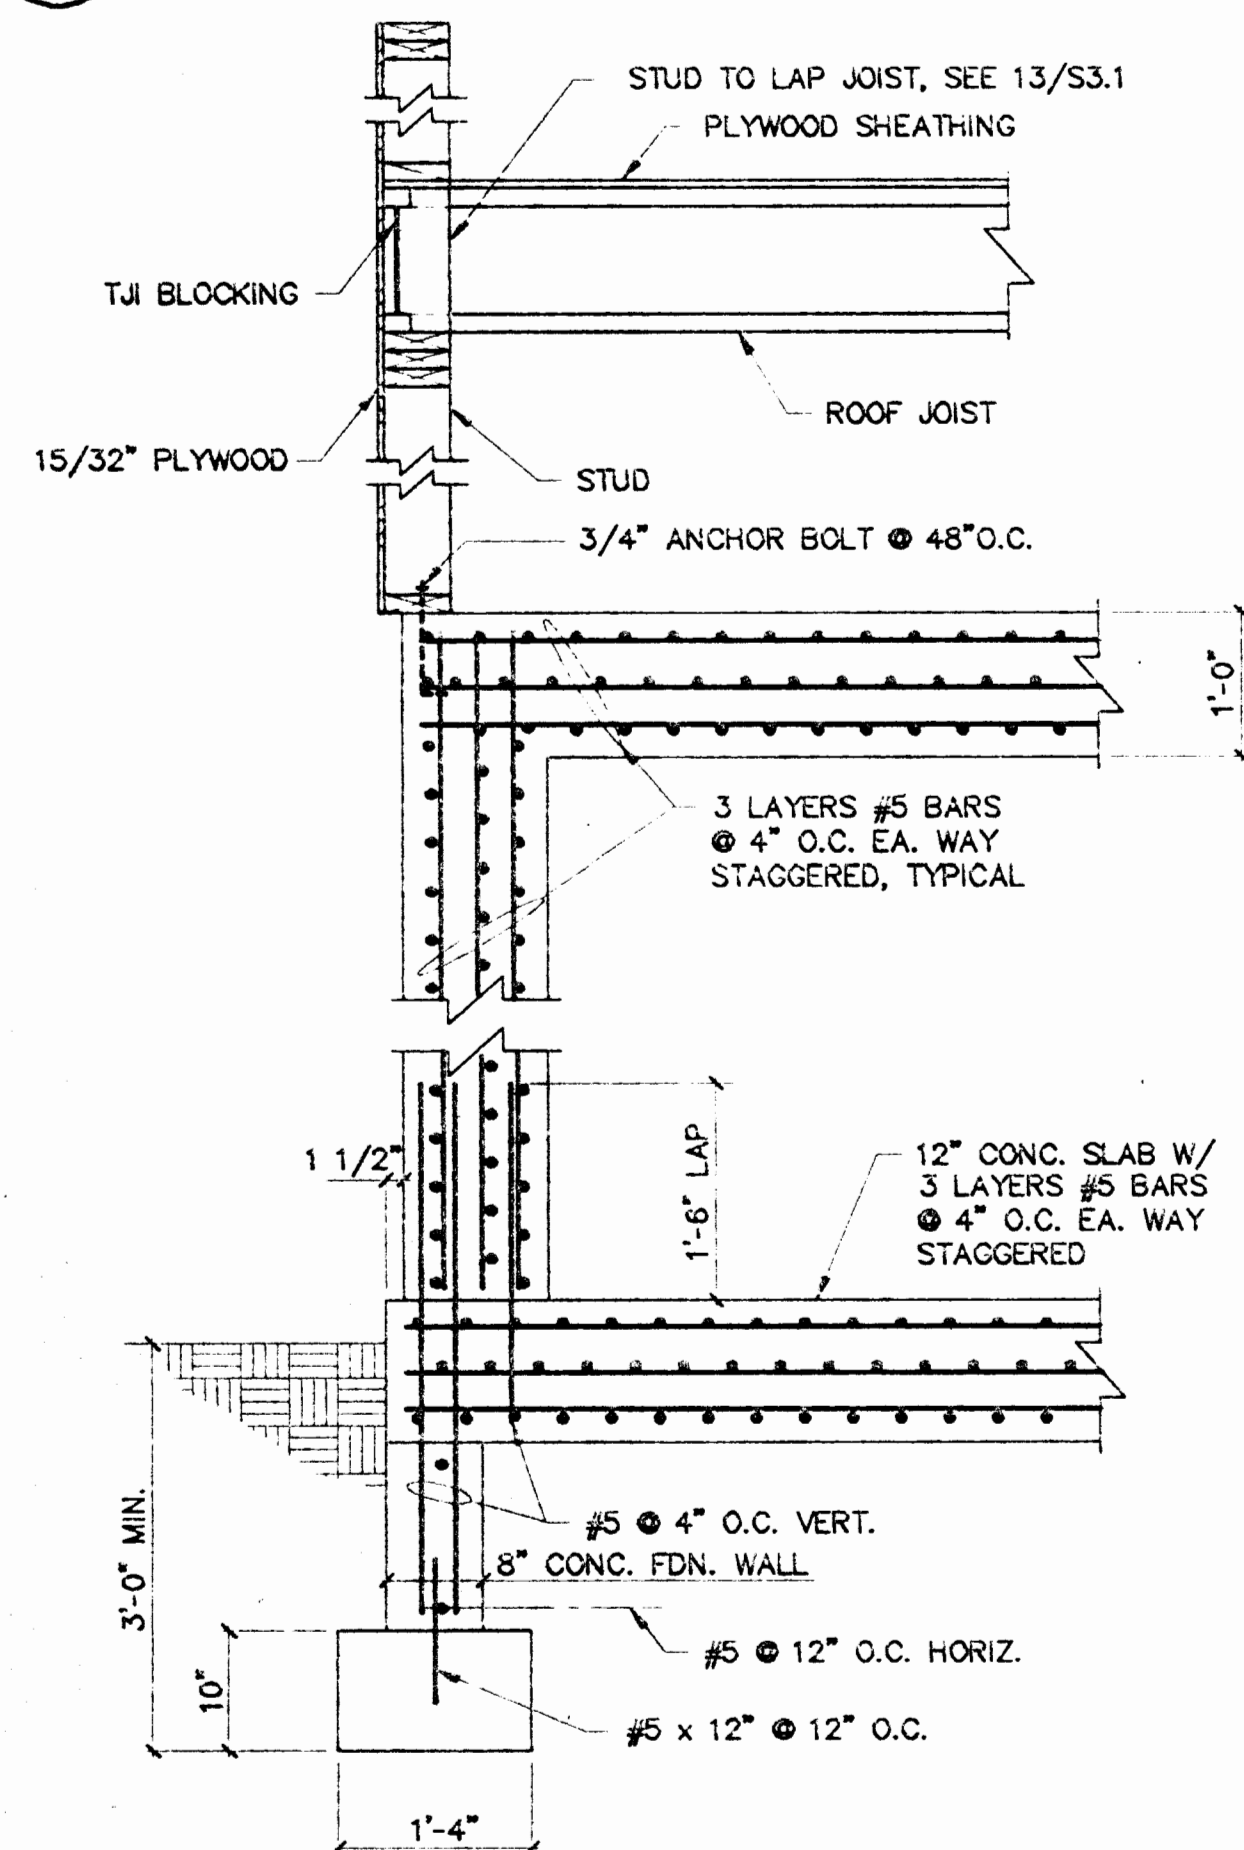


3 FULL HEIGHT WALL SECTION @ VAULT
3/4"=1'-0"

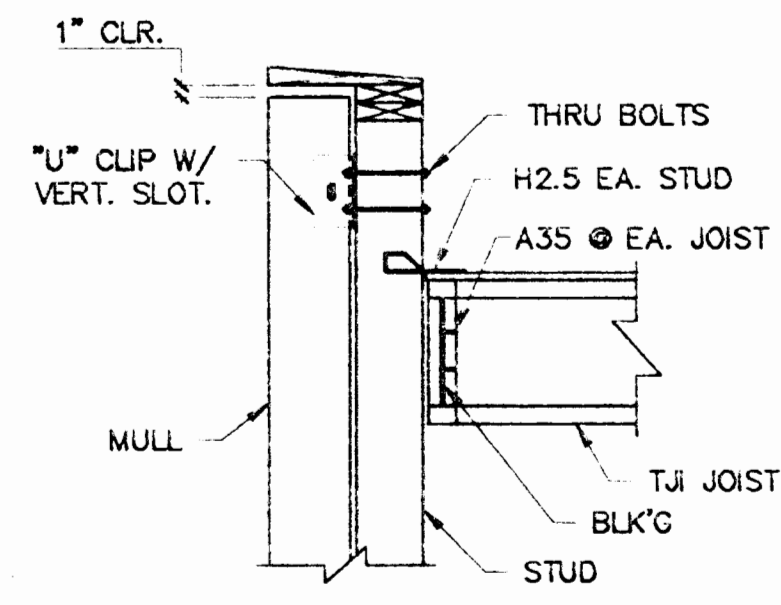


4 MULLION SUPPORT
3/4"=1'-0"

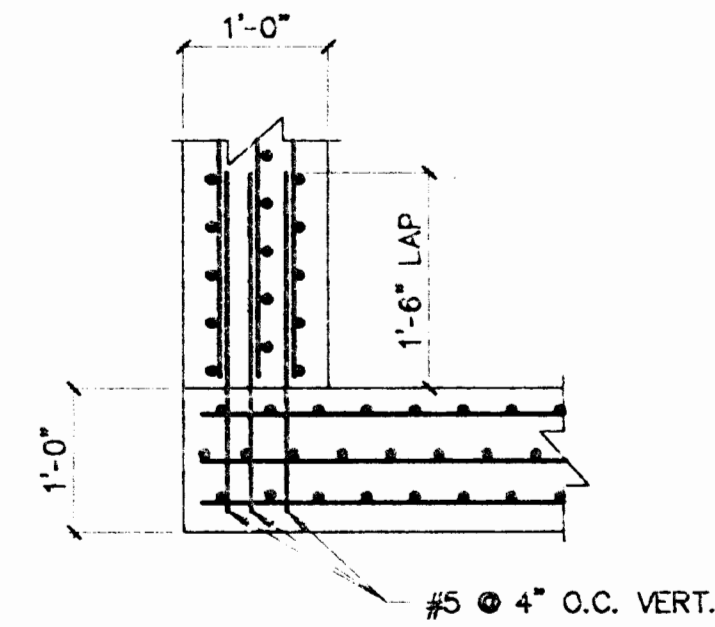


7 VAULT DETAIL
3/4"=1'-0"

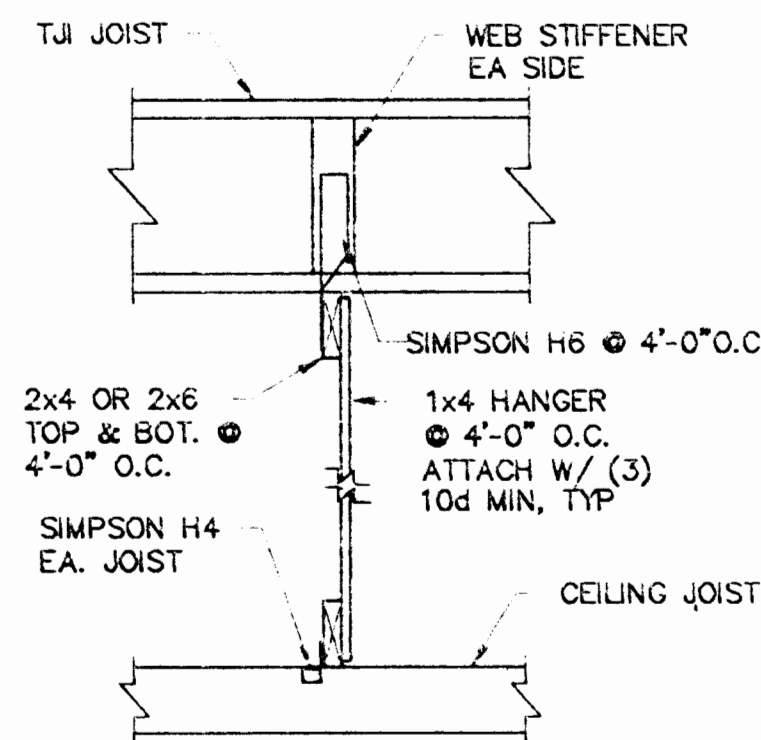


10 SUSPENDED CEILING SYSTEM
3/4"=1'-0"

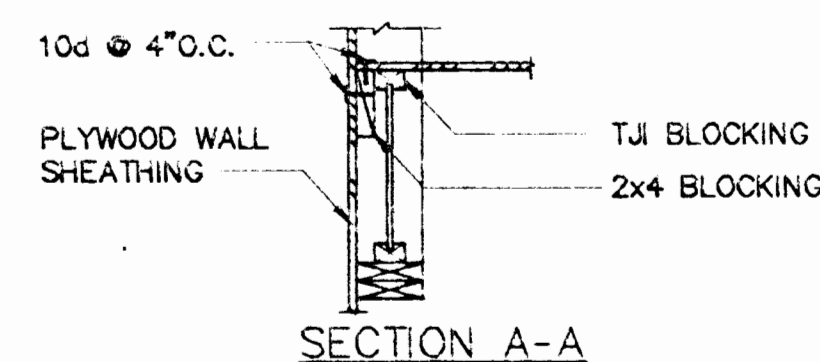


13 PARAPET PERP TO ROOF JOIST
3/4"=1'-0"

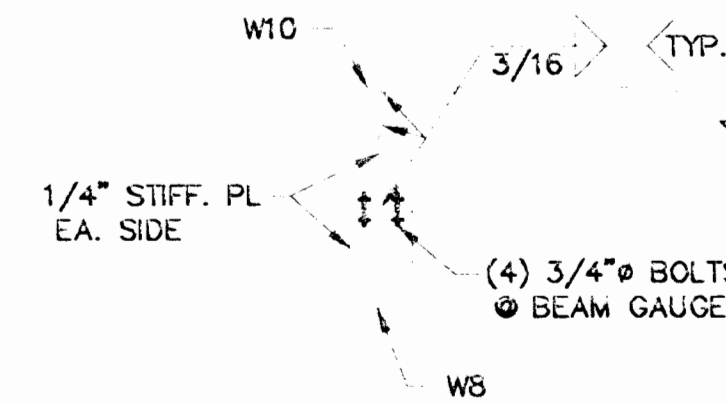


5 W8 TO W10 BEAM
3/4"=1'-0"

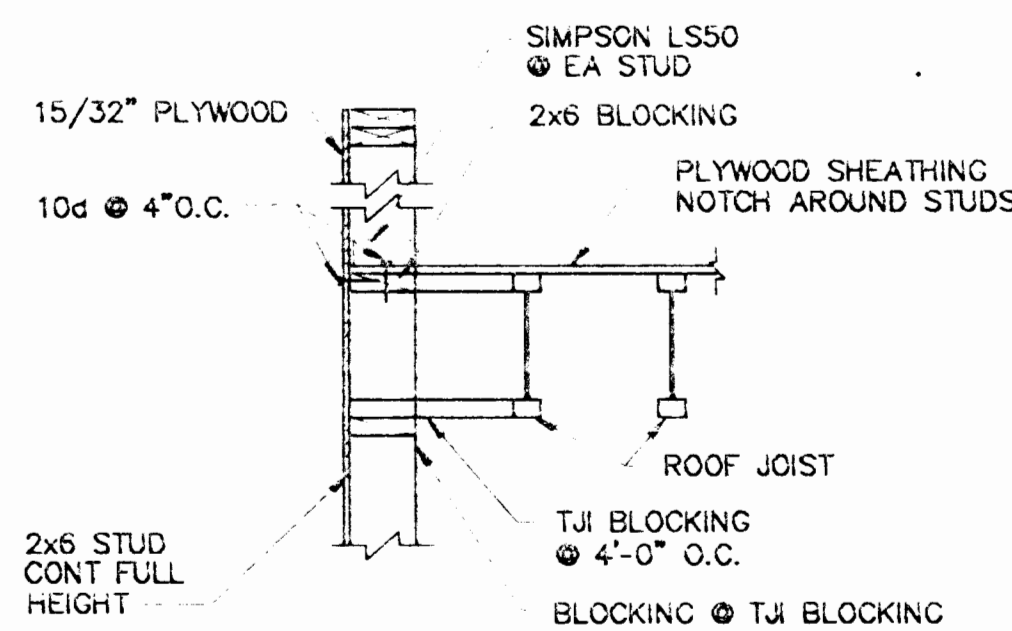


8 PARAPET PARALLEL TO JOIST
3/4"=1'-0"

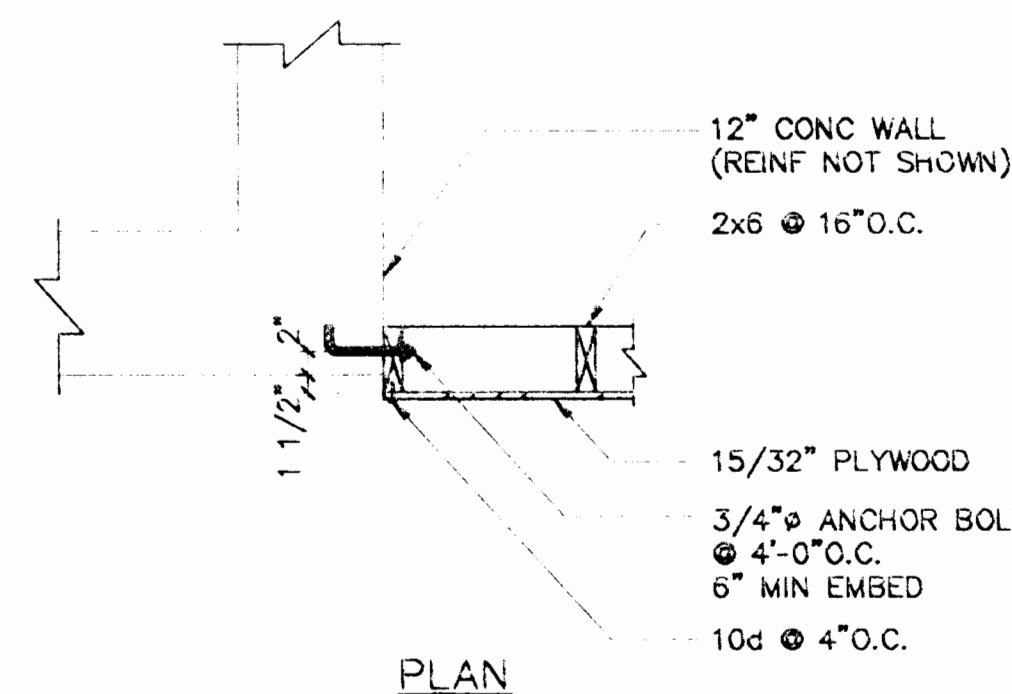


11 SHEAR WALL TO CONC WALL
3/4"=1'-0"

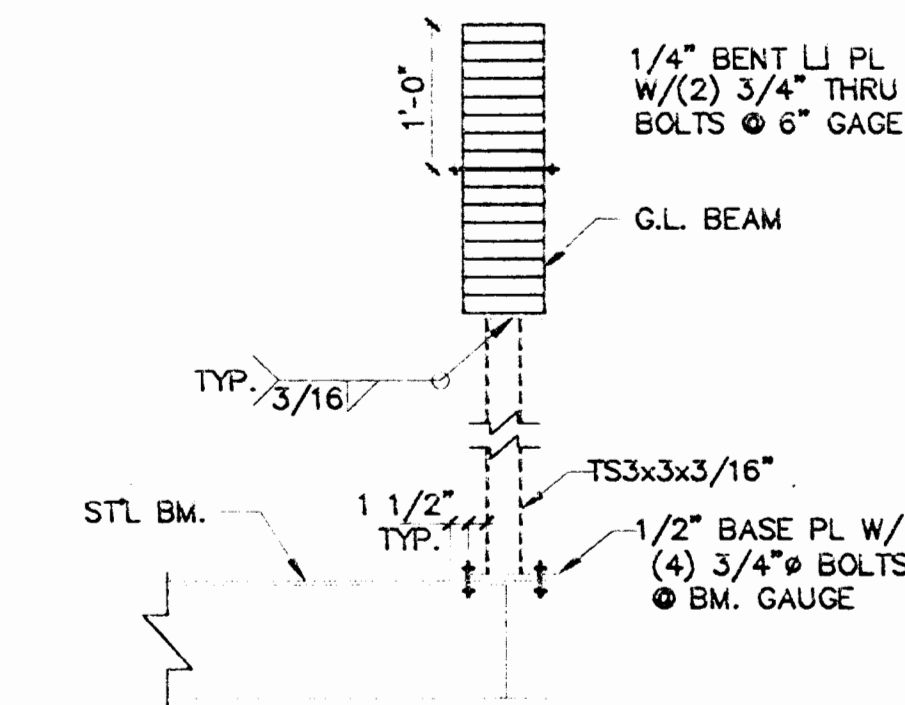


6 STL BEAM BELOW GL BEAM
3/4"=1'-0"

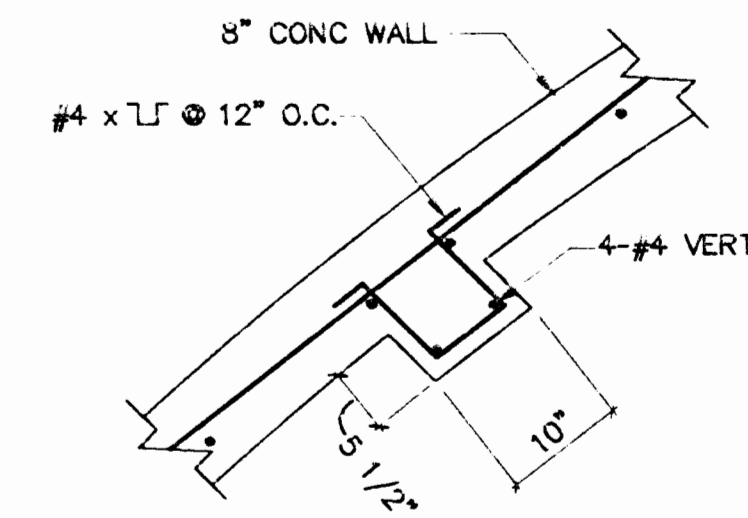


9 CONC. PILASTER @ ENTRY
3/4"=1'-0"

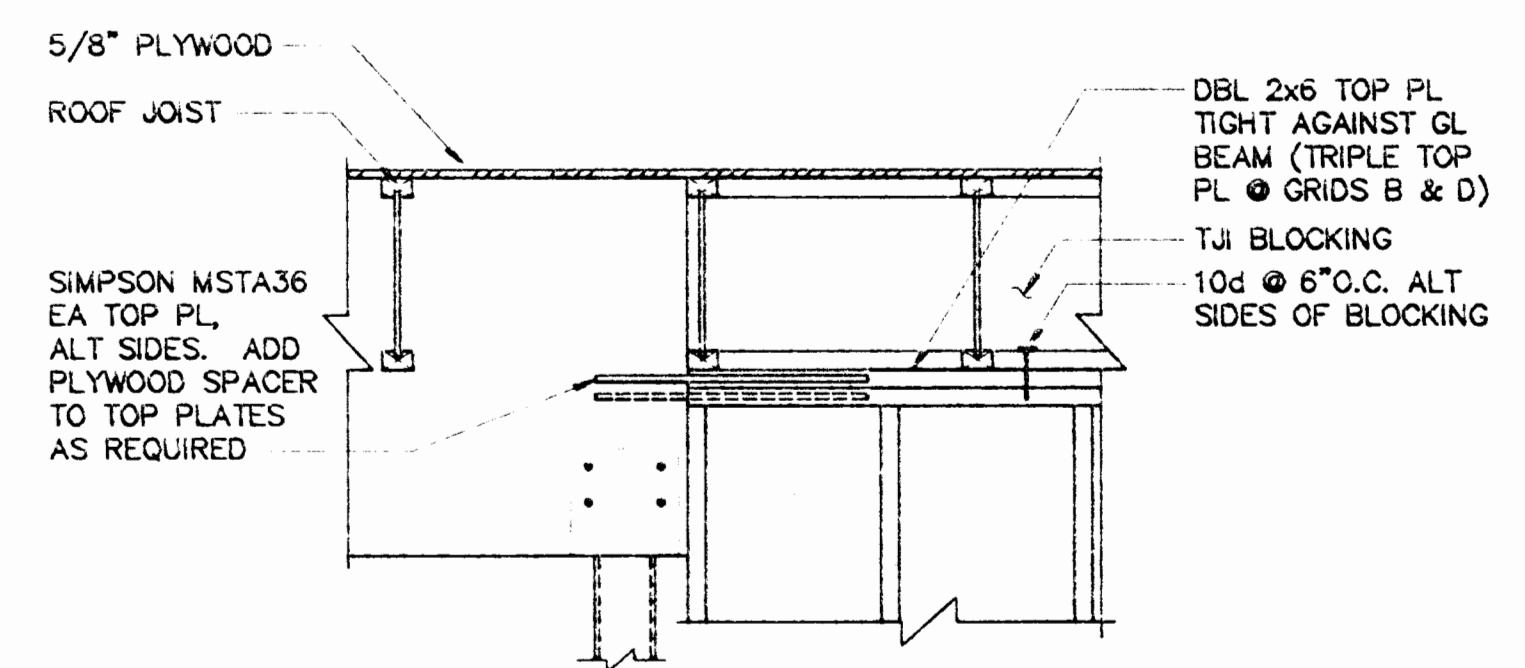

12 GL TO STUD WALL
3/4"=1'-0"

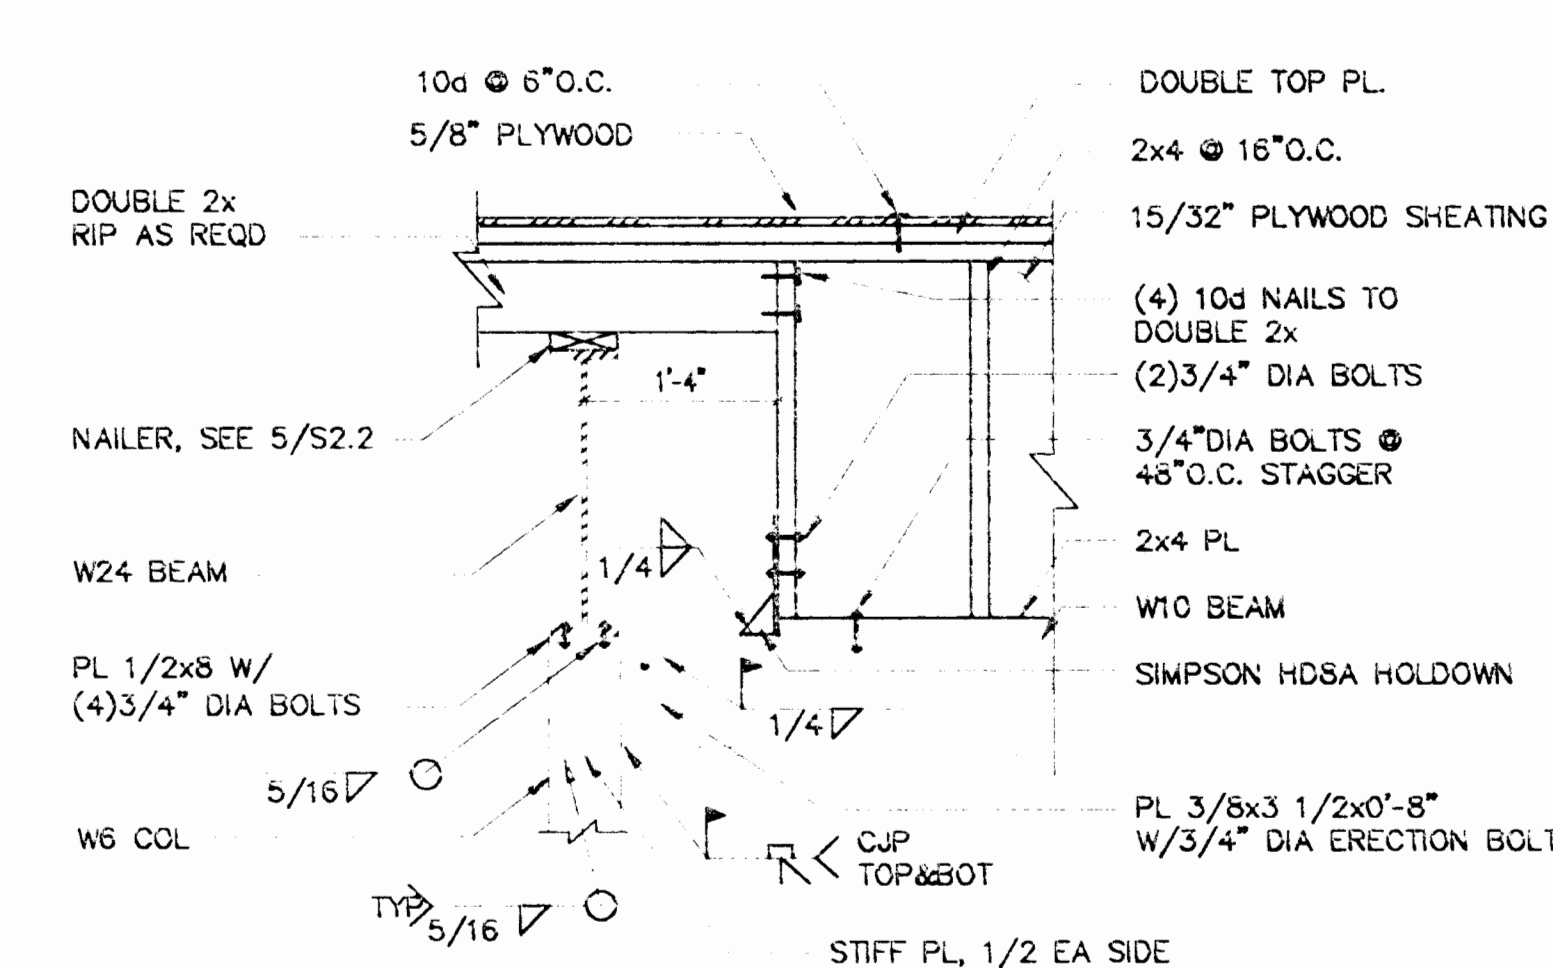

14 CANOPY FRAME AT ROOF
3/4"=1'-0"

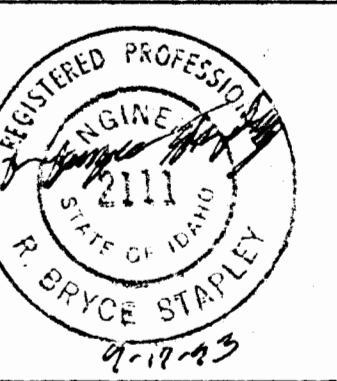

Conrad-Comad
ARCHITECTS
P. A., A. I. A.
1221 SHORELINE LANE BOISE, IDAHO 83702
TEL (208) 345-6677

BANK OF AMERICA
FAIRVIEW AND MITCHELL
BOISE IDAHO
DETAILS & SECTIONS

JOB NO. 93031.01	DATE 9/13/93
DRAWN BY JIM	CHECKED BY SUC
REVISIONS	DATE

SHEET NO.
S3.1
OF SHEETS